


ELECTRICAL ABBREVIATIONS	
AFF	ABOVE FINISHED FLOOR
GFI	GROUND FAULT INTERRUPTING
3R	WEATHERPROOF ENCLOSURE
UNO	UNLESS NOTED OTHERWISE
RGS	RIGID GALVANIZED STEEL
WP	WEATHERPROOF
AHU	AIR HANDLING UNIT
HP	HEAT PUMP
ER	EXISTING TO REMAIN


NOTES:
1. FOR 20A - 18" - 120 VOLT SERVICE WIRE
SIZE SHALL BE AS FOLLOWS:
DIST TO 1st CONNECTION WIRE SIZE
60' TO LESS #12
60' TO 100' #10
OVER 100' #8

ELECTRICAL LEGEND	
SYMBOL	DESCRIPTION
S	SWITCH, SINGLE POLE, 120/277VAC, MOUNTED AT 48" AFF TO TOP OF OUTLET BOX
Sos	OCCUPANCY SENSOR WITH ON/OFF SWITCH, 120VAC, MOUNTED AT 48" AFF TO TOP OF OUTLET BOX
D	DIMMER, SINGLE POLE, 120/277VAC, MOUNTED AT 48" AFF TO TOP OF OUTLET BOX
Dos	OCCUPANCY SENSOR WITH DIMMING AND ON/OFF SWITCH, 120VAC, MOUNTED AT 48" AFF TO TOP OF BOX
⊙	OCCUPANCY SENSOR, CEILING MOUNT, LUTRON OR EQUAL
⊙	DUPLEX CONVENIENCE RECEPTACLE, 120VAC, MOUNTED AT 18" AFF TO CENTER OF OUTLET BOX, UNO
⊙	DUPLEX CONVENIENCE RECEPTACLE ON EMERGENCY POWER, 120VAC, MOUNTED AT 18" AFF TO CENTER OF OUTLET BOX, UNO
⊙	CONVENIENCE RECEPTACLE, 120V, FLOOR MOUNT, COVER FLUSH W/ BRUSHED STAINLESS STEEL COVERPLATE
▽	PHONE/DATA OUTLET, MOUNTED AT 18" AFF TO CENTER OF OUTLET BOX UNO
⊙	JUNCTION BOX
T	TV CONNECTION, VERIFY REQUIREMENTS, MOUNT AT +18" AFF UNO
⬢	LIGHT ON EMERGENCY POWER
⬢	ELECTRICAL PANEL, SURFACE
⬢	ELECTRICAL PANEL, FLUSH
⬢	DISCONNECT SWITCH, FUSIBLE
---	EXISTING WIRING TO REMAIN
---	NEW WIRING
⬢	EQUIPMENT LOCATED IN ATTIC
⬢	EXISTING EQUIPMENT & WIRING DEVICES
⬢	NEW EQUIPMENT & WIRING DEVICES

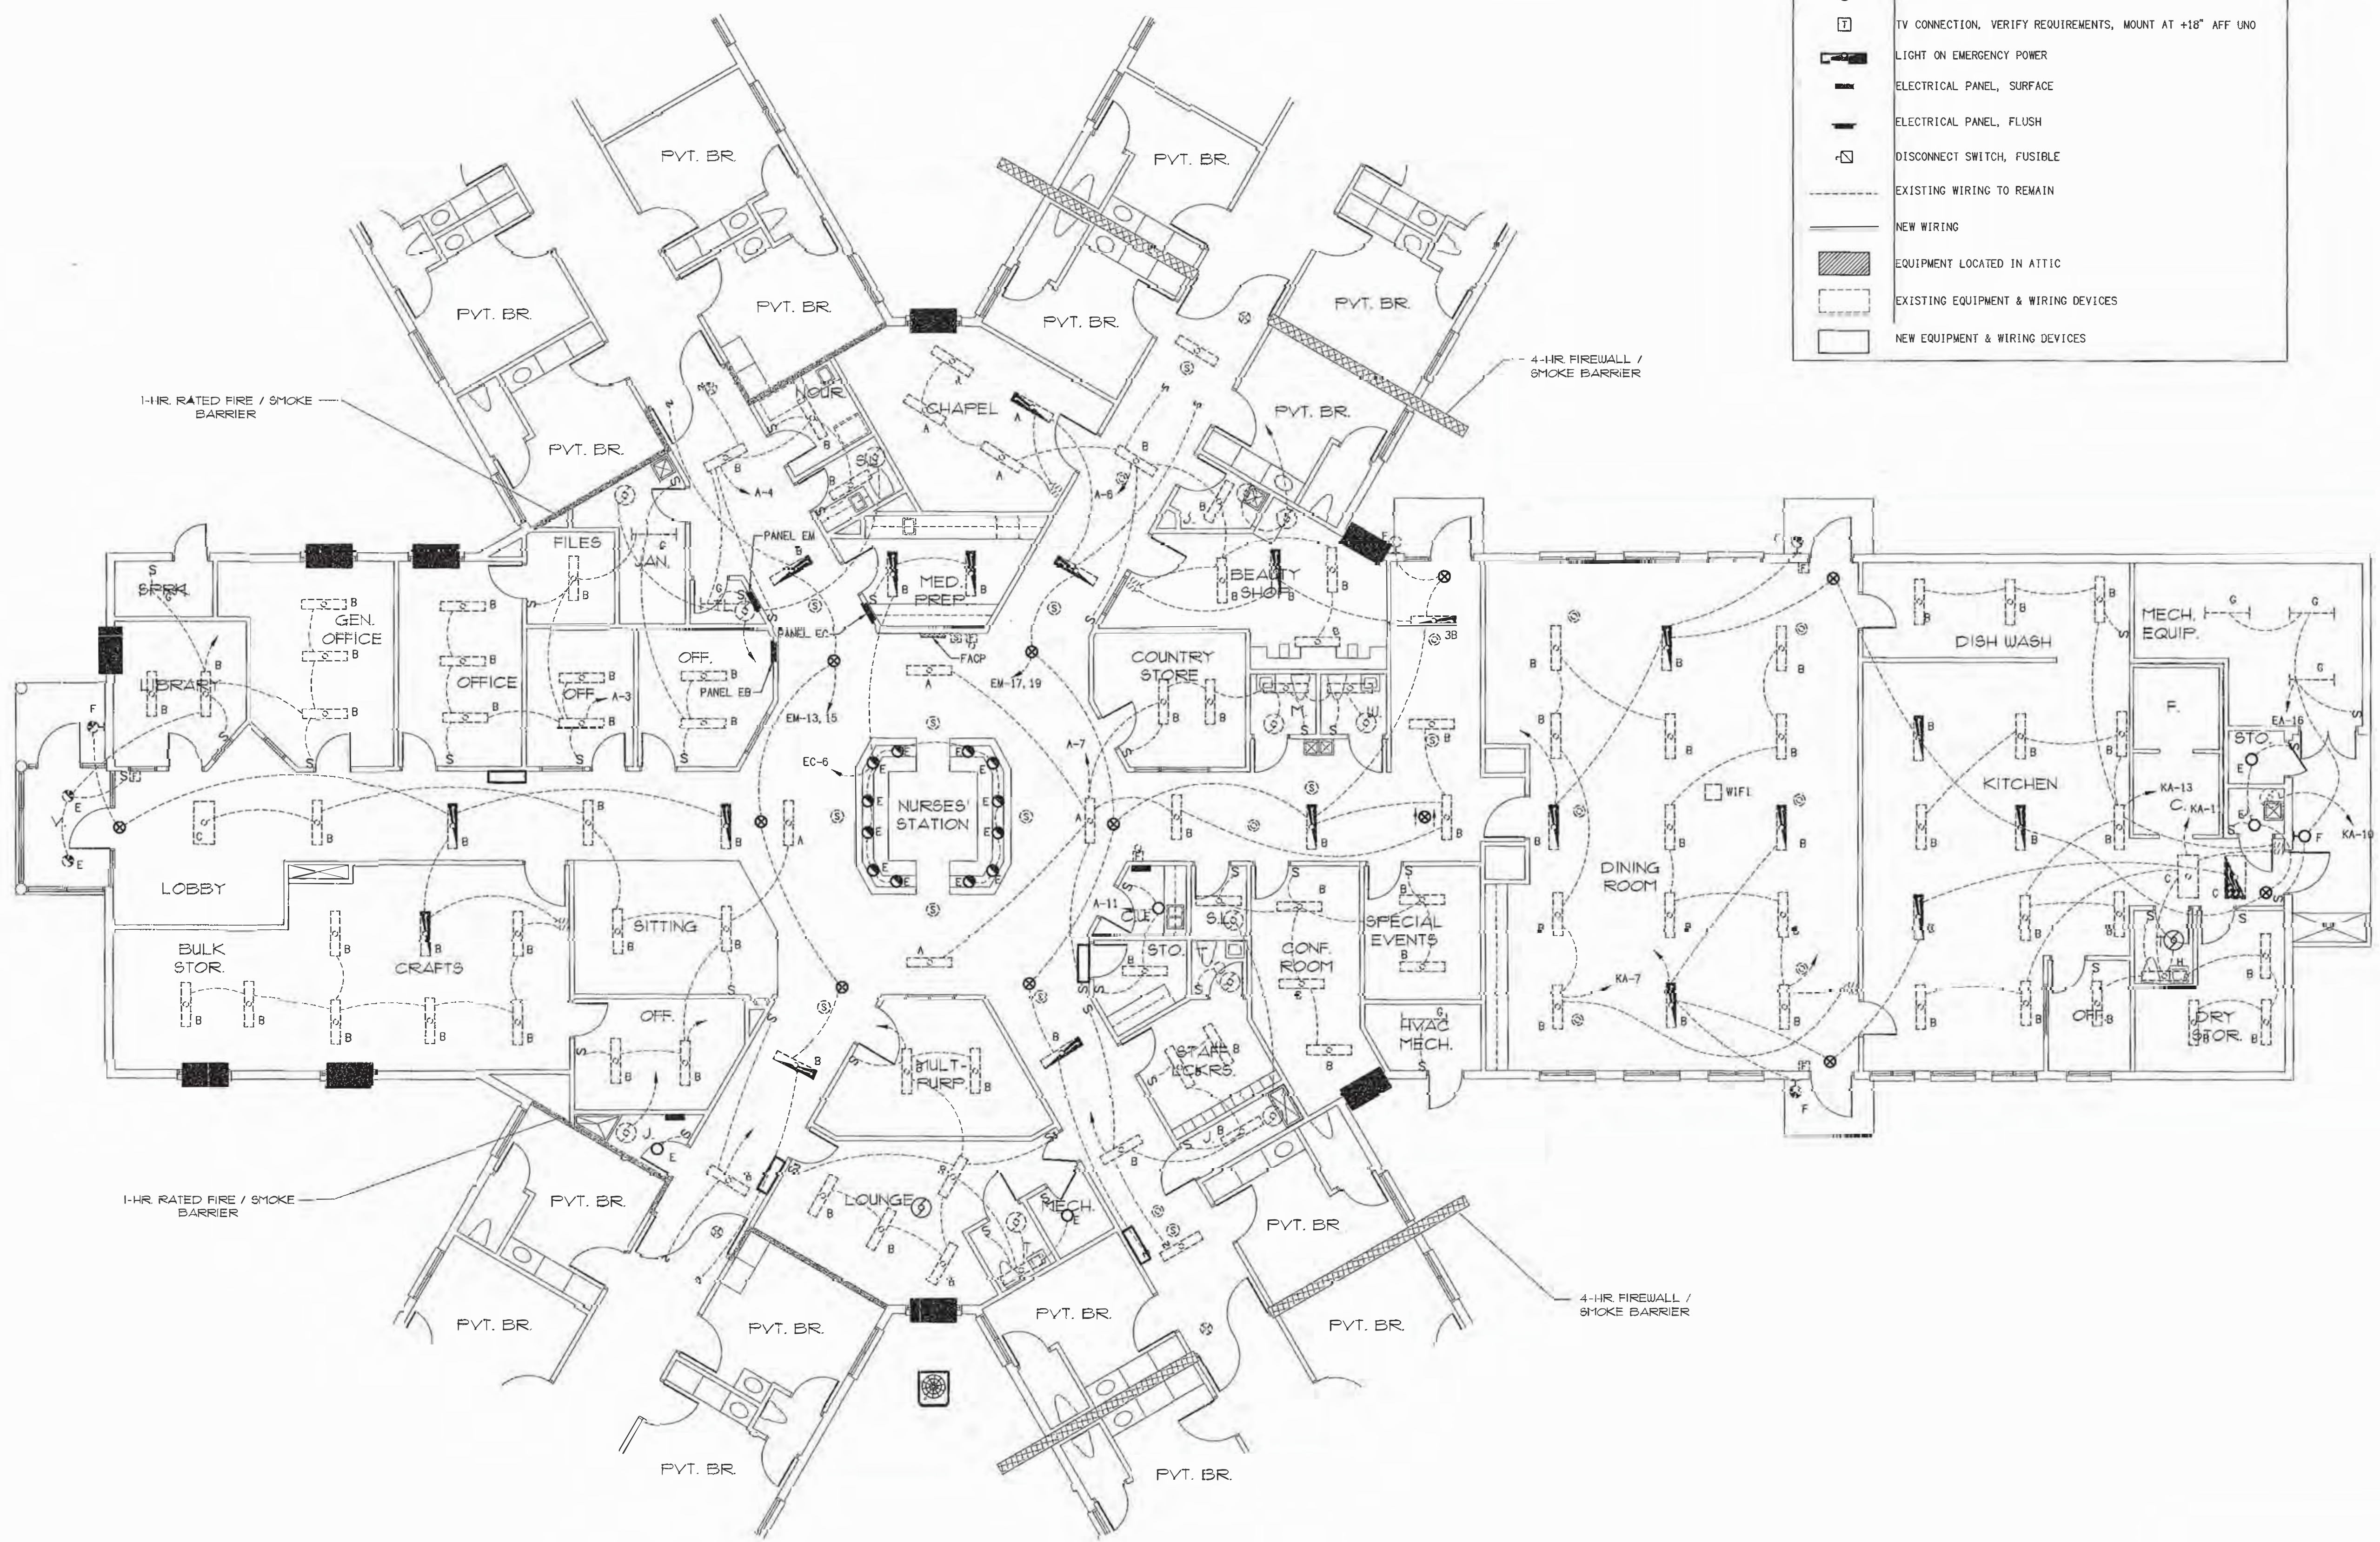


A Partial Lighting Plan - Existing Center Core
E1 SCALE: 1/8" = 1'-0"

symbol	date	description	by
REVISIONS			

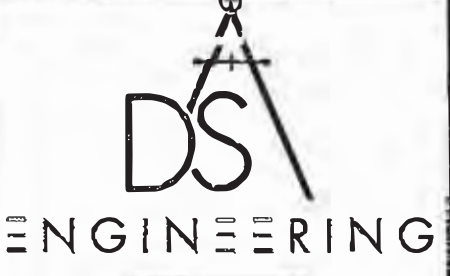

DSA ENGINEERING

101 N. 380 ST., SUITE 403
WILMINGTON, NC 28403
910.791.8016
NC License: C-1150
www.dsaeng.com

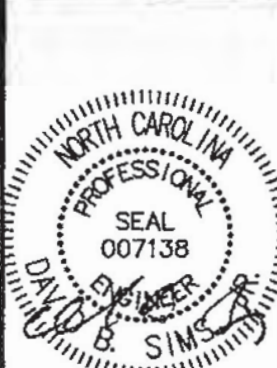

2/21/25

David R. Poiston - Architect
3806 Park Ave. Suite C, Wilmington, NC 28403
Architecture Planning Design

THE CARROLTON OF NASH
NURSING FACILITY
Rocky Mount, North Carolina

BUILDING RENOVATIONS



DSA #25906

DSA
ENGINEERING

DSA ENGINEERING
101 N. 3RD ST., SUITE 403
WILMINGTON, NC 2840
910.791.8016
NC License: C-1150
www.dsoeng.com


SEAL
007138
B. SIMS
2/21/25

THE CARROLTON OF NASH
NURSING FACILITY
Rocky Mount, North Carolina

David R. Polston - Architect
3806 Park Ave. Suite C, Wilmington, NC 28403
Architecture Planning Design

BUILDING
RENOVATIONS

2

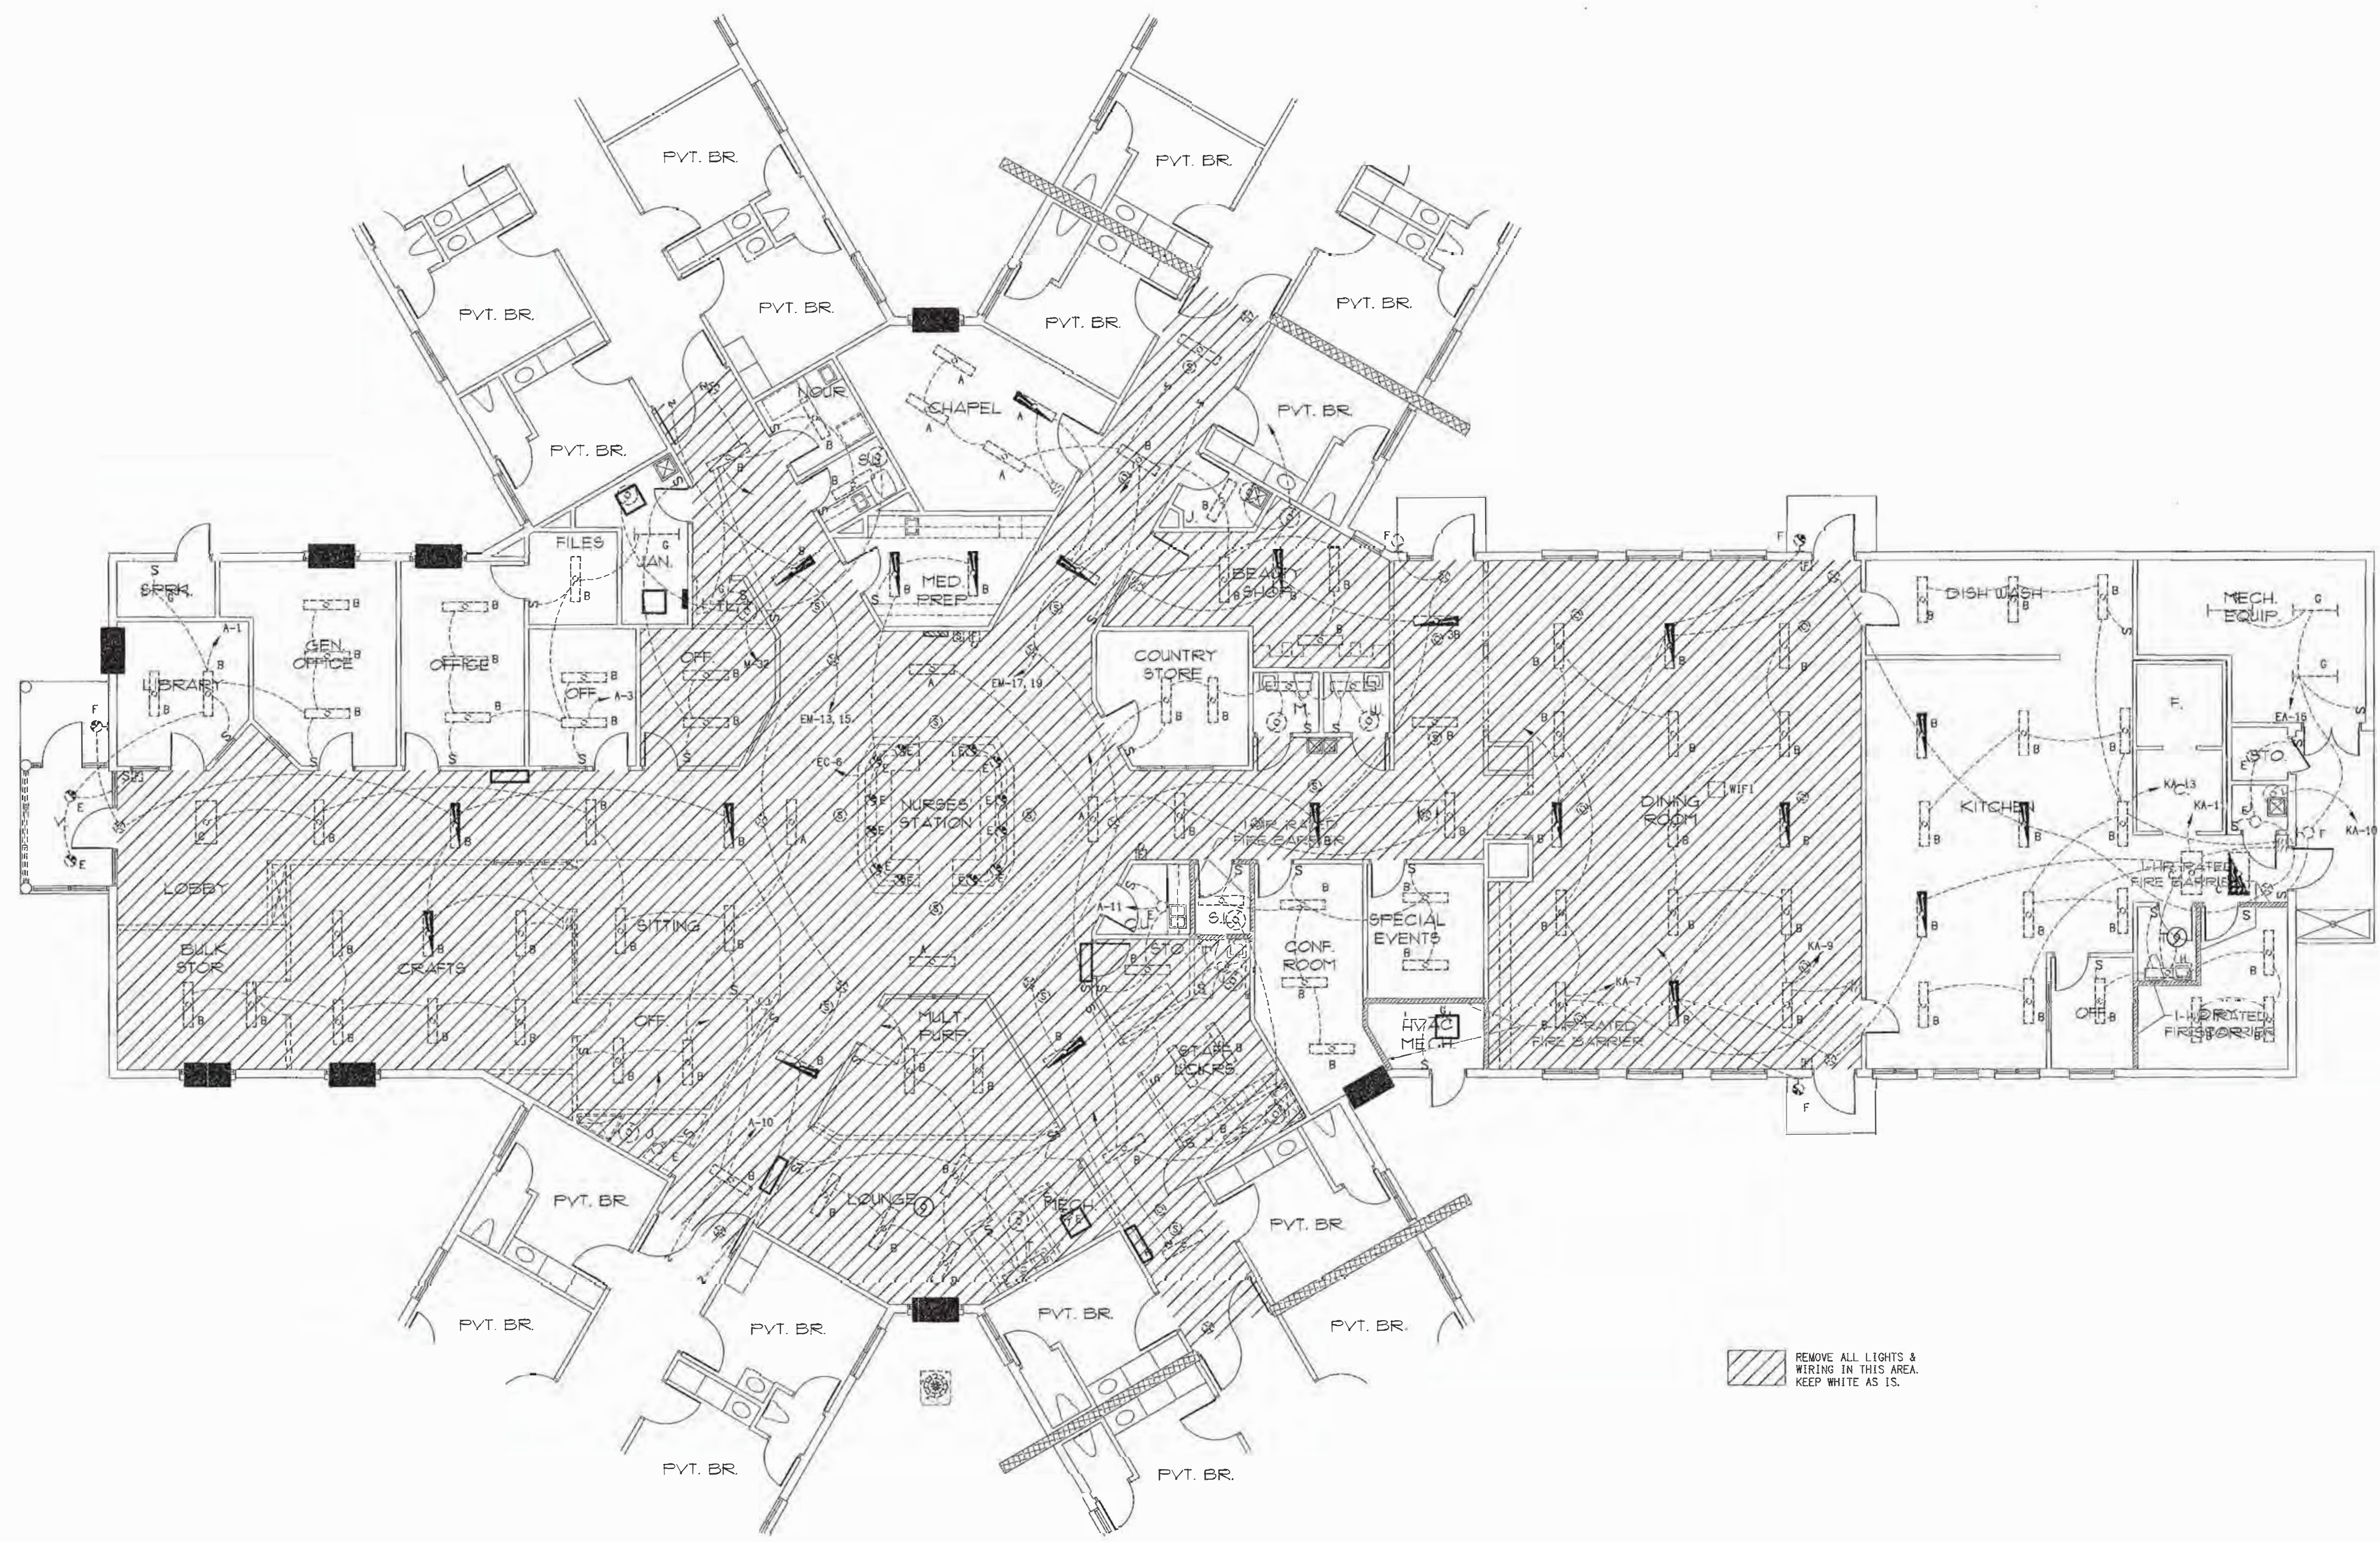

A Partial Lighting Demolition Plan - Existing Center Core
E2 SCALE: 1/8" = 1' - 0"

symbol	date	description	by
REVISIONS			

TIME: 9:28 DATE: 02/21/2025 DRAWING LOCATION: F:\PROJECTS\2023\25505\PI\new\A\WORK\25505.dwg

LIGHTING FIXTURE SCHEDULE - FOR UNSHADED AREAS										
SYMBOL	DESCRIPTION	LAMP				STATUS	MANUF.	MODEL	MOUNTING	REMARKS
		NO.	WATT	TYPE	VOLT					
	2' x 4' BOX	4	32	F	120	EXISTING	-	-	SURFACE	-
	1' x 4' BOX	2	32	F	120	EXISTING	-	2TG30LR840-2- FS-02F-UNV	SURFACE	-
	2' x 4' BOX	2	32	F	120	EXISTING REUSE	DAY-BRITE	-	SURFACE	-
	LAY-IN	4	32	F	120	EXISTING	-	-	CEILING LAY-IN	-
E	-	1	50	-	120	EXISTING	-	-	CEILING RECESS	-
F	EXTERIOR SCENCE	1	50	-	120	EXISTING	-	-	WALL	-
G	4' STRIP	-	32	F	120	EXISTING	-	-	CEILING SURFACE	-
H	2x4 BAY	1	61	LED	120	NEW	LUMAX SV LED	66L2435K9- FARSDM1	CEILING SURFACE	-
I	CHANDELIER	-	50	LED	120	NEW	-	-	SUSPEND FROM CEILING	\$500 ALLOWANCE
	EXIT	-	-	-	-	EXISTING	-	-	-	-
	EMERGENCY	-	-	-	-	EXISTING	-	-	7' 6"	PROVIDE BATTERY BACKUP

DATE- 02/21/2025 DRAWING LOCATION- F:\PROJECTS\2025\25906\PIonwork\DWGS\25906.e3.dwg

2/21/25

Rocky Mount, North Carolina

Architecture Planning Design


サニタリー

DSA #25906



E4 SCALE: 1/8" = 1'-0"

symbol	date	description	by
REVISIONS			

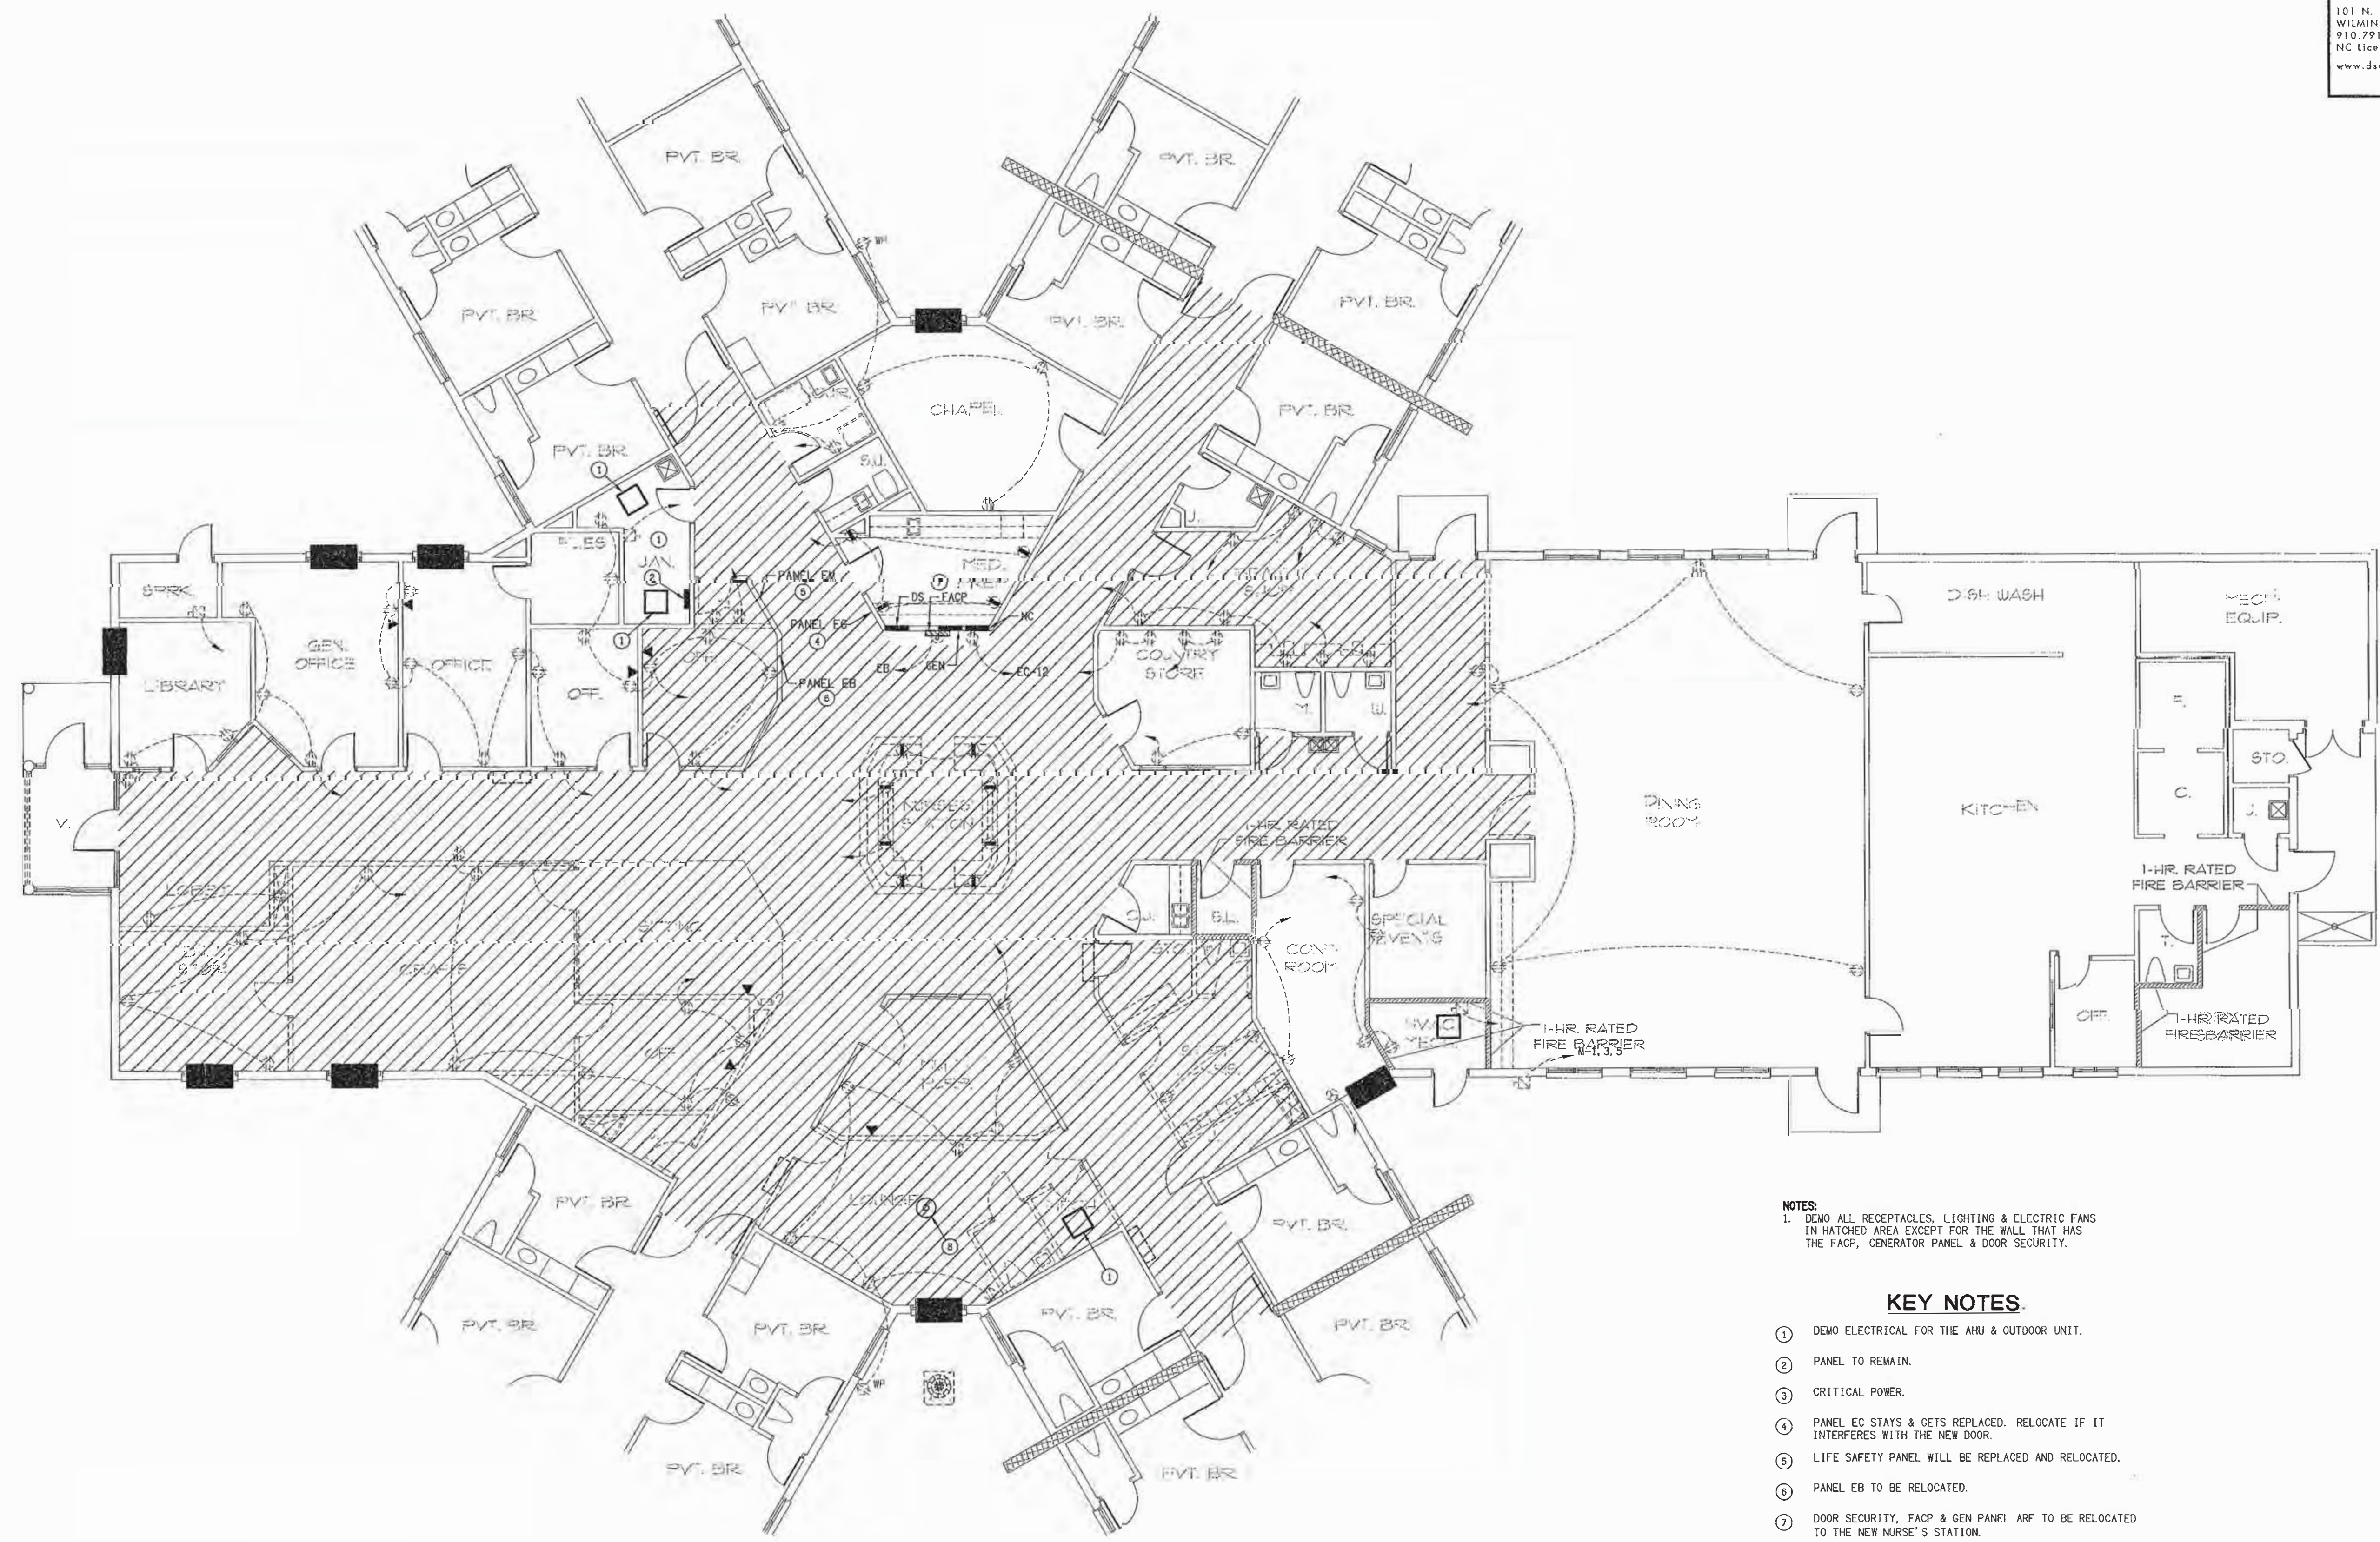


A Partial Power Demo Plan - Existing Center Core
E5 SCALE: 1/8" = 1'-0"

NOTES:
1. DEMO ALL RECEPTACLES, LIGHTING & ELECTRIC FANS
IN HATCHED AREA EXCEPT FOR THE WALL THAT HAS
THE FAC, GENERATOR PANEL & DOOR SECURITY.

- KEY NOTES:
- 1. DEMO ELECTRICAL FOR THE AHU & OUTDOOR UNIT.
 - 2. PANEL TO REMAIN.
 - 3. CRITICAL POWER.
 - 4. PANEL EC STAYS & GETS REPLACED. RELOCATE IF IT
INTERFERES WITH THE NEW DOOR.
 - 5. LIFE SAFETY PANEL WILL BE REPLACED AND RELOCATED.
 - 6. PANEL EB TO BE RELOCATED.
 - 7. DOOR SECURITY, FAC & GEN PANEL ARE TO BE RELOCATED
TO THE NEW NURSE'S STATION.
 - 8. DEMO FAN.

symbol	date	description	by
REVISIONS			

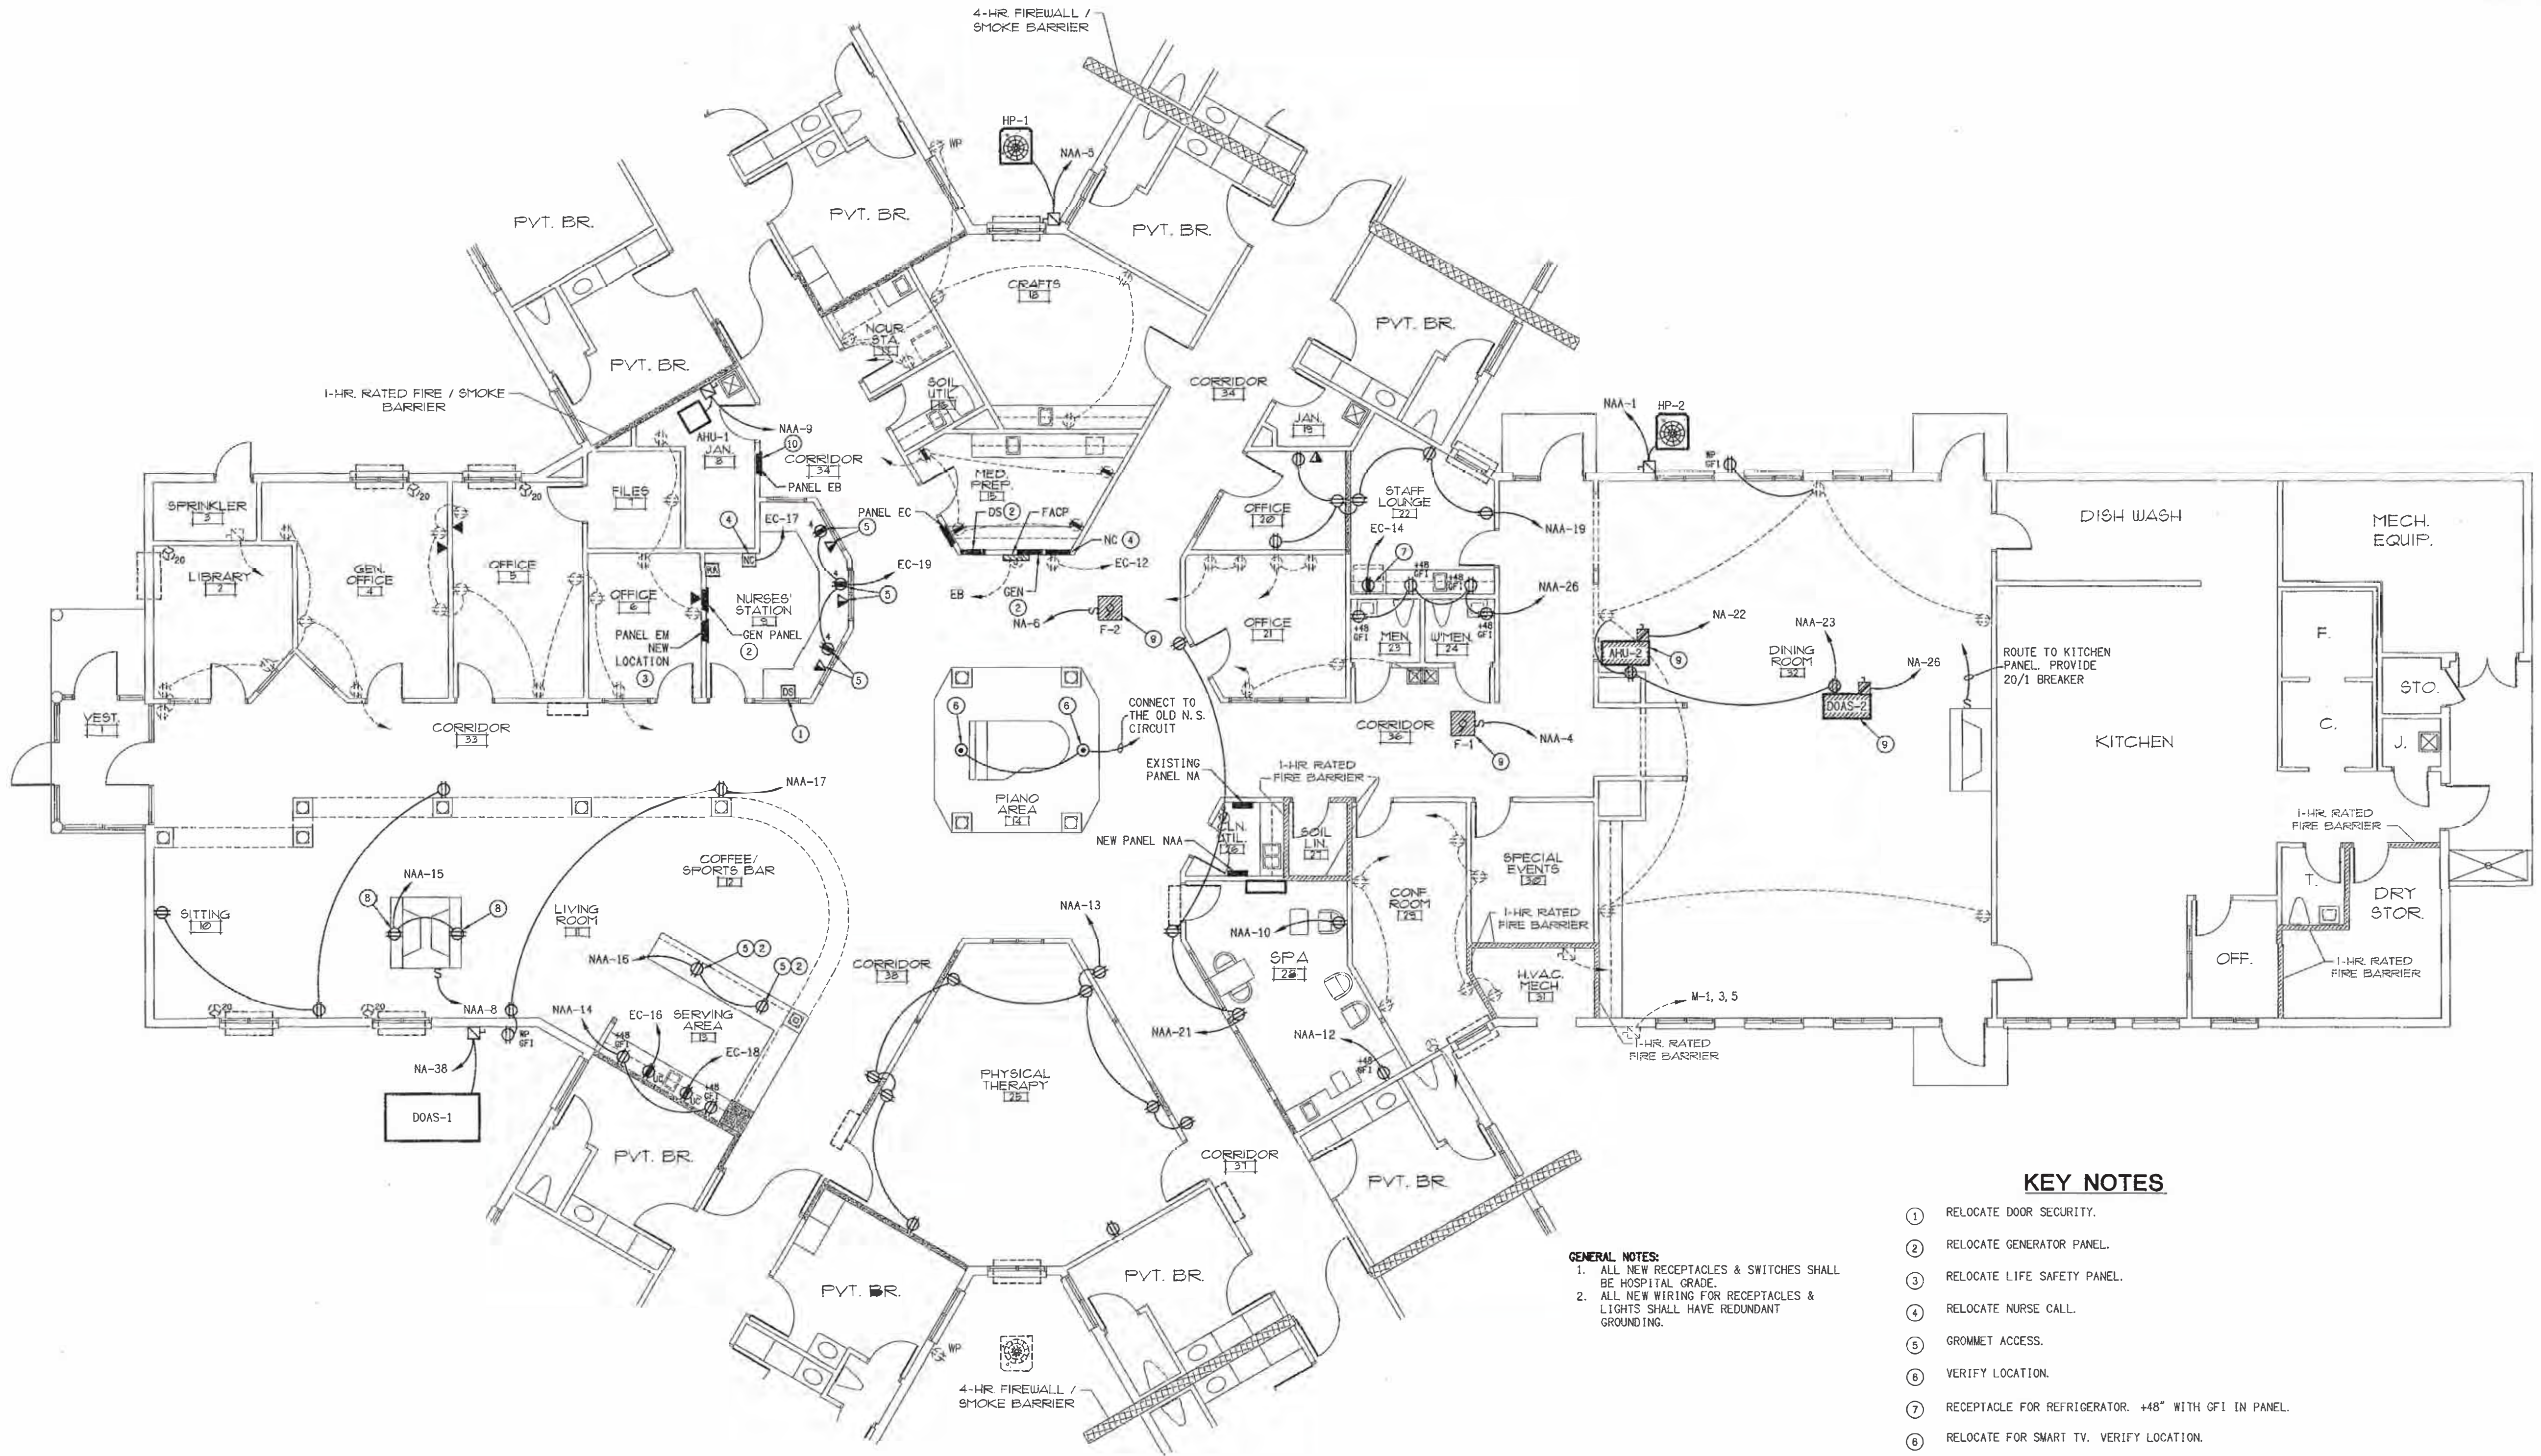

A Partial Power Renovation Plan - Center Core
E6 SCALE: 1/8" = 1'-0"

symbol	date	description	by
REVISIONS			

ELECTRICAL SPECIFICATIONS

- 1601 GENERAL
- A. INSTALLATION SHALL COMPLY WITH THE LATEST EDITION OF THE NORTH CAROLINA STATE BUILDING CODE, VOLUME 1 AND VOLUME 2, NATIONAL ELECTRIC CODE, LOCAL BUILDING CODES AND ORDINANCES AND OTHER NATIONAL CODES AND ORDINANCES. IN THE CASE OF CONFLICT BETWEEN THE CODE AND THE DRAWINGS AND SPECIFICATIONS OR BETWEEN THE VARIOUS CODES, THEN THE MOST RESTRICTIVE SHALL TAKE PRECEDENT.
- B. PROVIDE AND PAY ALL LICENSES, FEES, PERMITS, POWER COMPANY CONNECTION CHARGES, IF ANY, INSURANCE, ETC., REQUIRED FOR EXECUTION OF THIS WORK.
- C. ELECTRICAL CONTRACTOR SHALL PROVIDE THE MATERIALS, PERFORM THE WORK AND TEST AND PAY ALL FEES NECESSARY TO MAKE THE ELECTRICAL SYSTEM OPERABLE AND READY FOR USE BY THE OWNER.
- D. GUARANTEE: EQUIPMENT, MATERIALS AND INSTALLATION SHALL BE GUARANTEED TO BE FREE OF DEFECTS FOR A PERIOD OF ONE (1) YEAR AFTER FINAL ACCEPTANCE OF WORK OR IN ACCORDANCE WITH THE MANUFACTURER'S STANDARD GUARANTEE, IF LONGER.
- E. IT IS UNDERSTOOD AND AGREED THAT THESE PLANS AND SPECIFICATIONS SHALL BE FULFILLED IN THEIR TRUE SPIRIT AND INTENT SO THAT ANY MINOR MATERIALS OR DEVICES ESSENTIAL TO PROPER AND CONVENIENT OPERATION, REQUIRED OR IMPLIED, SHALL BE SUPPLIED AND INSTALLED BY THE CONTRACTOR WITHOUT EXTRA CHARGE, EVEN THOUGH NOT SPECIFICALLY CALLED OUT.
- F. INSTALLATION SHALL COMPLY WITH OSHA STANDARDS.
- G. THE ELECTRICAL CONTRACTOR SHALL BE RESPONSIBLE FOR HIS OWN CLEAN UP AND REMOVAL OF SCRAP FROM THE JOB SITE. THE ELECTRICAL CONTRACTOR SHALL MAINTAIN A CLEAN AND SAFE WORK AREA. THE ENGINEER IS NOT RESPONSIBLE FOR JOB SITE SAFETY.
- H. IN CASE OF CONFLICT BETWEEN THE PLANS AND SPECIFICATIONS OR CONFLICT BETWEEN INFORMATION PRESENTED ON THE PLANS OR IN THE SPECIFICATIONS, THEN THE MOST RESTRICTIVE SHALL TAKE PRECEDENT.
- I. DIVISION I SHALL BECOME A PART OF THESE SPECIFICATIONS BY REFERENCE.
- J. ALL ELECTRICAL COMPONENTS SHALL BE INSTALLED, SUPPORTED, AND RESTRAINED IN ACCORDANCE WITH THE NORTH CAROLINA BUILDING CODE REQUIREMENTS FOR SEISMIC DESIGN. IT SHALL BE THE RESPONSIBILITY OF THE CONTRACTOR TO RETAIN A PROFESSIONAL ENGINEER COMPETENT IN THIS FIELD FOR THIS DESIGN. FOR ONE POSSIBLE SOURCE FOR THIS SERVICE CONTACT SEISMIC CONTROL AND ISOLATIONS, INC. PHONE: 910-799-5204. ALL REQUIRED INSPECTIONS FOR THESE DESIGNS SHALL BE PERFORMED BY APPROVED INSPECTORS AND AGENCIES PROVIDED BY OWNER AND OWNER'S AGENT.
- K. THE PLAN SHOWN IS SCHEMATIC ONLY. DO NOT SCALE OFF OF THE ELECTRICAL PLANS. SCALE OF OF THE ARCHITECTURAL PLANS ONLY.

- 1602 SCOPE
- WORK SHALL INCLUDE BUT IS NOT LIMITED TO:
- A. PROVIDE ALL ELECTRICAL DEMOLITION REQUIRED FOR THE RENOVATION.
- B. PROVIDE AND INSTALL FIXTURES AS SHOWN ON THE PLANS.
- C. PROVIDE AND INSTALL WIRING DEVICES, PANELS, AND CONDUIT.
- D. PROVIDE CONNECTIONS TO MECHANICAL, AND PLUMBING EQUIPMENT.
- E. RESTORE ALL LOW VOLTAGE SYSTEMS INCLUDING NURSE CALL, P.A. SYSTEM, MAG LOCK AND FIRE ALARM SYSTEMS.

- 1603 MATERIALS
- A. CONDUCTORS
1. ALL WIRE SHALL BE COPPER. WIRE #8 AND LARGER SHALL BE STRANDED.
2. USE WIRE WITH THIN/THIN INSULATION FOR ALL WIRE.
3. POWER CONDUCTORS SHALL BE #12 AWG MINIMUM. PILOT AND CONTROL CIRCUITS MAY BE #14 AWG.
- B. CONDUIT
1. UNDERGROUND CONDUIT SHALL BE PVC. CHANGE TO RIGID GALVANIZED BELOW CONCRETE FLOOR AND STUB UP THROUGH FLOOR WITH RIGID GALVANIZED.
2. ARMOR CLAD CABLE SHALL BE ALLOWED IN CONCEALED AREAS.
3. OTHER ABOVE GRADE CONDUIT SHALL BE EMT WITH STEEL COMPRESSION FITTINGS. IF EXPOSED TO MECHANICAL DAMAGE CONDUIT SHALL BE RIGID GALVANIZED.
4. CONNECTIONS TO EQUIPMENT AND FIXTURES SHALL BE MADE WITH SEAL TIGHT FLEX CONDUIT FOR EXTERIOR CONNECTIONS AND GREENFIELD FOR INTERIOR CONNECTION. ALL NEW WIRE FOR RECEPTACLES AND LIGHTING SHALL HAVE REDUNDANT GROUNDING. HOSPITAL GRADE METAL CLAD CABLE WILL BE ALLOWED IN ATTICS & CONCEALED AREAS.
- C. WIRING DEVICES SHALL BE ONE MAKE, UNDERWRITERS APPROVED, MANUFACTURED BY PASS & SEYMOUR, HUBBELL OR EQUAL. DEVICE COVERS SHALL BE WEATHERPROOF FOR EXTERIOR COVERS. WIRING DEVICES SHALL BE HOSPITAL GRADE. COLOR SHALL BE DETERMINED BY THE ARCHITECT EXCEPT FOR WIRING DEVICES ON EMERGENCY POWER WHICH SHALL BE RED.
- D. DISTRIBUTION EQUIPMENT SHALL BE THE LATEST PRODUCTS, MANUFACTURER SHALL BE G.E., SQUARE D, WESTINGHOUSE, OR ITE. INTERIOR EQUIPMENT SHALL BE NEMA 1 AND EXTERIOR EQUIPMENT SHALL BE NEMA 3R MINIMUM.
- E. PROVIDE MOTOR RATED SWITCHES FOR SWITCHES SERVING MOTORS AS REQUIRED.
- F. FUSES SHALL BE CURRENT LIMITING TIME DELAY FUSES "CLASS RK5".
- G. ALL EQUIPMENT AND FIXTURES SHALL BE UL APPROVED.
- H. PROVIDE LAMPS FOR ALL FIXTURES. LAMPS SHALL BE G.E., OR SYLVANIA.

- 1604 EXECUTION
- A. UNLESS OTHERWISE NOTED, SET ALL RECEPTACLES SET ALL RECEPTACLES AT 16" AFF, AND SET ALL SWITCHES AT 48" AFF.
- B. HOLES SHALL BE DRILLED OR CUT. DO NOT BREAK HOLES.
- C. THE ELECTRICAL CONTRACTOR SHALL DO ALL CUTTING, PATCHING AND PAINTING NECESSARY TO INSTALL ALL EQUIPMENT AS REQUIRED UNDER THIS CONTRACT, AND SHALL ESTABLISH ALL FINISHES WHEN CUTTING AND PATCHING OCCUR TO THEIR ORIGINAL CONDITION. QUALIFIED WORKERS SHALL DO ALL CUTTING AND PATCHING WORK (I.E. DRY WALL CUTTING AND PATCHING SHALL BE DONE BY QUALIFIED DRY WALL CRAFTSMEN).
- D. PATCHING SHALL BE DONE BY THE ELECTRICAL CONTRACTOR. ALL PATCHING SHALL BE DONE BY A CRAFTSMAN SKILLED IN THE WORK BEING PERFORMED.
- E. WIRE SHALL BE COLOR CODED AS FOLLOWS:

PHASE A
PHASE B
PHASE C
NEUTRAL
GROUND

120/208
BLACK
RED
BLUE
WHITE
GREEN

- F. CONTRACTOR SHALL CONFIRM THE LOCATION OF ALL EQUIPMENT AND POWER REQUIREMENTS FOR ALL EQUIPMENT BEFORE RUNNING SERVICE.
- G. CONDUIT AND WIRING IN FINISHED AREAS SHALL BE CONCEALED. ANY EXPOSED CONDUIT SHALL BE RUN IN A NEAT FASHION AND SHALL BE RUN PERPENDICULAR AND PARALLEL TO THE BUILDING LINES.
- H. TELEPHONE AND COMPUTER OUTLETS SHALL BE QUAD RECEPTACLE BOXES WITH DRYWALL FLANGE WITH A 4"x4" OPENING AND 1" EMT STUBBED INTO THE CEILING WITH PULL STRINGS INSTALLED.
- I. CONTRACTOR SHALL PRESERVE ALL FIRE RATED WALLS AND CEILINGS. VERIFY RATING WAS OFF THE ARCHITECTURAL PLAN. THIS SHALL INCLUDE USING CAULKING THAT IS UL APPROVED FOR THE APPLICATIONS, OFFSETTING BOXES AS REQUIRED AND PROVIDING RATED CAPS OR COVERS FOR LIGHTS, AS REQUIRED.
- J. PROVIDE BOTH POWER AND SERVICE SIDE CONNECTIONS.

- 1605 DIRECTORY CARDS, NAME PLATES & EQUIPMENT LABELS
- A. PROVIDE A TYPED DIRECTORY CARD IN EACH PANELBOARD INDICATING ELECTRICAL DEVICES OR EQUIPMENT SERVED BY EACH CIRCUIT BREAKER. FURNISH BLANK COVERPLATE.
- B. PROVIDE NAMEPLATES FOR PANELS AND DISCONNECTS. NAMEPLATES SHALL BE LAMINATED PLASTIC. EACH NAMEPLATE SHALL IDENTIFY THE PANEL AND THE VOLTAGE. NAMEPLATES SHALL BE MELAMINE PLASTIC, 0.125 INCH THICK, BLACK WITH WHITE CENTER CORE. SURFACE SHALL BE MATTE FINISH. CORNERS SHALL BE SQUARE. ACCURATELY ALIGN LETTERING AND ENGRAVE INTO CORE. MINIMUM SIZE OF NAMEPLATES SHALL BE 1X2.5 INCHES. LETTERING SHALL BE A MINIMUM OF 0.25 INCHES HIGH, NORMAL BLOCK STYLE.

- 1606 TEST & ADJUSTMENTS
- A. TEST AND ADJUST THE ELECTRICAL SYSTEM AND RELATED WORK PROVIDED UNDER THIS DIVISION OF THE SPECIFICATIONS.
- B. TEST ALL CIRCUITS WITH A "MEGGER" TEST TO DETERMINE THAT THE SYSTEM IS FREE OF SHORT CIRCUITS AND THAT PHASE CONDUCTORS ARE NOT GROUNDED. CHECK ALL ELECTRICAL EQUIPMENT FOR PROPER OPERATIONS.

- 1607 GROUNDING
- A. THE SERVICE EQUIPMENT, CONDUIT SYSTEM SUPPORT CABINETS, EQUIPMENT AND NEUTRAL CONDUCTOR SHALL BE GROUNDED IN ACCORDANCE WITH ARTICLE 250 OF THE LATEST EDITION OF THE NATIONAL ELECTRIC CODE. GROUNDING CONDUCTORS SHALL BE SO ROUTED AS TO PERMIT, AS FAR AS PRACTICAL, THE SHORTEST AND MOST DIRECT PATH TO THE GROUND ELECTRODE SYSTEM. ALL GROUND CONNECTIONS SHALL HAVE A CLEAN CONTACT SURFACE.
- B. RUN A SEPARATE EQUIPMENT GROUND IN ALL FEEDS.

- 1608 SUBSTITUTION
- A. ALL MATERIALS SHALL BE NEW UNLESS OTHERWISE SHOWN OR SPECIFIED AND SHALL BE OF THE VERY BEST QUALITY AS SPECIFIED.
- B. REQUESTS TO SUBSTITUTE OTHER MATERIALS OR PRODUCTS FOR THOSE SPECIFIED SHALL BE SENT IN WRITING TO THE OWNER. REQUESTS SHALL BE ACCOMPANIED BY ENGINEERING DATA, SPECIFICATION SHEETS, ETC., AS NECESSARY TO FULLY IDENTIFY AND APPRAISE THE PRODUCTS.
- C. APPROVAL OF EQUIPMENT WILL NOT RELIEVE THE CONTRACTOR OF NONCOMPLIANCE WITH THE SPECIFICATIONS EVEN IF SUCH APPROVAL IS MADE IN WRITING, UNLESS THE ENGINEER IS CALLED TO THE NONCONFORMING FEATURES BY LETTER ACCOMPANYING THE SUBMITTAL DATA.

- 1609 VISIT TO SITE
- ALL BIDDERS ON THIS WORK SHALL VISIT THE SITE AND THOROUGHLY FAMILIARIZE THEMSELVES WITH EXISTING CONDITIONS BEFORE SUBMITTING THEIR BIDS. NO ALLOWANCE WILL BE MADE FOR LACK OF KNOWLEDGE OF EXISTING CONDITION.

- 1610 SHOP DRAWINGS
- AS SOON AS POSSIBLE (AND NOT MORE THAN 30 DAYS) AFTER THE CONTRACT IS SIGNED, THE CONTRACTOR SHALL SUBMIT FIVE (5) COPIES OF THE SHOP DRAWINGS COVERING LIGHTING FIXTURES, PANELS, CIRCUIT, BREAKERS, AND WIRING DEVICES, AND ANY SPECIAL EQUIPMENT WHICH HE INTENDS TO USE. SHOP DRAWINGS SHALL BE SUBMITTED TO THE OWNER FOR HIS APPROVAL.

PANEL-NA															
TYPE		BOLT-ON		MOUNTING		SURFACE		ENCLOSURE		NEMA-1		PHASE 3		WIRE 4	
VOLTS		120/208		MAIN		400A MLO		FRAME		400A		SHORT CIR.RATING		22,000 RMS SYM MIN	

DS

ENGINEERING

101 N. 3RD ST., SUITE 403
WILMINGTON, NC 28403
910.791.8016
NC License C-1150
www.dsoeng.com

2/21/25

THE CARROLTON OF NASH
NURSING FACILITY
Rocky Mount, North Carolina

David R. Polston - Architect
3806 Park Ave. Suite C, Wilmington, NC 28403
Architecture Planning Design

BUILDING
RENOVATIONS

symbol	date	description	by
REVISIONS			

DSA #25906

A EXISTING FIRE ALARM PLAN
E9 SCALE: 1/16" = 1'-0"

B DEMOLITION FIRE ALARM PLAN
E9 SCALE: 1/16" = 1'-0"

FIRE ALARM LEGEND	
SYMBOL	DESCRIPTION
(S)	EXISTING SMOKE DETECTOR
(XX)	EXISTING STROBE/CHIME
(P)	EXISTING FACP
(P)	EXISTING PULL STATION
(M)	EXISTING MAGNETIC DOOR HOLDER
(S)	NEW SMOKE DETECTOR
(XX)	NEW STROBE ONLY XX CANDELA
(XX)	NEW STROBE XX CANDELA
(B)	NEW SMOKE DETECTOR BEAM
(B)	NEW BEAM DETECTOR
FACP	FIRE ALARM CONTROL PANEL
FAHU	NEW FRESH AIR MAKE UP UNIT
(D)	EXISTING DUCT DETECTOR
(A)	REMOTE ANNUNCIATOR

FIRE ALARM NOTES:

1. PROVIDE NEW DEVICES AS SHOWN ON THE PLANS.
2. CONNECT TO THE EXISTING FACP. PROVIDE ALL NEEDED EQUIPMENT TO MAKE THE CONNECTIONS INCLUDING REPLACING THE FACP AND ADDING A POWER BOOSTING STATION. CONNECT TO PANEL EB FOR 120V POWER.
3. WIRE:
 - A. STRANDED COPPER.
 - B. SIGNAL CIRCUIT WIRE SIZE = #16 GA.
 - C. ALARM CIRCUIT WIRE SIZE = #14 GA.
 - D. ROUTE WIRE IN 3/4" CONDUIT WITH JUNCTION BOXES PAINTED RED.
 - E. UL APPROVED FIRE RATED CABLE WILL BE ALLOWED IN UNFINISHED AREAS AND WALLS.
4. PROVIDE A DUAL LINE DIALER IF NOT PRESENT.
5. PROVIDE A MAXIMUM OF 8 ALARMS PER CIRCUIT.
6. ON GENERAL ALARM, SHUT DOWN:
 - A. DOAS UNITS
 - B. OPEN DOORS TO SECURITY SYSTEM.
 - C. CLOSE DOORS ON MAGNETIC DOOR HOLDERS.
 - D. ACTIVATE ALL ALARM DEVICES.
7. POST A MAP OF ALL SMOKE COMPARTMENTS.
8. COORDINATE WITH THE MECHANICAL CONTRACTOR TO KEEP ALL SMOKE DETECTORS AT A DISTANCE OF 3'-0" MINIMUM FROM SUPPLY AND RETURN GRILLES.
9. SYSTEM IS ADDRESSABLE.
10. ADD OR REPLACE ITEMS THAT ARE MISSING OR DAMAGED.

E FIRE ALARM RISER
E9 SCALE: NTS

C RENOVATION FIRE ALARM PLAN
E9 SCALE: 1/16" = 1'-0"

D TYPICAL MOUNTING HEIGHT DETAIL
E9 SCALE: NTS

DSA
ENGINEERING

DSA ENGINEERING
101 N. 3RD ST., SUITE 403
WILMINGTON, NC 2840
910.791.8016
NC license: C-1150
www.dsaeng.com


PROFESSIONAL
SEAL
007138
DAVID R. POLSTON
2/21/25

THE CARROLTON OF NASH
NURSING FACILITY
Rocky Mount, North Carolina

David R. Polston - Architect
3806 Park Ave. Suite C, Wilmington, NC 28403
Architecture Planning Design

BUILDING
RENOVATIONS

10

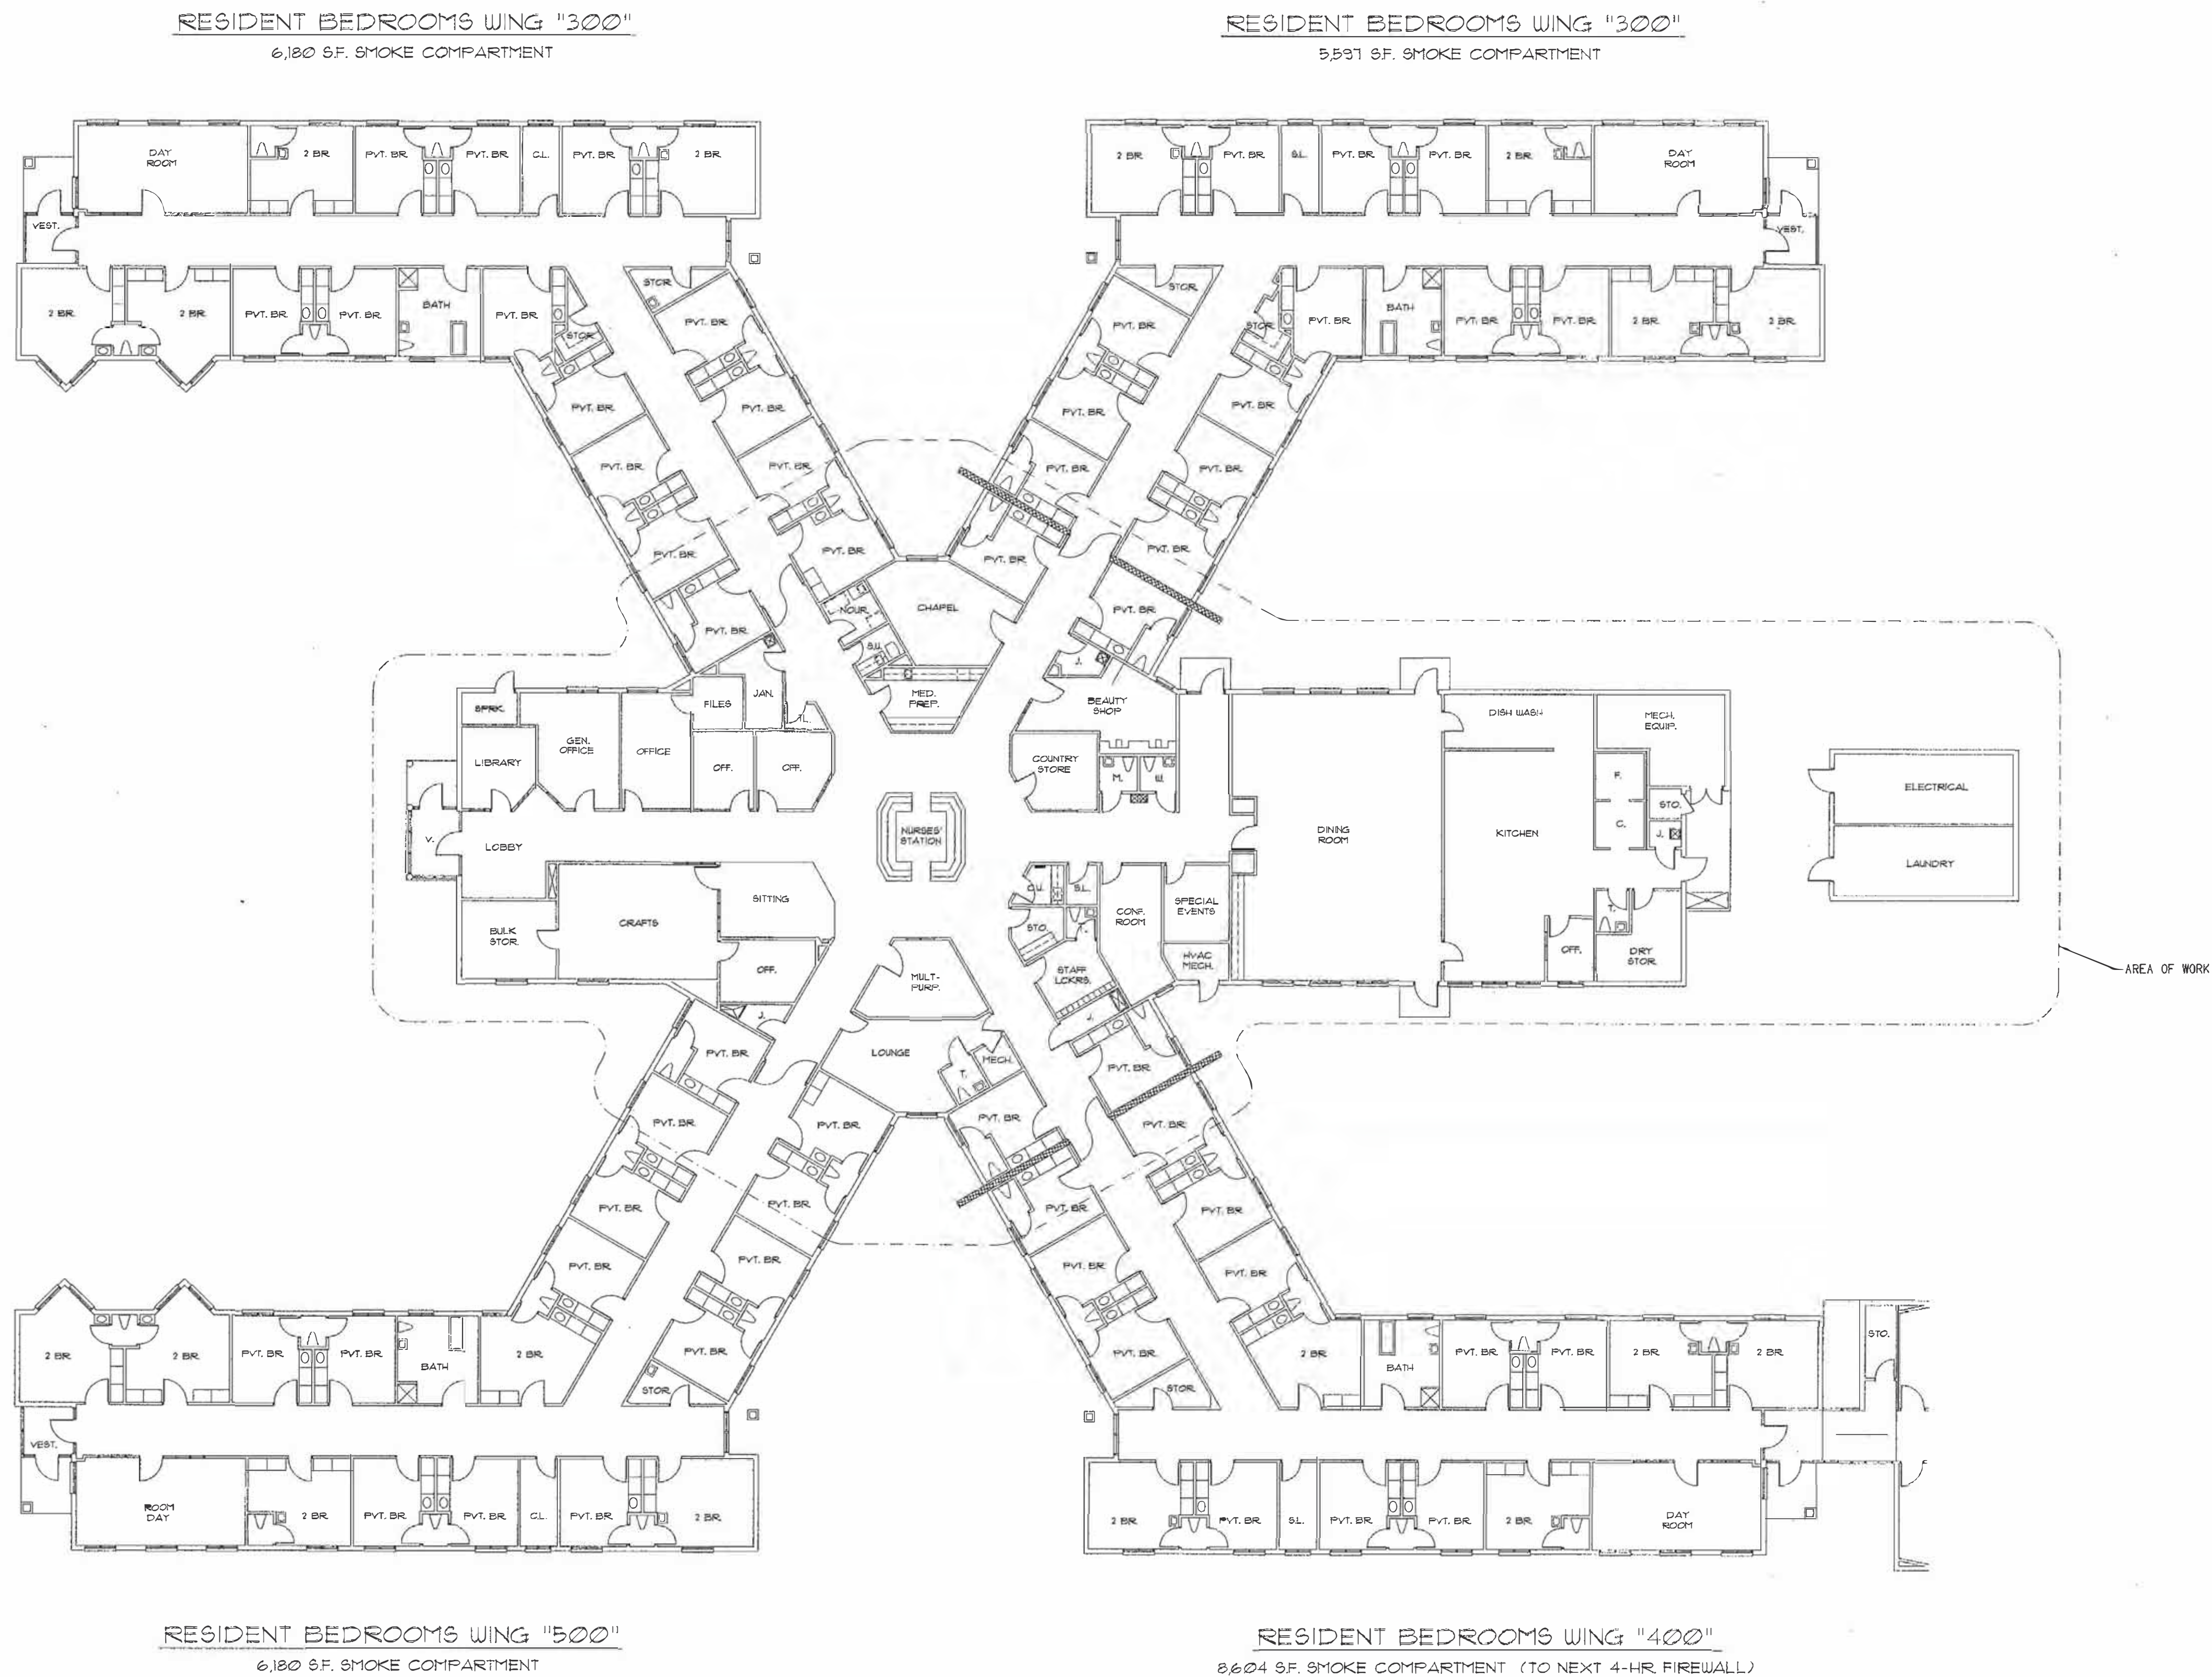

A

Overall Building Plan

E10

SCALE: 1/16" = 1' - 0"

symbol	date	description	by
REVISIONS			