

PRINCIPLE HEALTHCARE WAKE COUNTY
HOLLY SPRINGS
1435 HWY 258 N 28504,
KINSTON, NC 28501-0039

**NOT FOR
CONSTRUCTION**

11-17-25 9:10 AM PRINTED BY: MATTHEW


REVISIONS

PROJECT STATUS:	C
DATE ISSUED:	11/14/2011
DRAWN BY:	M
CHECKED BY:	A
PROJECT#	1038887

EQUIPMENT
PLANS



Q-101

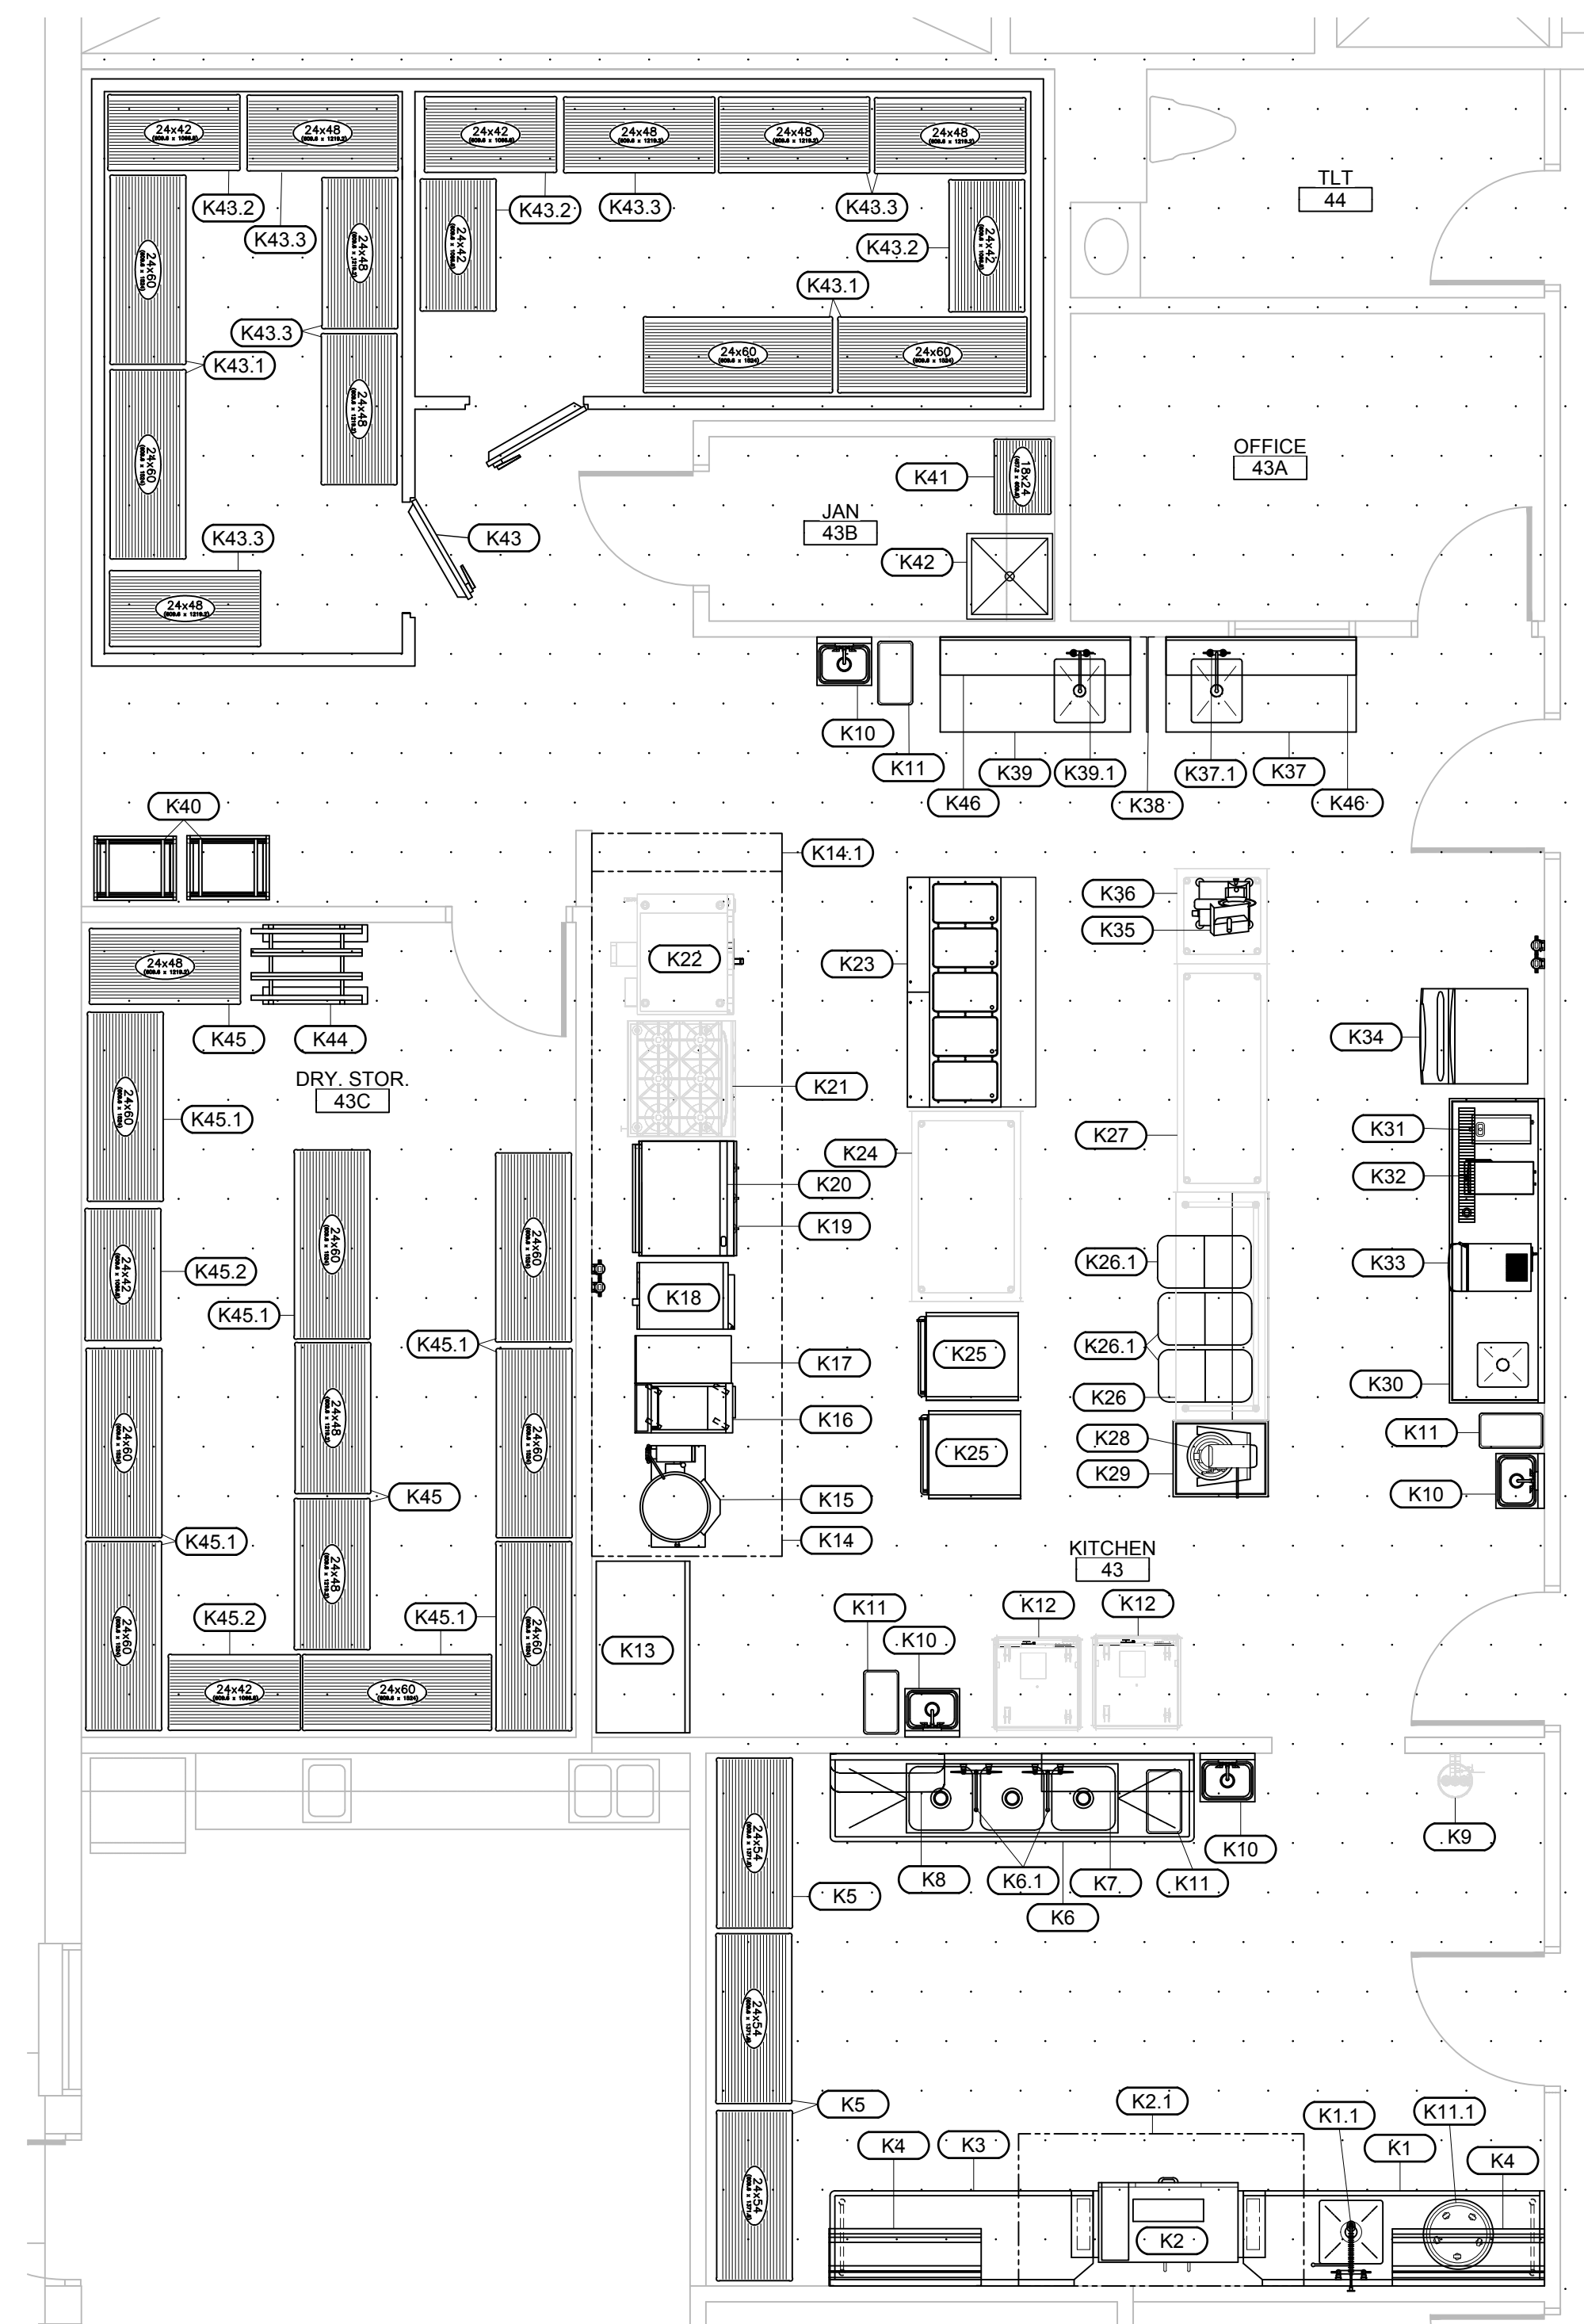



PLAN TRUE

1 MAIN KITCHEN EQUIPMENT PLAN

SCALE: 1/4" = 1'-0"

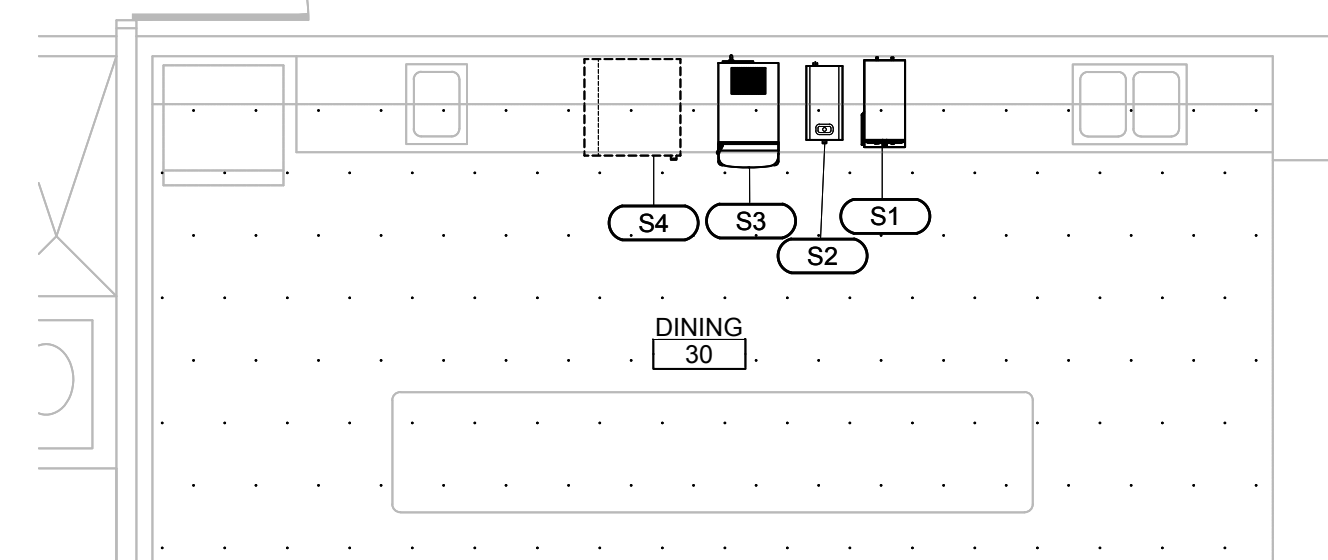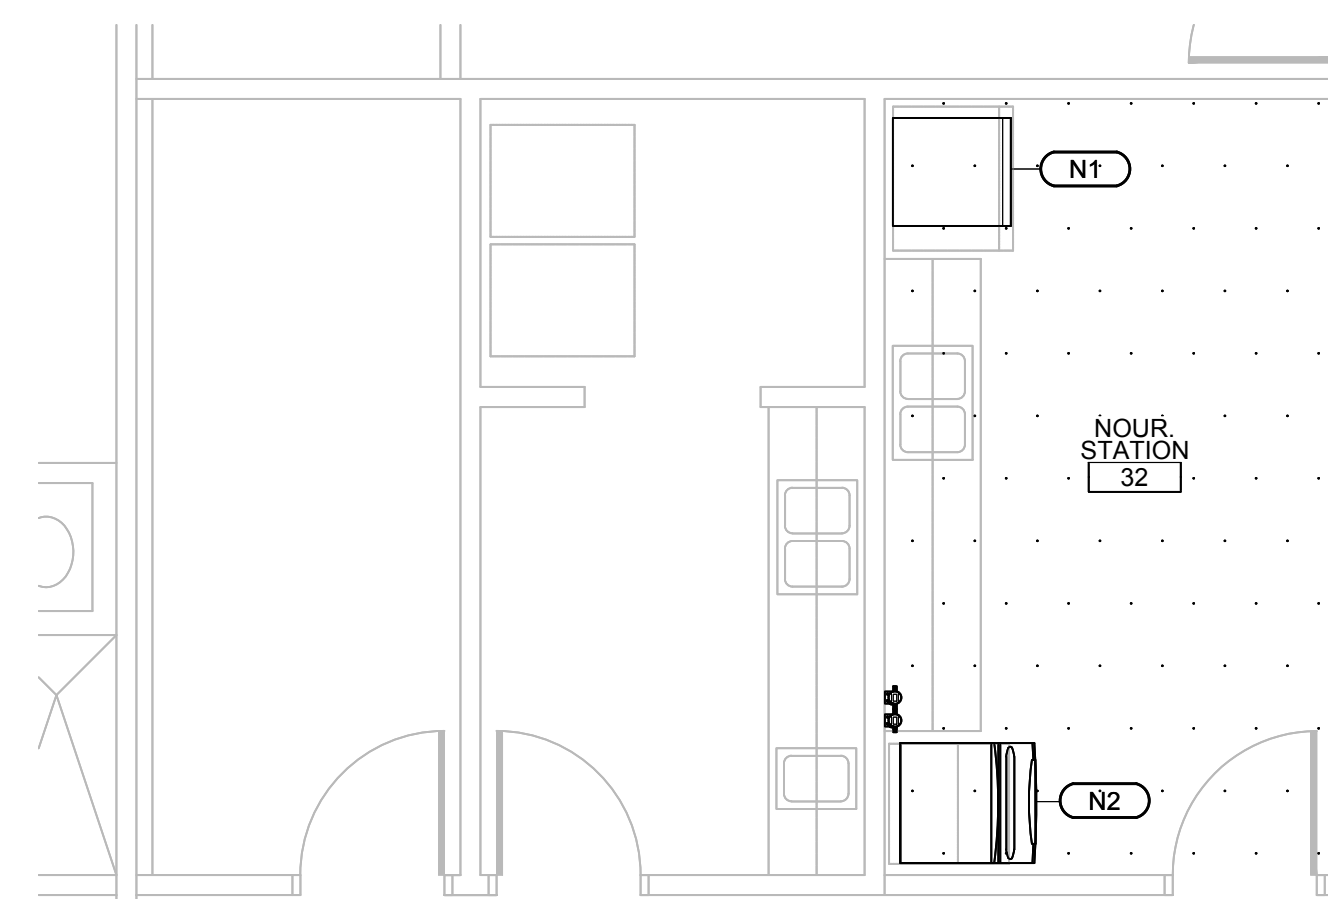

PLAN TRUE 2 NOURISH & DINING KITCHEN EQUIPMENT PLAN
SCALE: 1/4" = 1'-0"

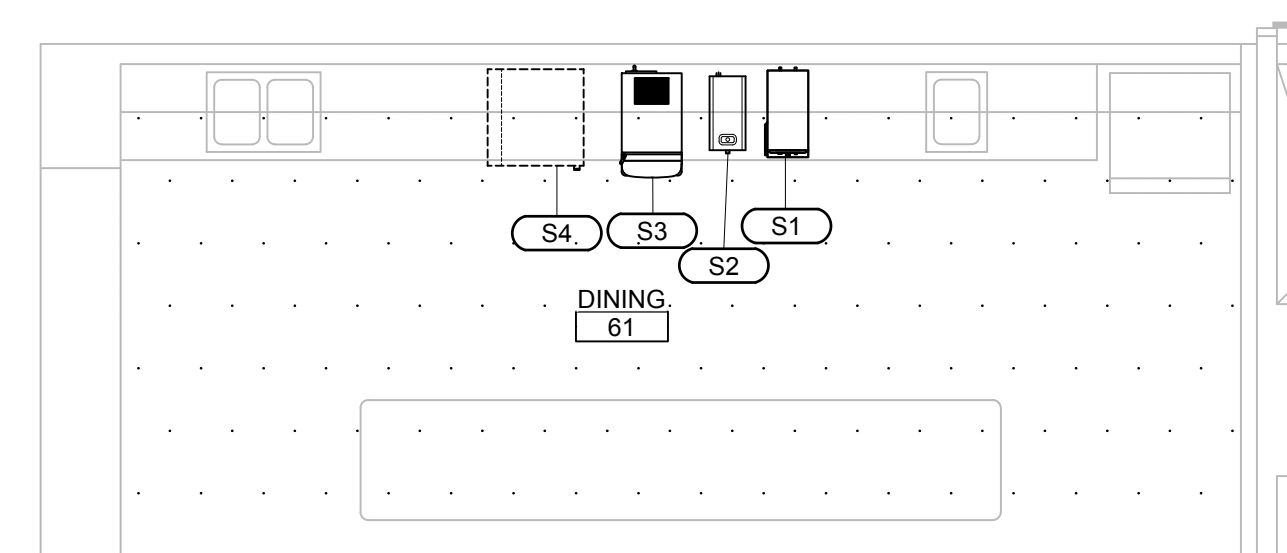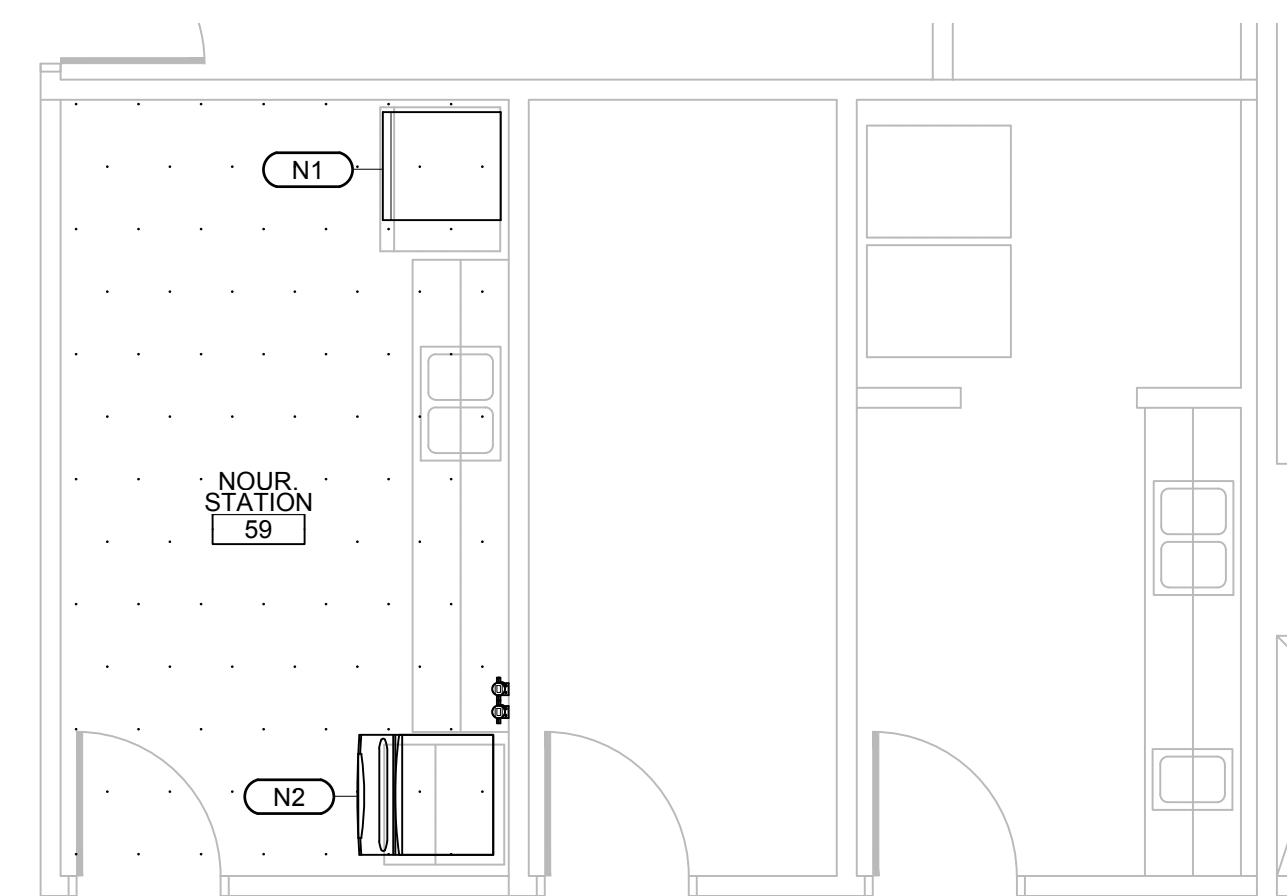

PLAN TRUE 3 NOURISH & DINING KITCHEN EQUIPMENT PLAN
SCALE: 1/4" = 1'-0"

KITCHEN - EQUIPMENT LEGEND			
ITEM NO	QTY	EQUIPMENT CATEGORY	EQUIPMENT REMARKS
K1	1	SOILED DISH TABLE	-
K1.1	1	PRE-RINSE UNIT	-
K2	1	WAREWASHER, CONVEYOR, HIGH TEMP	-
K2.1	1	CONDENSATE HOOD	-
K3	1	CLEAN DISH TABLE	-
K4	2	DISH RACK SHELF	-
K5	3	WIRE SHELVING, MOBILE	-
K6	1	THREE COMPARTMENT SINK	-
K6.1	2	FAUCET, SPLASH MOUNT	-
K7	1	SHELF, WALL MOUNT	-
K8	1	POT RACK, WALL MOUNT	-
K9	1	EYE WASH STATION	-
K10	4	HAND SINK, WALL MOUNT	-
K11	4	TRASH CAN	BY OWNER
K11.1	1	TRASH CAN MOBILE	BY OWNER
K12	2	HEATED BANQUET CART	-
K13	1	REFRIGERATOR, REACH-IN	-
K14	1	EXHAUST HOOD	-
K14.1	1	UTILITY CABINET	-
K15	1	STEAM KETTLE	-
K16	1	FRYER, GAS	-
K17	1	TABLE, FILLER	-
K18	1	STEAMER, ELECTRIC	-
K19	1	GRIDDLE, GAS	-
K20	1	STAND, EQUIPMENT	-
K21	1	RANGE, RESTAURANT, GAS	-
K22	1	CONVECTION OVEN, DOUBLE, GAS	-
K23	1	HOT FOOD TABLE	-
K24	1	WORK TABLE, MOBILE	-
K25	2	MOBILE HEATED CABINET	-
K26	1	WORK TABLE W/OVERSHELF	-
K26.1	3	INGREDIENT BIN	-
K27	1	WORK TABLE, MOBILE	-
K28	1	MIXER, 20 QT.	-
K29	1	STAND, MIXER	-
K30	1	BEVERAGE TABLE	-
K31	1	COFFEE MAKER	BY OWNER
K32	1	TEA BREWER	BY OWNER
K33	1	JUICE DISPENSER	BY OWNER
K34	1	ICE MAKER W/BIN	-
K35	1	SLICER	-
K36	1	SLICER STAND, MOBILE	-
K37	1	PREP SINK	-
K37.1	1	FAUCET, DECK MOUNT	-
K38	1	S/S SPLASH, WALL MOUNT	-
K39	1	PREP SINK	-
K39.1	1	FAUCET, DECK MOUNT	-
K40	2	BUN PAN RACK	-
K41	1	WIRE SHELVING, MOBILE	-
K42	1	MOP SINK	BY PLUMBING CONTRACTOR
K43	1	WALK-IN COOLER/FREEZER	-
K43.1	4	WIRE SHELVING, MOBILE	-
K43.2	4	WIRE SHELVING, MOBILE	-
K43.3	7	WIRE SHELVING, MOBILE	-
K44	1	CAN RACK	-
K45	3	WIRE SHELVING, MOBILE	-
K45.1	8	WIRE SHELVING, MOBILE	-
K45.2	2	WIRE SHELVING, MOBILE	-
K46	2	SHELF, WALL MOUNT	-

NOURISHMENT STATION - EQUIPMENT LEGEND			
ITEM NO	QTY	EQUIPMENT CATEGORY	EQUIPMENT REMARKS
N1	2	REFRIGERATOR, REACH-IN	-
N2	2	ICE MAKER W/IN	


SERVING KITCHEN - EQUIPMENT LEGEND			
ITEM NO	QTY	EQUIPMENT CATEGORY	EQUIPMENT REMARKS
S1	2	TEA BREWER	BY OWNER
S2	2	COFFEE MAKER	BY OWNER
S3	2	JUICE DISPENSER	BY OWNER
S4	2	REFRIGERATOR UNDERCOUNTER	GLASS DOOR




PLAN TRUE KEY PLAN
SCALE: NTS

ALL INFORMATION CONTAINED IN THIS DRAWING IS CONSIDERED TO BE THE PROPERTY OF DIRECT SUPPLY APTURA. NO USE OR REPRODUCTION THEREOF MAY BE MADE WITHOUT THE EXPRESS WRITTEN CONSENT OF DIRECT SUPPLY APTURA.


11-17-25 9:10 AM PRINTED BY: MATTEL

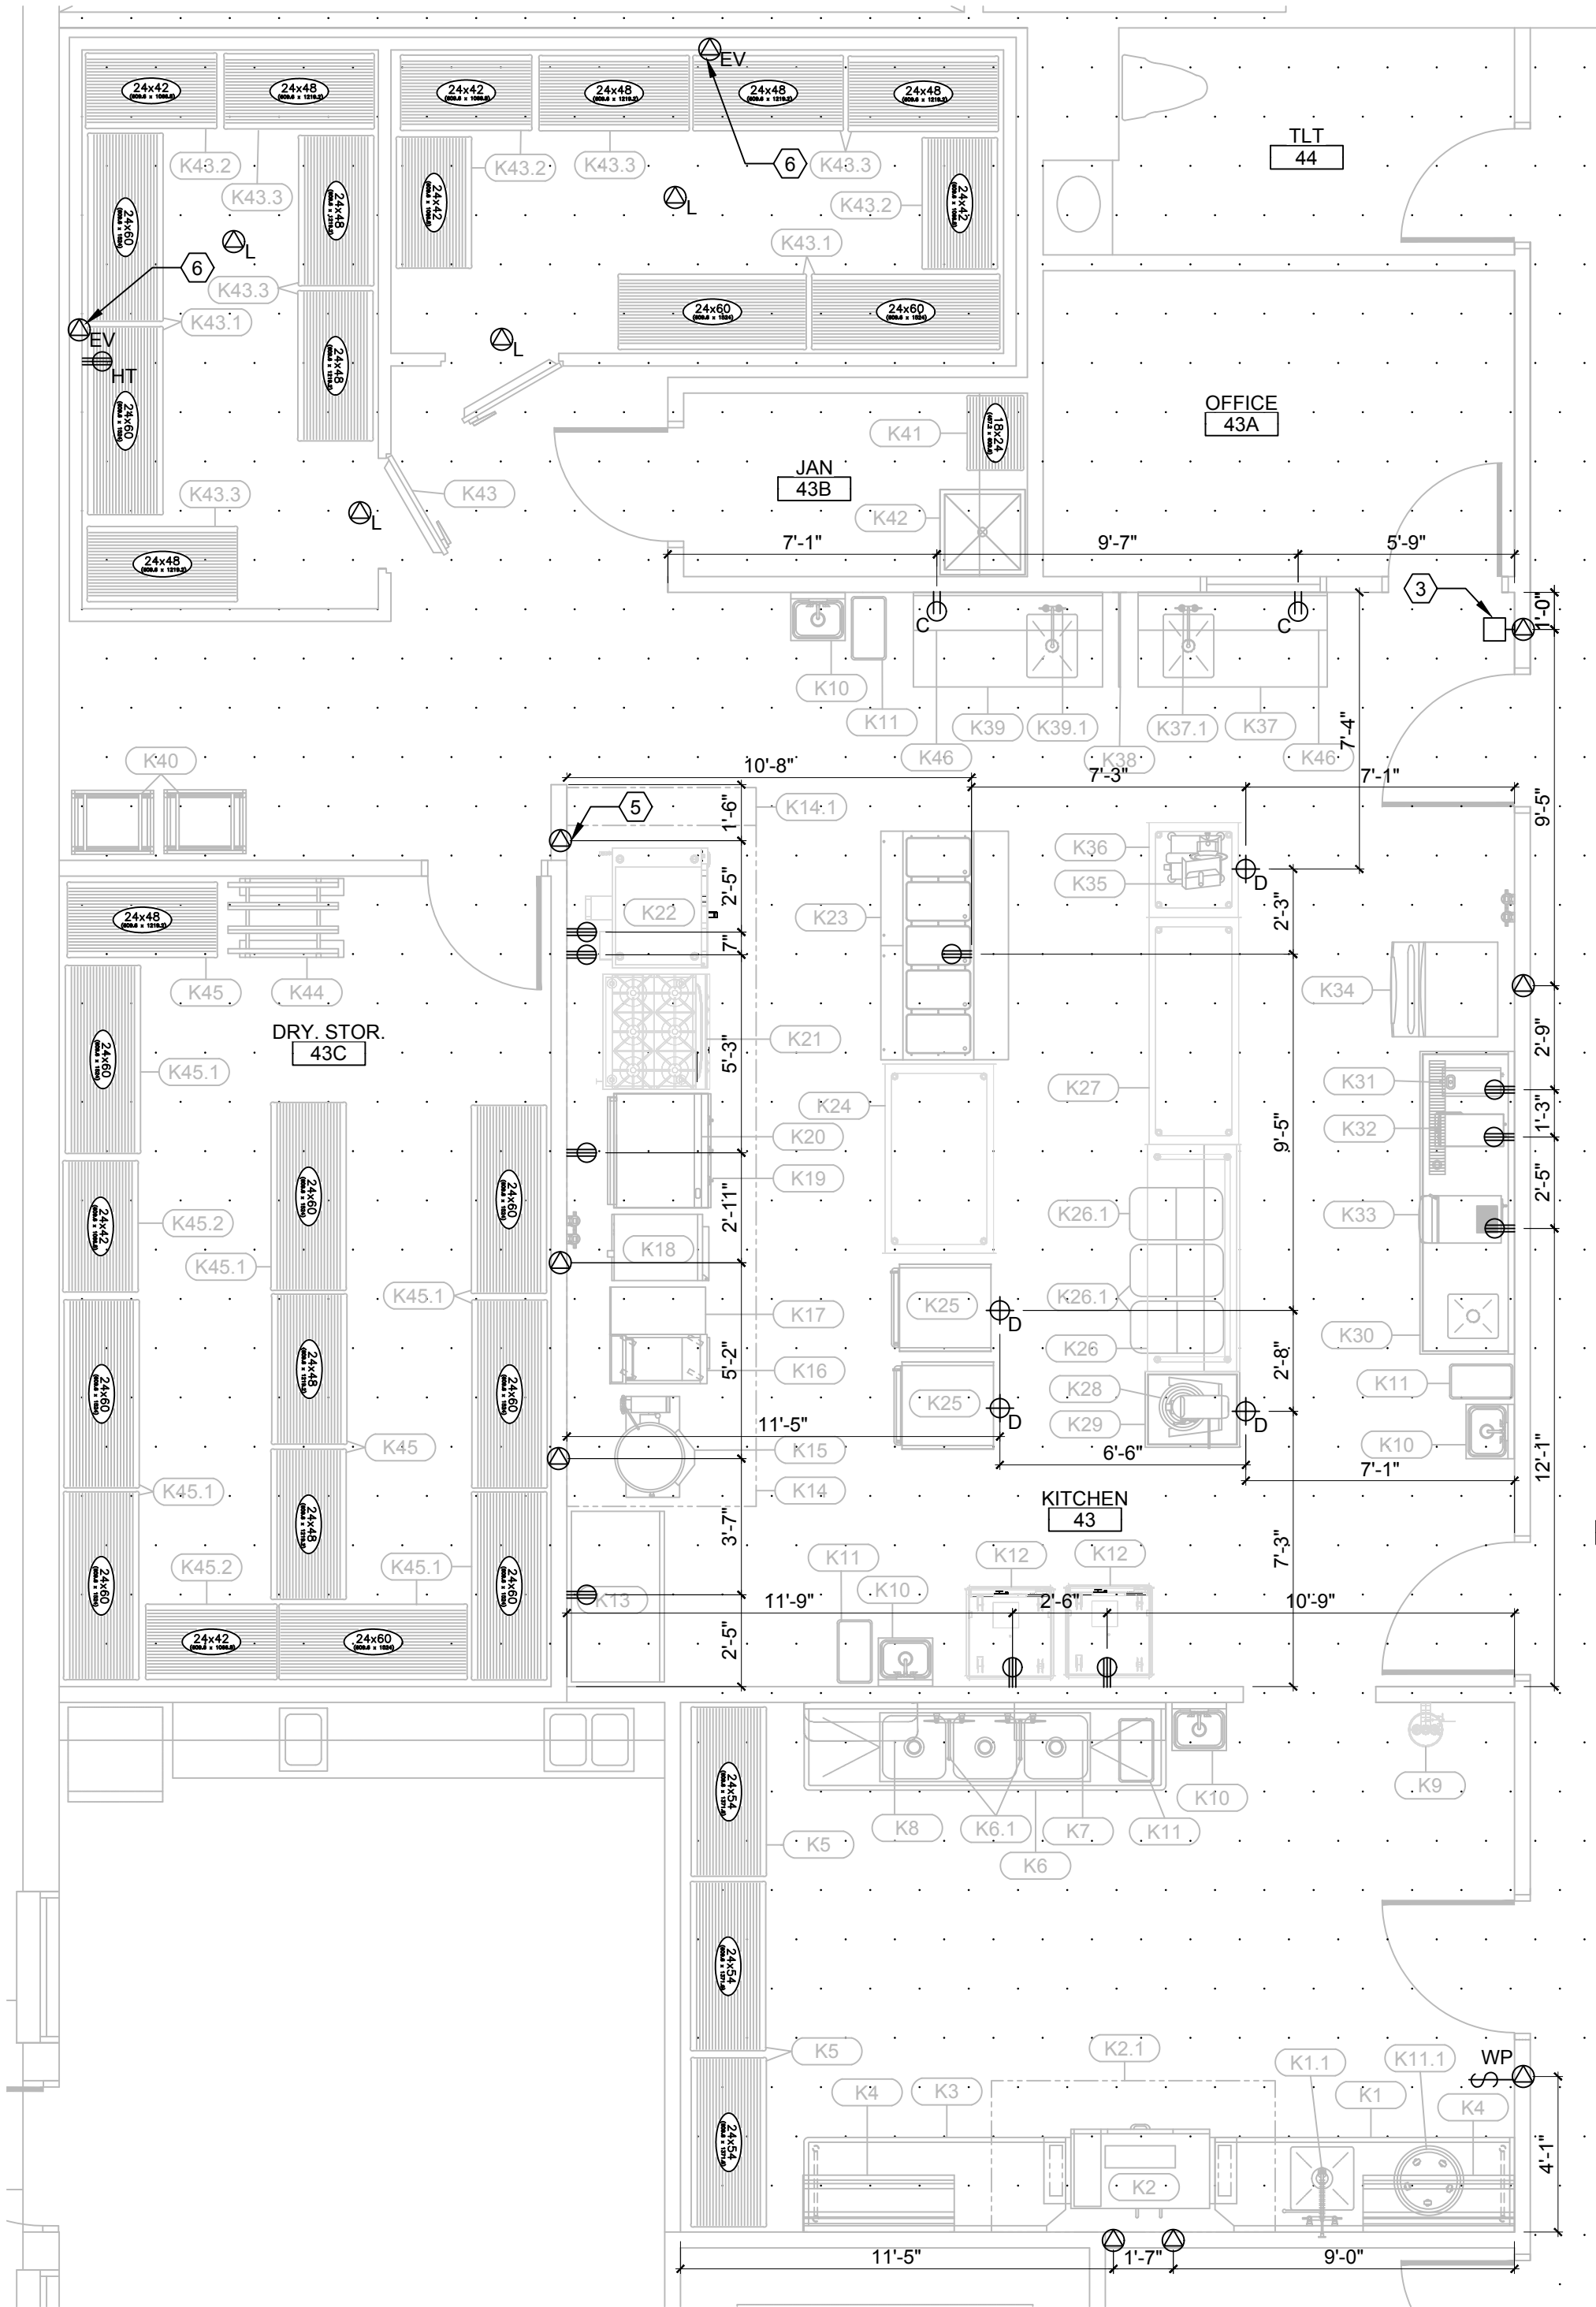

PLAN TRUE
1
MAIN KITCHEN ELECTRICAL PLAN
SCALE: 1/4" = 1'-0"

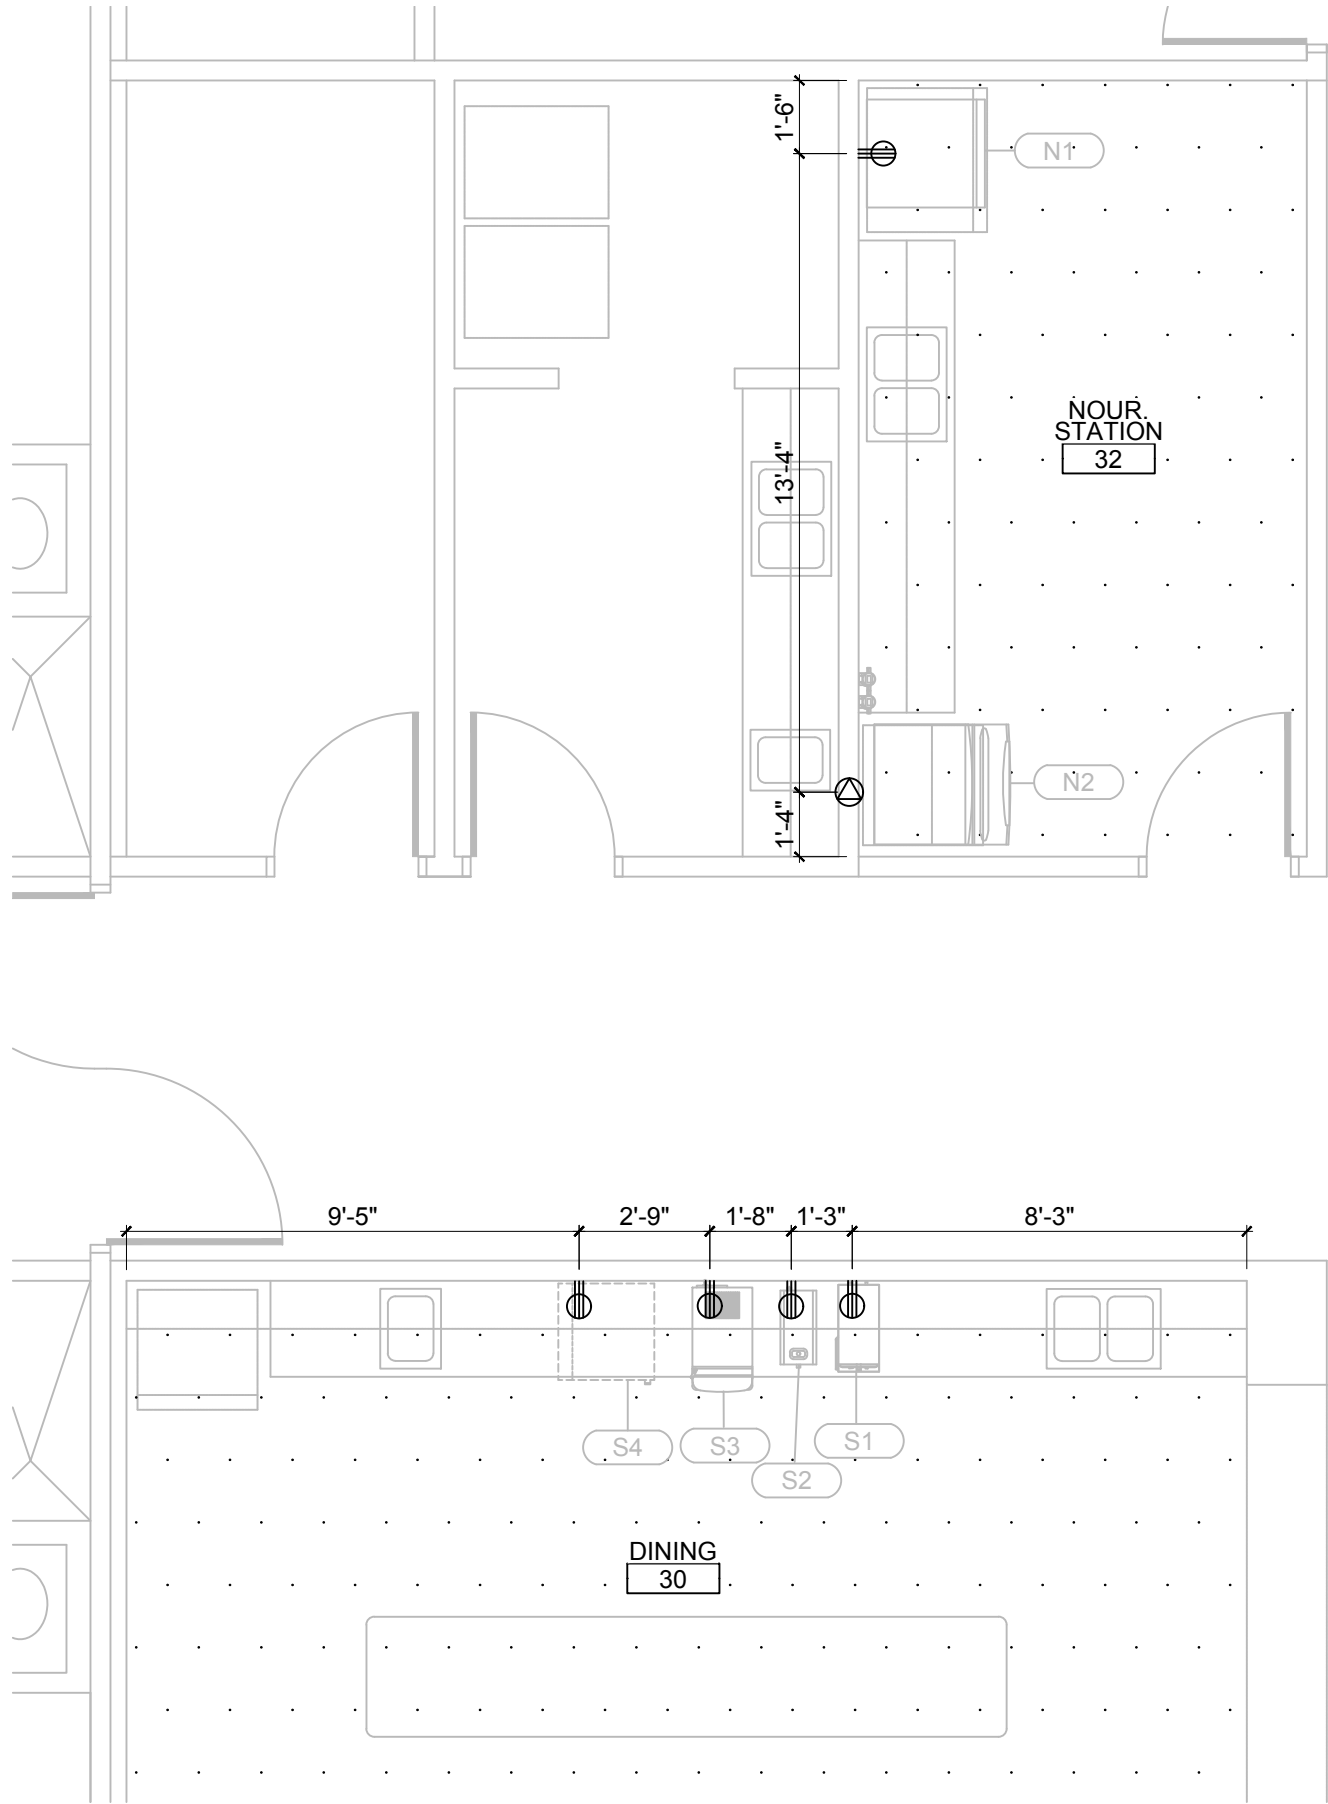

PLAN TRUE
2
NOURISH & DINING KITCHEN ELECTRICAL PLAN
SCALE: 1/4" = 1'-0"

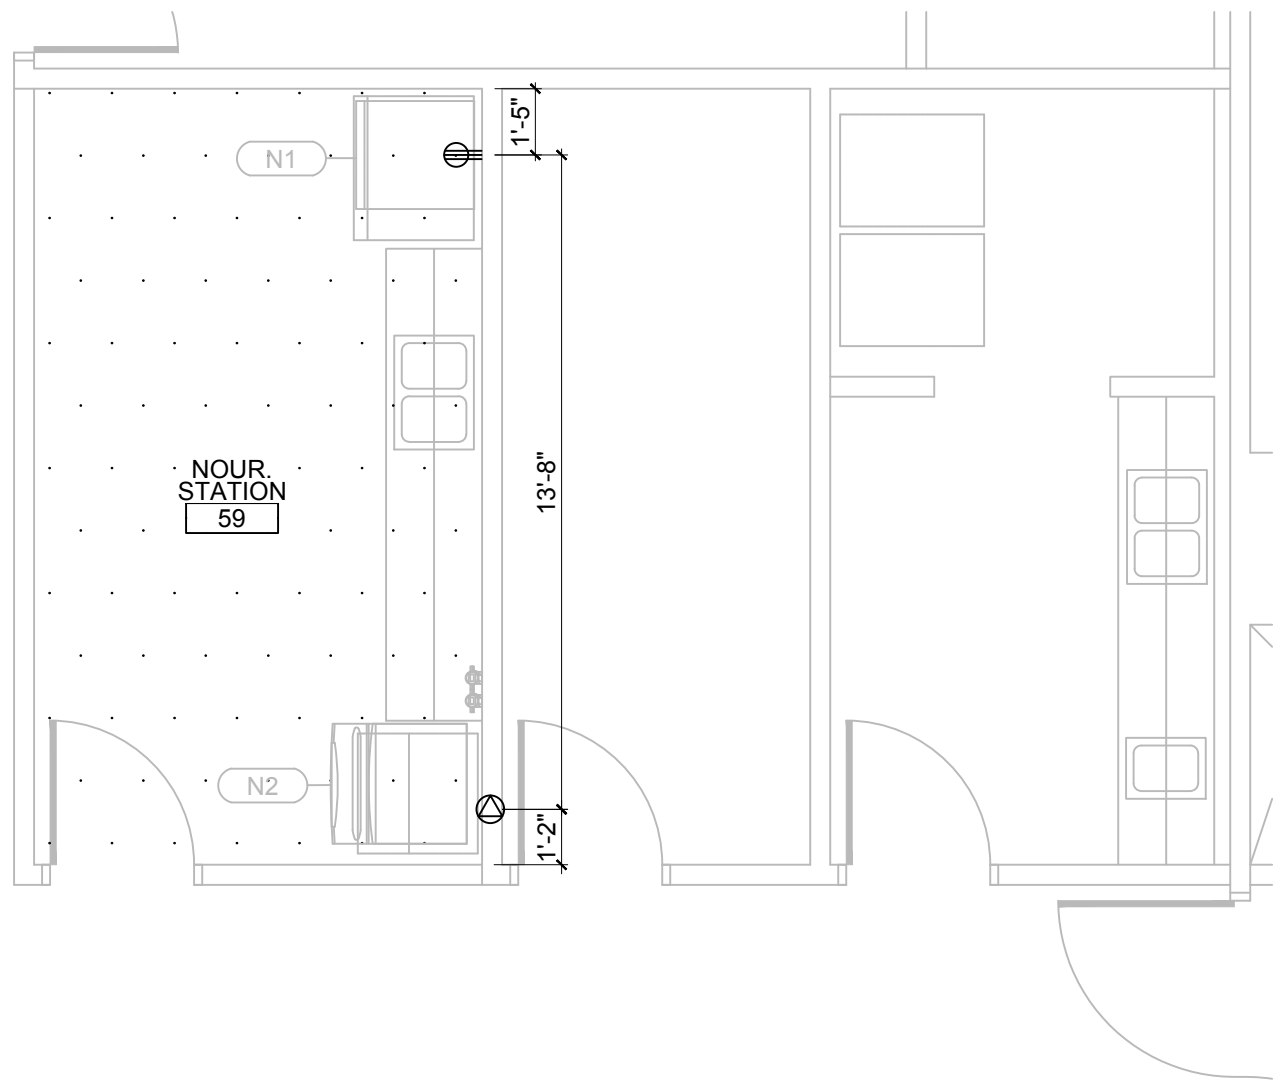


PLAN TRUE
3
NOURISH & DINING KITCHEN ELECTRICAL PLAN
SCALE: 1/4" = 1'-0"


SYMBOLS LEGEND	
SYMBOL	DEFINITION
ELECTRICAL	
	RECEPTACLE
	RECEPTACLE - CONVENIENCE
	RECEPTACLE - DEDICATED
	RECEPTACLE - HEAT TAPE
	RECEPTACLE - DROP FROM CEILING
	RECEPTACLE - FLOOR MOUNTED
	DIRECT CONNECT
	DIRECT CONNECT - LOAD CENTER
	DIRECT CONNECT - EVAPORATOR
	DIRECT CONNECT - EXHAUST FAN
	DIRECT CONNECT - LIGHTS
	SWITCH - EXHAUST FAN
	SWITCH - KEY OPERATED
	SWITCH - WEATHER RESISTANT
	FIRE/ALARM MANUAL PULL STATION
PLUMBING	
	HOT/COLD WATER CONNECTION
	DIRECT WASTE
	HUB DRAIN
	FLOOR SINK
	FLOOR DRAIN
	FLOOR DRAIN - DEDICATED
	GAS CONNECTION
BUILDING WORKS	
	WALL BLOCKING
	FLOOR DEPRESSION
ABBREVIATIONS	
AFF	ABOVE FINISH FLOOR
ACH	ABOVE COUNTER HEIGHT
FV	FIELD VERIFY
HW/CW	HOT/COLD WATER
FOH	FRONT OF HOUSE
BOH	BACK OF HOUSE
FSEC	FOODSERVICE EQUIPMENT CONTRACTOR
GC	GENERAL CONTRACTOR
EC	ELECTRICAL CONTRACTOR
PC	PLUMBING CONTRACTOR

- GENERAL ELECTRICAL NOTES**
- ELECTRICAL AND GROUNDING CONNECTIONS MUST COMPLY WITH THE APPLICABLE PORTIONS OF THE NATIONAL ELECTRICAL CODE AND/OR OTHER LOCAL ELECTRICAL CODES.
 - REFER TO MANUFACTURER'S EQUIPMENT CUTSHEETS.
 - REFER TO MEP SCHEDULE FOR HEIGHT OF ROUGH-IN LOCATIONS. HEIGHTS LISTED ARE TO THE CENTER LINE OF THE ROUGH-IN ABOVE FINISH FLOOR.
 - UNLESS OTHERWISE NOTED, ELECTRICAL CONTRACTOR TO PROVIDE AND INSTALL DUPLEX CONVENIENCE RECEPTACLES, TO BE MOUNTED AT 50" AFF TO CENTER OF BOX IN BACK OF HOUSE LOCATIONS AS SHOWN ON ELECTRICAL PLAN. MOUNT DUPLEX CONVENIENCE RECEPTACLES AT 46" AFF TO CENTER OF BOX FOR FRONT OF HOUSE LOCATIONS AS SHOWN ON ELECTRICAL PLAN.
 - ELECTRICAL CONTRACTOR TO INSTALL AND CONNECT LIGHT FIXTURES SUPPLIED WITH WALK-IN BY FSEC.
 - FOODSERVICE EQUIPMENT CONTRACTOR (FSEC) SHALL COORDINATE ROUGH-IN REQUIREMENTS WITH EC. ALL ROUGH-IN LOCATIONS SHALL BE FIELD VERIFIED BY FSEC PRIOR TO DRYWALL INSTALLATION TO ASSURE CORRECT PLACEMENTS.
 - ELECTRICAL CONTRACTOR TO CONNECT DRAIN WATER TEMPERING KIT TO DISHWASHER WHEN FIELD MOUNTING IS REQUIRED.
 - GC TO VERIFY ELECTRICAL REQUIREMENTS FOR OWNER SUPPLIED EQUIPMENT WITH OWNER/OPERATOR.
 - ALL CONDUIT TO BE CONCEALED IN WALLS UNTIL POINT OF CONNECTION.
 - FOR HOODS AND WALK-INS REFER TO EQUIPMENT CUTSHEET BOOK.
 - FINAL ELECTRICAL CONNECTIONS, INCLUDING THE DEFROST TIMER, AS APPLICABLE, AND NECESSARY DISCONNECT(S) TO BE PERFORMED IN THE FIELD BY THE ELECTRICAL CONTRACTOR.
 - ATTACHMENT OF THE CONDENSING UNITS TO THE STRUCTURE AND ANY NECESSARY CURBS AND ROOF WORK TO BY PERFORMED IN THE FIELD BY THE GC OR OTHER APPROPRIATE TRADE.

- KEYED ELECTRICAL NOTES**
- ELECTRICAL CONTRACTOR TO PROVIDE ELECTRICAL KEYED LOCK-OUT SWITCH AS INDICATED ON PLAN FOR ALL EQUIPMENT EXCEPT REFRIGERATION, ICE AND BEVERAGE MACHINES. KEY TO BE REMOVABLE IN OFF POSITION ONLY.
 - ELECTRICAL CONTRACTOR TO PROVIDE WEATHER-RESISTANT SWITCHES TO CONTROL ROOFTOP FAN AND LIGHTS, IF APPLICABLE, FOR CONDENSATE HOOD MOUNTED AT 42" - 48" AFF OR IN ACCORDANCE WITH LOCAL CODES.
 - ELECTRICAL CONTRACTOR TO ROUGH-IN STANDARD SINGLE GANG BOX WITH CONDUIT RACEWAY FROM TANK ACTIVATION SWITCH TO UTILITY CABINET. STUB OUT ABOVE CEILING. REFER TO EQUIPMENT CUTSHEET BOOK FOR ANSUL PULL STATION DETAIL.
 - ELECTRICAL CONTRACTOR TO ROUGH-IN DOUBLE GANG BOX FOR EXHAUST HOOD ROOFTOP FAN CONTROLS WITH CONDUIT RACEWAY BETWEEN CONTROLS AND ELECTRICAL BOX AT FAN LOCATION. CAT5 CABLE SHIPS WITH HOOD AND ACCESSORIES. REFER TO EQUIPMENT CUTSHEET BOOK FOR DETAILS. HOOD CONTROLS SHALL BE MOUNTED AT A HEIGHT OF 42" - 48" AFF OR IN ACCORDANCE WITH LOCAL CODES. HOOD LIGHT BULBS NOT INCLUDED WITH HOOD PACKAGE BY OTHER.
 - PROVIDE POWER AT GAS SHUTOFF VALVE
 - PROVIDE POWER AT WALK-IN CONDENSER LOCATION. REFER TO EQUIPMENT CUTSHEET BOOK FOR DETAILS.

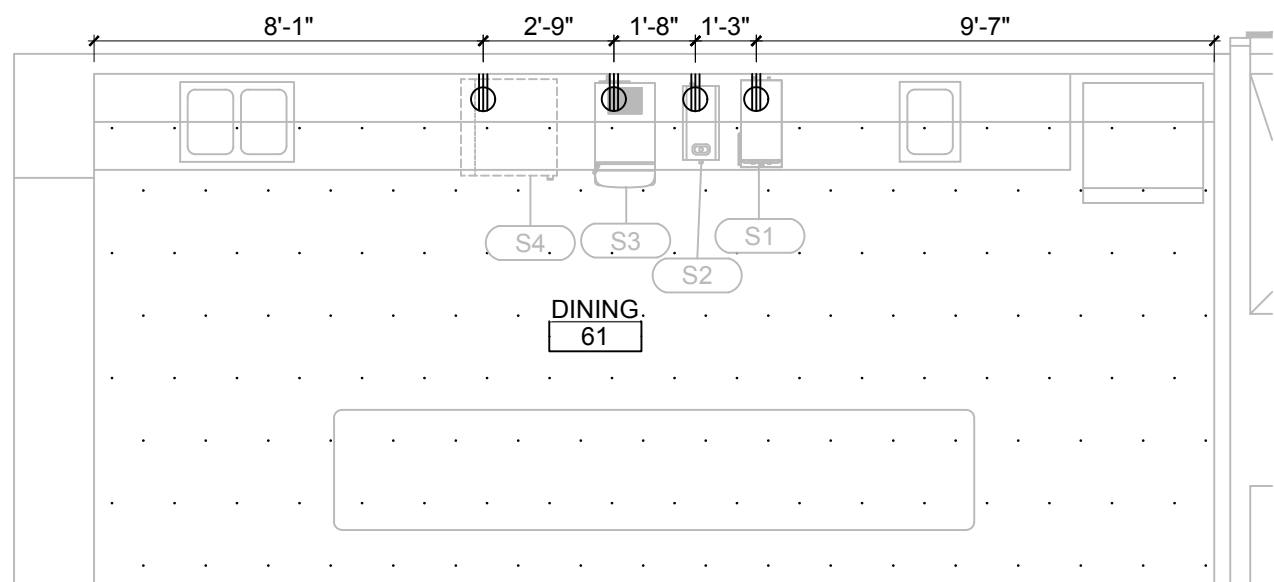

PLAN TRUE
3
NOURISH & DINING KITCHEN ELECTRICAL PLAN
SCALE: 1/4" = 1'-0"

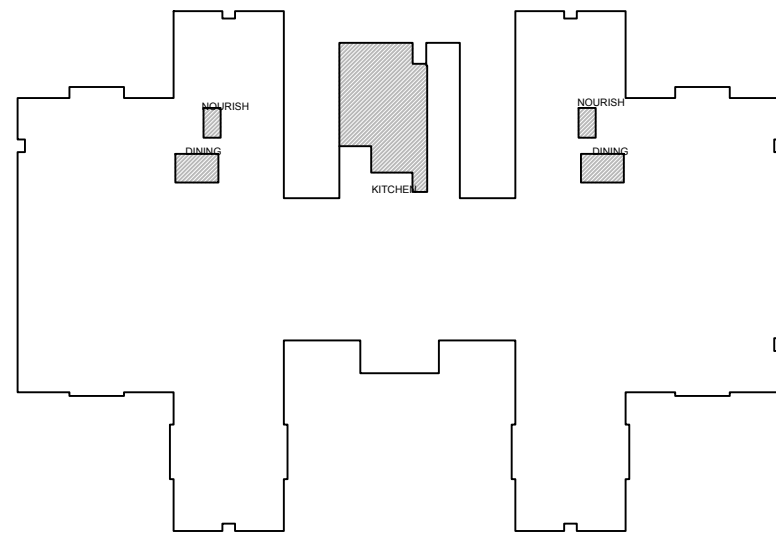

PLAN TRUE
KEY PLAN
SCALE: NTS


REVISIONS

△	
△	
△	
△	
△	
△	

PROJECT STATUS:	CD
DATE ISSUED:	11/14/2025
DRAWN BY:	ME
CHECKED BY:	AM
PROJECT#	10388875


ALL INFORMATION CONTAINED IN THIS DRAWING IS TO BE USED FOR INFORMATIONAL PURPOSES ONLY. THE DRAWING IS NOT TO BE USED FOR CONSTRUCTION. THE USER OF THIS DRAWING SHALL BE RESPONSIBLE FOR OBTAINING ALL NECESSARY PERMITS AND FOR THE PROPER INSTALLATION OF ANY EQUIPMENT OR MATERIALS SHOWN ON THIS DRAWING. THE USER SHALL BE RESPONSIBLE FOR THE PROPER INSTALLATION OF ANY EQUIPMENT OR MATERIALS SHOWN ON THIS DRAWING.

FOR SPINELLY SPRINGS DESIGN & CONSTRUCTION, INC. 11/17/25 9:10 AM PRINTED BY: MATTEL


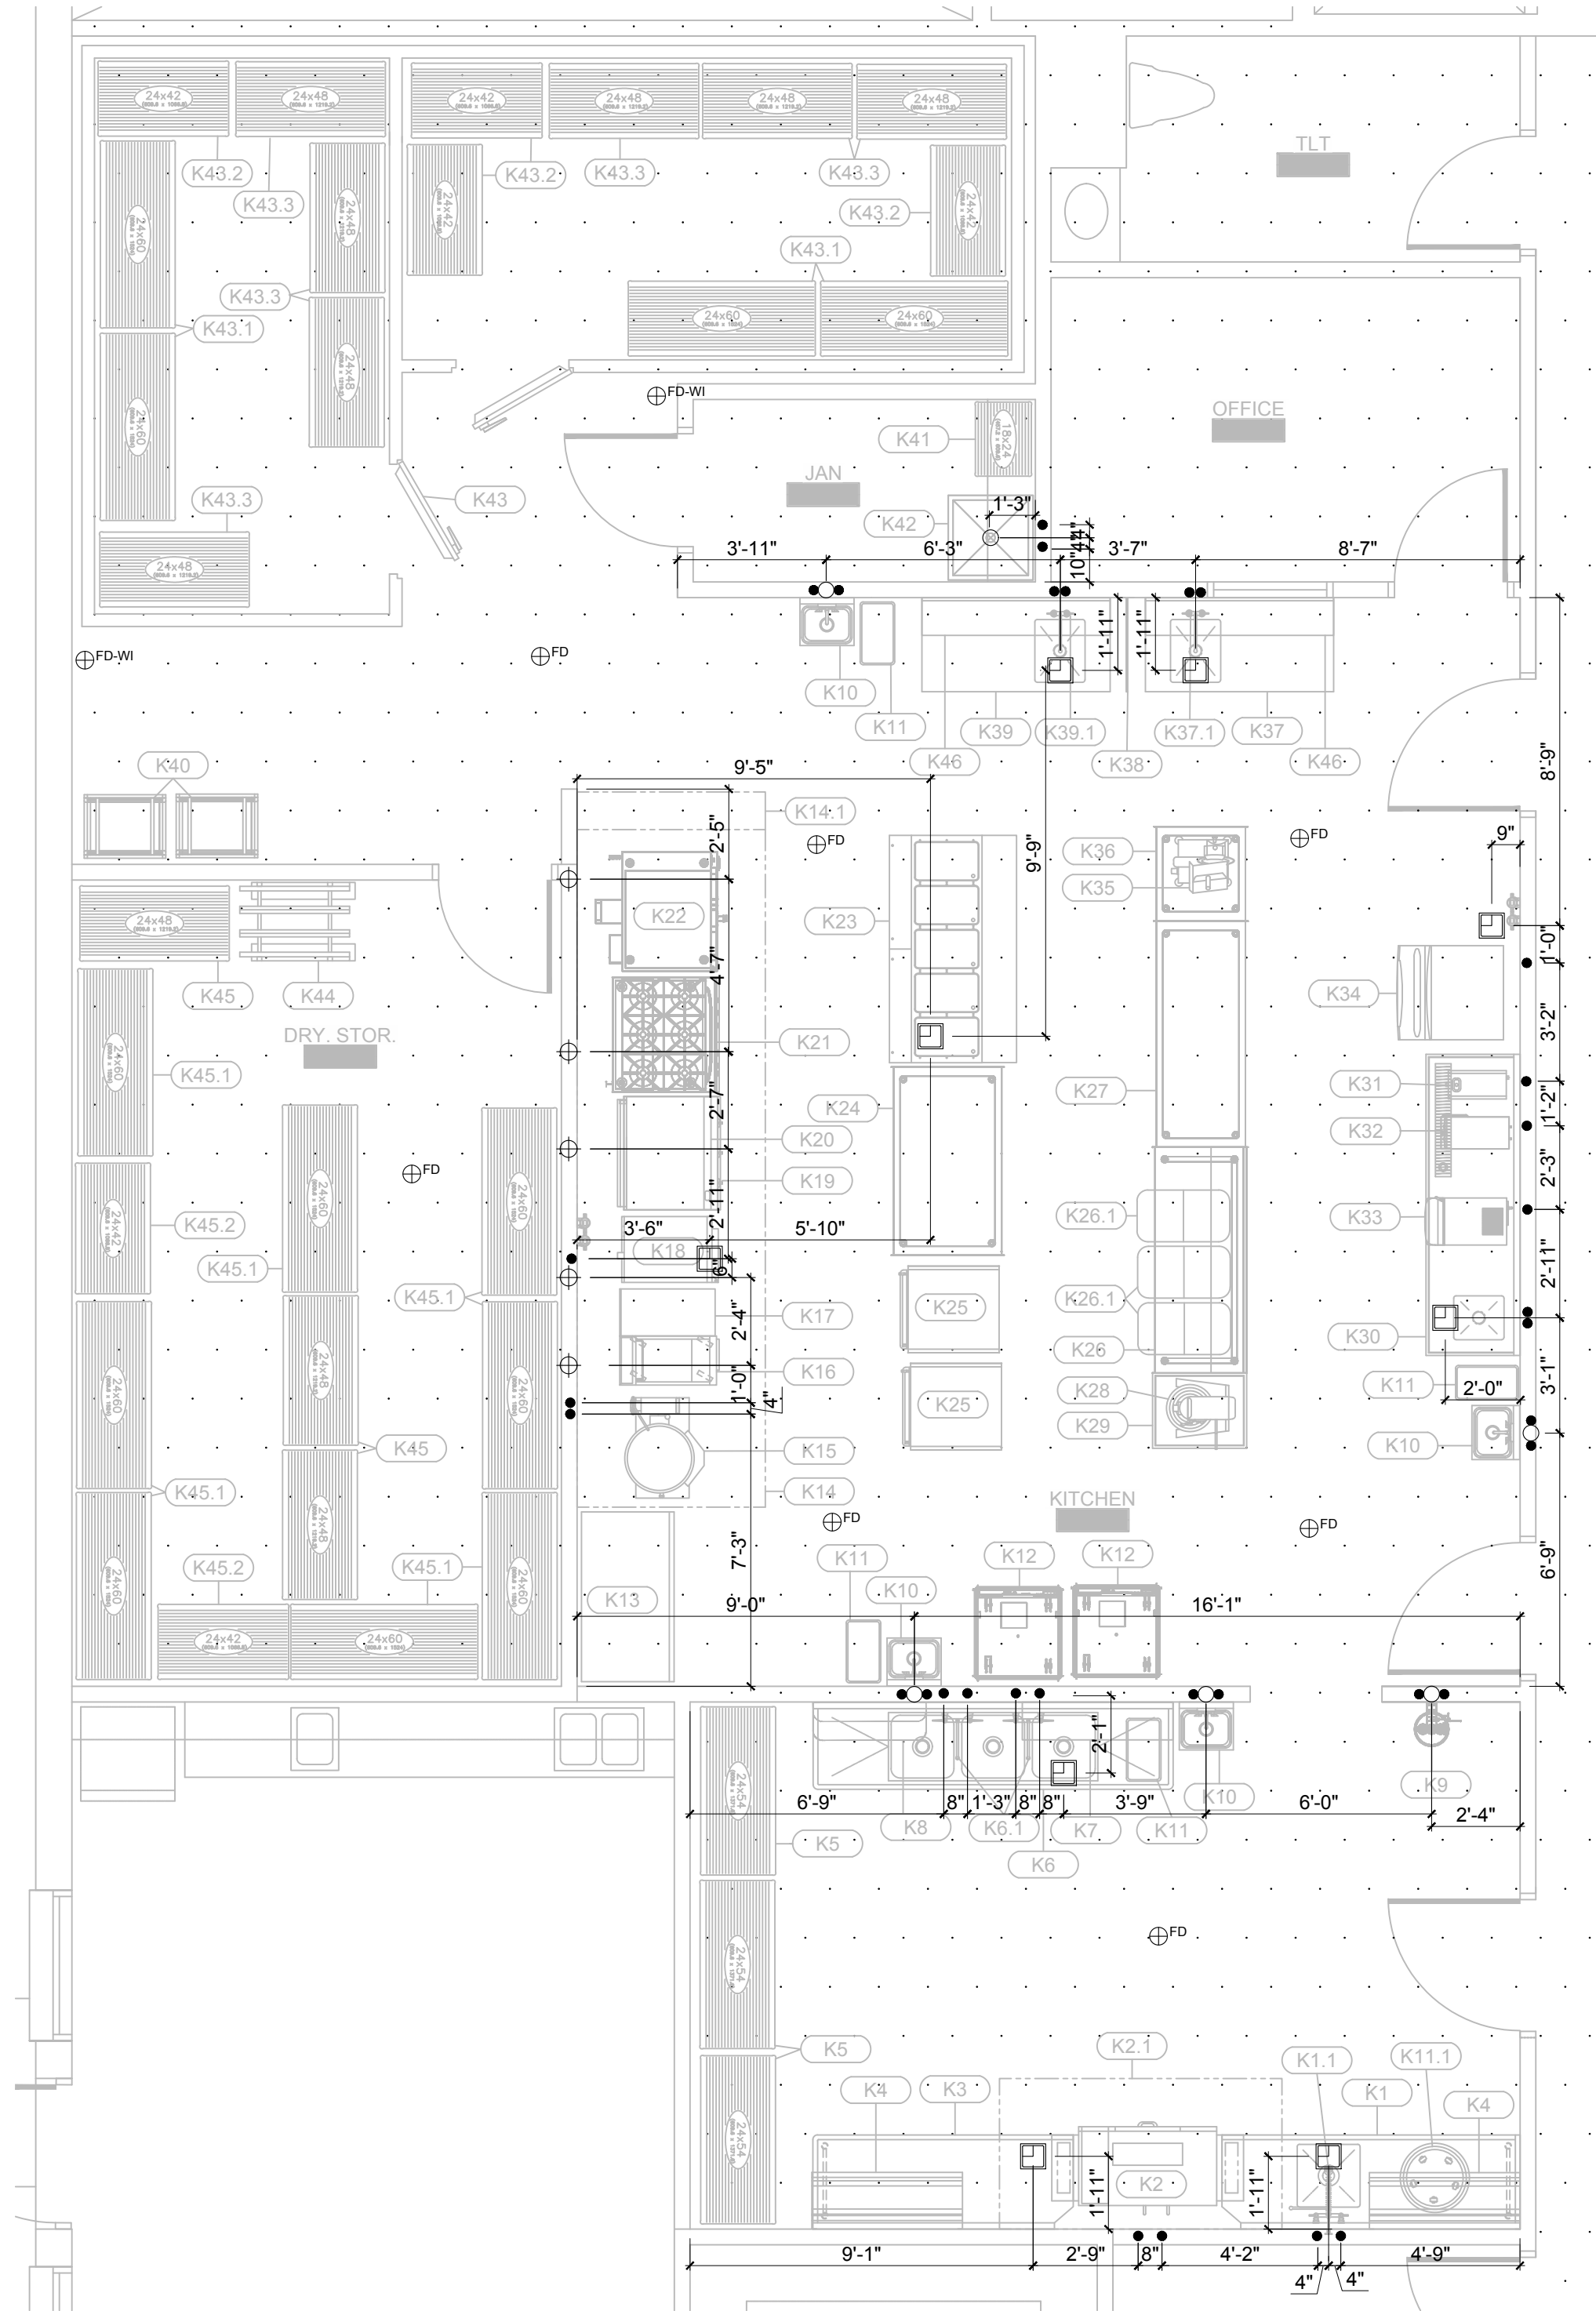


PLAN TRUE
1
SCALE: 1/4" = 1'-0"



NOTE:
• TYPICAL PLUMBING FIXTURE MOUNTING HEIGHTS

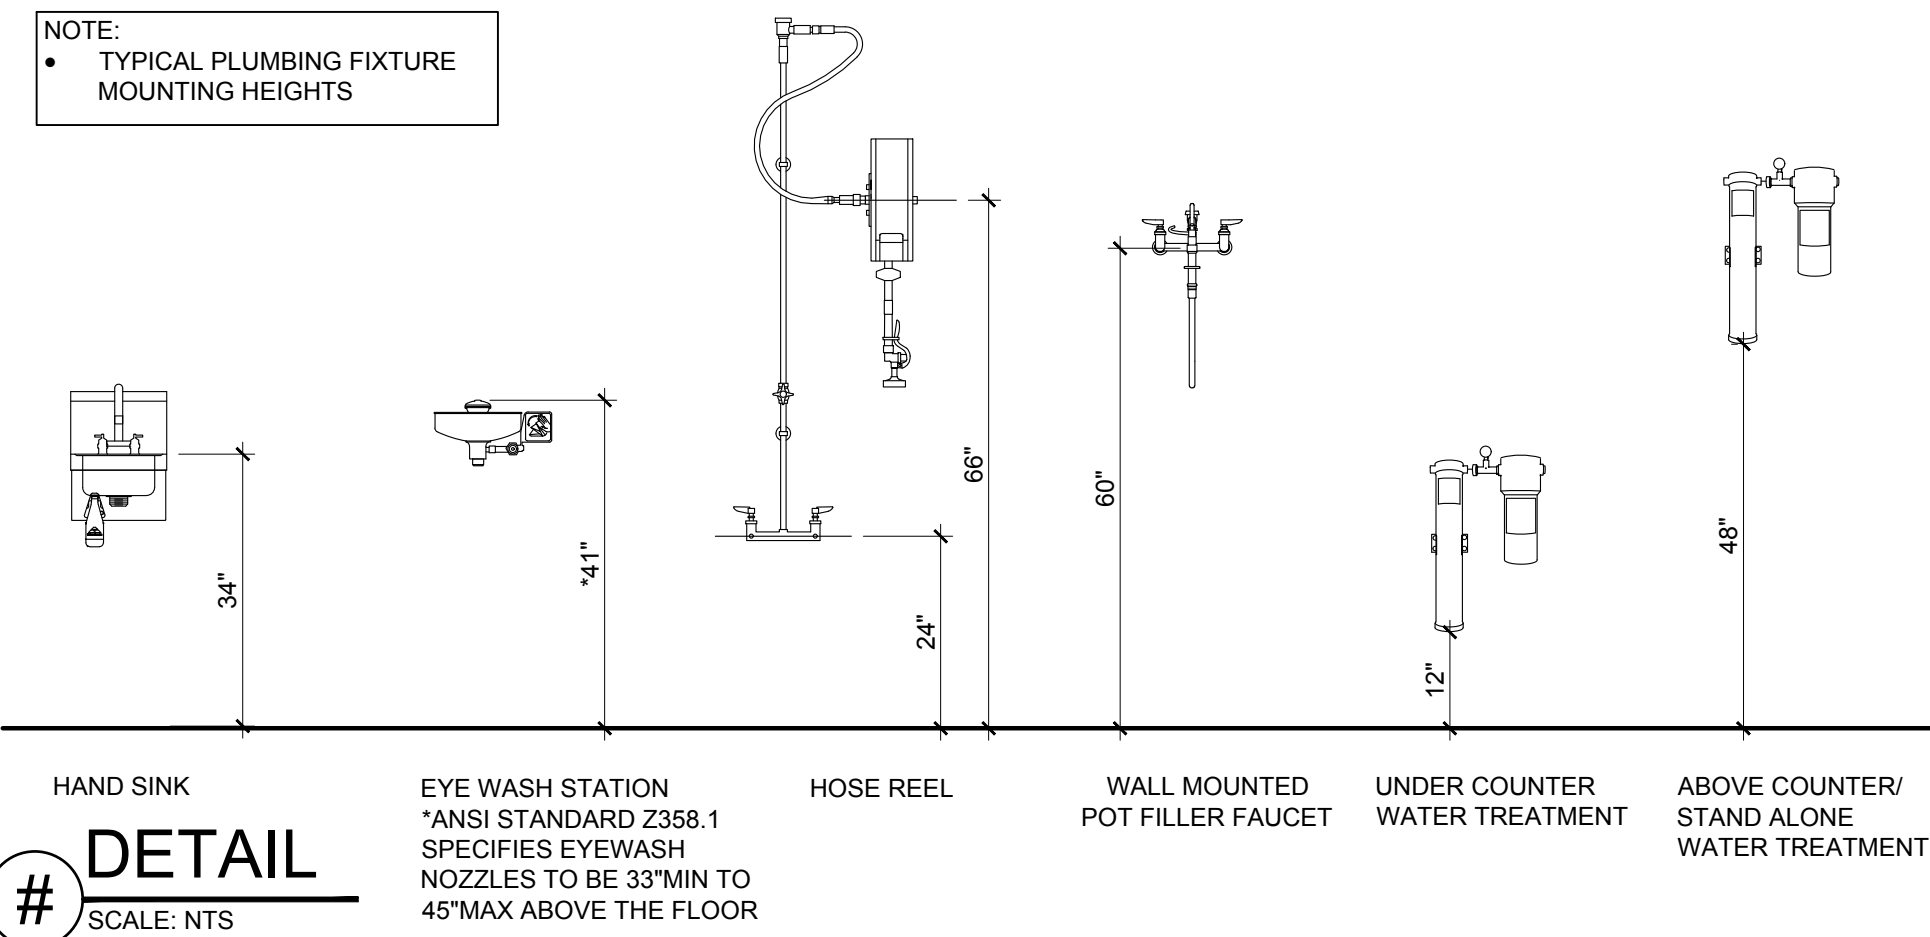

SCALE: NTS

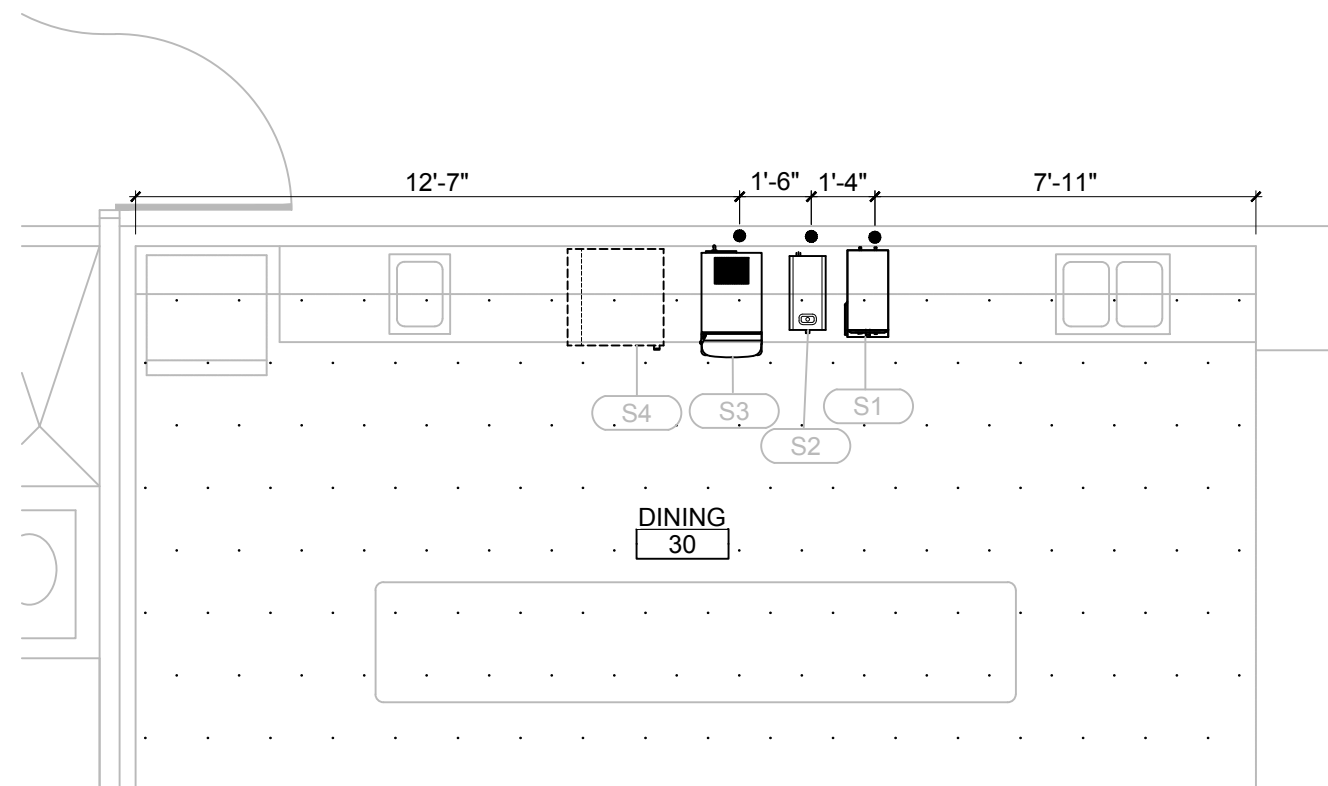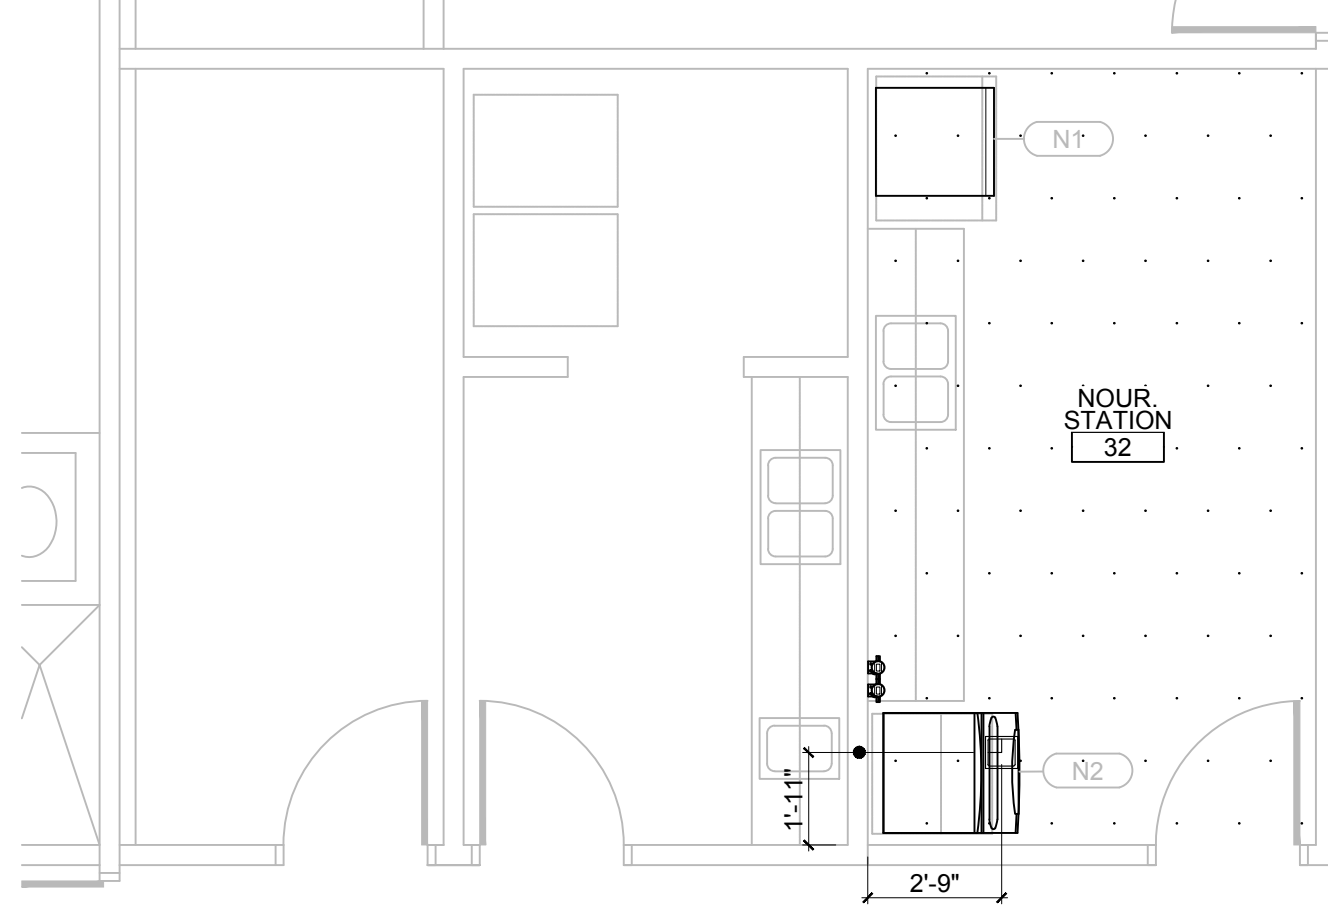


PLAN TRUE
2
SCALE: 1/4" = 1'-0"

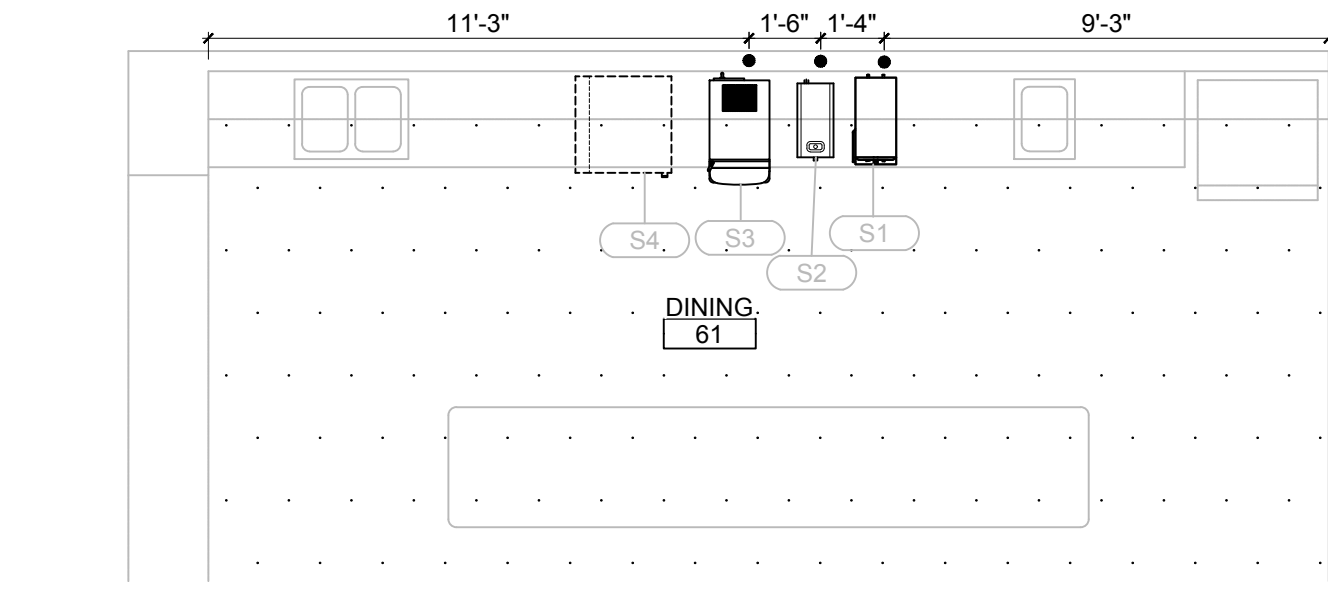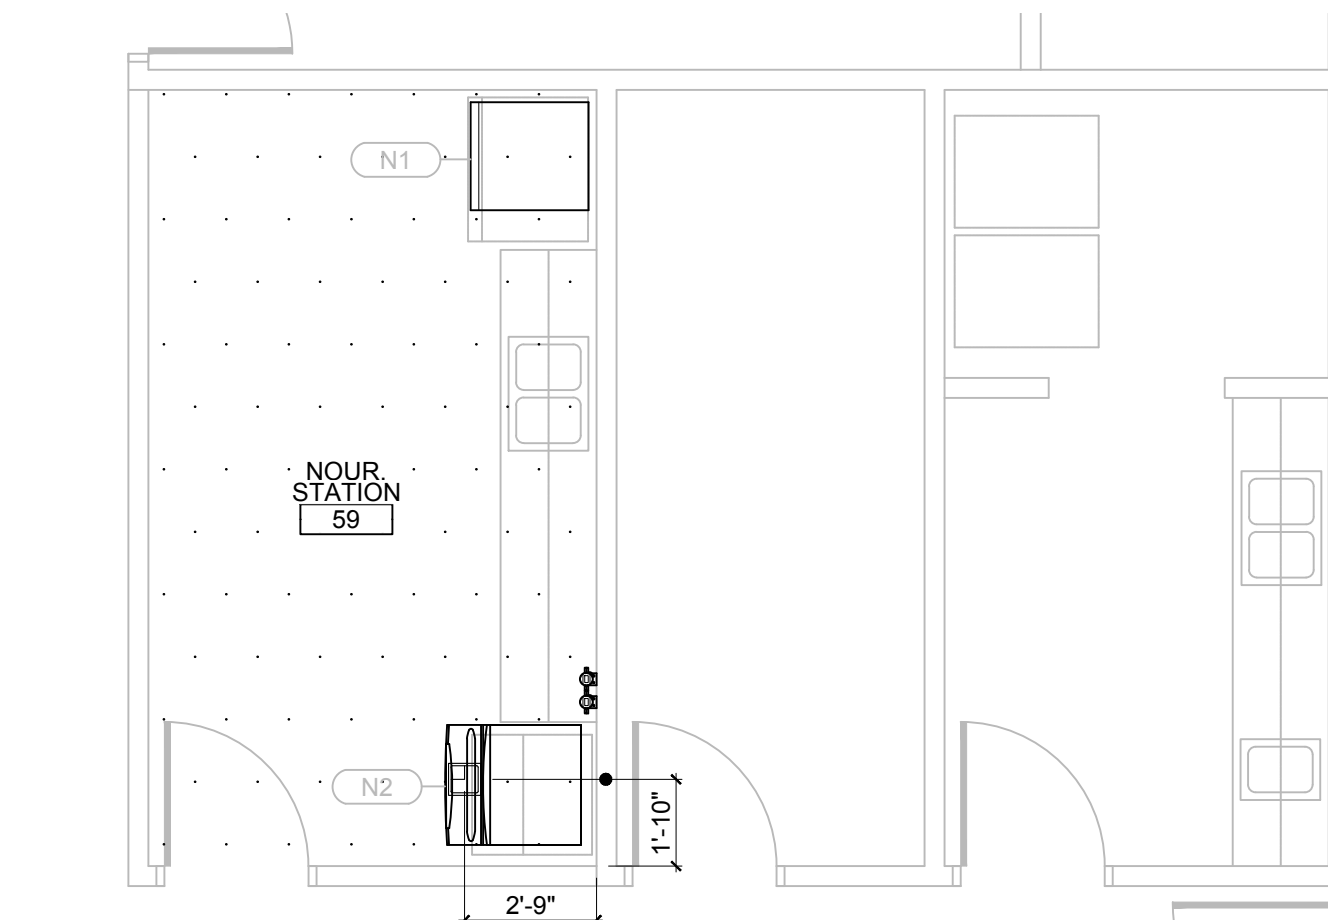

PLAN TRUE
3
SCALE: 1/4" = 1'-0"

SYMBOLS LEGEND	
SYMBOL	DEFINITION
ELECTRICAL	
⊖	RECEPTACLE
⊖C	RECEPTACLE - CONVENIENCE
⊖D	RECEPTACLE - DEDICATED
⊖HT	RECEPTACLE - HEAT TAPE
⊖D	RECEPTACLE - DROP FROM CEILING
⊖F	RECEPTACLE - FLOOR MOUNTED
⊖	DIRECT CONNECT
⊖C	DIRECT CONNECT - LOAD CENTER
⊖EV	DIRECT CONNECT - EVAPORATOR
⊖F	DIRECT CONNECT - EXHAUST FAN
⊖	DIRECT CONNECT - LIGHTS
⊖F	SWITCH - EXHAUST FAN
⊖K	SWITCH - KEY OPERATED
⊖W	SWITCH - WEATHER RESISTANT
⊖	FIRE/ALARM MANUAL PULL STATION
PLUMBING	
•	HOT/COLD WATER CONNECTION
○	DIRECT WASTE
⊖	HUB DRAIN
⊖	FLOOR SINK
⊖FD	FLOOR DRAIN
⊖FD-W	FLOOR DRAIN - DEDICATED
⊖	GAS CONNECTION
BUILDING WORKS	
■	WALL BLOCKING
▨	FLOOR DEPRESSION
ABBREVIATIONS	
AFF	ABOVE FINISH FLOOR
ACH	ABOVE COUNTER HEIGHT
FV	FIELD VERIFY
HW/CW	HOT/COLD WATER
FOH	FRONT OF HOUSE
BOH	BACK OF HOUSE
FSEC	FOODSERVICE EQUIPMENT CONTRACTOR
GC	GENERAL CONTRACTOR
EC	ELECTRICAL CONTRACTOR
PC	PLUMBING CONTRACTOR

- GENERAL PLUMBING NOTES
- REFER TO MEP SCHEDULE FOR HEIGHT OF ROUGH-IN LOCATIONS.
 - PLUMBING CONNECTIONS MUST COMPLY WITH APPLICABLE SANITARY, SAFETY AND PLUMBING CODES.
 - DIMENSIONED LOCATIONS LISTED ON ROUGH-IN SCHEDULE ARE TO THE CENTER LINE OF THE ROUGH-IN.
 - FSEC SHALL COORDINATE ALL ROUGH-INS WITH APPROPRIATE TRADE TO ENSURE ALL ROUGH-IN LOCATIONS ARE CONCEALED IN THE WALLS AND STUBBED OUT IN THE LOCATIONS SHOWN ON THE DRAWINGS.
 - FOR ALL INDIRECT DRAIN LOCATIONS, PLUMBING CONTRACTOR (PC) TO EXTEND WASTE PIPING FROM DRAIN TO A POINT OVER FLUSH FLOOR SINK.
 - 8"x8"x6" FLOOR SINKS TO HAVE 3/4" GRATE FLUSH TO FLOOR. SEE PLAN FOR LOCATIONS. PC TO PROVIDE FLOOR SINKS.
 - MEP CONSULTANT TO LOCATE AND SIZE GREASE INTERCEPTOR. PC TO PROVIDE AND INSTALL GREASE INTERCEPTOR. COMPLY WITH LOCAL PLUMBING AND SANITARY CODES.
 - AT ALL VACUUM BREAKER LOCATIONS PC TO PROVIDE CODE COMPLIANT BACKFLOW DEVICE AS NEEDED. MEP CONSULTANT TO DETERMINE NECESSITY PER LOCAL CODES.
 - PIPES MUST BE HELD RIGID UNDER SINK BY CONNECTION FITTINGS, BRACE, ETC.
 - FOR HOODS AND WALK-INS REFER TO EQUIPMENT CUTSHEET BOOK.
 - CAST IRON PIPE IS RECOMMENDED AT ALL DISHWASHER, HOTWELL AND COMBI OVEN/STEAMER DRAIN LOCATIONS.
 - WHEN WATER TREATMENT SYSTEMS ARE USED, THE CHLORINE FILTER SHOULD BE LOCATED CLOSEST TO THE WATER SOURCE, FOLLOWED BY THE SCALE REMOVAL FILTER. FOR INSTALLATIONS UNDERCOUNTER OR INSIDE CABINETS, ALLOW 2" MINIMUM CLEARANCE BENEATH EQUIPMENT.
 - PC TO INSTALL DRAIN WATER TEMPERING KITS ON DISH MACHINES.

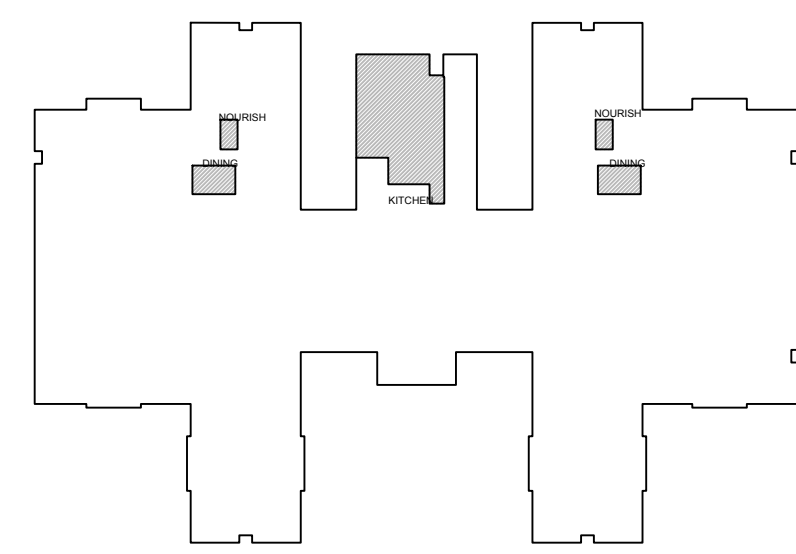


PLAN TRUE
KEY PLAN
SCALE: NTS


△	
△	
△	
△	
△	

PROJECT STATUS:	CD
DATE ISSUED:	11/14/2025
DRAWN BY:	ME
CHECKED BY:	AM
PROJECT#	10388875

ALL INFORMATION CONTAINED IN THIS DRAWING IS CONSIDERED TO BE THE PROPERTY OF DIRECT SUPPLY APTURA. NO USE OR REPRODUCTION THEREOF MAY BE MADE WITHOUT THE EXPRESS WRITTEN CONSENT OF DIRECT SUPPLY APTURA.
COMPUTER-GENERATED DRAWING. DESIGNED BY DWG 11-17-25 9:10 AM PRINTED BY MATTEL

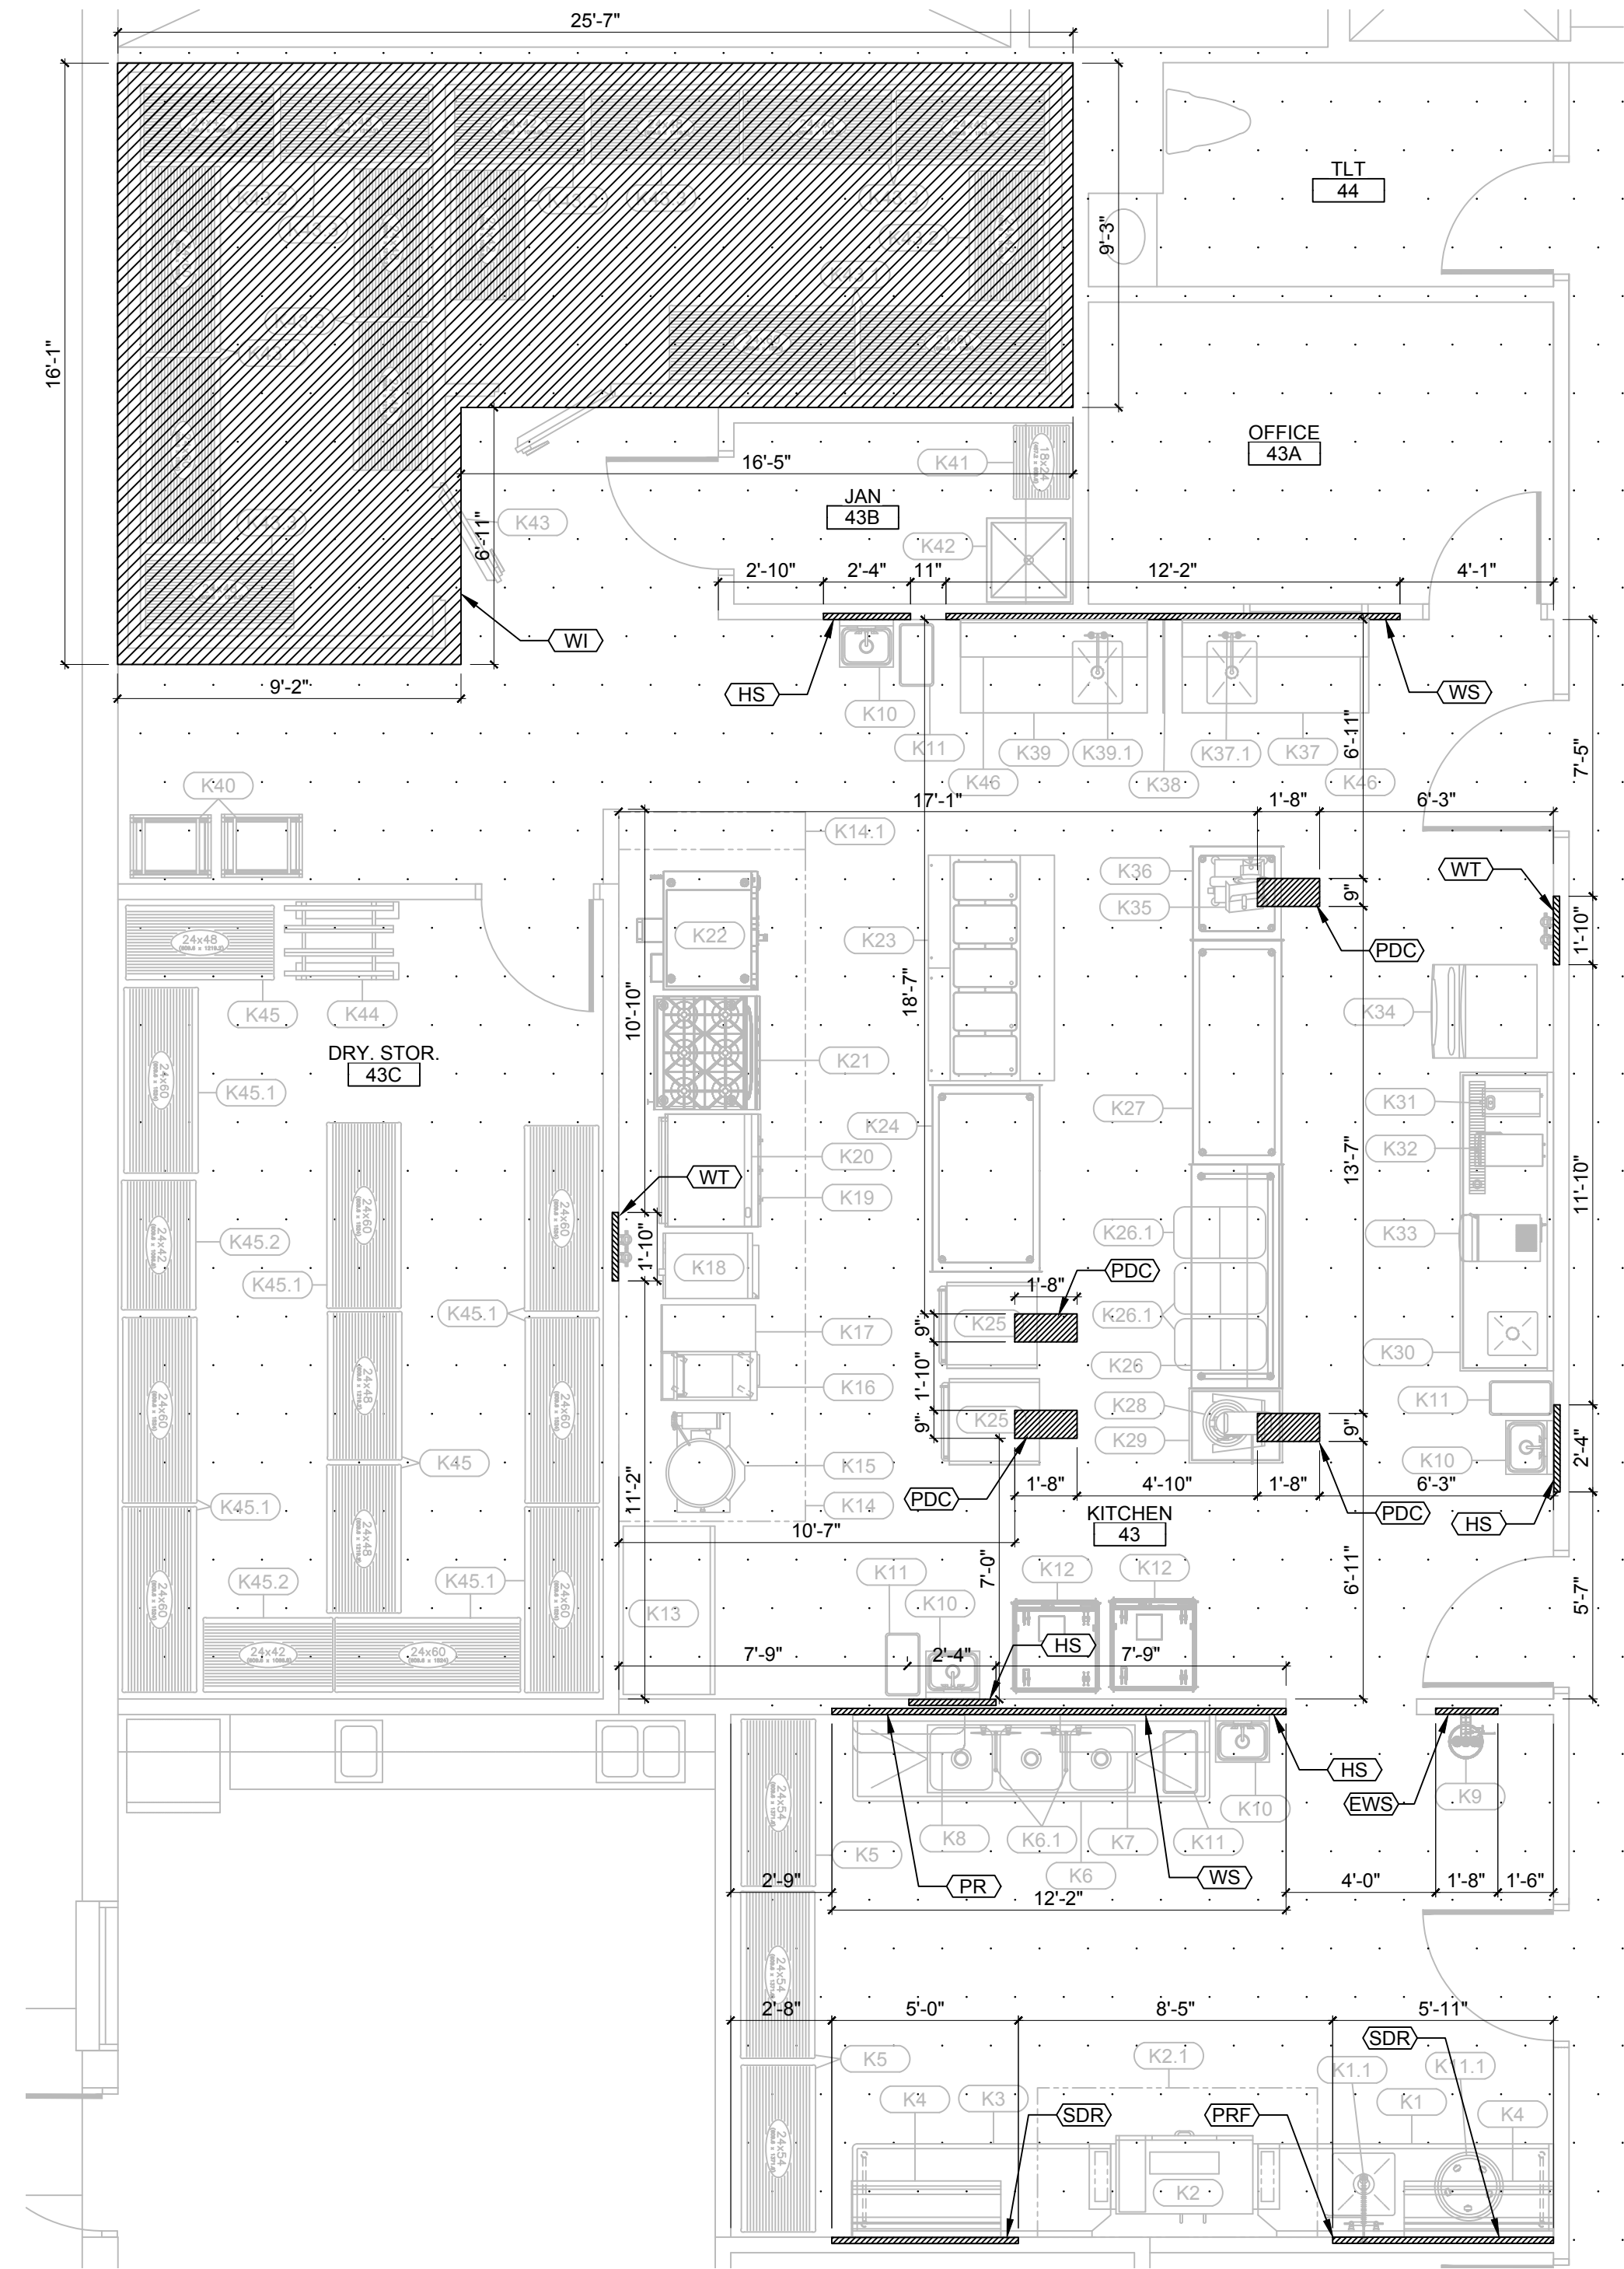




PLAN TRUE
1
SCALE: 1/4" = 1'-0"

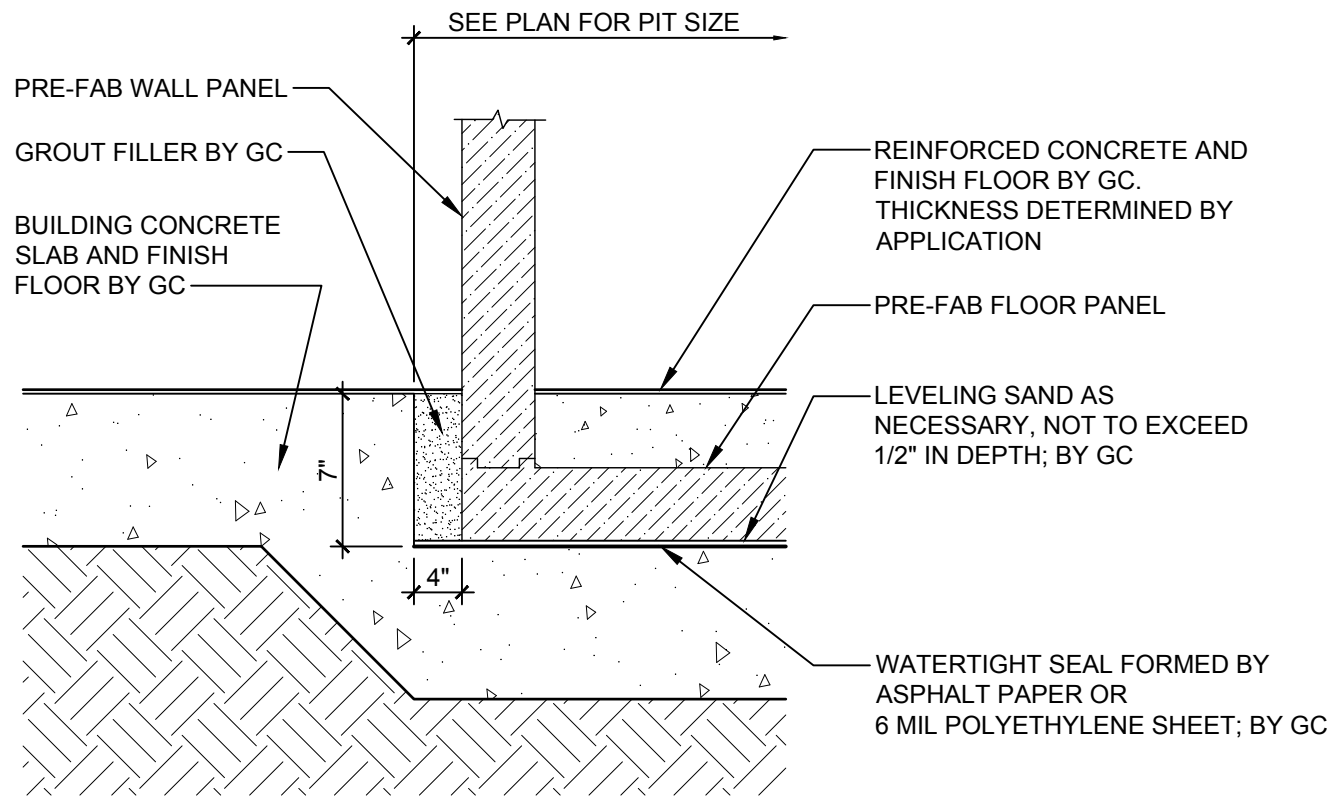

NOTE:
RECESSED WALK-IN WALL AND FLOOR PANEL DETAIL APPLIES TO BOTH WALK-IN COOLER AND WALK-IN FREEZER
4
SCALE: NTS

PLAN TRUE
2
SCALE: 1/4" = 1'-0"

PLAN TRUE
3
SCALE: 1/4" = 1'-0"

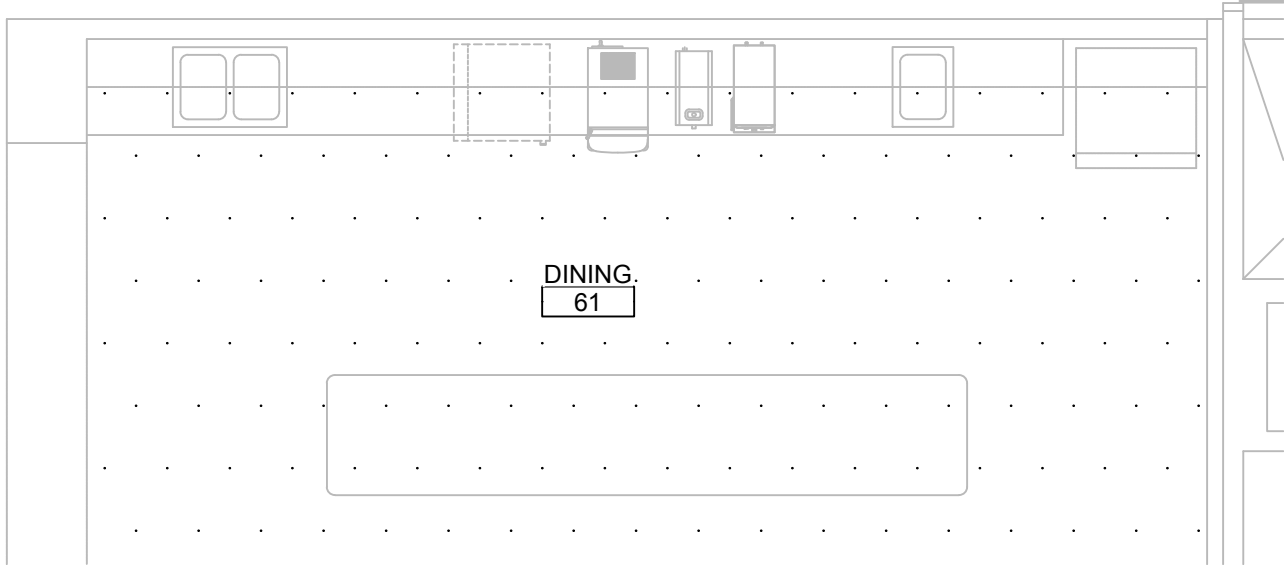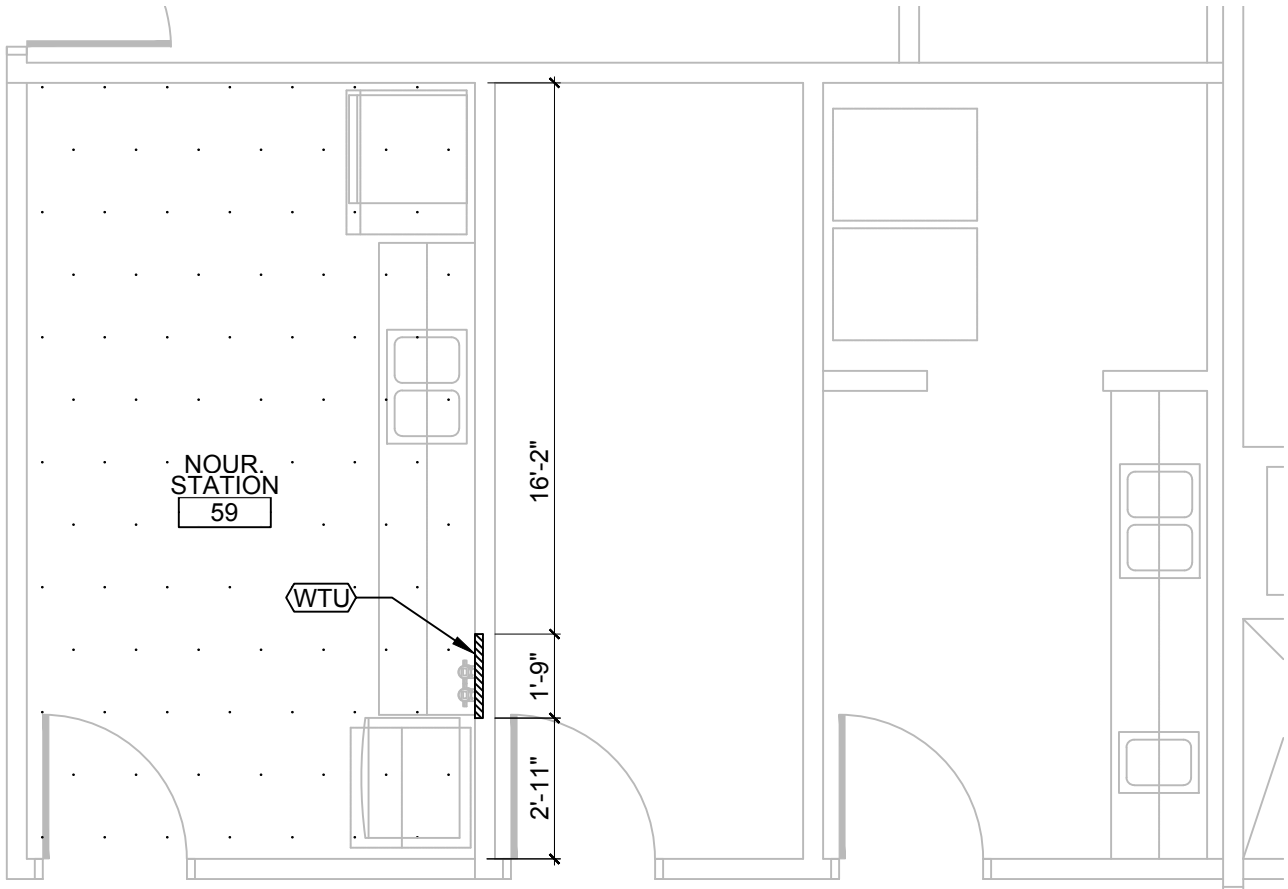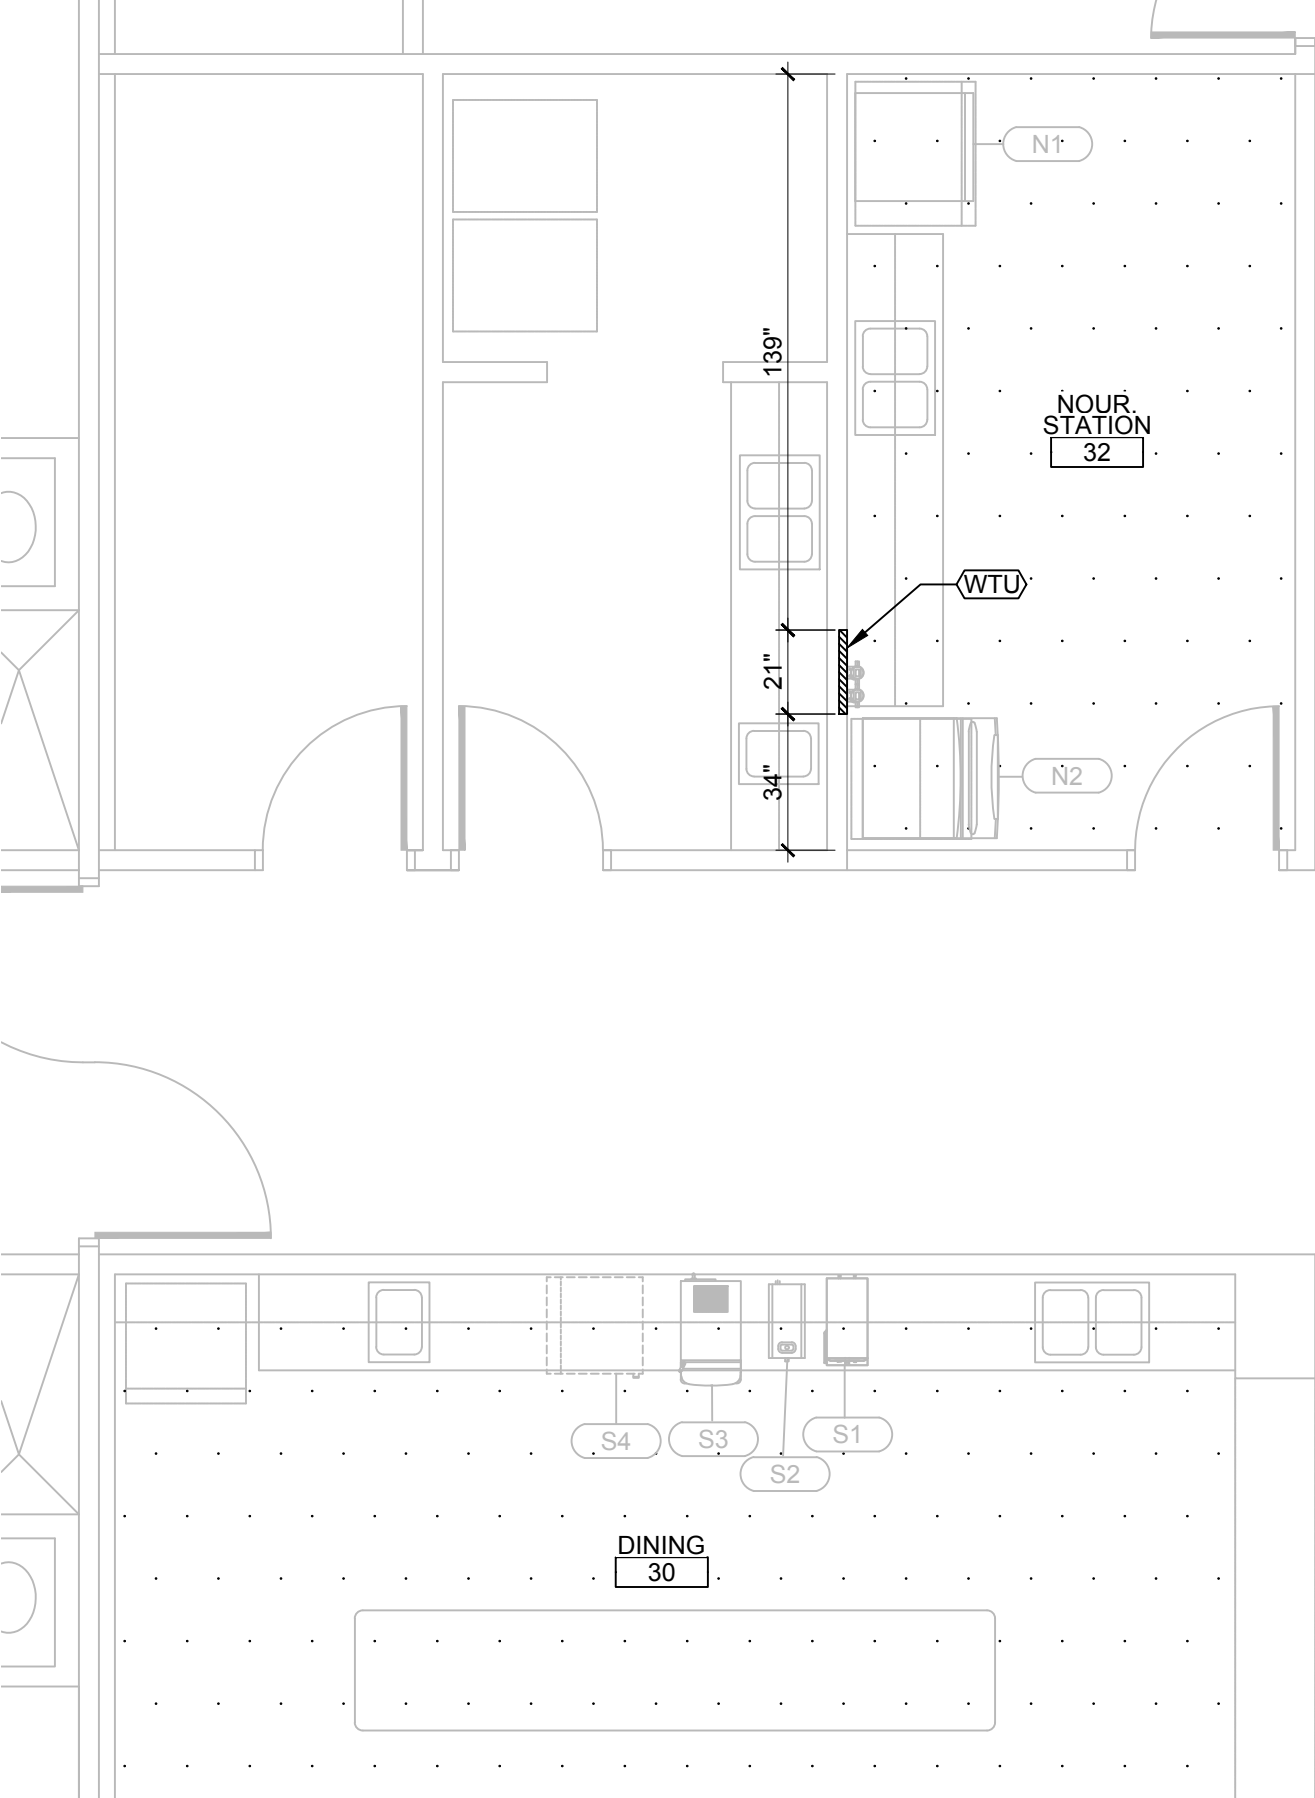


- GENERAL BUILDING WORKS NOTES
1. ALL WALLS WITHIN 1'-6" OF TYPE 1 HOODS TO BE NON-COMBUSTIBLE.
 2. CONDENSERS FOR WALK-IN COOLERS AND FREEZERS TO BE LOCATED ON BUILDING ROOF, DIRECTLY ABOVE WALK-INS, OR ON EXTERIOR PAD, PREFERABLY WITHIN 50'-0" OF WALK-INS. VERIFY EXACT LOCATION WITH ARCHITECT, ROOF RAILS OR EXTERIOR PAD BY GENERAL CONTRACTOR.
 3. FOR HOODS AND WALK-INS REFER TO EQUIPMENT CUTSHEET BOOK.

WALL BLOCKING SCHEDULE		
CONFIRM ALL WALL BLOCKING HEIGHTS WITH EQUIPMENT CUT SHEETS AND FIELD CONDITIONS		
TAG	EQUIPMENT TYPE	BLOCKING HEIGHT AFF
EWS	EYEWASH STATION	24"-50"
FSC	FIRE SUPPRESSION CABINET - BACK OF HOUSE	72"-FINISHED CEILING
HR	HOSE REEL	60"-86"
HS	HAND SINK	24"-50"
PR	POT RACK	42"-90"
PRF	PRE-RINSE FAUCET	54"-72"
SR	SORTING RACK	46"-66"
SDR	SLANTED DISH RACK	42"-72"
WS	WALL SHELF	42"-60"
WSD	WALL SHELF DOUBLE	42"-80"
WT	WATER TREATMENT SYSTEM	36"-72"
WTU	WATER TREATMENT SYSTEM - UNDERCOUNTER	12"-36"
PFF	PULL DOWN CORD REEL	ABOVE GRID

FLOOR DEPRESSION SCHEDULE		
CONFIRM ALL FLOOR DEPRESSIONS WITH EQUIPMENT CUT SHEETS/DRAWINGS AND FIELD CONDITIONS		
TAG	EQUIPMENT TYPE	DEPRESSION DEPTH
FT	FLOOR THROUGH	4"
WI	WALK-IN COOLER AND FREEZER	7"

BUILDING WORKS	
	WALL BLOCKING
	FLOOR DEPRESSION
ABBREVIATIONS	
AFF	ABOVE FINISH FLOOR
ACH	ABOVE COUNTER HEIGHT
FV	FIELD VERIFY
HW/CW	HOT/COLD WATER
FOH	FRONT OF HOUSE
BOH	BACK OF HOUSE
FSEC	FOODSERVICE EQUIPMENT CONTRACTOR
GC	GENERAL CONTRACTOR
EC	ELECTRICAL CONTRACTOR
PC	PLUMBING CONTRACTOR

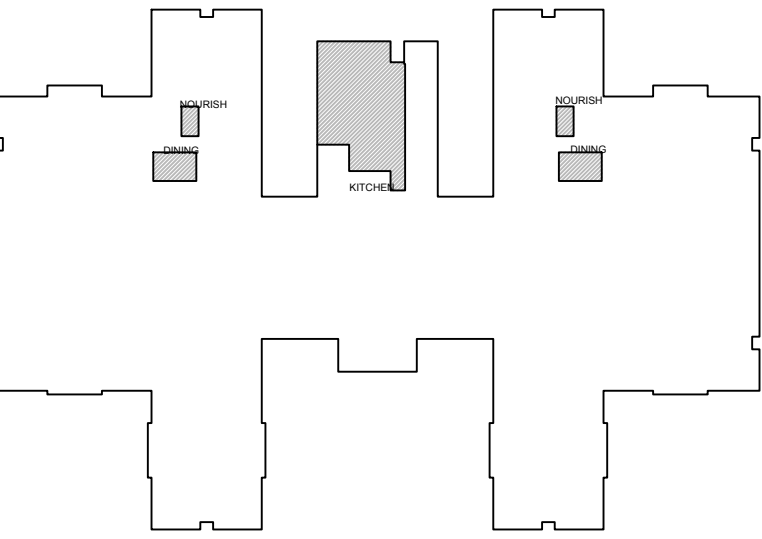

PLAN TRUE
KEY PLAN
SCALE: NTS

NOT FOR CONSTRUCTION
11-17-25 9:10 AM PRINTED BY: MATTEL

REVISIONS

△	
△	
△	
△	
△	

PROJECT STATUS: CD
DATE ISSUED: 11/14/2025
DRAWN BY: ME
CHECKED BY: AM
PROJECT# 10388875

BUILDING WORKS PLANS

 
PRINCIPLE HEALTHCARE WAKE COUNTY
HOLLY SPRINGS
1435 HWY 258 N 28504.
KINSTON, NC 28501-0039

1435 HWY 258 N 28504.
KINSTON, NC 28501-00399

**NOT FOR
CONSTRUCTION**

11-17-25 9:10 AM PRINTED BY: MATTE

REVISIONS



PROJECT STATUS:	CD
DATE ISSUED:	11/14/2025
DRAWN BY:	ME
CHECKED BY:	AM
PROJECT#	10388875

MEP
SCHEDULES

Q-701

KITCHEN - MECHANICAL, ELECTRICAL, & PLUMBING SCHEDULE

ITEM NO	QTY	EQUIPMENT CATEGORY	MANUFACTURER	MODEL NUMBER	EQUIPMENT REMARKS	AMPS	KW	VOLTS	PHASE	CYCLE	DIRECT PLUG	NEMA	ELECTRICAL AFF (IN)	ELEC REMARKS	COLD WATER SIZE (IN)	COLD WATER AFF (IN)	HOT WATER SIZE (IN)	HOT WATER AFF (IN)	DIRECT DRAIN SIZE (IN)	DIRECT DRAIN AFF (IN)	INDIR DRAIN SIZE (IN)	GAS SIZE (IN)	MBTUH	GAS (IN)	PLUMBING REMARKS	ITEM NO
K1	1	SOILED DISH TABLE	ADVANCE TABCO	DT5-S70-96L	-	-	-	-	-	-	-	-	-	-	-	-	-	-	-	-	-	-	-	-	-	K1
K1.1	1	PRE-RINSE UNIT	T & S BRASS	B-0133-12ACB8ST	-	-	-	-	-	-	-	-	-	-	-	-	-	-	-	-	-	-	-	-	-	K1.1
K2	1	WAREWASHER, CONVEYOR, HIGH TEMP	CMA	EST-44	-	55.0	-	208	3	60	X	-	60	-	-	0.5	18	0.5	18	-	-	-	-	-	-	K2
			CMA	BOOSTER HEATER	-	42.0	-	208	3	60	X	-	60	-	-	-	-	-	-	-	2	-	-	-	-	
K2.1	1	CONDENSATE HOOD	CAPTIVEAIRE	CUSTOM	-	-	-	-	-	-	-	-	-	SEE FS CUTSHEET BOOK	-	-	-	-	-	-	-	-	-	-	-	K2.1
K3	1	CLEAN DISH TABLE	ADVANCE TABCO	DT0-S70-84R	-	-	-	-	-	-	-	-	-	-	-	-	-	-	-	-	-	-	-	-	-	K3
K4	2	DISH RACK SHELF	ADVANCE TABCO	DT-6R-48	-	-	-	-	-	-	-	-	-	-	-	-	-	-	-	-	-	-	-	-	-	K4
K5	3	WIRE SHELVING, MOBILE	QUANTUM	2454P	-	-	-	-	-	-	-	-	-	-	-	-	-	-	-	-	-	-	-	-	-	K5
K6	1	THREE COMPARTMENT SINK	ADVANCE TABCO	94-23-60-24RL	-	-	-	-	-	-	-	-	-	-	-	-	-	-	-	-	-	-	-	-	-	K6
K6.1	2	FAUCET, SPLASH MOUNT	T&S BRASS	B-0290-04	-	-	-	-	-	-	-	-	-	-	-	0.5	18	0.5	18	-	-	-	-	-	-	K6.1
K7	1	SHELF, WALL MOUNT	ADVANCE TABCO	WS-12-48-16	-	-	-	-	-	-	-	-	-	-	-	-	-	-	-	-	-	-	-	-	-	K7
K8	1	POT RACK, WALL MOUNT	ADVANCE TABCO	SW-36-EC	-	-	-	-	-	-	-	-	-	-	-	-	-	-	-	-	-	-	-	-	-	K8
K9	1	EYE WASH STATION	T&S BRASS	EW-7360B-TMV	-	-	-	-	-	-	-	-	-	-	-	0.5	18	0.5	18	1.5	18	-	-	-	-	K9
K10	4	HAND SINK, WALL MOUNT	ADVANCE TABCO	7-PS-60	-	-	-	-	-	-	-	-	-	-	-	0.5	18	0.5	-	1.5	18	-	-	-	-	K10
K11	4	TRASH CAN	-	-	BY OWNER	-	-	-	-	-	-	-	-	-	-	0.5	18	0.5	-	1.5	18	-	-	-	-	K11
K11.1	1	TRASH CAN MOBILE	-	-	BY OWNER	-	-	-	-	-	-	-	-	-	-	-	-	-	-	-	-	-	-	-	-	K11.1
K12	2	HEATED BANQUET CART	CRES COR	EB-64	-	13.8	1.5	120	1	60	-	X	5-15P	25	-	-	-	-	-	-	-	-	-	-	-	K12
K13	1	REFRIGERATOR, REACH-IN	ARCTIC AIR	AR49	-	5.4	1.1	115	1	60	-	X	5-15P	25	-	-	-	-	-	-	-	-	-	-	-	K13
K14	1	EXHAUST HOOD	CAPTIVEAIRE	CUSTOM	-	-	-	-	-	-	-	-	-	-	-	-	-	-	-	-	-	-	-	-	-	K14
K14.1	1	UTILITY CABINET	CAPTIVEAIRE	CUSTOM	-	-	-	-	-	-	-	-	-	-	-	-	-	-	-	-	-	-	-	-	-	K14.1
K15	1	STEAM KETTLE	CLEVELAND RANGE	KET-20-T	-	40.9	-	208	3	60	X	-	25	-	-	0.5	18	0.5	-	-	-	-	-	-	-	K15
K16	1	FRYER, GAS	FRYMASTER	GF14	-	-	-	-	-	-	-	-	-	-	-	-	-	-	-	-	-	0.75	90	16	-	K16
K17	1	TABLE, FILLER	ADVANCE TABCO	FT-3015	-	-	-	-	-	-	-	-	-	-	-	-	-	-	-	-	-	-	-	-	-	K17
K18	1	STEAMER, ELECTRIC	CLEVELAND RANGE	21-CET-16	-	45.9	-	208	3	60	X	-	25	-	-	0.5	18	-	-	-	1	-	-	-	-	K18
K19	1	GRIDDLE, GAS	WELLS	HDG-3630G	-	-	-	-	-	-	-	-	-	-	-	-	-	-	-	-	-	0.75	90	16	-	K19
K20	1	STAND, EQUIPMENT	ADVANCE TABCO	EG-LG-303	-	-	-	-	-	-	-	-	-	-	-	-	-	-	-	-	-	-	-	-	-	K20
K21	1	RANGE, RESTAURANT, GAS	SOUTHBEND	336D	-	-	-	-	-	-	-	-	-	-	-	-	-	-	-	-	-	-	-	-	-	K21
K22	1	CONVECTION OVEN, DOUBLE, GAS	SOUTHBEND	PCG100B/SD	-	9.0	1.5	120	1	60	-	X	5-15P	25	(2) CONNECTIONS	-	-	-	-	-	-	-	0.75	203	16	K22
K23	1	HOT FOOD TABLE	DUKE	E305SW	-	18.0	-	208	1	60	-	X	L6-30P	12	STUB UP FROM FLOOR	-	-	-	-	-	1	-	-	-	-	K23
K24	1	WORK TABLE, MOBILE	ADVANCE TABCO	MSLAG-365-X	-	-	-	-	-	-	-	-	-	-	-	-	-	-	-	-	-	-	-	-	-	K24
K25	2	MOBILE HEATED CABINET	METRO	C539-HLDS-UA	-	12.0	-	120	1	60	-	X	5-15P	-	DROP CORD FROM CEILING	-	-	-	-	-	-	-	-	-	-	K25
K26	1	WORK TABLE W/OVERSHELF	ADVANCE TABCO	TKMSLAG-306-X	-	-	-	-	-	-	-	-	-	-	-	-	-	-	-	-	-	-	-	-	-	K26
K26.1	3	INGREDIENT BIN	CAMBRO	IBS27148	-	-	-	-	-	-	-	-	-	-	-	-	-	-	-	-	-	-	-	-	-	K26.1
K27	1	WORK TABLE, MOBILE	ADVANCE TABCO	MSLAG-306C-X	-	-	-	-	-	-	-	-	-	-	-	-	-	-	-	-	-	-	-	-	-	K27
K28	1	MIXER, 20 QT.	GLOBE	SP20	-	6.0	-	120	1	60	-	X	5-15P	-	DROP CORD FROM CEILING	-	-	-	-	-	-	-	-	-	-	K28
K29	1	STAND, MIXER	ADVANCE TABCO	MT-SS-302	-	-	-	-	-	-	-	-	-	-	-	-	-	-	-	-	-	-	-	-	-	K29
K30	1	BEVERAGE TABLE	ADVANCE TABCO	BEV-30-96R	-	20.0	-	120	1	60	-	-	40	CONNECT TO OUTLET IN BACKSPLASH	0.5	18	0.5	18	-	-	1.5	-	-	-	-	K30
K31	1	COFFEE MAKER	BUNN	36700.0009	BY OWNER	14.4	1.7	120	1	60	-	X	5-15P	50	VERIFY ELECTRICAL REQUIREMENTS	0.25	50	-	-	-	-	-	-	-	-	K31
K32	1	TEA BREWER	BUNN	23001.0000	BY OWNER	14.4	1.7	120	1	60	-	X	5-15P	50	VERIFY ELECTRICAL REQUIREMENTS	0.25	50	-	-	-	-	-	-	-	-	K32
K33	1	JUICE DISPENSER	BUNN	37300.0004	BY OWNER	6.0	-	120	1	60	-	X	5-15P	50	VERIFY ELECTRICAL REQUIREMENTS	0.375	50	-	-	-	-	-	-	-	-	K33
K34	1	ICE MAKER W/BIN	MANITOWOC	IDT9450A	-	13.2	-	115	1	60	X	-	66	-	-	0.375	60	-	-	-	1	-	-	-	-	K34
K35	1	SLICER	GLOBE	C12	-	3.0	-	120	1	60	-	X	5-15P	-	DROP CORD FROM CEILING	-	-	-	-	-	-	-	-	-	-	K35
K36	1	SLICER STAND, MOBILE	ADVANCE TABCO	MSLAG-300-X	-	-	-	-	-	-	-	-	-	-	-	-	-	-	-	-	-	-	-	-	-	K36
K37	1	PREP SINK	ADVANCE	KMS-11B-305L	-	-	-	-	-	-	-	-	-	-	-	-	-	-	-	-	1.5	-	-	-	-	K37
K37.1	1	FAUCET, DECK MOUNT	T&S BRASS	B-0225-CC-CR	-	-	-	-	-	-	-	-	-	-	-	0.5	18	0.5	18	-	-	-	-	-	-	K37.1
K38	1	S/S SPLASH, WALL MOUNT	CUSTOM	48"H X 30"D	-	-	-	-	-	-	-	-	-	-	-	-	-	-	-	-	-	-	-	-	-	K38
K39	1	PREP SINK	ADVANCE	KMS-11B-305R	-	-	-	-	-	-	-	-	-	-	-	-	-	-	-	-	1.5	-	-	-	-	K39
K39.1	1	FAUCET, DECK MOUNT	T&S BRASS	B-0225-CC-CR	-	-	-	-	-	-	-	-	-	-	-	0.5	18	0.5	18	-	-	-	-	-	-	K39.1
K40	2	BUN PAN RACK	ADVANCE	PR30-2W	-	-	-	-	-	-	-	-	-	-	-	-	-	-	-	-	-	-	-	-	-	K40
K41	1	WIRE SHELVING, MOBILE	QUANTUM	1824P	-	-	-	-	-	-	-	-	-	-	-	-	-	-	-	-	-	-	-	-	-	K41
K42	1	MOP SINK	-	-	BY PLUMBING CONTRACTOR	-	-	-	-	-	-	-	-	-	-	-	-	-	-	-	-	-	-	-	-	K42
K43	1	WALK-IN COOLER/FREEZER	KOLPAK	CUSTOM	-	-	-	-	-	-	-	-	-	-	-	-	-	-	-	-	-	-	-	-	-	K43
K43.1	4	WIRE SHELVING, MOBILE	QUANTUM	2460P	-	-	-	-	-	-	-	-	-	-	-	-	-	-	-	-	-	-	-	-	-	K43.1
K43.2	4	WIRE SHELVING, MOBILE	QUANTUM	2442P	-	-	-	-	-	-	-	-	-	-	-	-	-	-	-	-	-	-	-	-	-	K43.2
K43.3	7	WIRE SHELVING, MOBILE	QUANTUM	2448P	-	-	-	-	-	-	-	-	-	-	-	-	-	-	-	-	-	-	-	-	-	K43.3
K44	1	CAN RACK	NEW AGE	1250CK	-	-	-	-	-	-	-	-	-	-	-	-	-	-	-	-	-	-	-	-	-	K44
K45	3	WIRE SHELVING, MOBILE	QUANTUM	2448P	-	-	-	-	-	-	-	-	-	-	-	-	-	-	-	-	-	-	-	-	-	K45
K45.1	8	WIRE SHELVING, MOBILE	QUANTUM	2460P	-	-	-	-	-	-	-	-	-	-	-	-	-	-	-	-	-	-	-	-	-	K45.1
K45.2	2	WIRE SHELVING, MOBILE	QUANTUM	2442P	-	-	-	-	-	-	-	-	-	-	-	-	-	-	-	-	-	-	-	-	-	K45.2
K46	2	SHELF, WALL MOUNT	ADVANCE TABCO	WS-12-60-16	-	-	-	-	-	-	-	-	-	-	-	-	-	-	-	-	-	-	-	-	-	K46

NOURISHMENT STATIONS - MECHANICAL, ELECTRICAL, & PLUMBING SCHEDULE

ITEM NO.	QTY	EQUIPMENT CATEGORY	MANUFACTURER	MODEL NUMBER	EQUIPMENT REMARKS	AMPS	KW	VOLTS	PHASE	CYCLE	DIRECT	PLUG	NEMA	ELECTRICAL SIZE (IN)	ELEC. REMARKS	COLD WATER SIZE (IN)	COLD WATER AFF (IN)	HOT WATER SIZE (IN)	HOT WATER AFF (IN)	DIRECT DRAIN SIZE (IN)	DIRECT DRAIN AFF (IN)	INDIR DRAIN SIZE (IN)	GAS SIZE (IN)	MBTUH	GAS (IN)	PLUMBING REMARKS	ITEM NO.
N1	2	REFRIGERATOR, REACH-IN	ARCTIC AIR	AR23	-	3.0	-	115	1	60	-	X	5-15P	25	-	-	-	-	-	-	-	-	-	-	-	-	N1
N2	2	ICE MAKER W/BIN	MANITOWOC	IYT-0300W	-	10.0	-	115	1	60	X	-	-	60	-	0.375	66	-	-	-	-	-	1	-	-	-	N2

SERVING - MECHANICAL, ELECTRICAL, & PLUMBING SCHEDULE

[illegible]