

PLUMBING SCHEDULE

DRAWING CODE	FIXTURE		DESCRIPTION	MANUFACTURER	MODEL	NOTES	PIPE SIZE			
							CW	HW	WASTE	VENT
WC1	TANK TYPE WATER CLOSET, FLOOR MTD, ADA	BOWL	17" HIGH BOWL, ELONGATED, V.C., 1.6 GPF, WHITE FINISH	AMERICAN STANDARD	215AA.004	5,7	1/2"	-	3"	2"
		SEAT	OFLC w/ SELF-SUSTAINING S.S. CHECK HINGE	OLSONITE	95C					
LAV1	COUNTERTOP LAVATORY ADA	BOWL	INTEGRAL WITH COUNTERTOP- FURN. BY G.C.	-	-	2,4,5	1/2"	1/2"	2"	2"
		FAUCET	4" CENTERSET, TWO HANDLE, 1.20GPM@60PSI, THREE HOLE MOUNT, 1/4 TURN HANDLE STOPS V.P.	DELTA	2538-TP-DST					
SH1	JOB-BUILT SHOWER, ADA	DRAIN	POP-UP	DELTA	-	8	1/2"	1/2"	2"	2"
		ENCLOSURE	JOB-BUILT BY G.C. W/ GRAB BARS per ADA	-	-					
		VALVE	PRESS. BAL., ARM/, 2.0 GPM HEAD	SYMMONS	S-96-1					
		VALVE	PRESS. BAL., HAND SPRAY w/ VACUUM BREAKER, 24" SLD. BAR	SYMMONS	S-96-300-B30-L-V					
		DRAIN	6" DIA. NKL. BRZ.	JR SMITH	2000					
SK1	1-COMPARTMENT COUNTERTOP SINK, ADA	BOWL	15x15x6 18 GA S.S.	ELKAY	BCR153	2,3,4,5	1/2"	1/2"	2"	2"
		FAUCET	GOOSENECK,WRISTBLADE HANDLE	DELTA	B28910LF					
		DRAIN	CRUMBUCUP STRAINER	ELKAY	LK35					
SK2	2-COMPARTMENT COUNTERTOP SINK, ADA	BOWL	33x21x5.5, 18 GA S.S.	ELKAY	LRAD3321	2,3,4,5	1/2"	1/2"	2"	2"
		FAUCET	GOOSENECK,WRISTBLADE HANDLE, V.P. LAMINAR FLOW AERATOR	DELTA	26T3925					
		DRAIN	(2) CRUMBUCUP STRAINER	ELKAY	LK35					
FCO	FLOOR CLEANOUT	FIXT	C.I. BODY, ADJUSTABLE, SCORIGATED, NICKEL BRONZE TOP	JR SMITH	4020	-	-	MATCH	-	-
WCO	WALL CLEANOUT	FIXT	ROUND S/S ACCESS COVER & SCREW, RECESS BRONZE THRD. PLUG	JR SMITH	4710	-	-	MATCH	-	-
FD1	FLOOR DRAIN	FIXT	C.I. BODY, MEMBRANE CLAMP, 6" DIA. NICKEL BRONZE TOP	JR SMITH	2000	6	-	-	MATCH	-
FS1	FLOOR SINK	FIXT	8x8x6 A.R.C.I. RECEPTOR, MEMBRANE CLAMP, DOME STRAINER, 1/2 GRATE	JR SMITH	3100	-	-	MATCH	-	-
HB1	INTERIOR HOSE BIBB	FIXT	POLISHED CHROME, VACUUM BREAKER, WHEEL HANDLE, 3/4" HOSE THREAD	WOODFORD	24P	-	3/4"	-	-	-
HB2	EXTERIOR HOSE BIBB	FIXT	NON-FREEZE, ROUGH BRASS, VACUUM BREAKER, REMOVABLE HANDLE, 3/4" HOSE THREAD	WOODFORD	25CP	-	3/4"	-	-	-
GI1	GREASE INTERCEPTOR	FIXT	430 GALLON CONCRETE INTERCEPTOR, AS APPROVED BY LOCAL JURSDICTION	-	-	-	-	-	4"	-
GI2	GREASE INTERCEPTOR	FIXT	1500 GALLON CONCRETE INTERCEPTOR, AS APPROVED BY LOCAL JURISDICTION	-	-	-	-	-	4"	-

- NOTES
- NOT USED.
 - PROVIDE BRASS 1-1/2" TAILPIECE, CAST BRASS SLIP JOINT P-TRAP WITH CLEANOUT; PROVIDE ADA OFFSET ARRANGEMENT AND/OR TRAP PRIMER CONNECTION WHERE REQUIRED.
 - PROVIDE ADA INSULATION KIT
 - COORDINATE WITH MILLWORK.
 - PROVIDE 1/2" IPS X 3/8" OD BRASS STOP(S) WITH RIGID COPPER RISERS. ALL EXPOSED PIPING SHALL BE CHROME PLATED.
 - PROVIDE TRAP PRIMER
 - TRIP LEVER TO BE LOCATED ON WIDE SIDE OF TOILET ROOM.
 - REFER TO ARCHITECTURAL DETAILS FOR VALVE/HEAD ARRANGEMENT.

GAS-FIRED TANKLESS WATER HEATER SCHEDULE

DRAWING CODE	DESCRIPTION	LOCATION	DESIGN BASIS MFR	MODEL	CAPACITY (GPM @F RISE)	FUEL			WATER CONN.	ELECTRICAL	NOTES
						TYPE	INPUT (MBH) (4) 159	GAS CONNECTION		VOLTAGE (VPHHZ) 120/160	
GW1	TANKLESS, FREE STANDING RACK SYSTEM	MECH. 49	RINNAI	TRSD4CXN	30.8 @ 50	NG		5-1/4"	2"		1-5
NOTES: 1 RACK SYSTEM INCLUDES (4) CU199 199 MBH INPUT CONDENSING TANKLESS WATER HEATERS WITH PRE-PIPED COLD WATER, HOT WATER, GAS AND DRAIN MANIFOLDS AND FLOOR SUPPORT FRAME. 2 PRE-WIRED ELECTRICAL ASSEMBLY WITH (2) 20A 120V 2-POLE 3-WIRE GROUNDING RECEPTACLES. 3 COORDINATE ELECTRICAL REQUIREMENTS WITH ELECTRICAL CONTRACTOR. 4 MSB-M MODULAR ELECTRONIC CONTROL SYSTEM WITH INTERCONNECTING WIRING TO STAGE ALL HEATERS IN EACH GWH AS A GROUP. 5 ET1: 11.3 GALLON ACCEPTANCE EXPANSION TANK @ 100PSI MAX, 60 PSI INLET, NSF RATED FOR POTABLE WATER AMTROL ST-30VC-DD											

PUMP SCHEDULE

DRAWING CODE	DESCRIPTION	MANUFACTURER	MODEL	FLOW GPM@FT. HD	MOTOR HP (WATTS)	POWER (V/PHHZ)	PIPE CONNECTION (INCHES)	NOTES
CP1	CARTRIDGE CIRCULATOR, STAINLESS STEEL FITTED, FLANGE CONNECTIONS	GRUNDFOS	UPS 15-42 F	5@10	(92.00)	120/160	1"	1
NOTES: 1. PROVIDE WITH 110°F AQUASTAT								

PLUMBING NOTES

- MAIN WATER LINES ARE SHOWN ON OVERALL PLAN DRAWINGS. SEE TYPICAL AND ENLARGED PLANS FOR BRANCH PIPING NOT SHOWN ON OVERALL PLANS.
- ROUTE WATER LINES IN ATTIC TO AVOID CATWALKS. WHERE PIPING CROSSES CATWALK, ROUTE OVERHEAD (6' MIN. ABOVE CATWALK) OR UNDER CATWALK FLOOR.
- MINIMUM WATER LINE SIZE SHALL BE 1/2". MINIMUM VENT SIZE SHALL BE 2". MINIMUM WASTE SIZE SHALL BE 2".
- ALL PIPING PENETRATIONS THRU SMOKE AND FIRE WALLS SHALL BE SEALED PER APPROPRIATE LISTED ASSEMBLIES. SEE ARCHITECTURAL DRAWINGS FOR DETAILS.
- PLUMBING CONNECTIONS SHOWN ARE SCHEMATIC. ALL FITTINGS AND PIPING ARRANGEMENTS SHALL BE IN ACCORDANCE WITH APPLICABLE PLUMBING CODES.
- PIPE ROUTING IS APPROXIMATE BASED ON ASSUMED FRAMING ARRANGEMENTS, ADJUST ROUTING AS REQUIRED TO CONFORM TO STRUCTURE.
- ICE MAKERS SHALL DRAIN THRU 2" AIR GAP INTO FLOOR DRAIN. PROVIDE REMOVABLE No. 10 MESH SCREEN OVER PIPE DISCHARGE OPENING AND CUT VERTICAL DROP AT 45° ANGLE.
- DO NOT INSTALL VTR'S ON FRONT FACING ROOF. EXTEND ALL VENTS TO EXIT BACK SIDE OF ROOF LINE. INDIVIDUAL VENTS AND VTR'S MAY BE COMBINED AT A SINGLE VTR PROVIDED CODE SIZING AND ARRANGEMENT IS FOLLOWED.
- RECESS ALL SHOWERS FLUSH WITH FLOOR FOR HANDICAPPED ACCESSIBILITY.
- VERIFY AND COORDINATE PLUMBING CONNECTIONS WITH SITE UTILITY PLANS.
- MAINTAIN 25'-0" MINIMUM BETWEEN ALL PLUMBING VENTS AND MECHANICAL INTAKES.
- PROVIDE SHUTOFFS ON WATER SUPPLIES TO EACH GROUP OF FIXTURES AS INDICATED OR REQUIRED BY CODE.
- BOILER WATER HEATER SHALL BE INSPECTED AND CERTIFIED BY FLORIDA STATE FIRE MARSHALL BOILER SAFETY SECTION. INSTALLATION SHALL COMPLY WITH SAME.

PIPING LEGEND

----	DOMESTIC COLD WATER PIPING
----	DOMESTIC 110°F HOT WATER PIPING
----	DOMESTIC HOT WATER CIRCULATION PIPING
----	SANITARY WASTE PIPING
----	SANITARY VENT PIPING

WALL TYPE LEGEND

----	1 HOUR FIRE BARRIER WALL
----	1 HOUR FIRE/SMOKE BARRIER WALL
----	SMOKE RESISTANT WALL
----	2 HOUR FIRE BARRIER WALL


PLUMBING ABBREVIATIONS

(X)	EXISTING
A.F.F.	ABOVE FINISHED FLOOR
A.R.C.I.	ACID RESISTANT CAST IRON
ADA	AMERICANS WITH DISABILITIES ACT
BRZ	BRONZE
BT	BATHTUB
C.I.	CAST IRON
CO	CLEANOUT
CONC.	CONCRETE
DCW	DOMESTIC COLD WATER
DHW	DOMESTIC HOT WATER
DIA.	DIAMETER
E.C.I.	ENAMELED CAST IRON
EC	ELECTRICAL CONTRACTOR
EWG	ELECTRIC WATER COOLER
EWH	ELECTRIC WATER HEATER
FCO	FLOOR CLEANOUT
FD	FLOOR DRAIN
FS	FLOOR SINK
GA.	GAUGE
GAL	GALLON
GC	GENERAL CONTRACTOR
GCO	GRADE CLEANOUT
GPF	GALLONS PER FLUSH
GPH	GALLONS PER HOUR
GPM	GALLONS PER MINUTE
GWH	GAS-FIRED WATER HEATER
HB	HOSE BIBB
INCL.	INCLUDED
KS	KITCHEN SINK
LAV	LAVATORY
LP	LIQUID PROPANE
MS	MOP SERVICE BASIN
NAT.	NATURAL GAS
NKL.	NICKEL
NON SIMULT.	NON SIMULTANEOUS
O.F.L.C.	OPEN FRONT LESS COVER
OB	OUTLET BOX
OC	ON CENTER
ORDL	OVERFLOW ROOF DRAIN LEADER
PC	PLUMBING CONTRACTOR
PRESS. BAL.	PRESSURE BALANCED
RCVY.	RECOVERY
RDL	ROOF DRAIN LEADER
SH	SHOWER
SK	SINK
SLD.	SLIDE
SS	STAINLESS STEEL
TDH	TOTAL DYNAMIC HEAD
TP	TRAP PRIMER
UR	URINAL
V	VENT
VB	VACUUM BREAKER
VC	VITREOUS CHINA
VR	VANDAL RESISTANT
VTR	VENT THROUGH ROOF
W	WASTE
WC	WATER CLOSET
WCO	WALL CLEANOUT
WH	WALL HYDRANT


NOTE: ALL ABBREVIATIONS MAY NOT BE USED IN PROJECT.

PLUMBING LOADS

	EXISTING	ADDITION	TOTAL
WASTE (DRAINAGE FIXTURE UNITS)	330	301	631
WATER	303	223	526

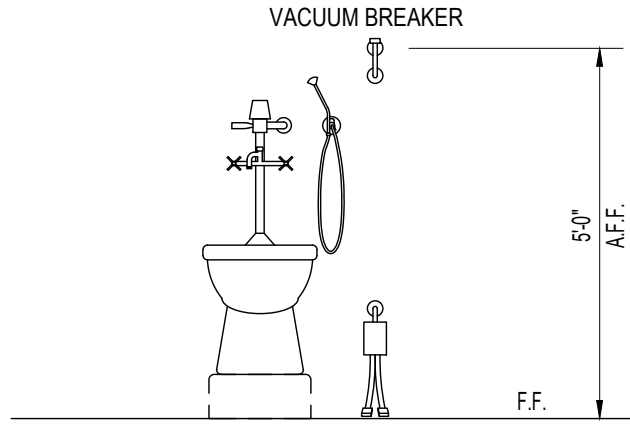


1 **CLINICAL SINK DETAIL**
NOT TO SCALE

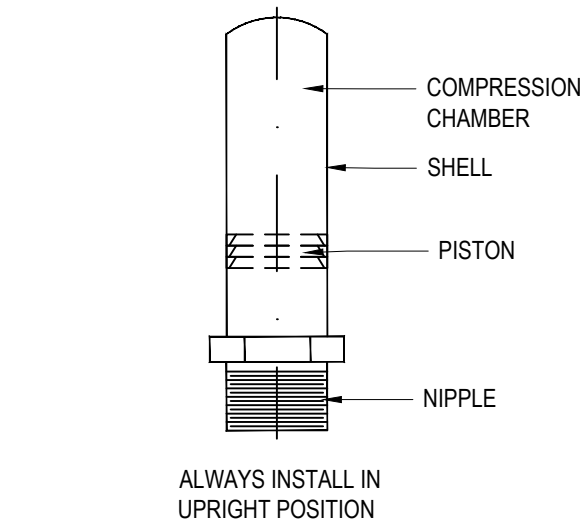


JOSAM NO.	P.D.I. SYMBOL	FIXTURE UNIT RATING	PIPE SIZE
7501-S	A	1-11	1/2
7502-S	B	12-32	3/4
7503-S	C	33-60	1
7504-S	D	61-113	1 1/4
7505-S	E	114-154	1 1/2
7506-S	F	155-330	2


2 **HAMMER ARRESTOR SCHEDULE AND DETAIL**
NOT TO SCALE

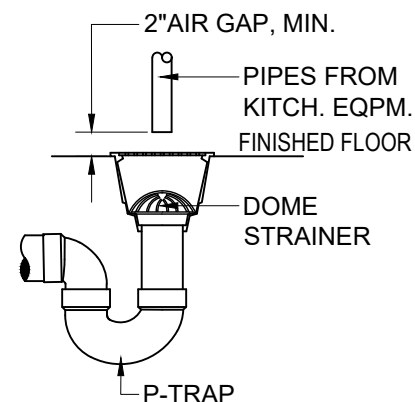


3 **FLOOR SINK DETAIL**
NOT TO SCALE

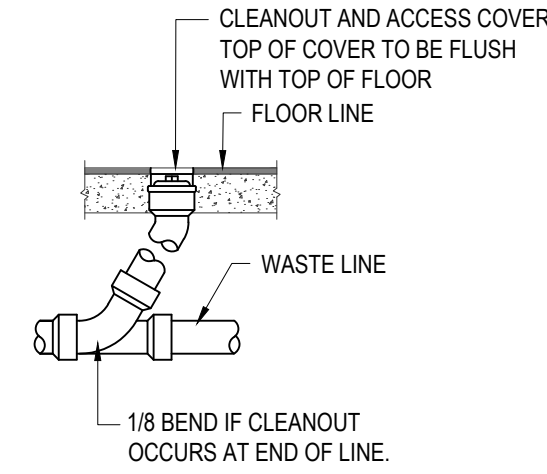


FLOOR CLEANOUT (FCO)

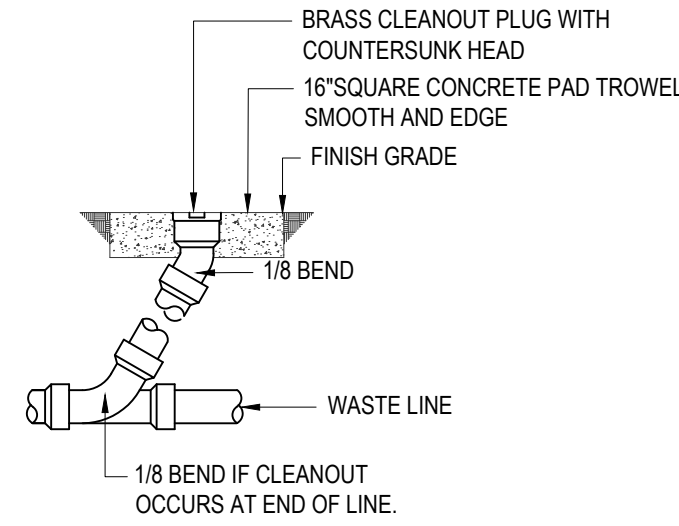

GRADE CLEANOUT (GCO)

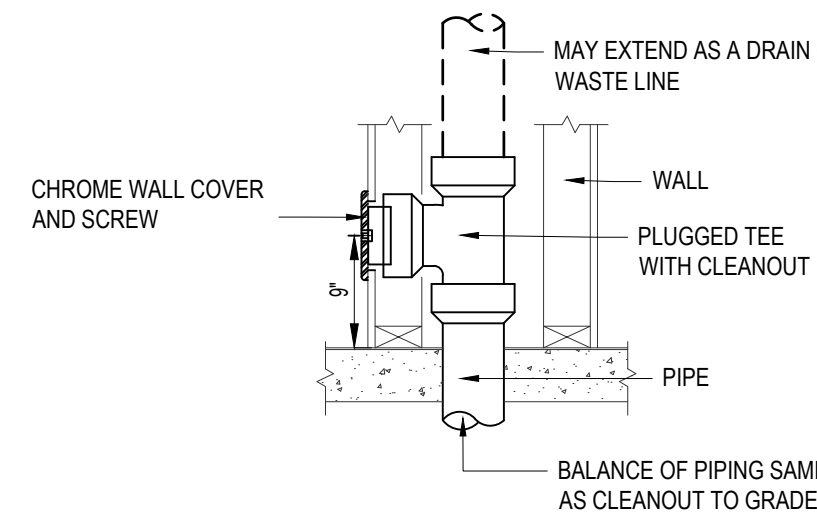


NOTE: CLEANOUT TO BE FLUSH WITH FINISHED WALL.
WALL CLEANOUT (WCO)

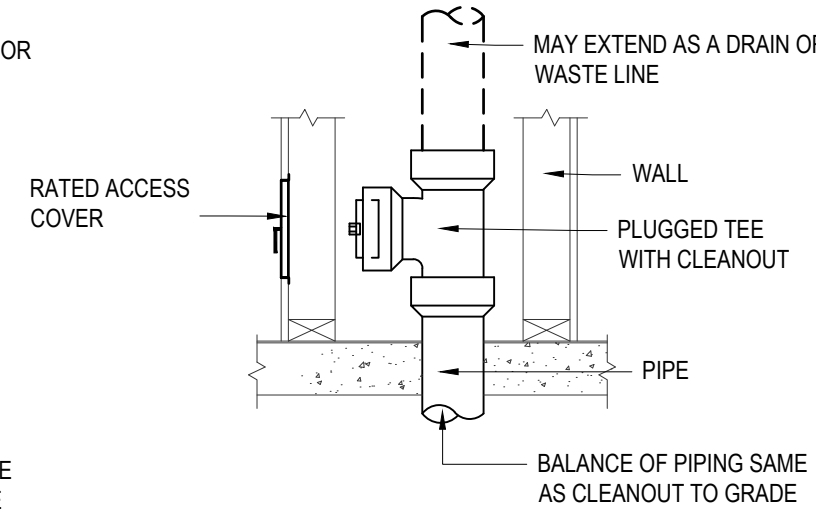


NOTE: CLEANOUT TO BE FLUSH WITH FINISHED WALL.
WALL CLEANOUT (WCO) RATED WALL


4 **CLEANOUT DETAILS**
NOT TO SCALE

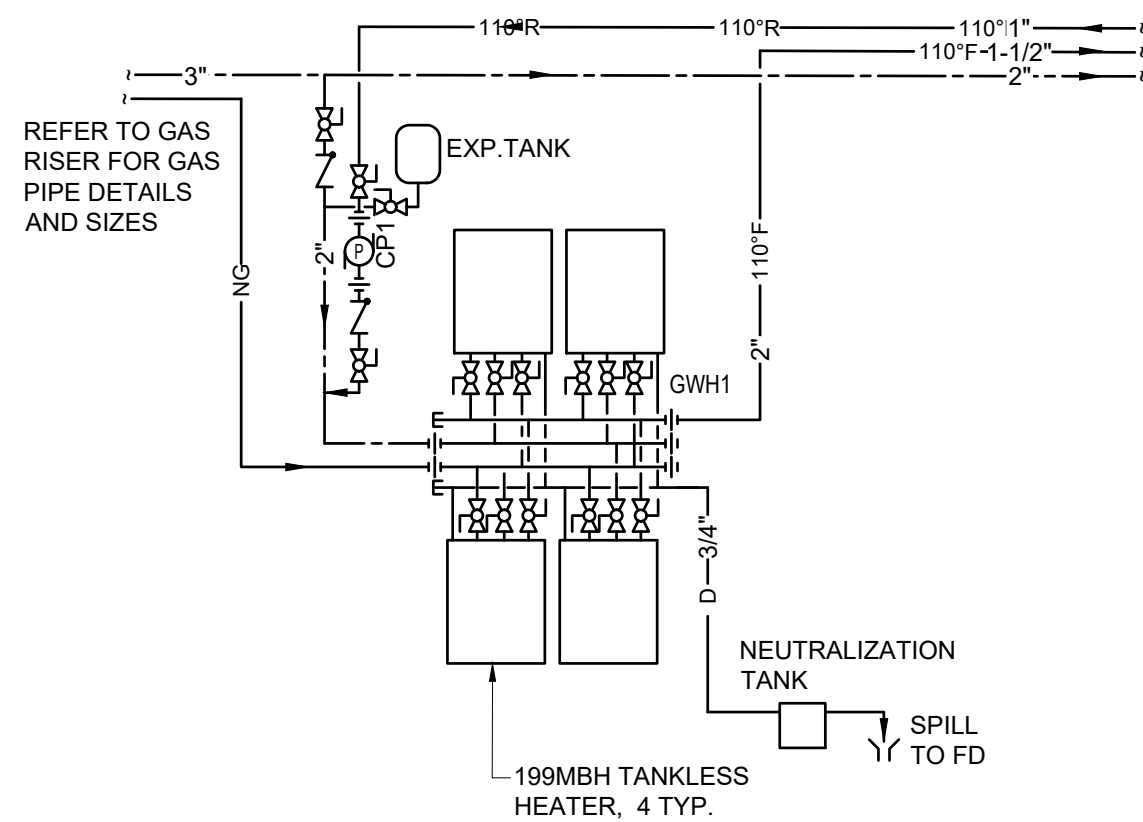


5 **GAS WATER HEATER DETAIL**
NOT TO SCALE

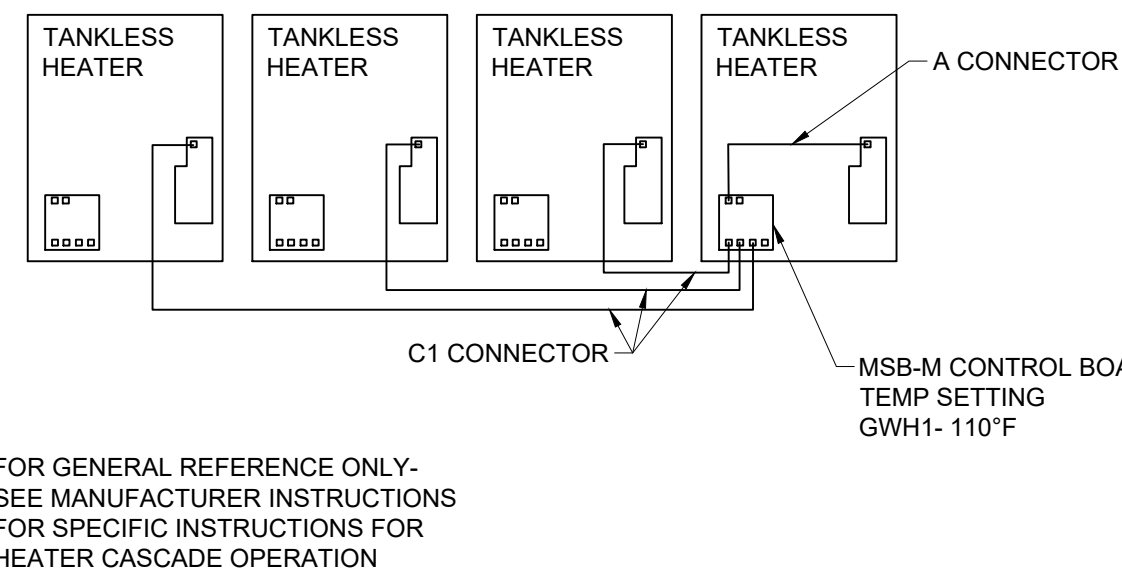

6 **GAS WATER HEATER CONTROL DETAIL**
NOT TO SCALE

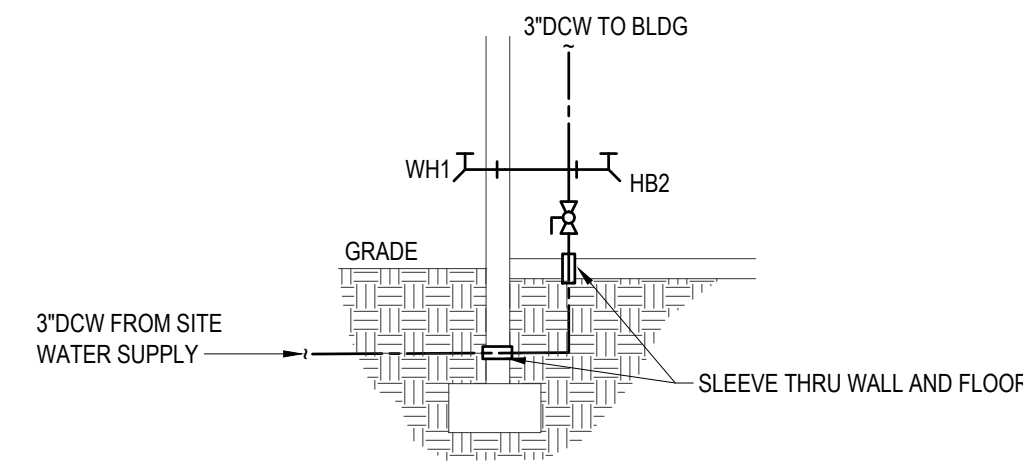


7 **WATER SERVICE ENTRANCE DETAIL**
NOT TO SCALE

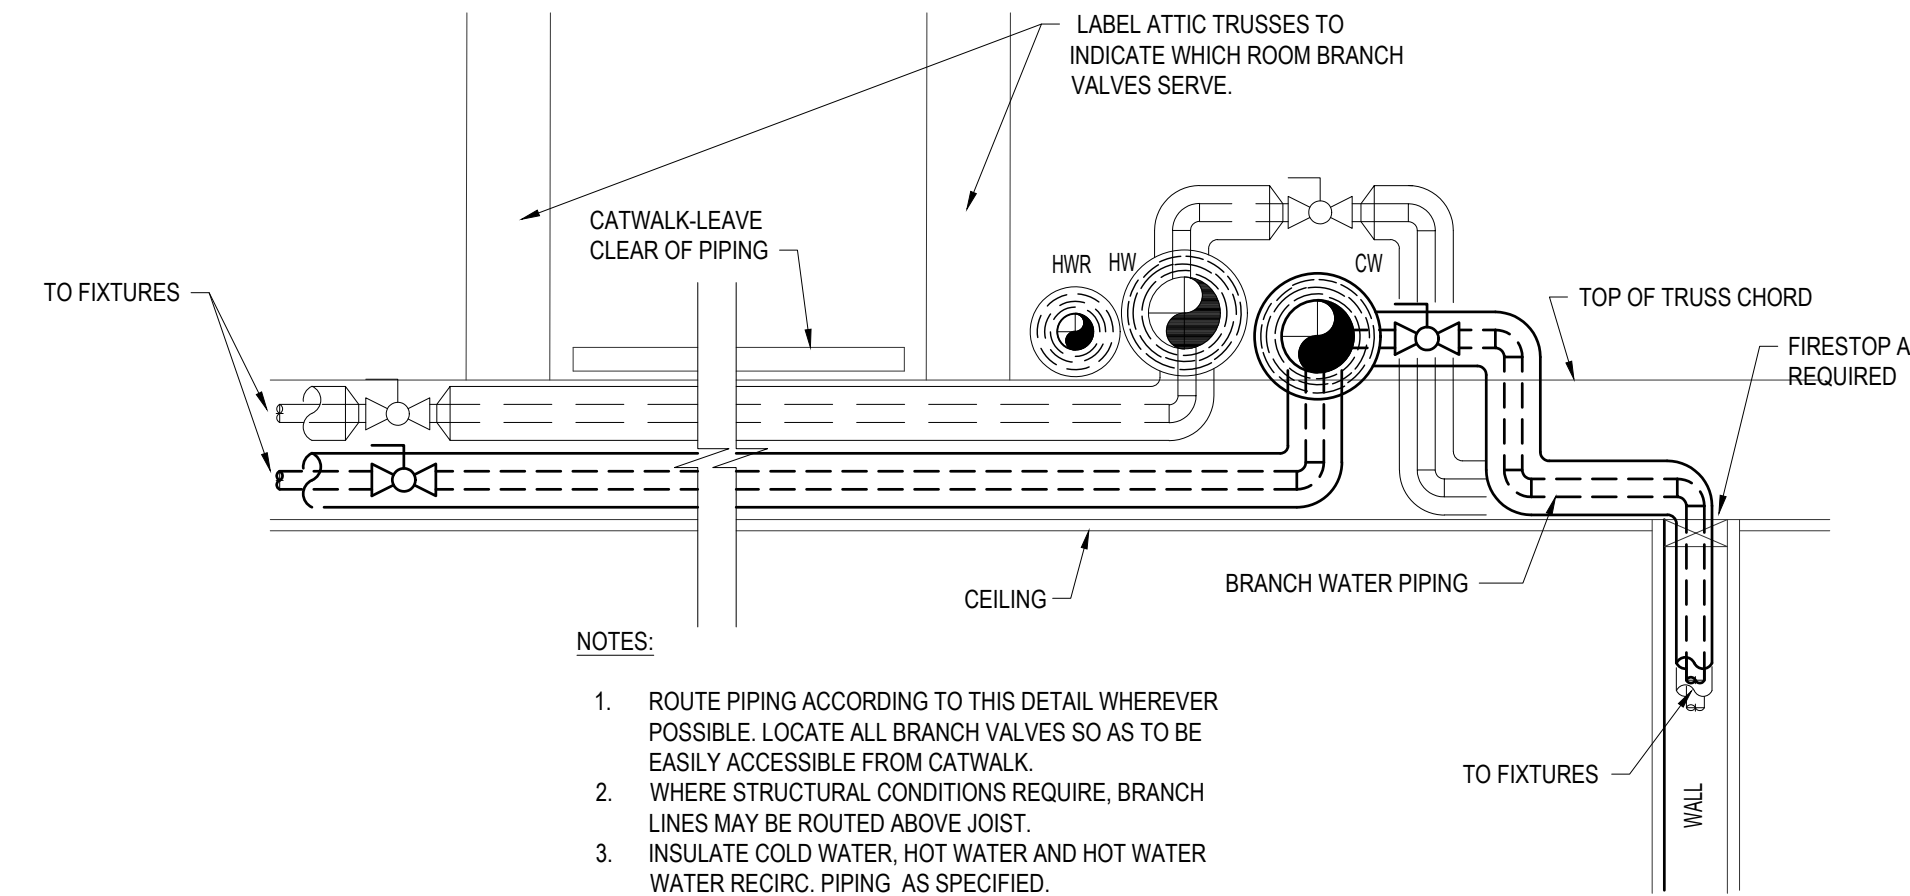


- NOTES:
- ROUTE PIPING ACCORDING TO THIS DETAIL WHEREVER POSSIBLE. LOCATE ALL BRANCH VALVES SO AS TO BE EASILY ACCESSIBLE FROM CATWALK.
 - WHERE STRUCTURAL CONDITIONS REQUIRE, BRANCH LINES MAY BE ROUTED ABOVE JOIST.
 - INSULATE COLD WATER, HOT WATER AND HOT WATER WATER RECIRC. PIPING AS SPECIFIED.
 - COORDINATE WITH MECHANICAL AND ELECTRICAL EQUIPMENT.
 - NON-RECIRC. HW SUPPLIES TO FIXTURES SHALL BE WITHIN 25 FEET OF RECIRC. MAIN.


8 **ATTIC WATER PIPING DETAIL**
NOT TO SCALE

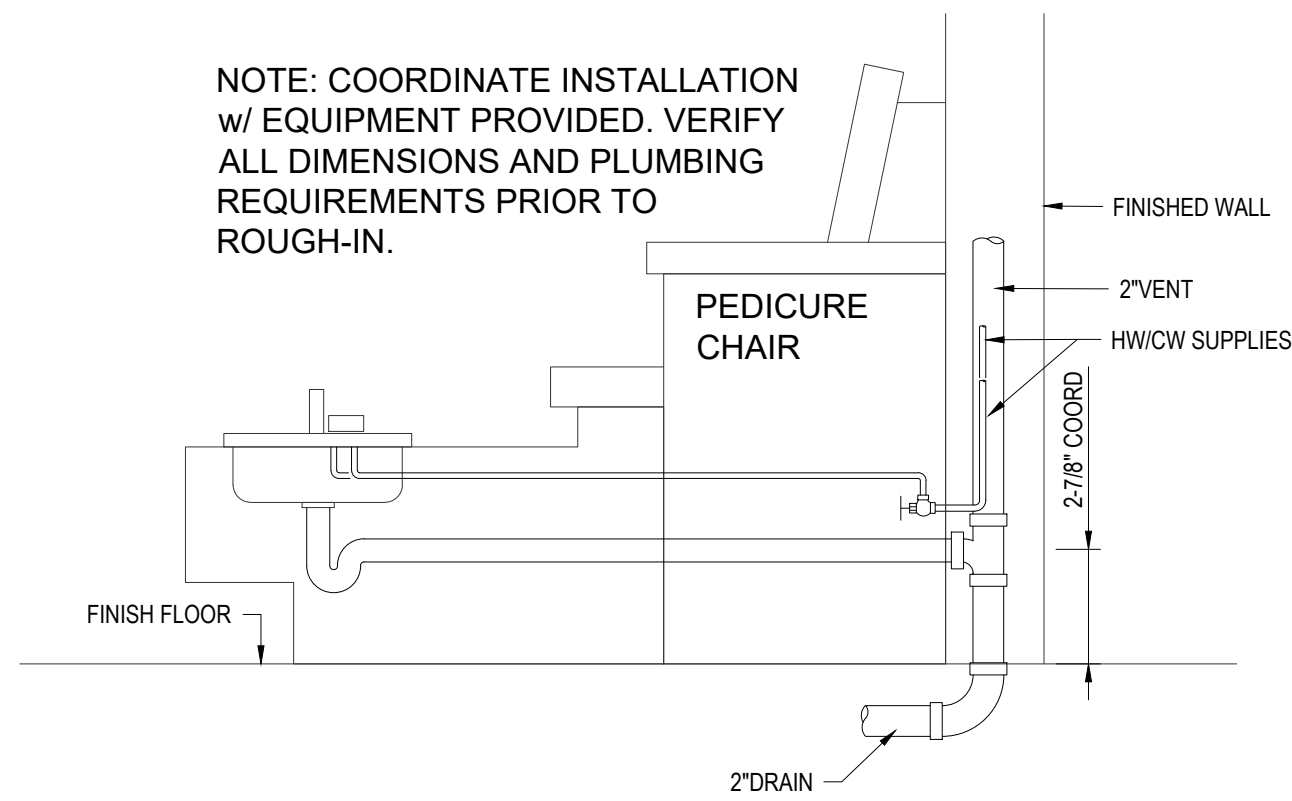


9 **PEDICURE CHAIR DETAIL**
NOT TO SCALE

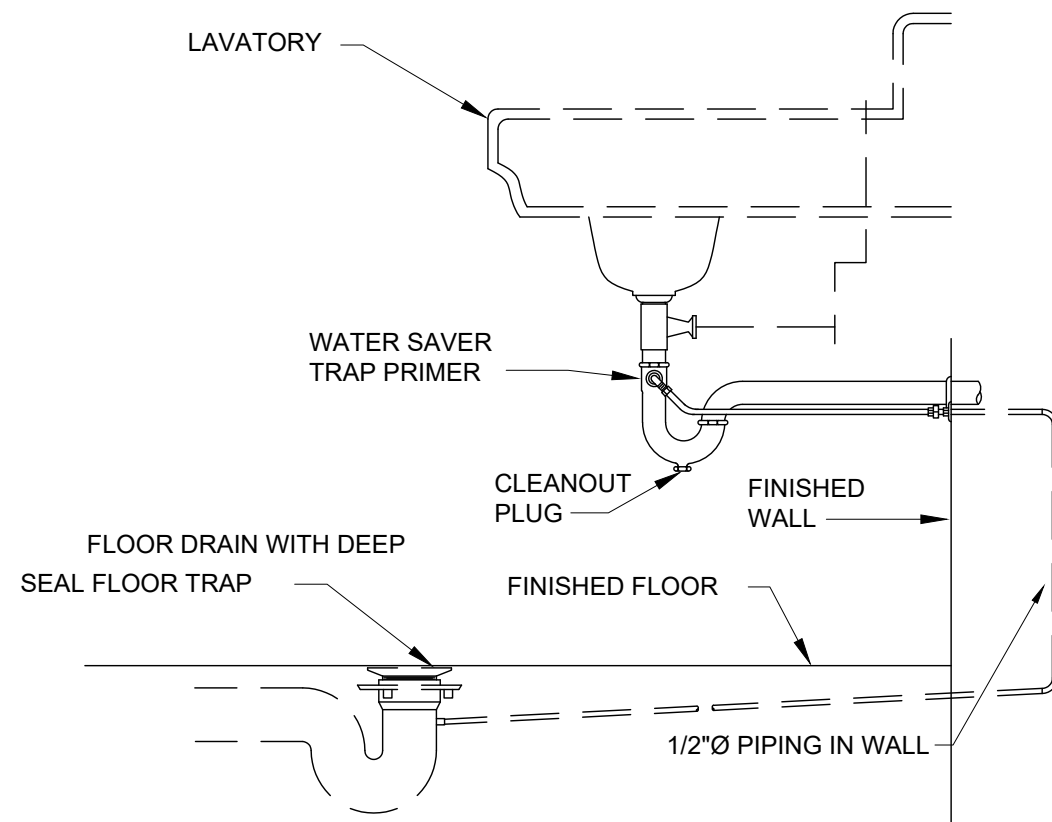

10 **TAILPIECE TRAP PRIMER DETAIL**
NOT TO SCALE

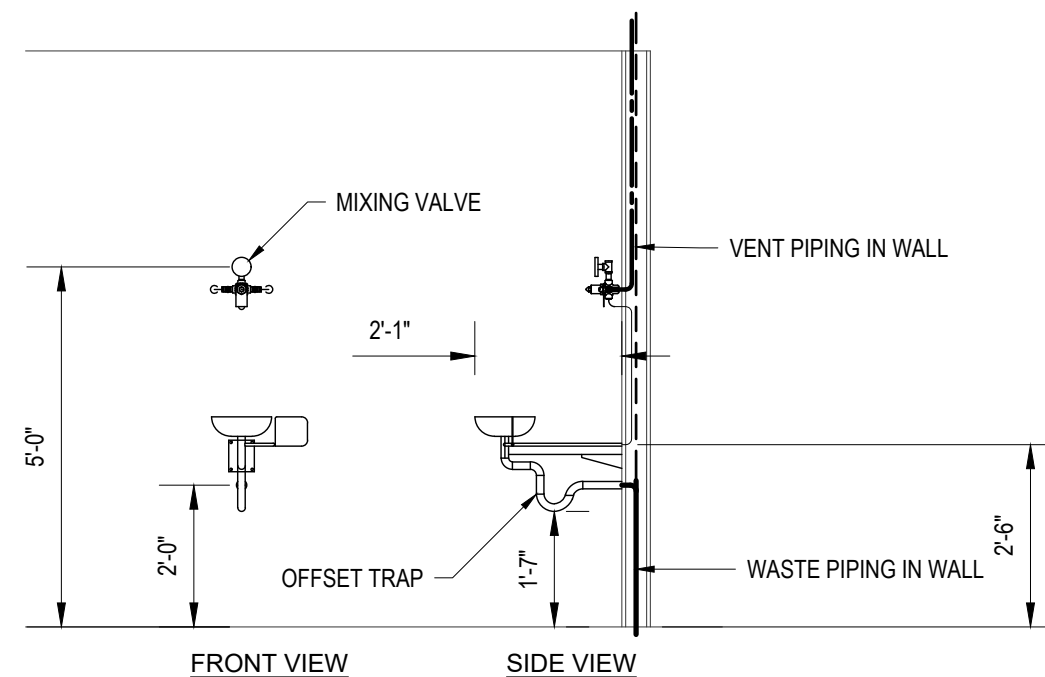


11 **WALL MOUNTED EYEWASH DETAIL**
NOT TO SCALE

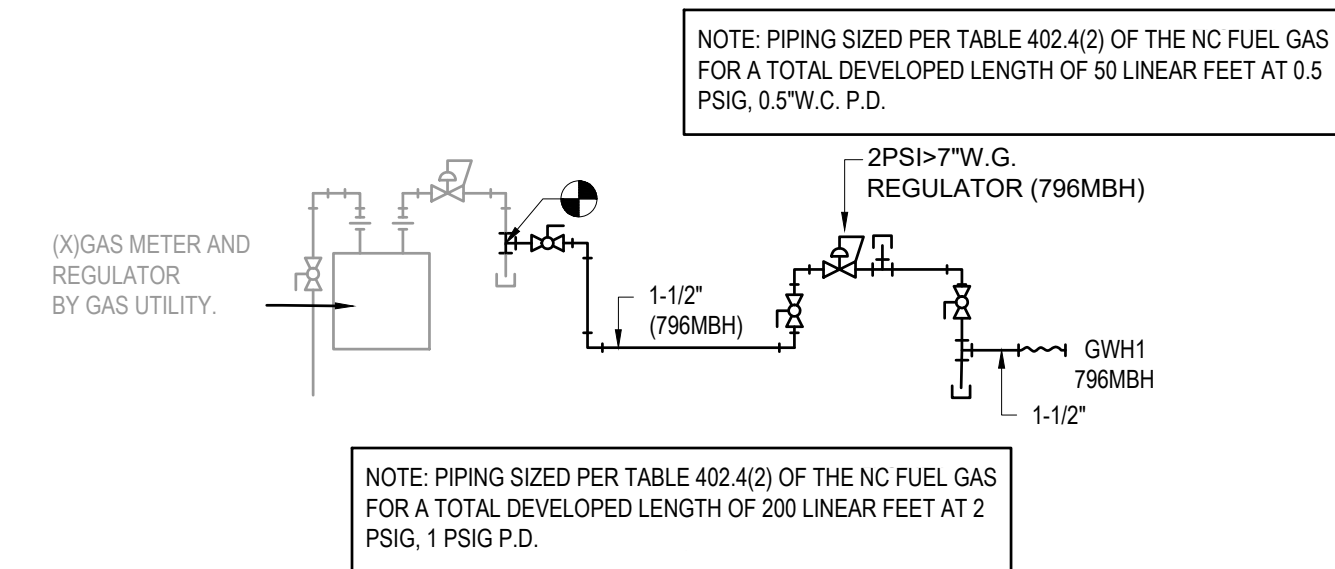


12 **GAS RISER DETAIL**
NOT TO SCALE

Drawing: M:\Projects\22186 - Pruitt Health\22186-PRU-PLUMB-01.dwg Plot Time: 8/25/2025 10:11 AM

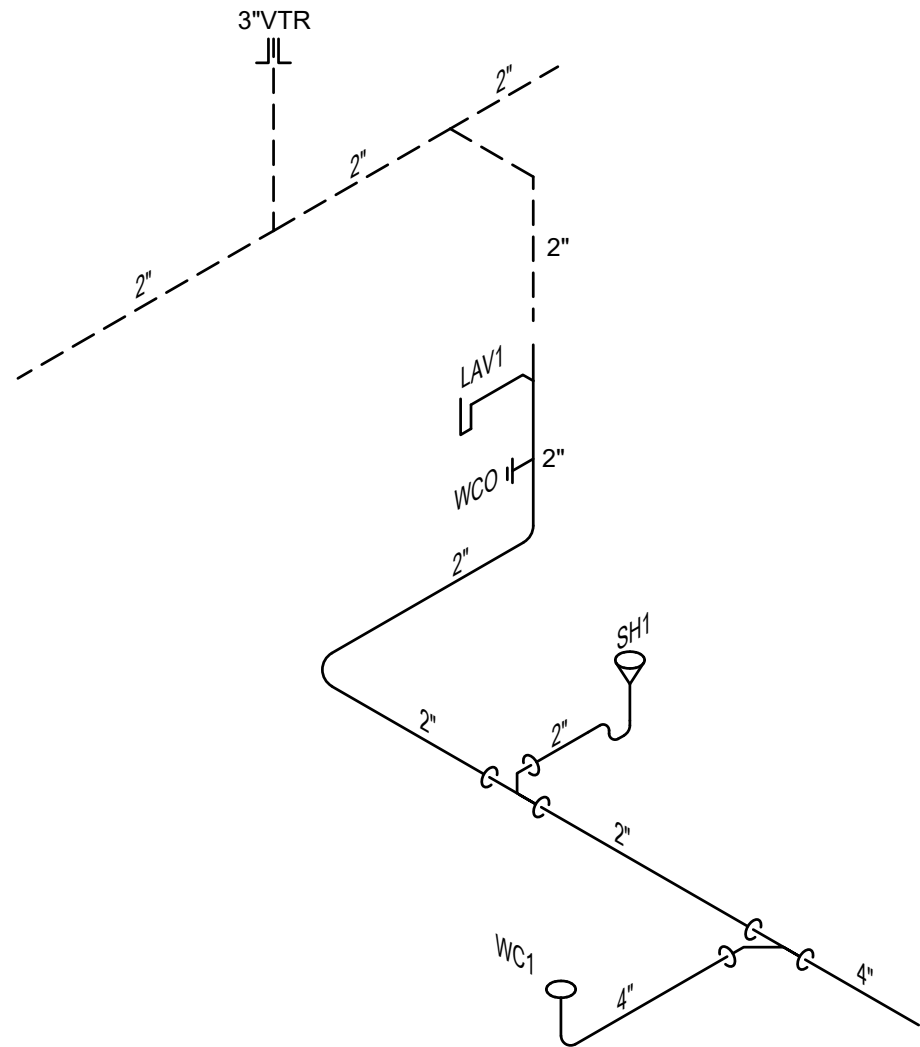

1 - WASTE-VENT RISER DIAGRAM
TYPICAL PRIVATE BEDROOM

NO SCALE

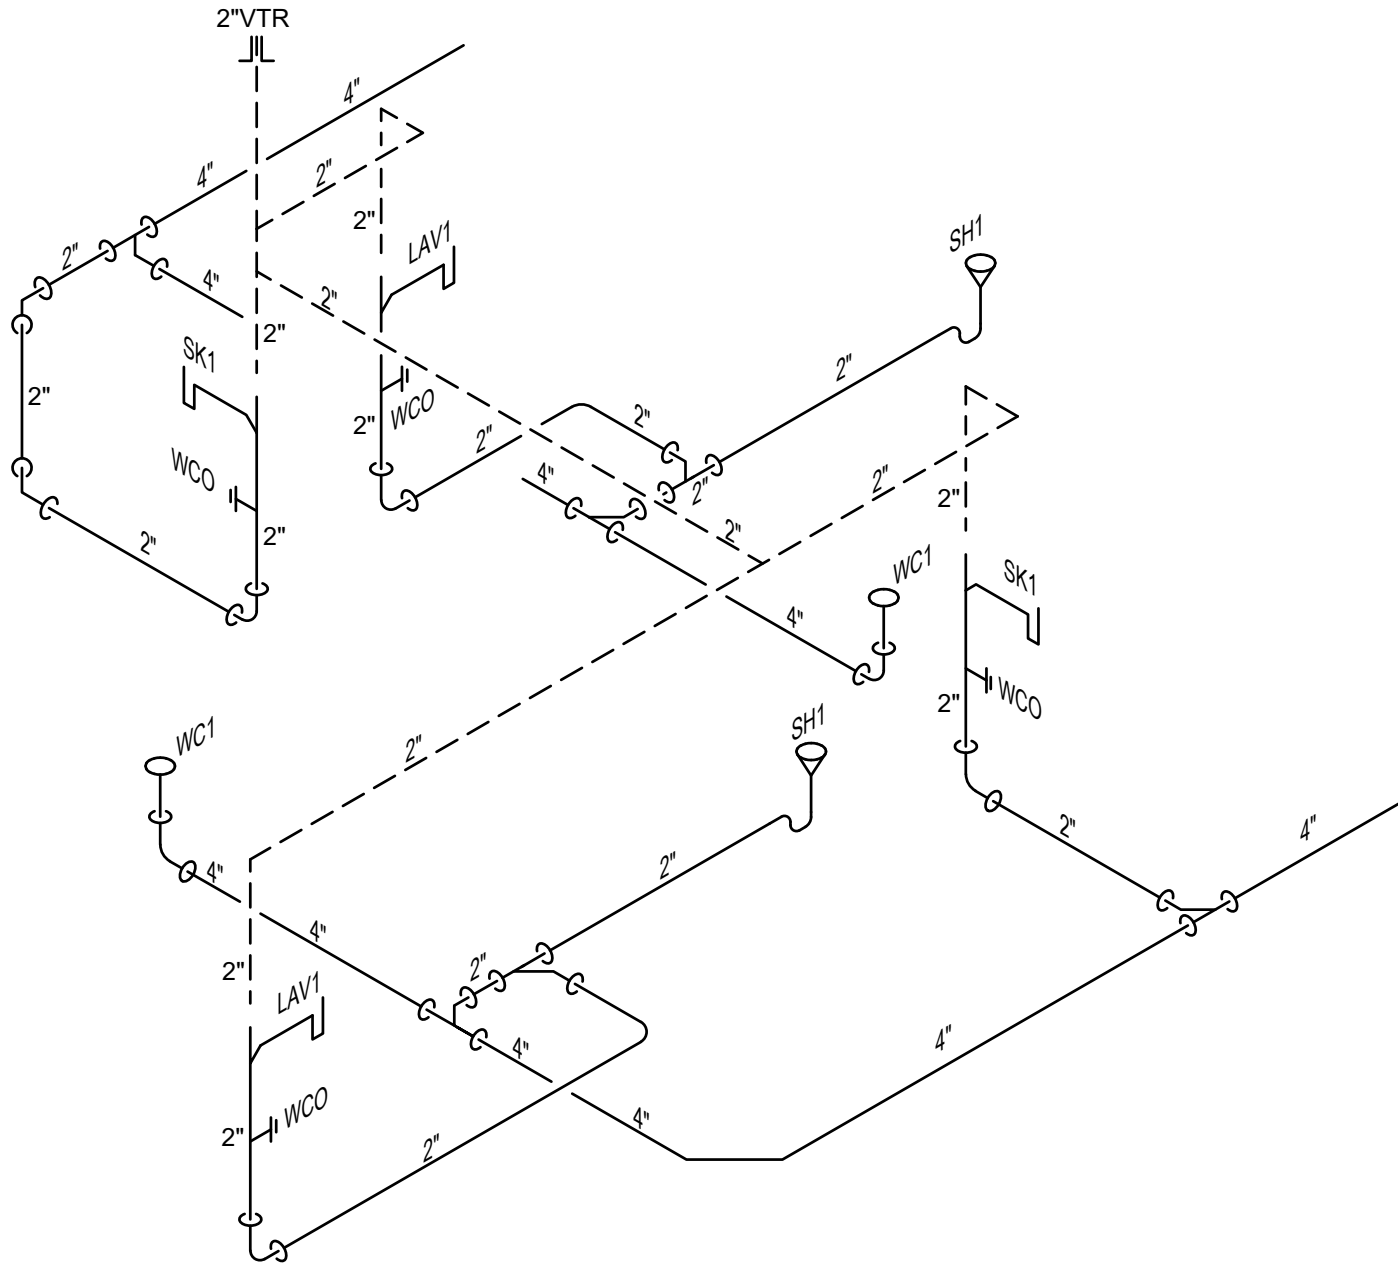

2 - WASTE-VENT RISER DIAGRAM
TYPICAL PRIVATE BEDROOM

NO SCALE

CBHF
Engineers, PLLC

2246 Yaupon Drive
Wilmington, NC 28401

Phone: 910.791.4000
Fax: 910.791.5266
www.cbhfenr.com
NCE P-0266


303 51 BEDROOM ADDITION /RENOVATION PLUMBING RISERS	David R. Polston - Architect 3806 Park Ave. Suite C, Wilmington, NC 28403 Architecture Planning Design	PRUITT HEALTH TOWN CENTER Harrisburg, North Carolina	Professional Engineer Seal NORTH CAROLINA SEAL 10692 BECOM PLUMBING 08/25/2025 ISSUED FOR CONSTRUCTION 08-26-2025
---	---	---	--

GENERAL NOTES - DEMOLITION

1. REFER TO ARCHITECTURAL PHASING PLANS FOR SEQUENCING OF PLUMBING DEMOLITION. MAINTAIN ALL EXISTING PLUMBING IN SERVICE UNTIL REQUIRED BY CONSTRUCTION SEQUENCE.

DEMOLITION KEYED NOTES

- 1 REMOVE ALL PLUMBING FIXTURES IN THIS AREA. CAP WASTE PIPING BELOW SLAB. REMOVE (X)VENT PIPING BACK TO ROOF PENETRATION AND CAP. REMOVE DOMESTIC WATER PIPING BACK TO BRANCH VALVES AT MAIN AND CAP.
- 2 REMOVE ALL PLUMBING FIXTURES IN THIS AREA. CAP WASTE PIPING BELOW SLAB. REMOVE (X)VENT PIPING BACK TO ROOF PENETRATION AND CAP. REMOVE DOMESTIC WATER PIPING BACK TO BRANCH VALVES AT MAIN AND CAP.
- 3 REMOVE SINK IN NOURISHMENT STATION. CAP WASTE PIPING BELOW SLAB. REMOVE VENT PIPING BACK TO ROOF PENETRATION AND CAP. REMOVE DOMESTIC WATER PIPING BACK TO BRANCH VALVES AT MAIN AND CAP.
- 4 REMOVE FLOOR SINK AND CAP WASTE PIPING BELOW SALB.
- 5 REMOVE EXTERIOR HOSE BIBB AND ASSOCIATED PIPING BACK TO SHUT OFF VALVE.
- 6 EXISTING PLUMBING TO REMAIN. MAINTAIN IN SERVICE THROUGHOUT CONSTRUCTION.

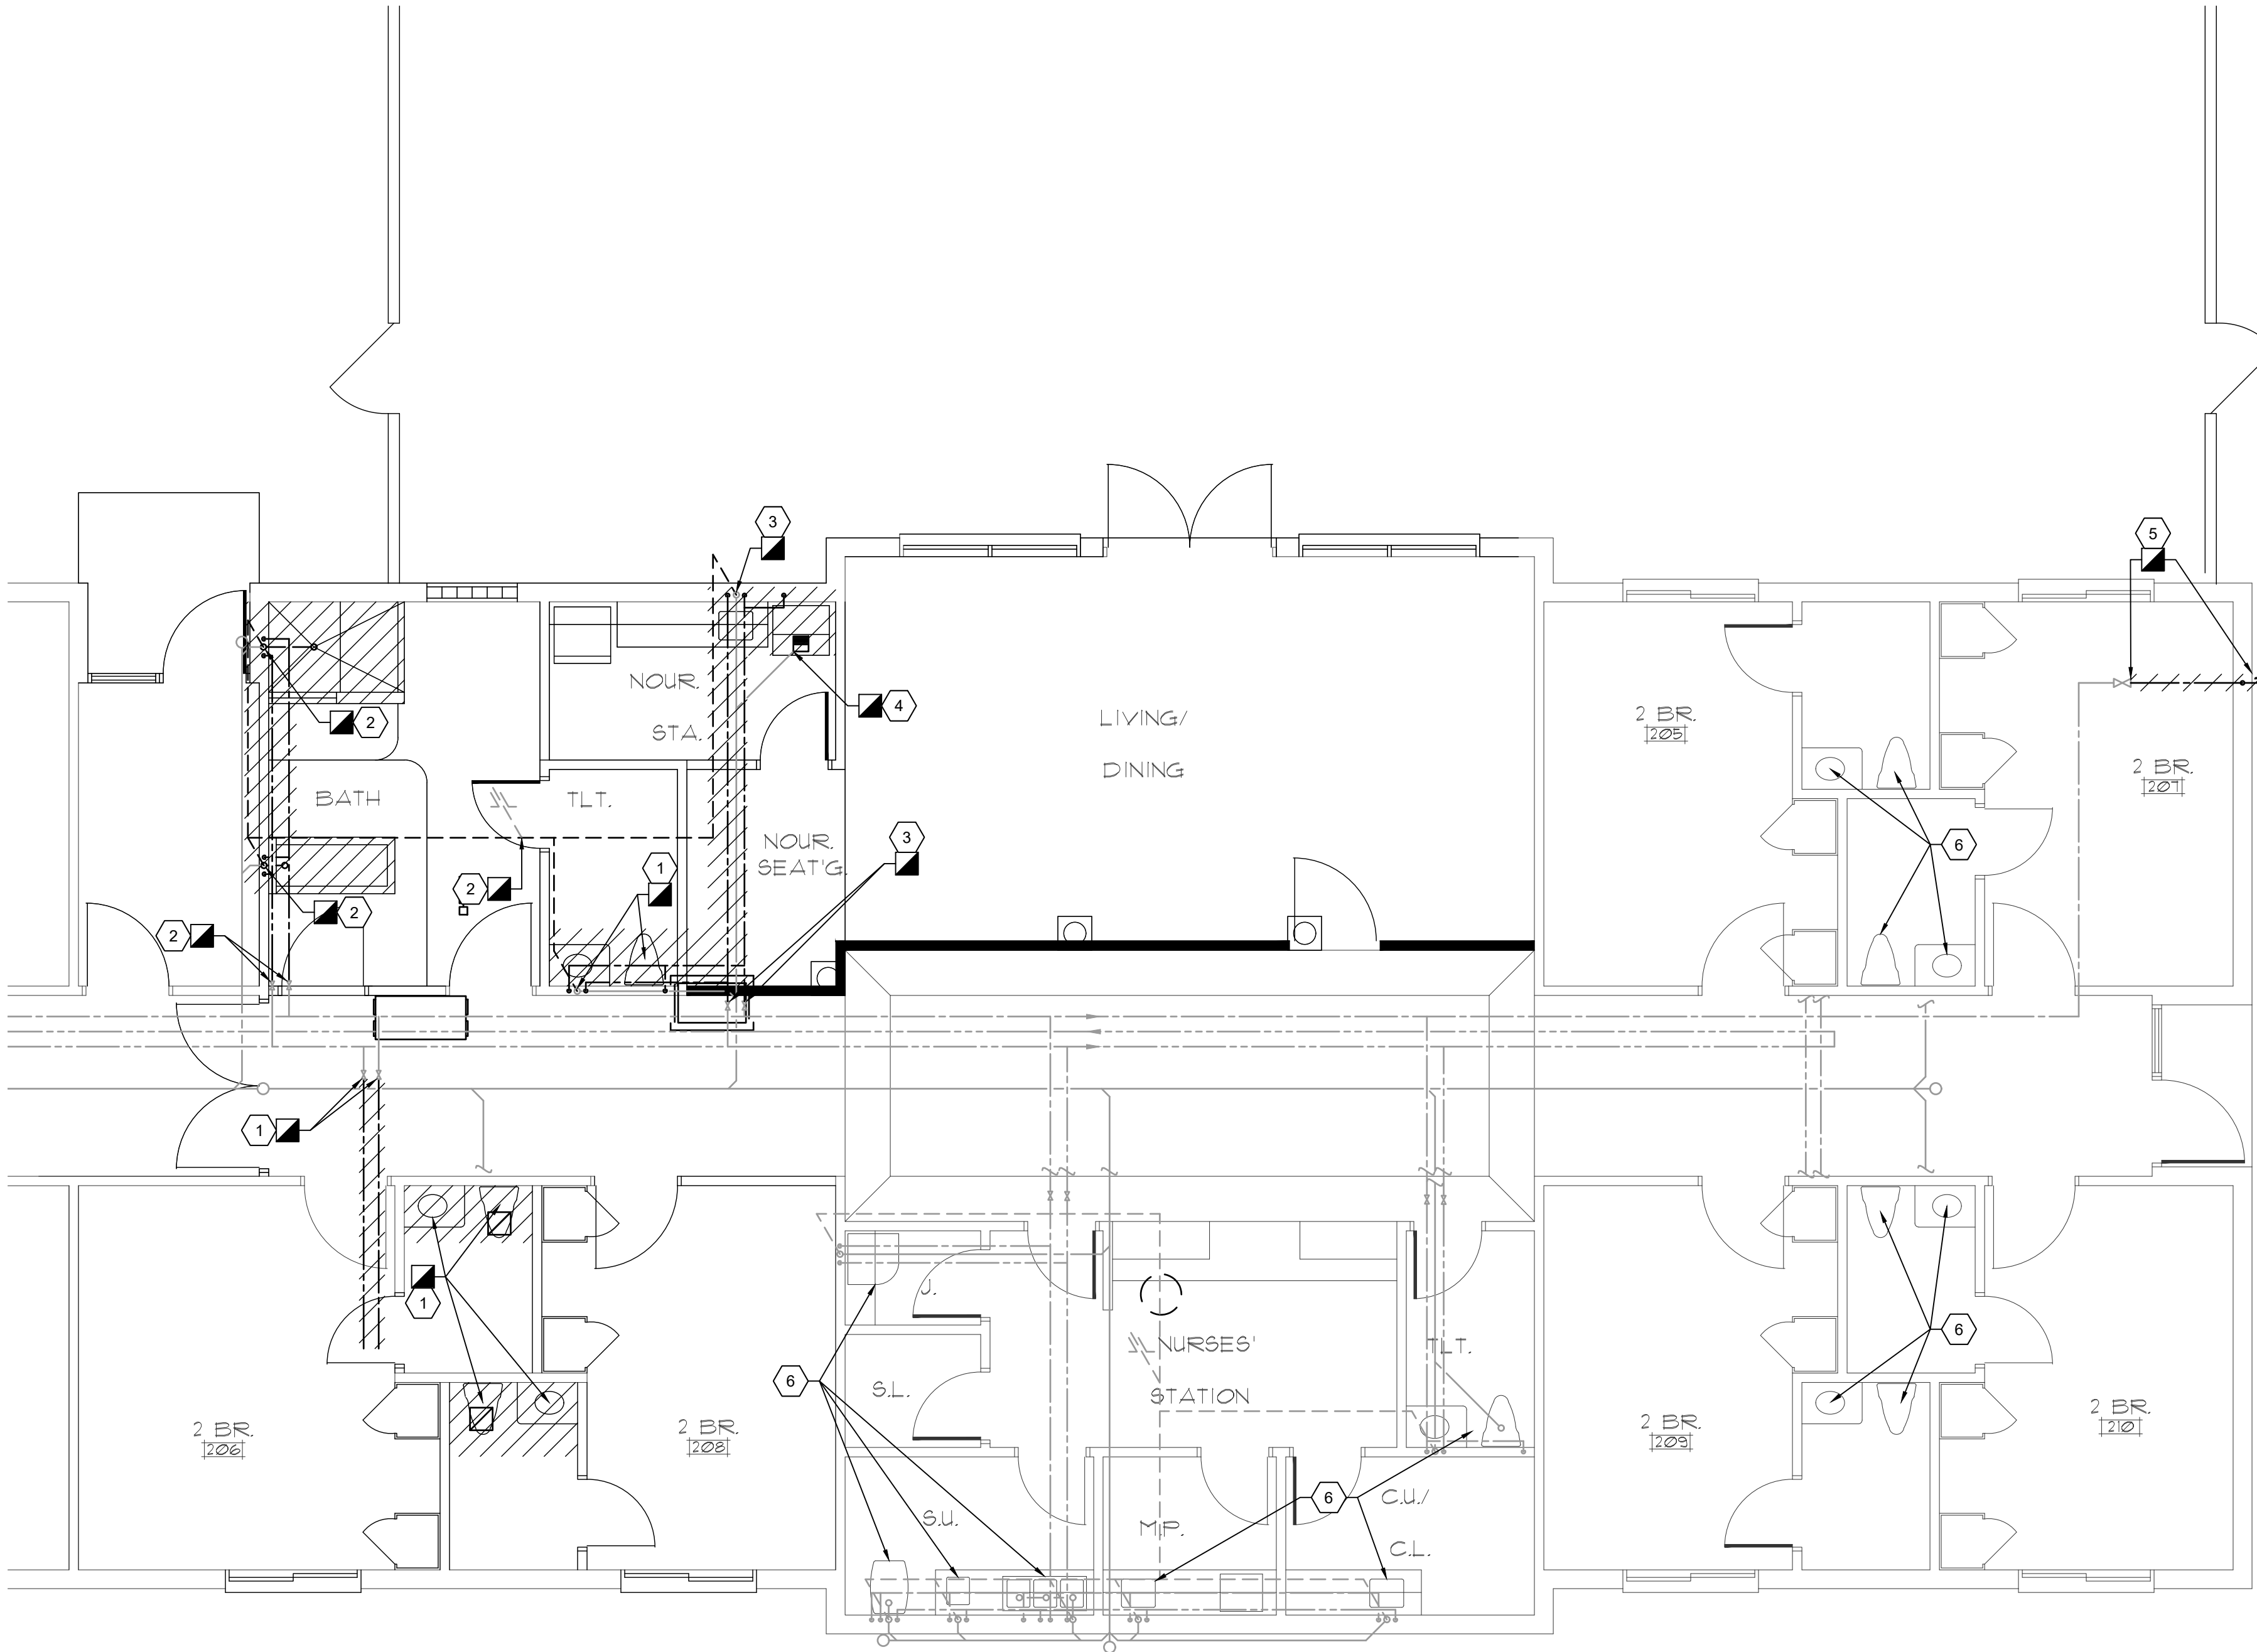


1

PARTIAL DEMOLITION FLOOR PLAN - WING 200

3/16" = 1'-0"


0 4 8 12

PLAN
NORTH

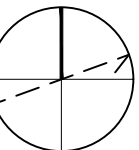

WALL TYPE LEGEND

- 1 HOUR FIRE BARRIER WALL
- 1 HOUR FIRE/SMOKE BARRIER WALL
- 2 HOUR FIRE BARRIER WALL
- SMOKE RESISTANT WALL

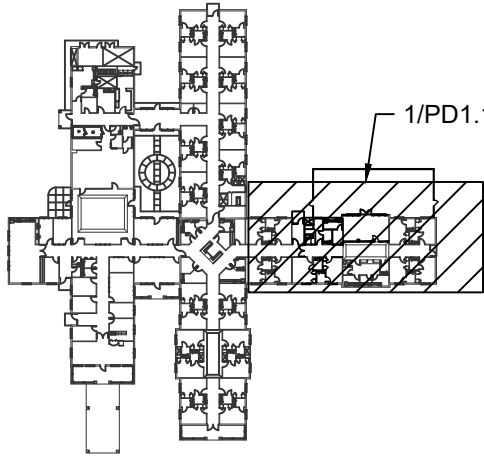

0

KEYPLAN


NOT TO SCALE

GENERAL NOTES - DEMOLITION

1. REFER TO ARCHITECTURAL PHASING PLANS FOR SEQUENCING OF PLUMBING DEMOLITION. MAINTAIN ALL EXISTING PLUMBING IN SERVICE UNTIL REQUIRED BY CONSTRUCTION SEQUENCE.

DEMOLITION KEYED NOTES

- 1 EXISTING GREASE WASTE PIPING TO BE DEMOLISHED ONCE NEW GREASE WASTE SYSTEM IS IN AND OPERATIONAL. COORDINATE TIE-IN TO NEW SYSTEM WITH NEW WORK DRAWINGS.
- 2 EXISTING GREASE TRAP TO BE DEMOLISHED ONCE NEW GREASE TRAP AND GREASE WASTE SYSTEM IS INSTALLED AND OPERATIONAL. COORDINATE TIE-IN TO NEW SYSTEM WITH NEW WORK DRAWINGS.
- 3 REMOVE EXISTING HOSE BIBB AND DCW PIPING BACK TO SHUTOFF VALVE.
- 4 REMOVE EXISTING BEAUTY SALON FIXTURES AND ASSOCIATED WASTE, VENT AND WATER PIPING AS INDICATED ON DRAWINGS. CAP LINES AS REQUIRED. SEE NEW WORK DRAWINGS FOR ADDITIONAL INFORMATION.
- 5 REMOVE EXISTING PHYSICAL THERAPY FIXTURES AND ASSOCIATED WASTE, VENT AND WATER PIPING AS INDICATED ON DRAWINGS. CAP LINES AS REQUIRED. SEE NEW WORK DRAWINGS FOR ADDITIONAL INFORMATION.

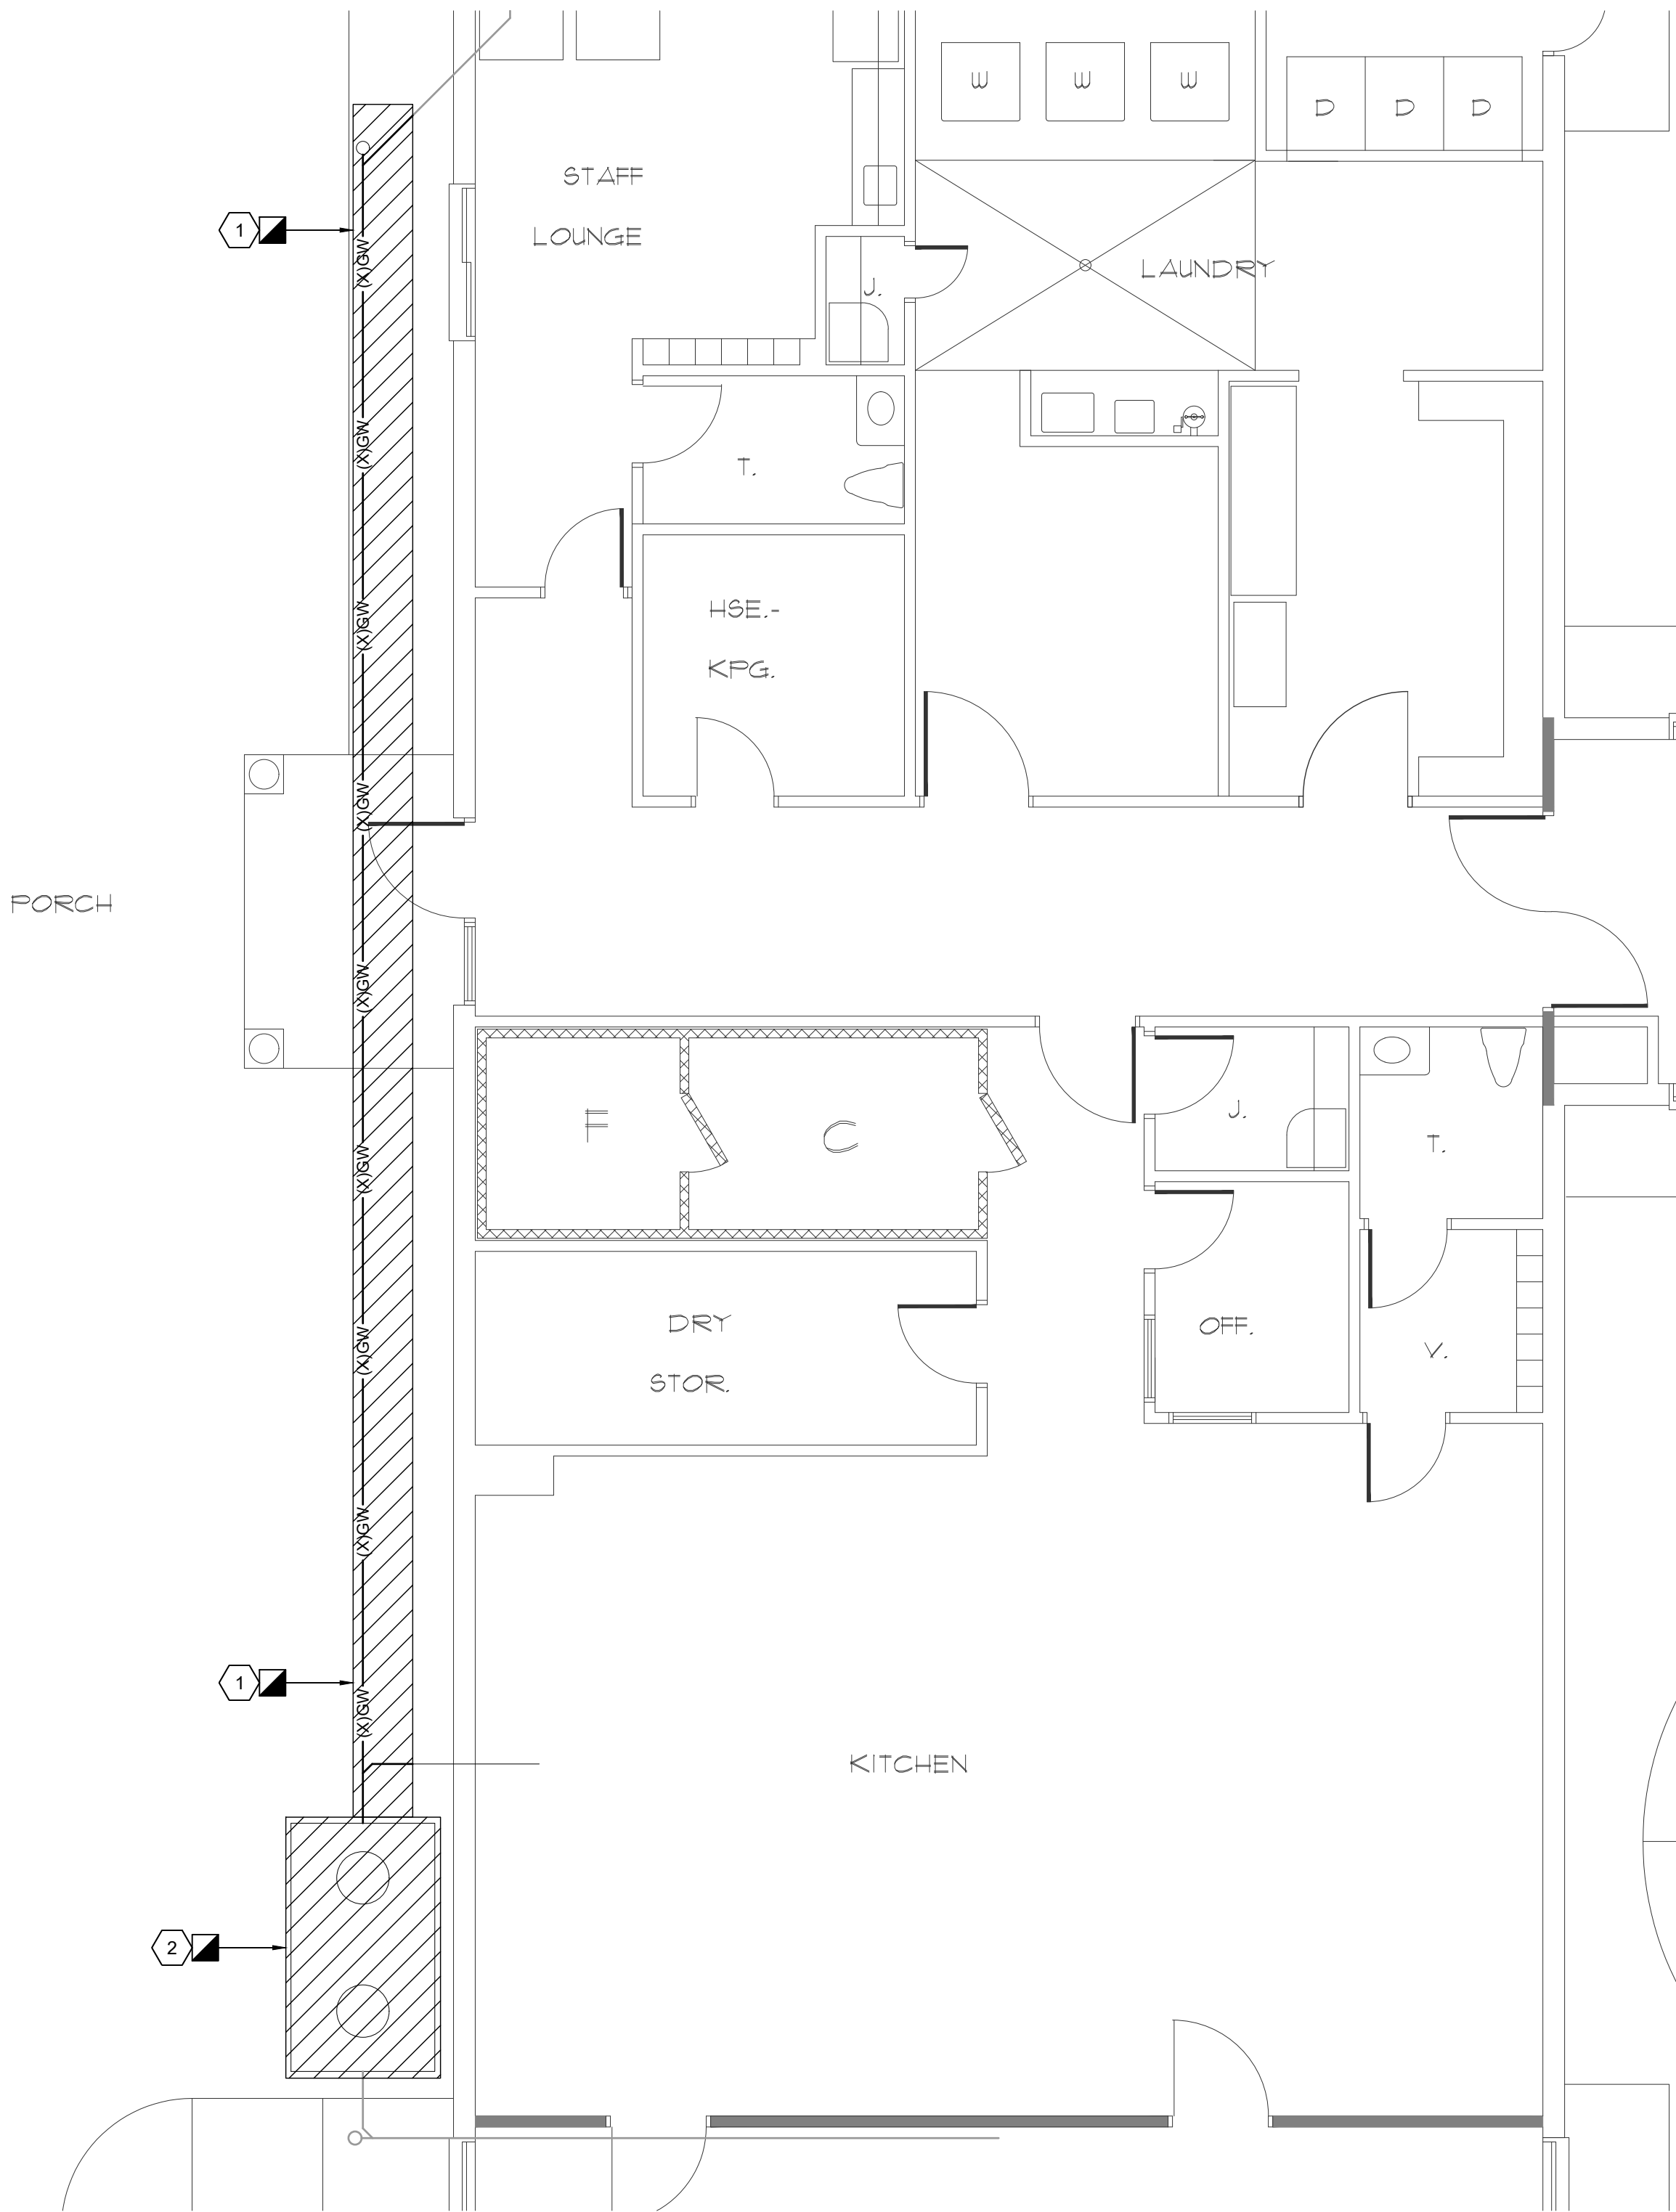


1

PARTIAL DEMOLITION FLOOR PLAN - KITCHEN AREA

3/16" = 1'-0"

0 4' 8' 12'

PLAN
NORTH

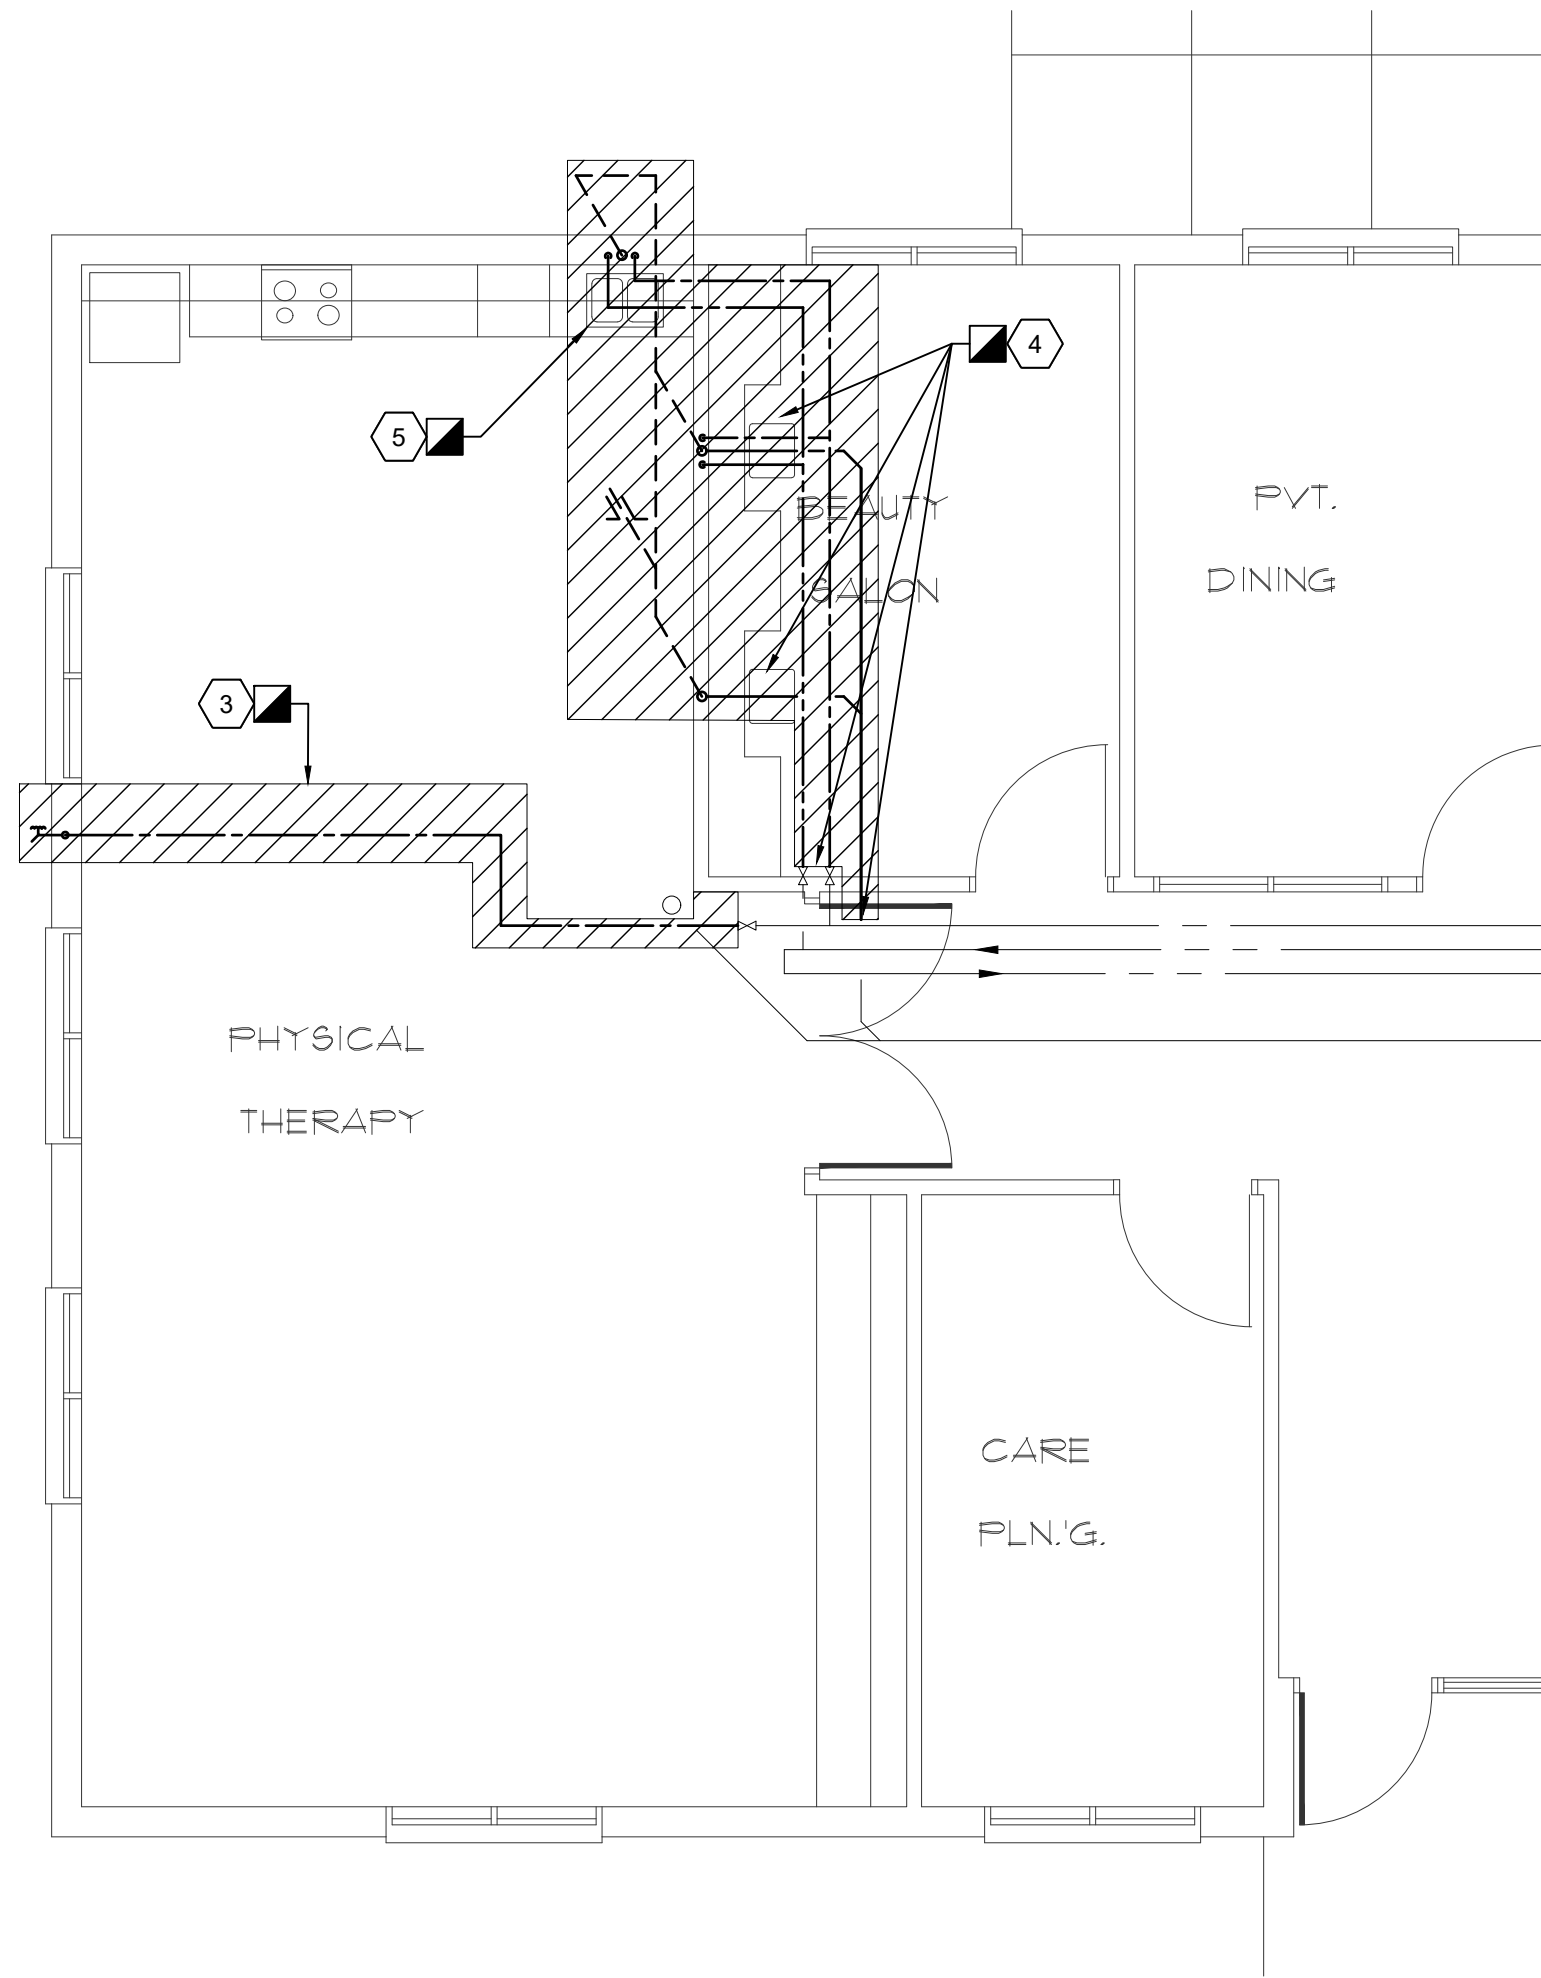

2

PARTIAL DEMOLITION FLOOR PLAN - PHYSICAL THERAPY AREA


3/16" = 1'-0"

0 4' 8' 12'

PLAN
NORTH

WALL TYPE LEGEND

	1 HOUR FIRE BARRIER WALL
	1 HOUR FIRE/SMOKE BARRIER WALL
	2 HOUR FIRE BARRIER WALL
	SMOKE RESISTANT WALL

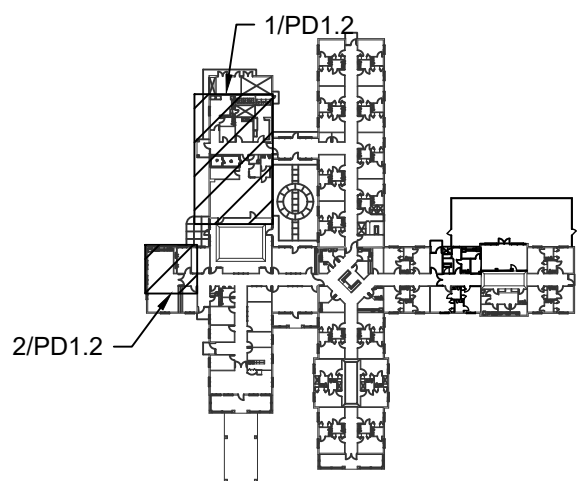

0

KEYPLAN

NOT TO SCALE


GENERAL NOTES - RENOVATION

1. REFER TO ARCHITECTURAL PHASING PLANS FOR SEQUENCING OF PLUMBING RENOVATIONS. MAINTAIN ALL EXISTING PLUMBING IN SERVICE UNTIL REQUIRED BY CONTRSTRUCTION SEQUENCE.
2. COMBINE PLUMBING VENTS IN ATTIC PER CODE TO VTR. MAINTAIN 25 FEET SEPARATION FROM ALL AIR INTAKES.

CBHF
Engineers, PLLC

2246 Yaupon Drive
Wilmington, NC 28401
© Copyright 2025 CBHF Engineers, PLLC

Phone: 910.791.4000
Fax: 910.791.5266
www.cbhfinders.com
NCE P-0506

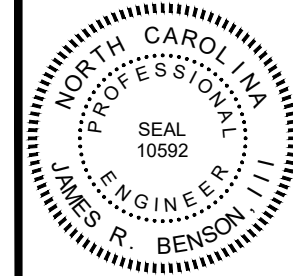


ISSUED FOR
CONSTRUCTION
08-26-2025

**PRUITT HEALTH
TOWN CENTER**
Harrisburg, North Carolina

David R. Polston - Architect
3806 Park Ave. Suite C, Wilmington, NC 28403
Architecture Planning Design

5TH BEDROOM ADDITION
/RENOVATION
PLUMBING RENO
PARTIAL SEWER PLANS


**PS
1.1**

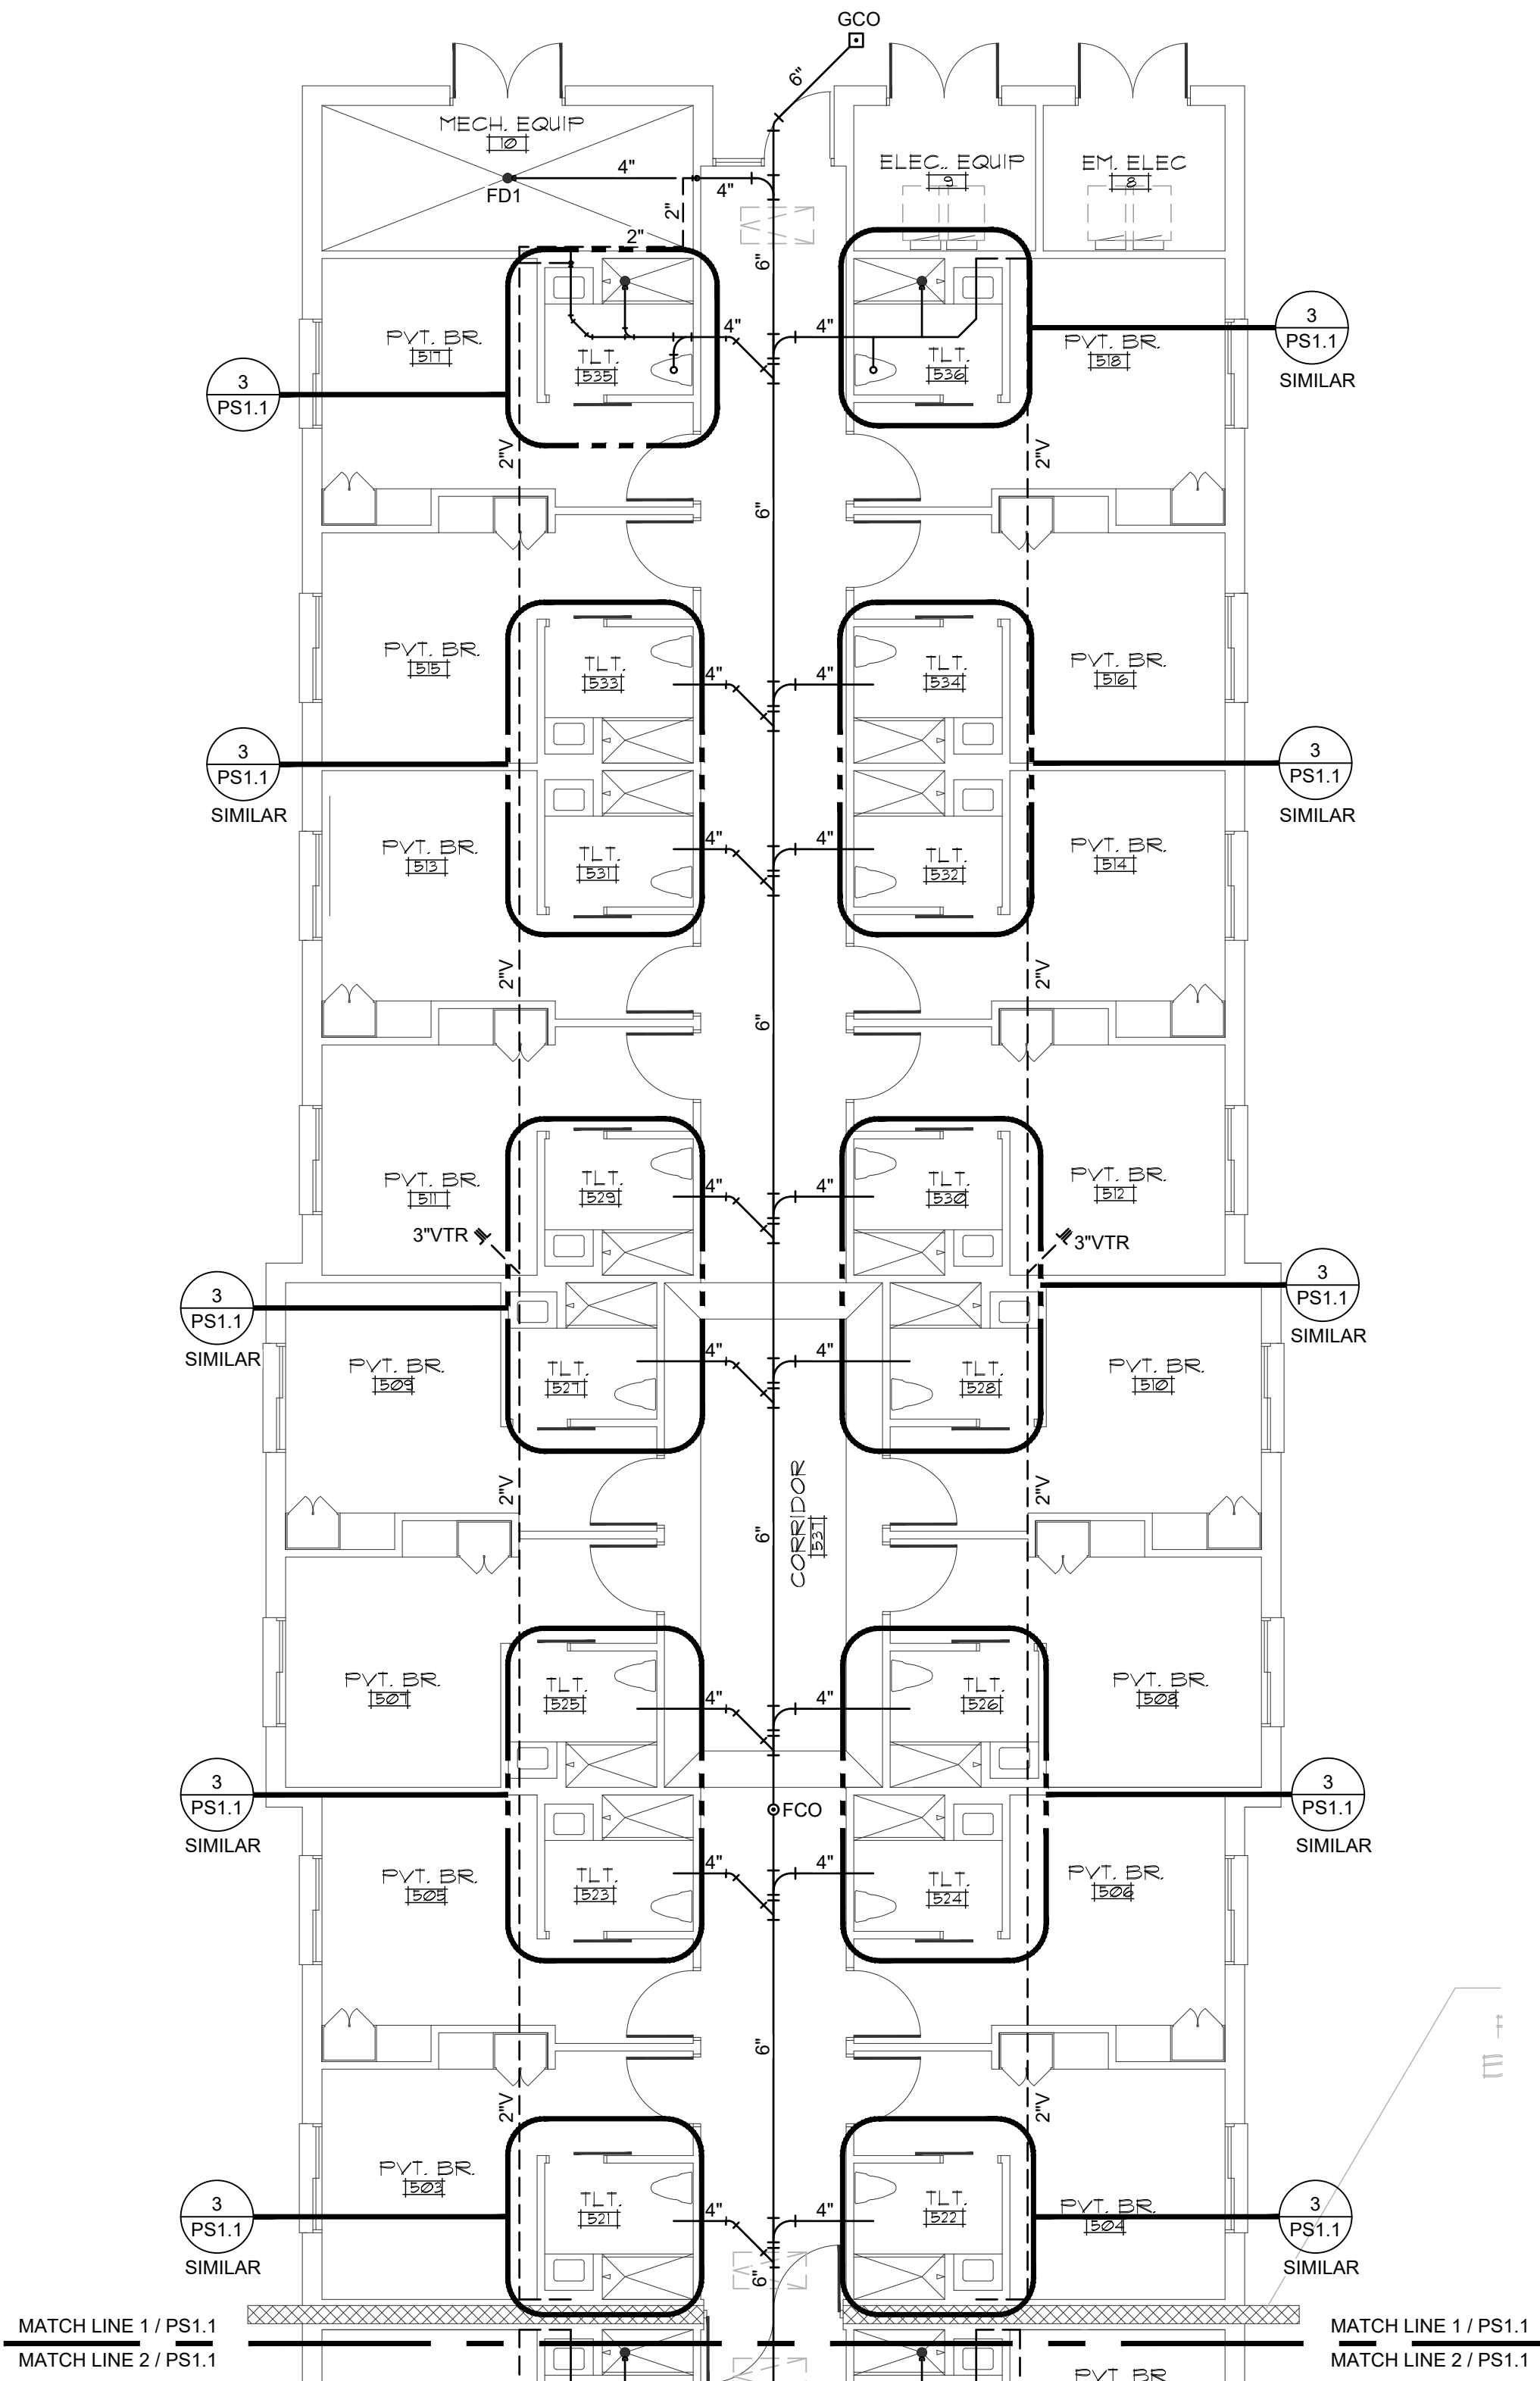

1 PARTIAL FLOOR PLAN - WING 500

1/8" = 1'-0"

PLAN
NORTH

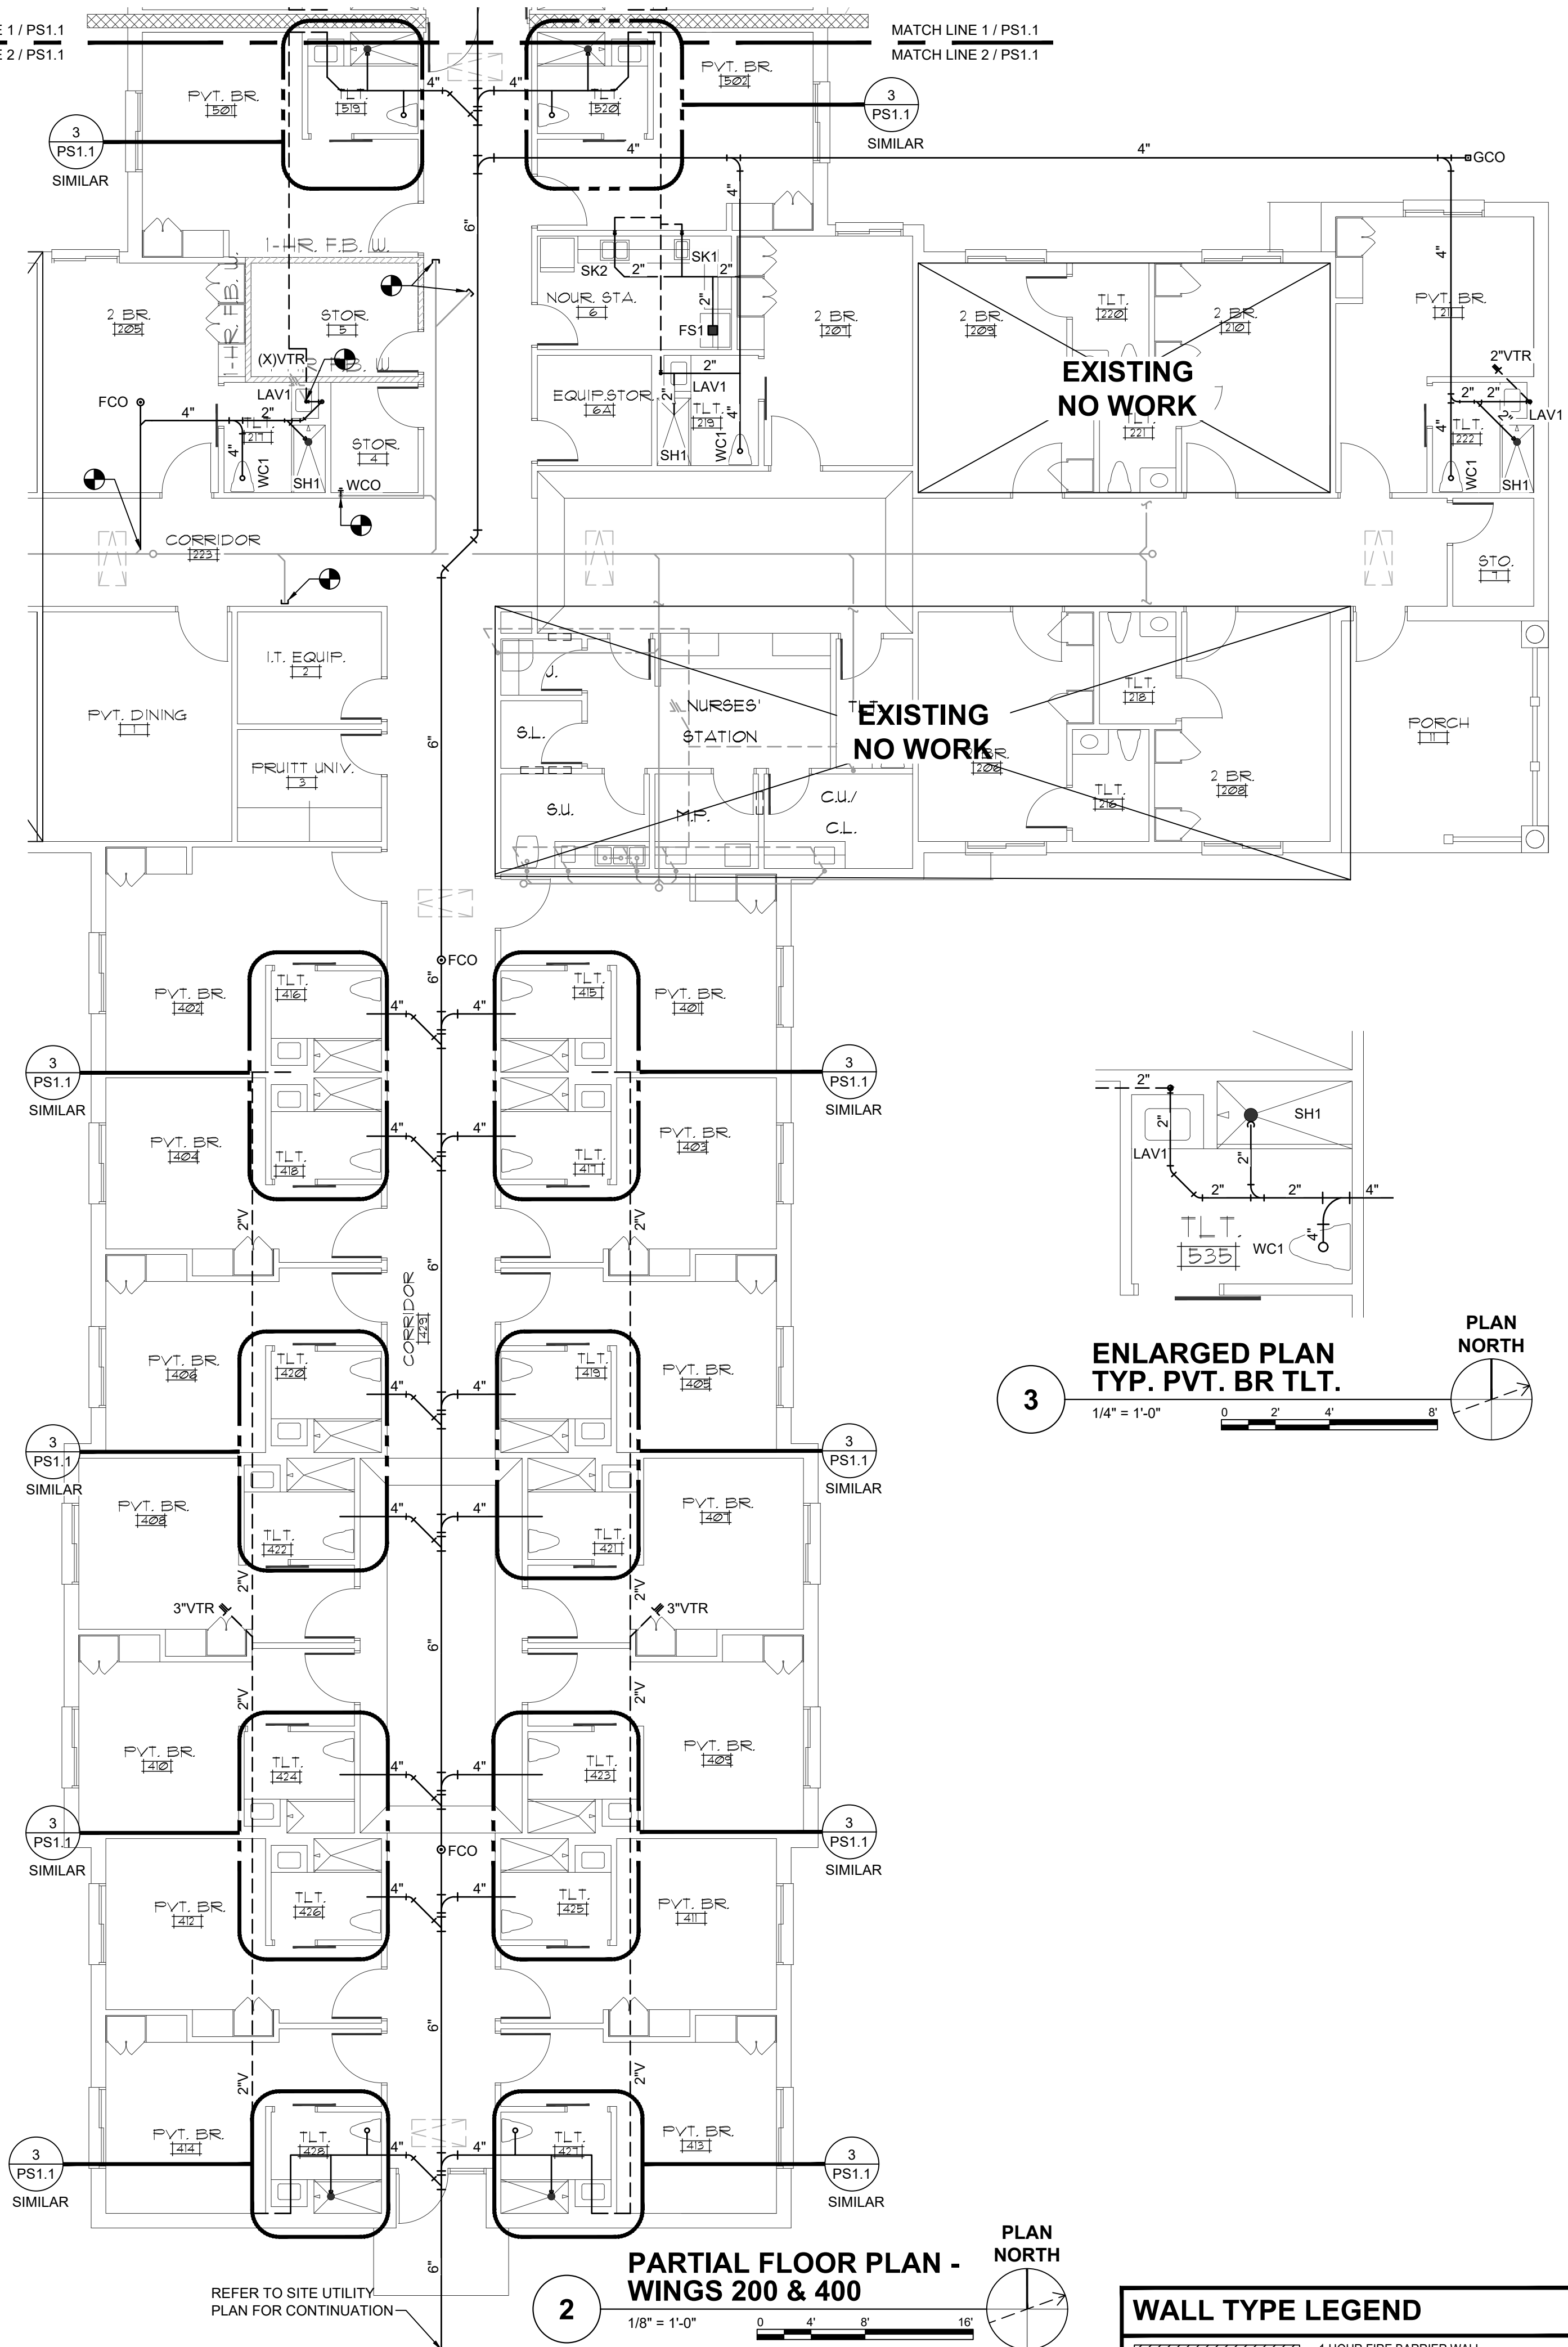


**2 PARTIAL FLOOR PLAN -
WINGS 200 & 400**

1/8" = 1'-0"

PLAN
NORTH

WALL TYPE LEGEND


- 1 HOUR FIRE BARRIER WALL
- 1 HOUR FIRE/SMOKE BARRIER WALL
- 2 HOUR FIRE BARRIER WALL
- SMOKE RESISTANT WALL

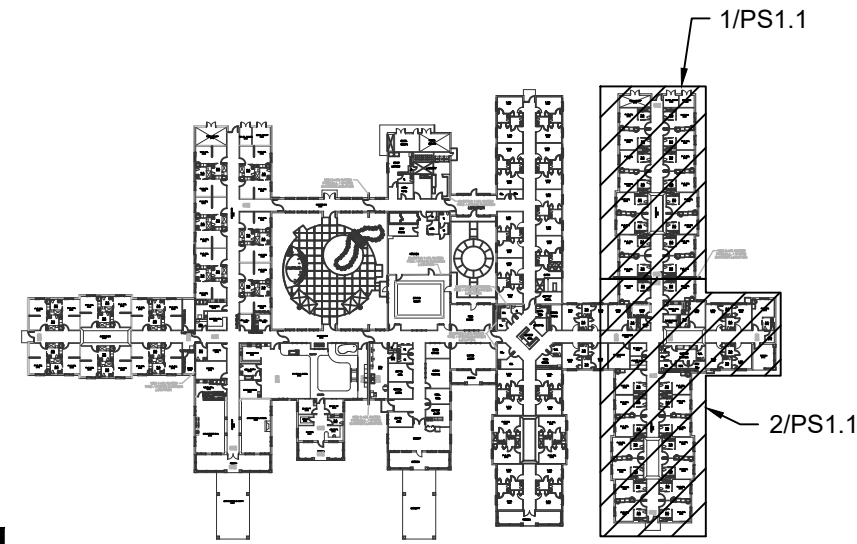

0 KEYPLAN
NOT TO SCALE




- GENERAL NOTES - RENOVATION**
- REFER TO ARCHITECTURAL PHASING PLANS FOR SEQUENCING OF PLUMBING RENOVATIONS. MAINTAIN ALL EXISTING PLUMBING IN SERVICE UNTIL REQUIRED BY CONSTRUCTION SEQUENCE.
 - COMBINE PLUMBING VENTS IN ATTIC PER CODE TO VTR. MAINTAIN 25 FEET SEPARATION FROM ALL AIR INTAKES.

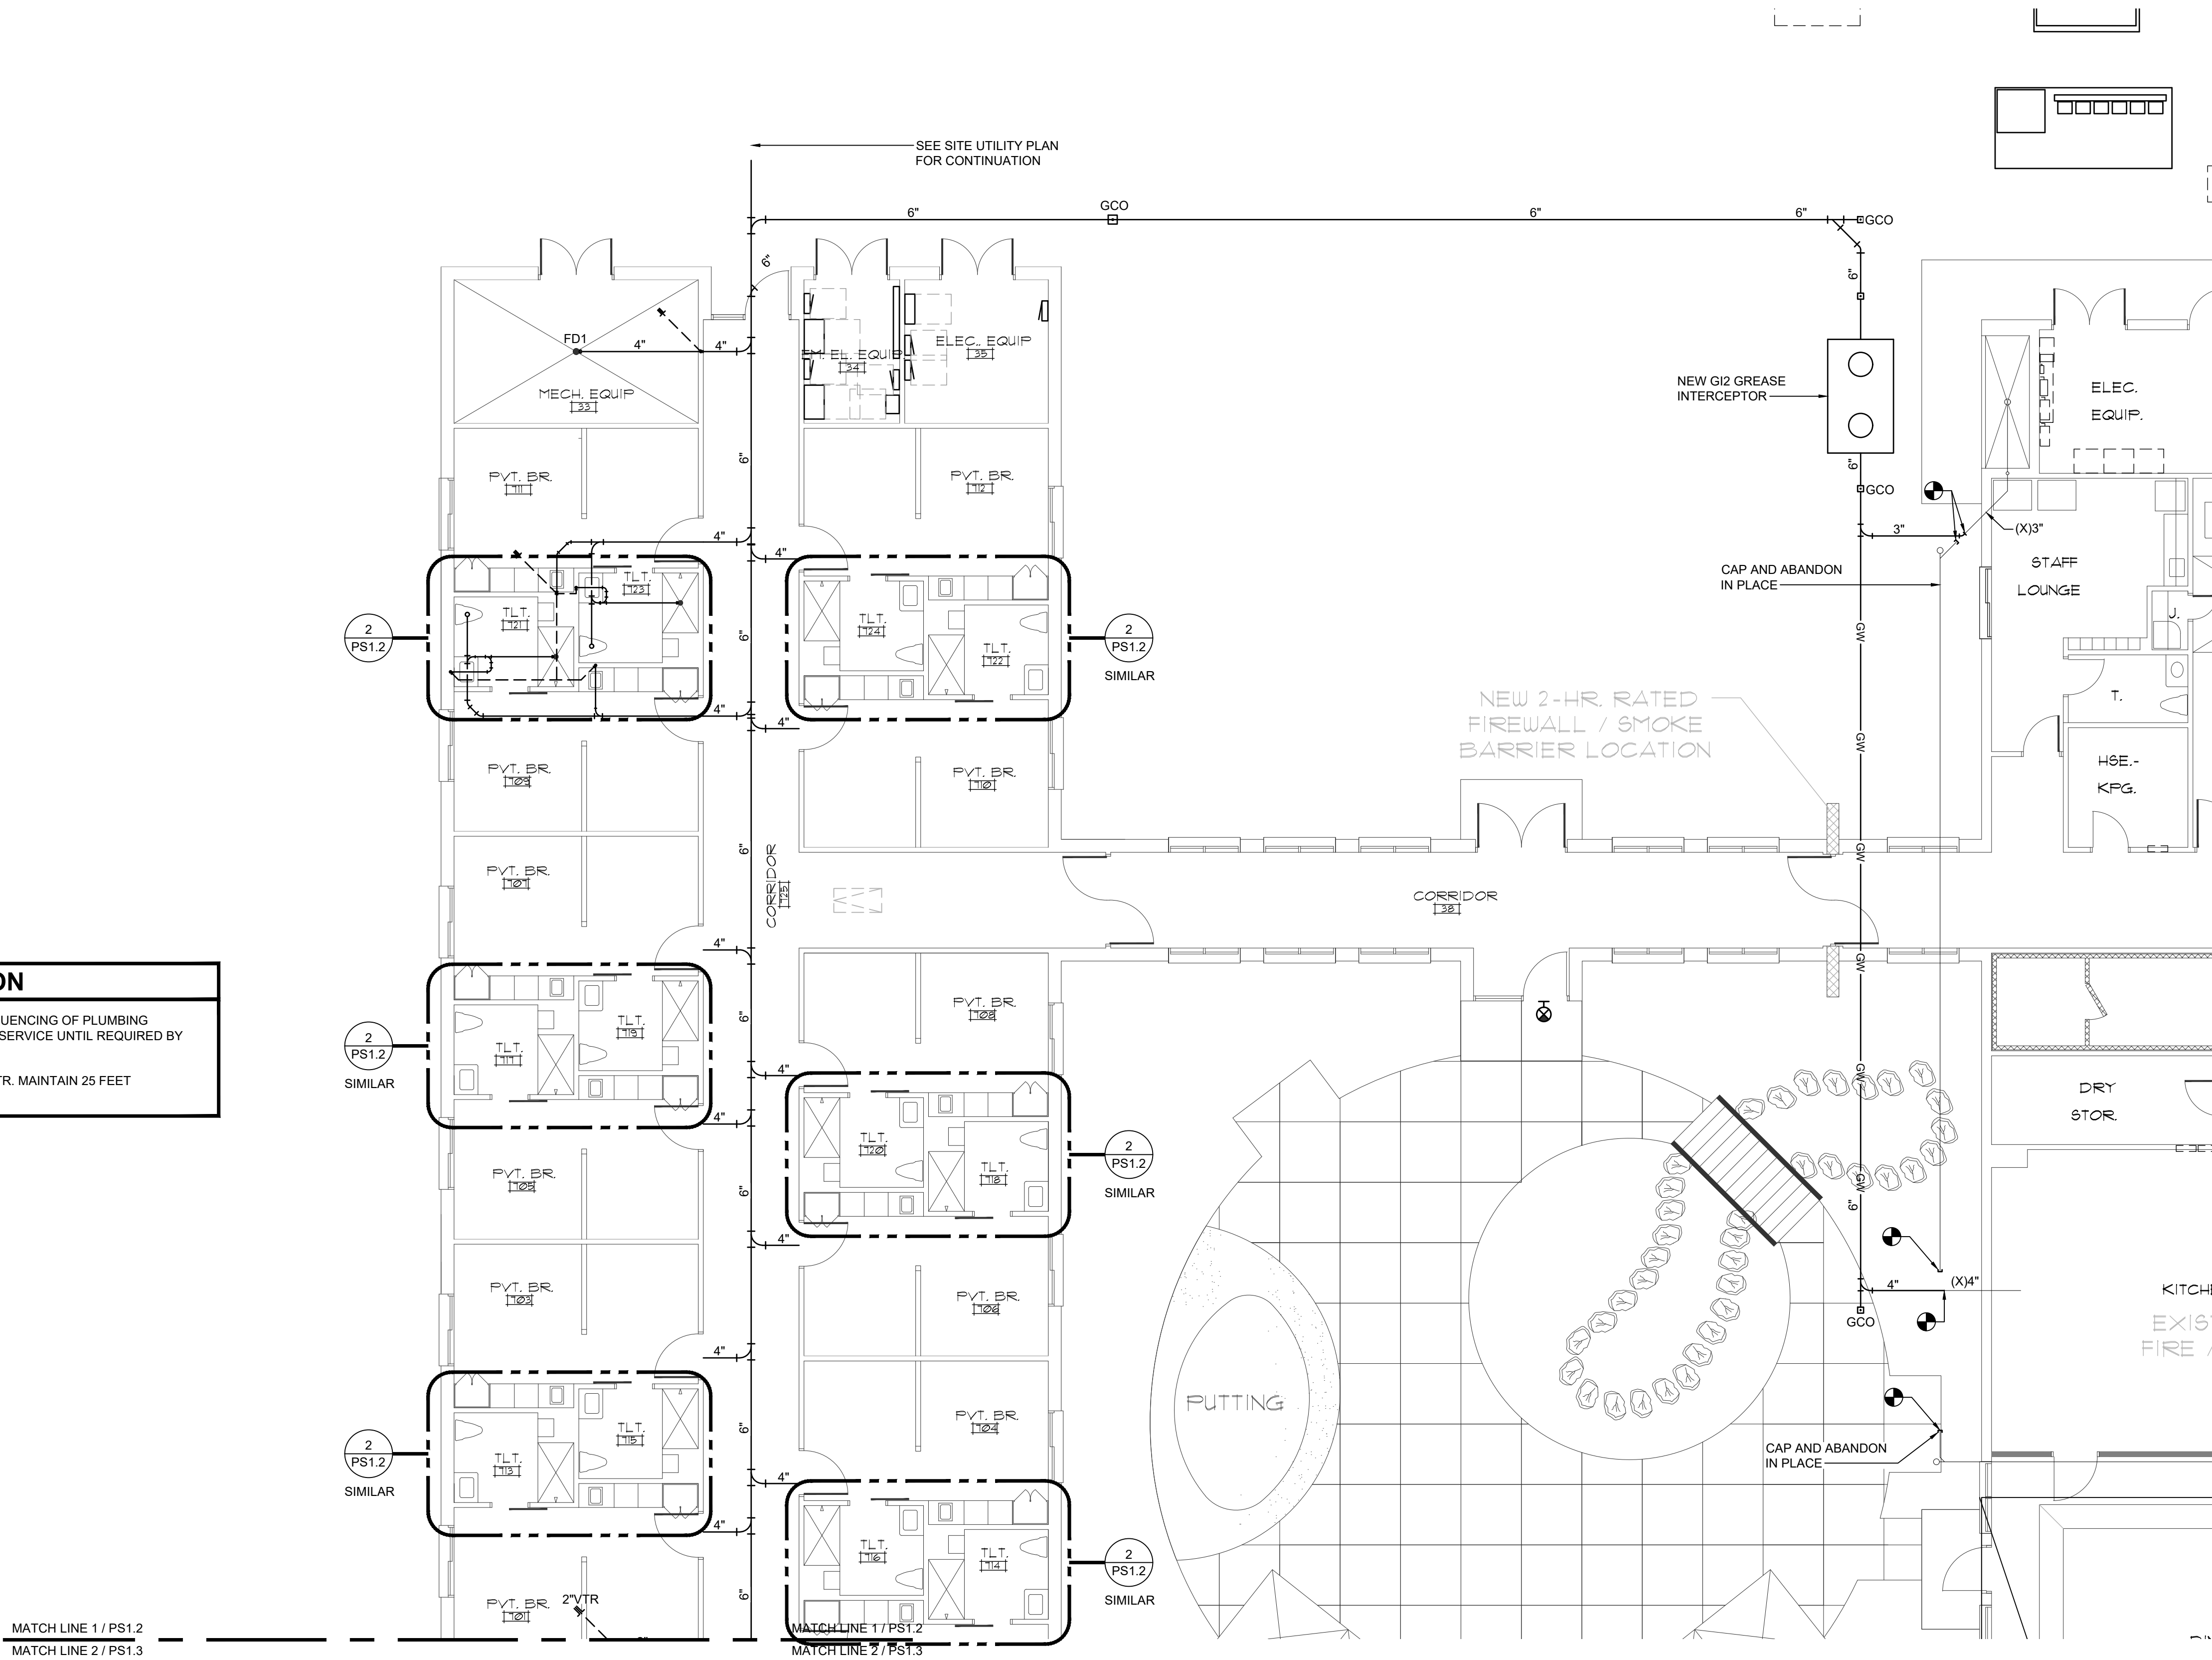

1 PARTIAL FLOOR PLAN - WING 700
1/8" = 1'-0"
0 4' 8' 16'
PLAN NORTH

WALL TYPE LEGEND	
	1 HOUR FIRE BARRIER WALL
	1 HOUR FIRE/SMOKE BARRIER WALL
	2 HOUR FIRE BARRIER WALL
	SMOKE RESISTANT WALL

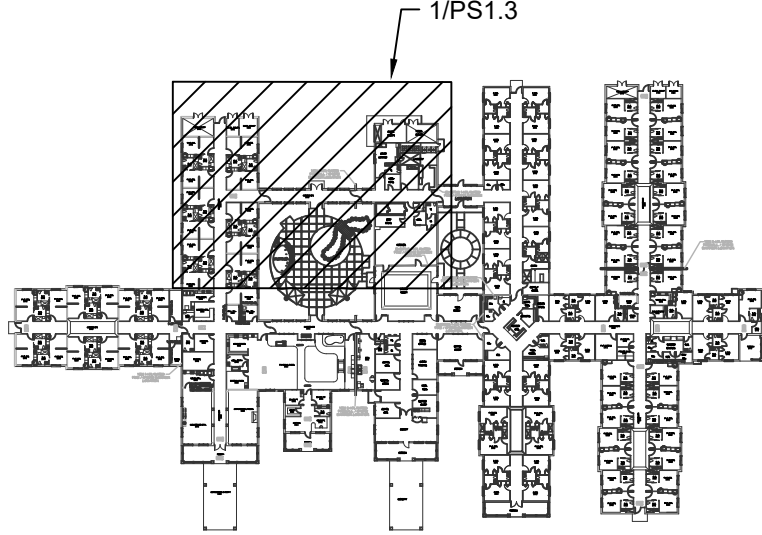

0 KEYPLAN
NOT TO SCALE


GENERAL NOTES - RENOVATION

1. REFER TO ARCHITECTURAL PHASING PLANS FOR SEQUENCING OF PLUMBING RENOVATIONS. MAINTAIN ALL EXISTING PLUMBING IN SERVICE UNTIL REQUIRED BY CONTRSTRUCTION SEQUENCE.

CBHF
Engineers, PLLC

2246 Yaupon Drive
Wilmington, NC 28401
© Copyright 2025 CBHF Engineers, PLLC

Phone: 910.791.4000
Fax: 910.791.5266
www.cbhfindesign.com
NCE P-0266

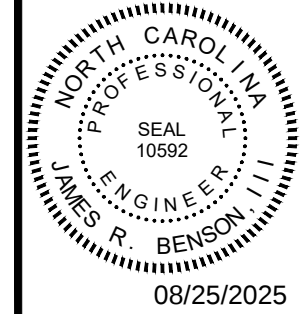


ISSUED FOR
CONSTRUCTION
08-26-2025

**PRUITT HEALTH
TOWN CENTER**
Harrisburg, North Carolina

David R. Polston - Architect
3806 Park Ave. Suite C, Wilmington, NC 28403
Architecture Planning Design

51 BEDROOM ADDITION
/ RENOVATION
PLUMBING RENO
PARTIAL WATER PLANS


**PW
1.1**

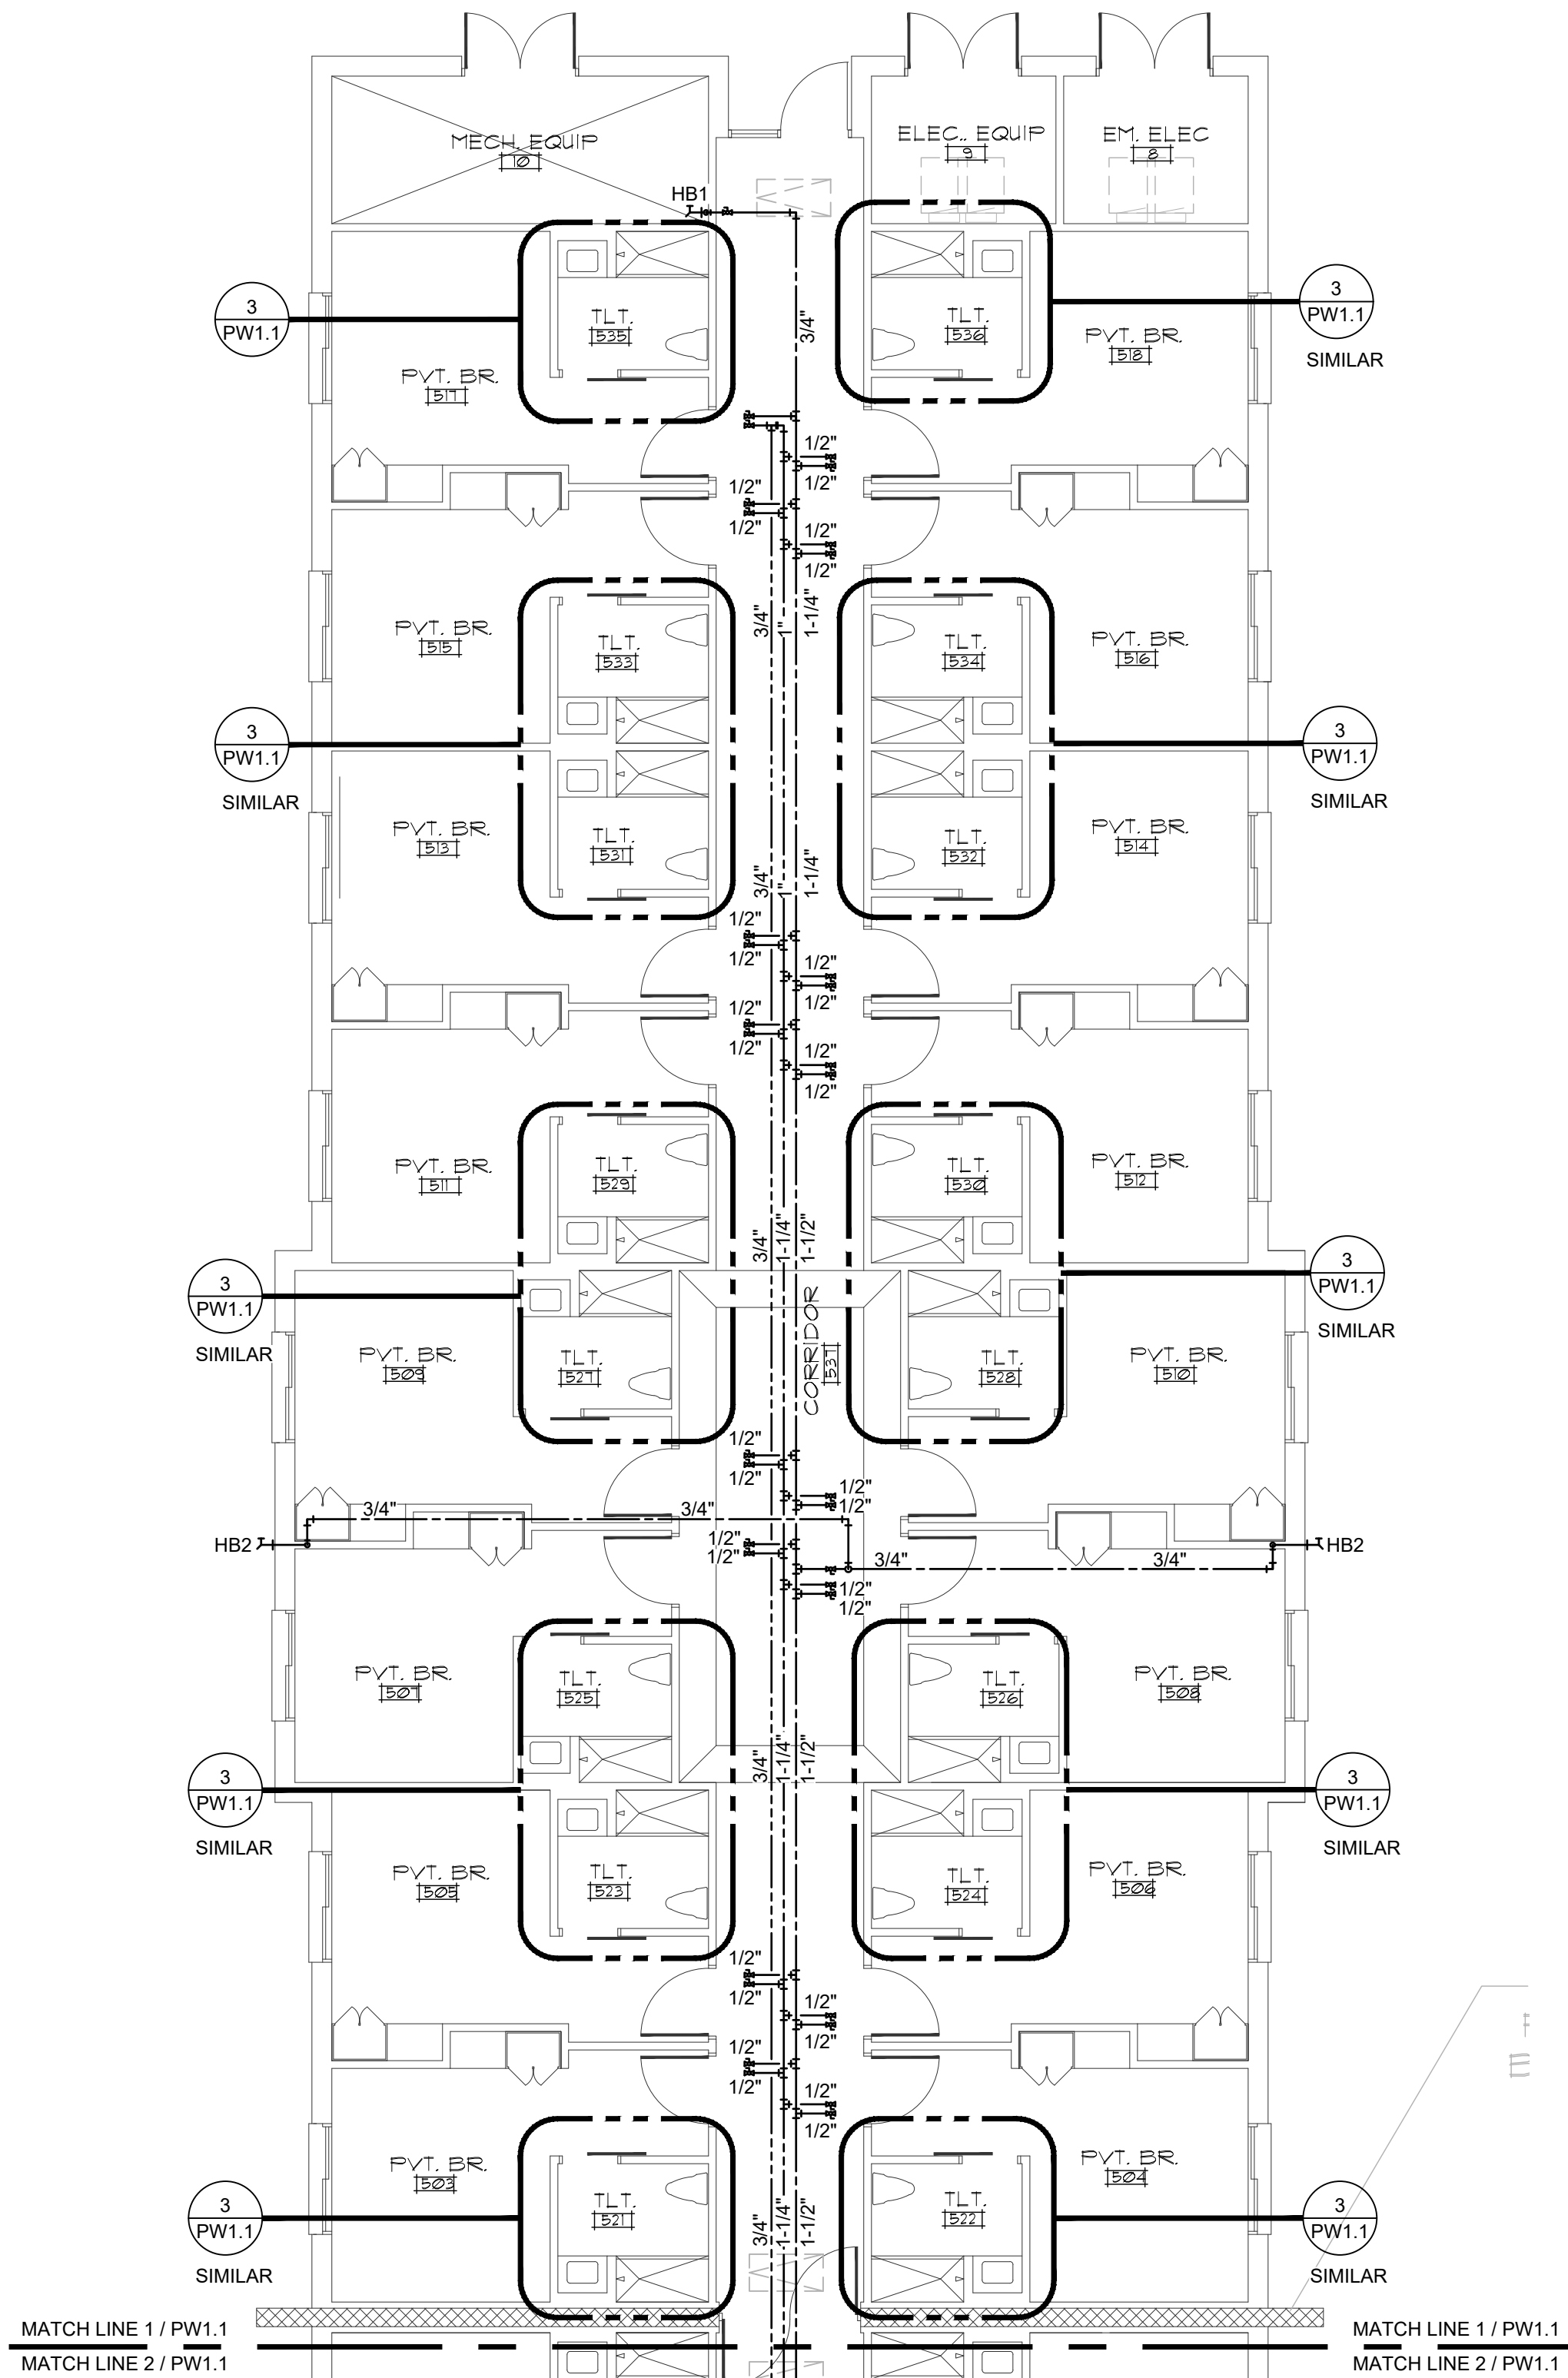

PARTIAL FLOOR PLAN - WING 400

1/8" = 1'-0"

PLAN
NORTH

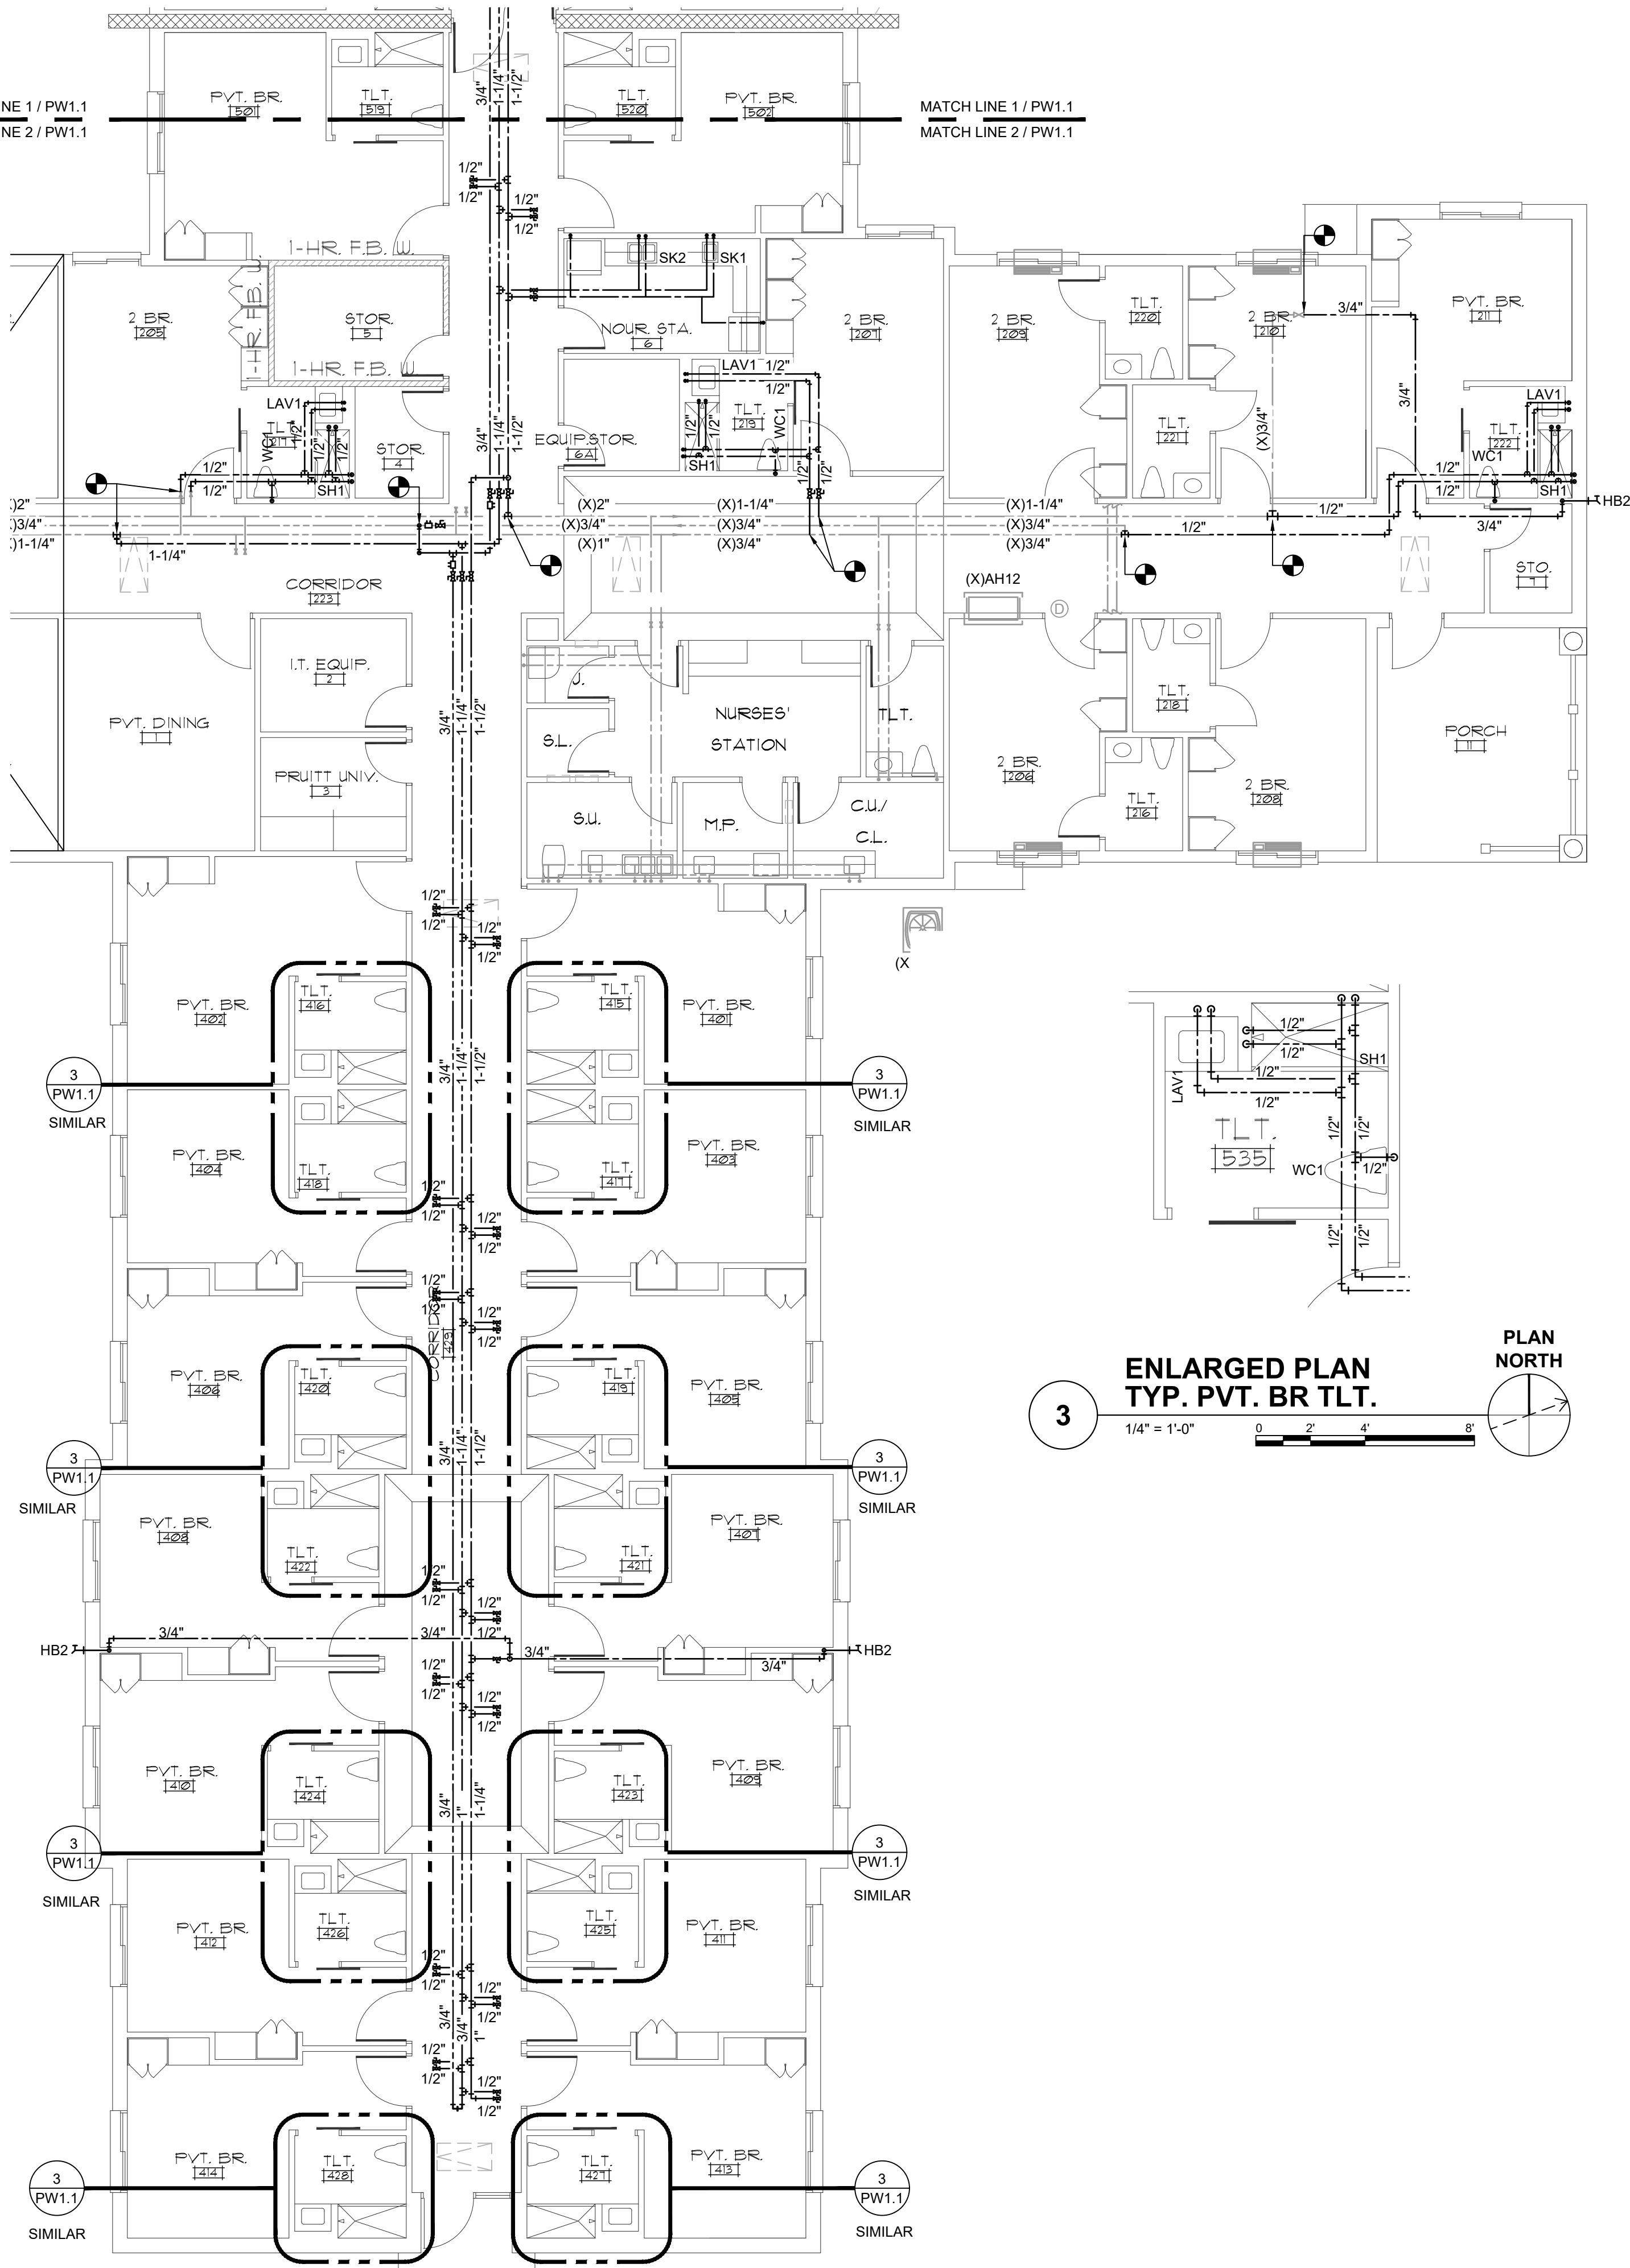


**PARTIAL FLOOR PLAN -
WINGS 200 AND 500**

1/8" = 1'-0"

PLAN
NORTH


WALL TYPE LEGEND

- 1 HOUR FIRE BARRIER WALL
- 1 HOUR FIRE/SMOKE BARRIER WALL
- 2 HOUR FIRE BARRIER WALL
- SMOKE RESISTANT WALL

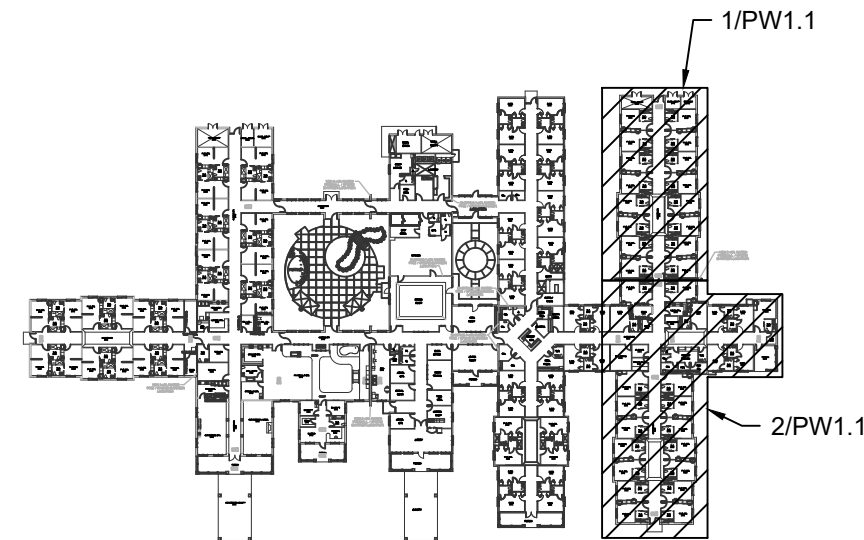

KEYPLAN

NOT TO SCALE

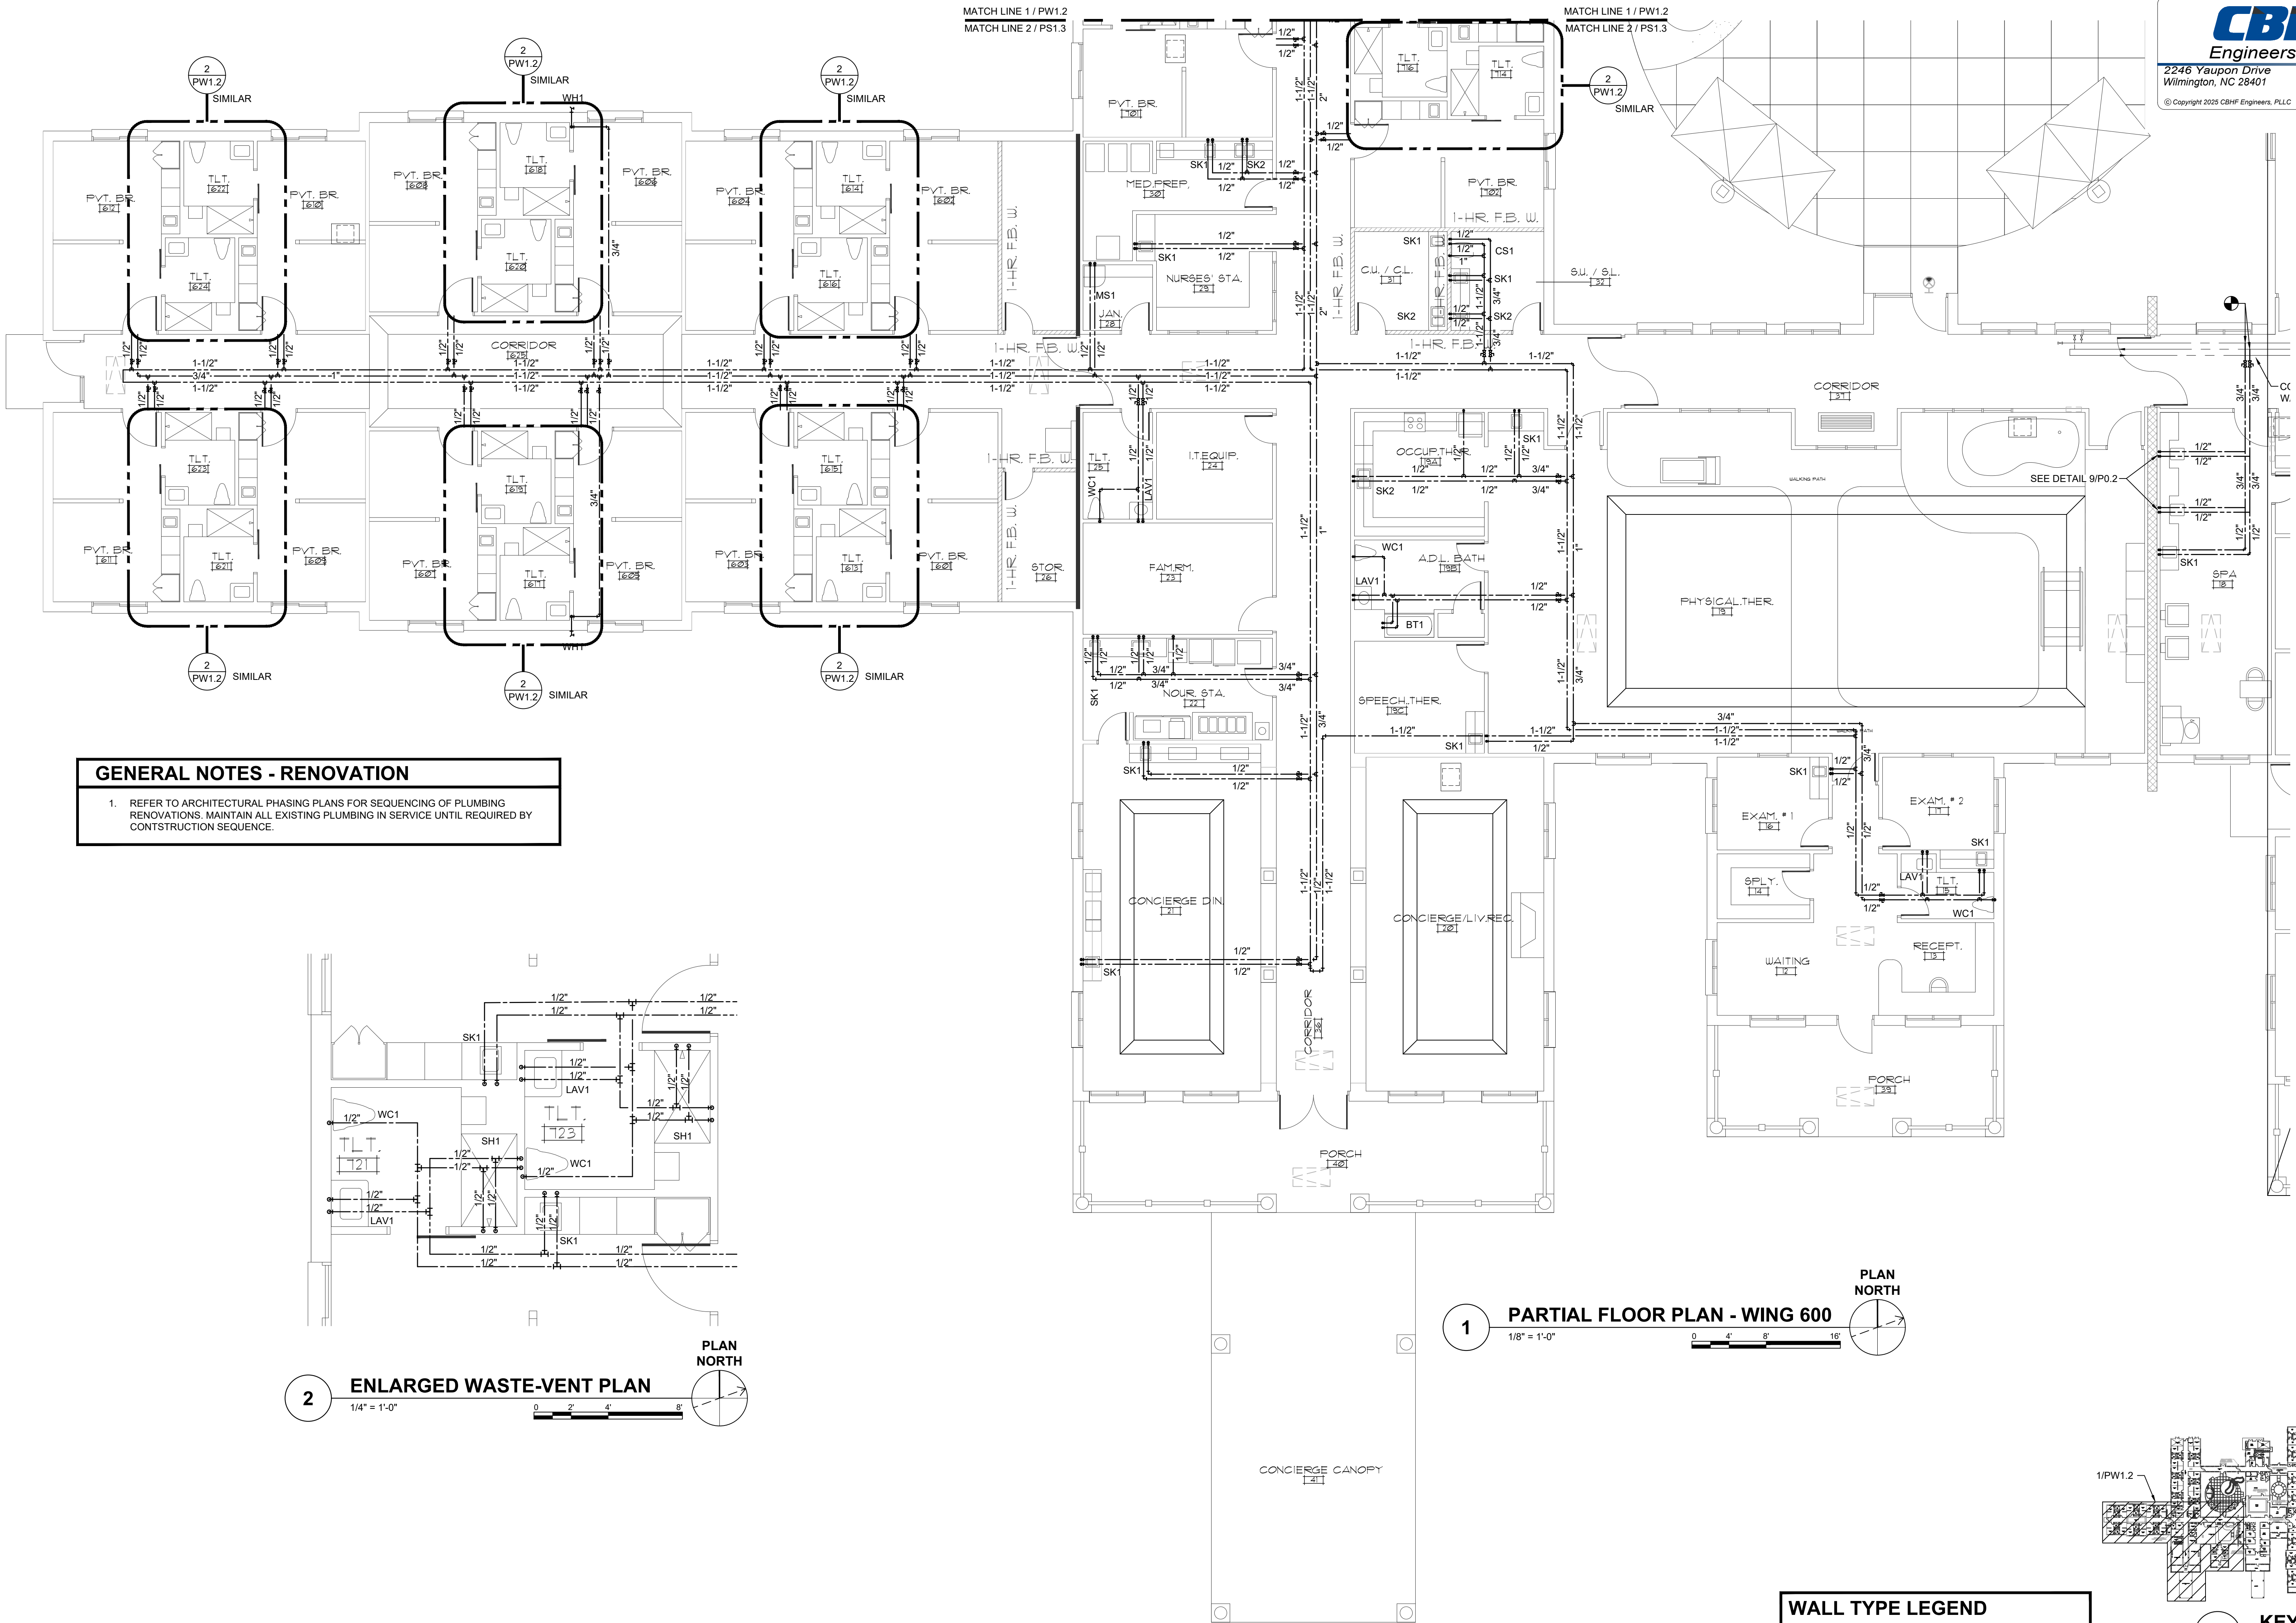

GENERAL NOTES - RENOVATION

1. REFER TO ARCHITECTURAL PHASING PLANS FOR SEQUENCING OF PLUMBING RENOVATIONS. MAINTAIN ALL EXISTING PLUMBING IN SERVICE UNTIL REQUIRED BY CONSTRUCTION SEQUENCE.


WALL TYPE LEGEND

	1 HOUR FIRE BARRIER WALL
	1 HOUR FIRE/SMOKE BARRIER WALL
	2 HOUR FIRE BARRIER WALL
	SMOKE RESISTANT WALL

KEYPLAN

NOT TO SCALE

0

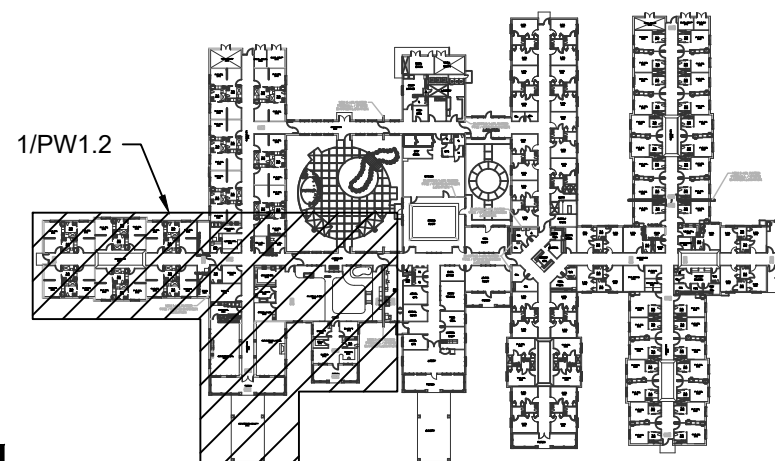


1/PW1.2

1 PARTIAL FLOOR PLAN - WING 600

1/8" = 1'-0"

0 4' 8' 16'

 PLAN NORTH




2 ENLARGED WASTE-VENT PLAN

1/4" = 1'-0"


0 2' 4' 8'

 PLAN NORTH



CBHF
Engineers, PLLC

2246 Yaupon Drive
Wilmington, NC 28401
Phone: 910.791.4000
Fax: 910.791.5266
www.cbhfenr.com
NCE P-0506

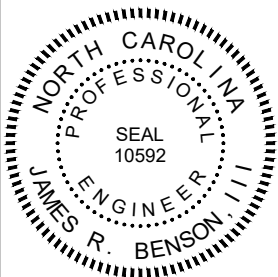


ISSUED FOR
CONSTRUCTION
08-26-2025

PRUITT HEALTH
TOWN CENTER
Harrisburg, North Carolina

David R. Polston - Architect
3806 Park Ave. Suite C, Wilmington, NC 28403
Architecture Planning Design

51 BEDROOM ADDITION
/RENOVATION
PLUMBING RENO
PARTIAL WATER PLANS

PW
1.2

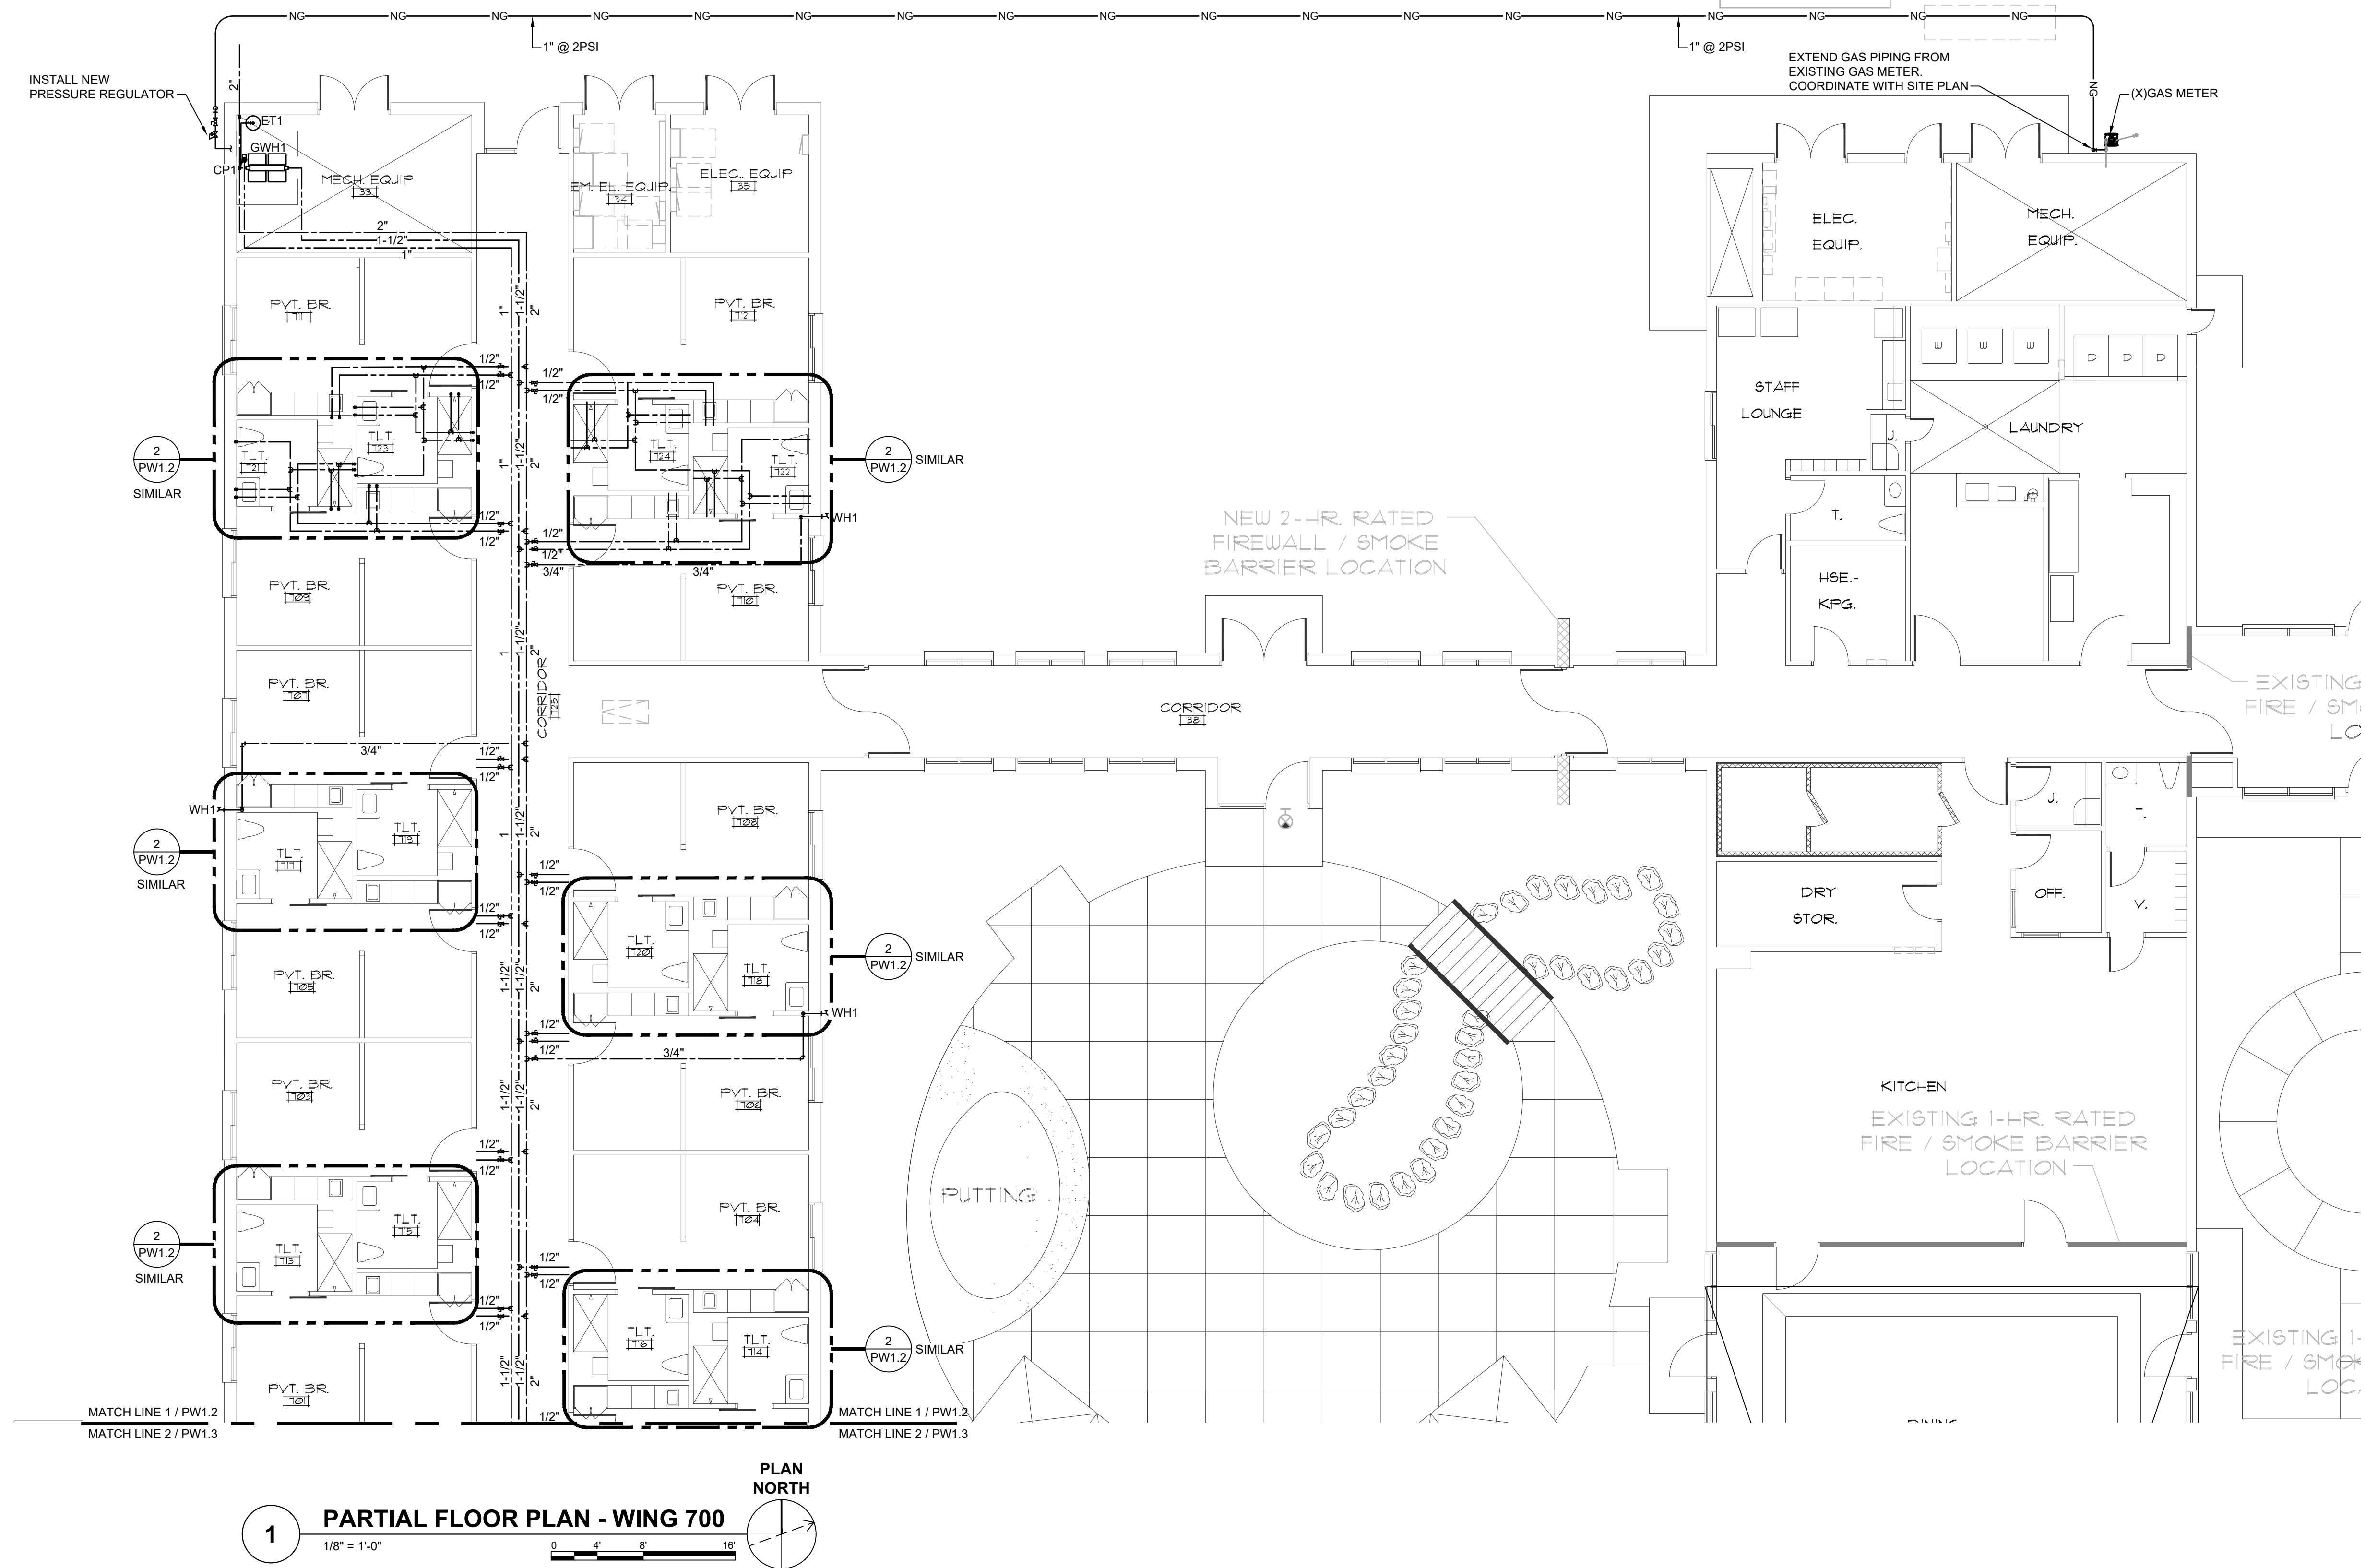


GENERAL NOTES - RENOVATION

1. REFER TO ARCHITECTURAL PHASING PLANS FOR SEQUENCING OF PLUMBING RENOVATIONS. MAINTAIN ALL EXISTING PLUMBING IN SERVICE UNTIL REQUIRED BY CONSTRUCTION SEQUENCE.

WALL TYPE LEGEND

	1 HOUR FIRE BARRIER WALL
	1 HOUR FIRE/SMOKE BARRIER WALL
	2 HOUR FIRE BARRIER WALL
	SMOKE RESISTANT WALL

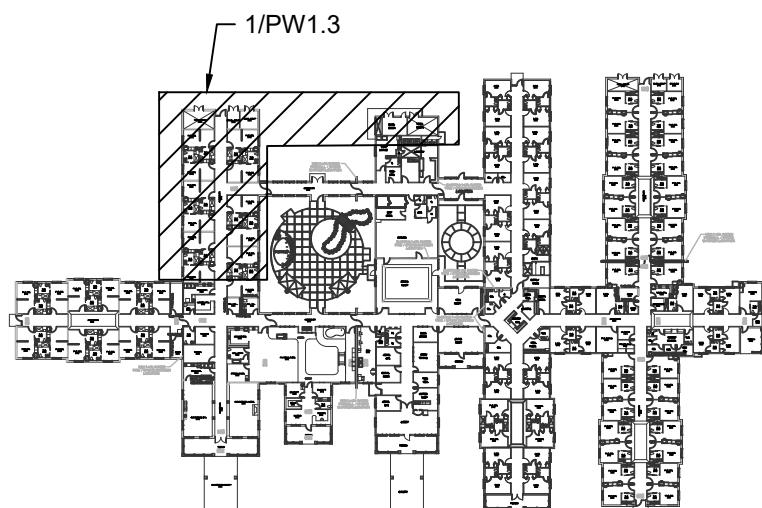

KEYPLAN

NOT TO SCALE