



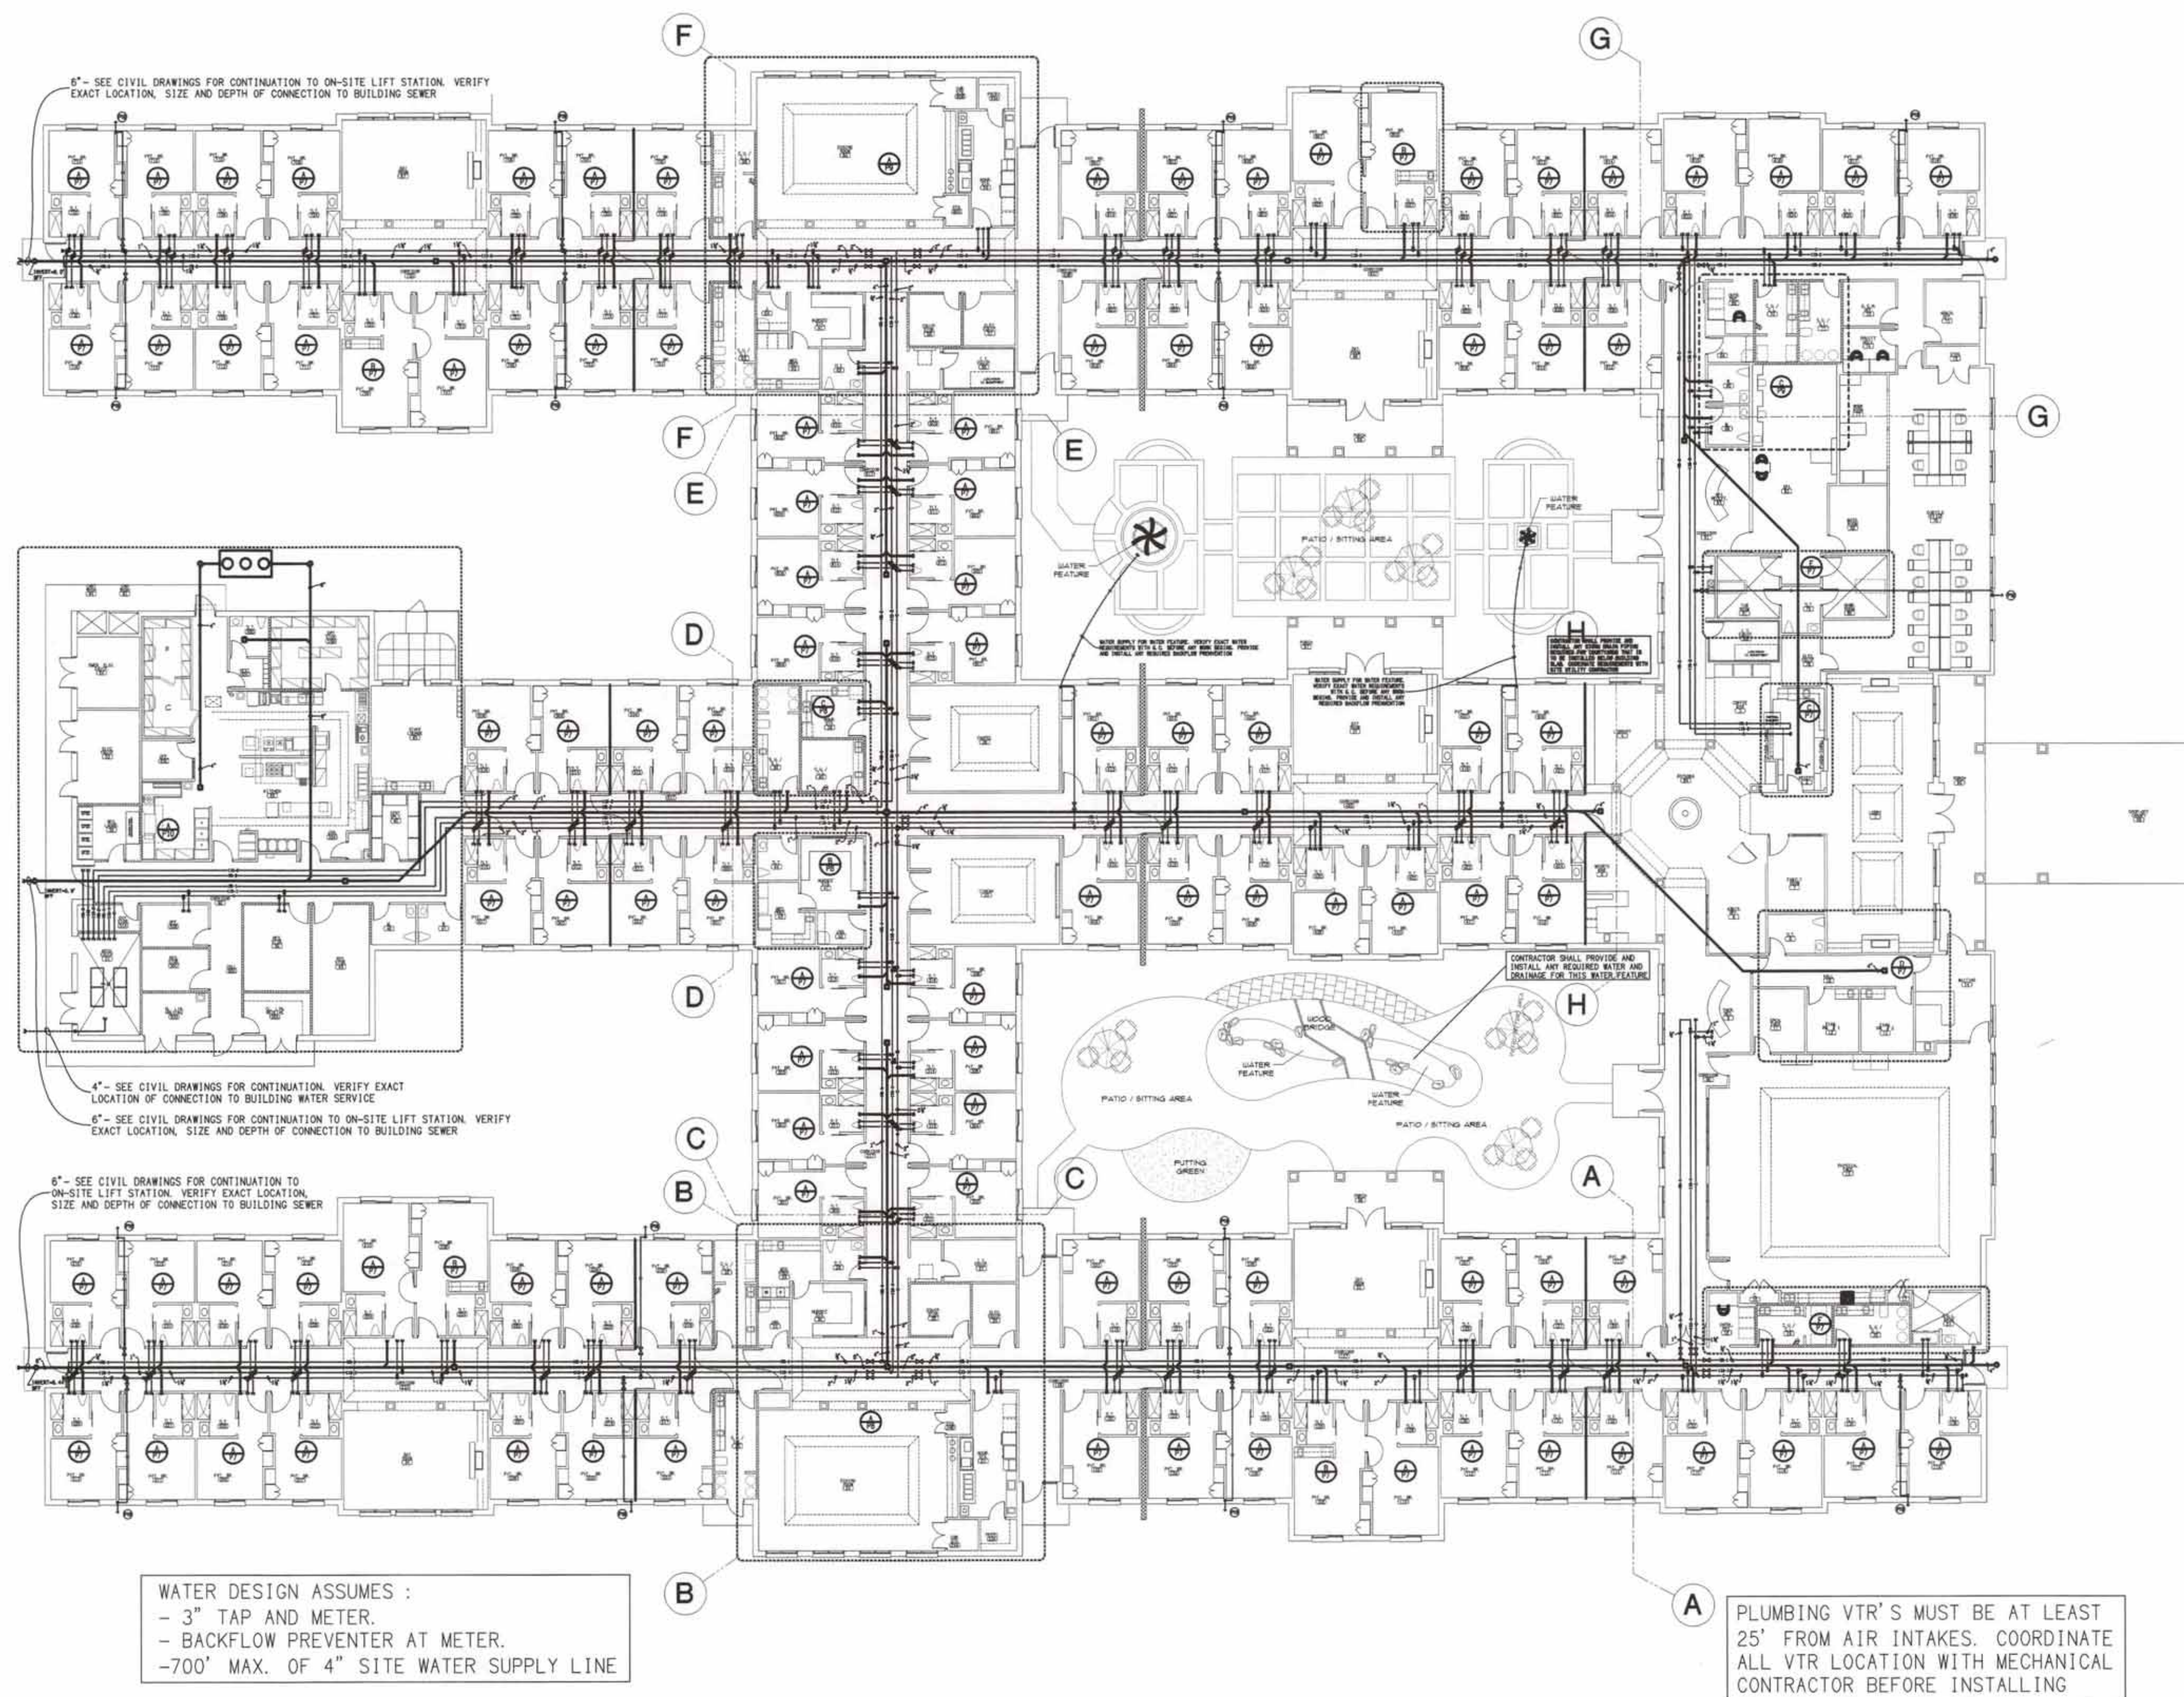


LEGEND	
—	WASTE PIPE
- - - -	VENT PIPE
—	COLD WATER PIPE - ABOVE GRADE
- - - -	COLD WATER PIPE - BELOW GRADE
—110—	HOT WATER PIPE - ABOVE GRADE - 110°F
—110-1—	HOT WATER PIPE - ABOVE GRADE - 110°F
—110-2—	HOT WATER PIPE - ABOVE GRADE - 110°F
- - -110-	HOT WATER PIPE - BELOW GRADE - 110°F
—140—	HOT WATER PIPE - ABOVE GRADE - 140°F
- - -140-	HOT WATER PIPE - BELOW GRADE - 140°F
HR-1	RECIRCULATION PIPE - ABOVE GRADE - 110°F
HR-2	RECIRCULATION PIPE - ABOVE GRADE - 110°F
HR-3	RECIRCULATION PIPE - ABOVE GRADE - 140°F
HR-4	RECIRCULATION PIPE - ABOVE GRADE - 140°F
—	GAS PIPE - ABOVE GRADE
- - -	GAS PIPE - BELOW GRADE
X	GATE VALVE
Z	CHECK VALVE
+	HOSE BIBB
—	UNION
—	INTAKE/EXHAUST PIPE
—	PIPE REDUCTION
□	INTERIOR CLEANOUT (P2)
○	EXTERIOR CLEANOUT (P2)
+	WALL CLEANOUT (P2)
VTR	VENT THROUGH ROOF
CO	CLEANOUT
AS P	REFER TO PLAN OR DETAIL A ON SHEET P1
IS P	REFER TO ISOMETRIC A ON SHEET P1
+	RELIEF VALVE
X	BALL VALVE
X	BALANCING VALVE - 110 RECIRC SYSTEM
X	GAS SHUTOFF VALVE
+	STRAINER
+	MIXING VALVE
+	TEMPERATURE GAUGE
+	FLOOR DRAIN
+	FLOOR SINK
+	HUB DRAIN
+	RECIRCULATION PUMP
+	BACKFLOW PREVENTER

A
P1 OVERALL PLUMBING PLAN
SCALE: 1/16" = 1'-0"


symbol	date	description	by
REVISIONS			

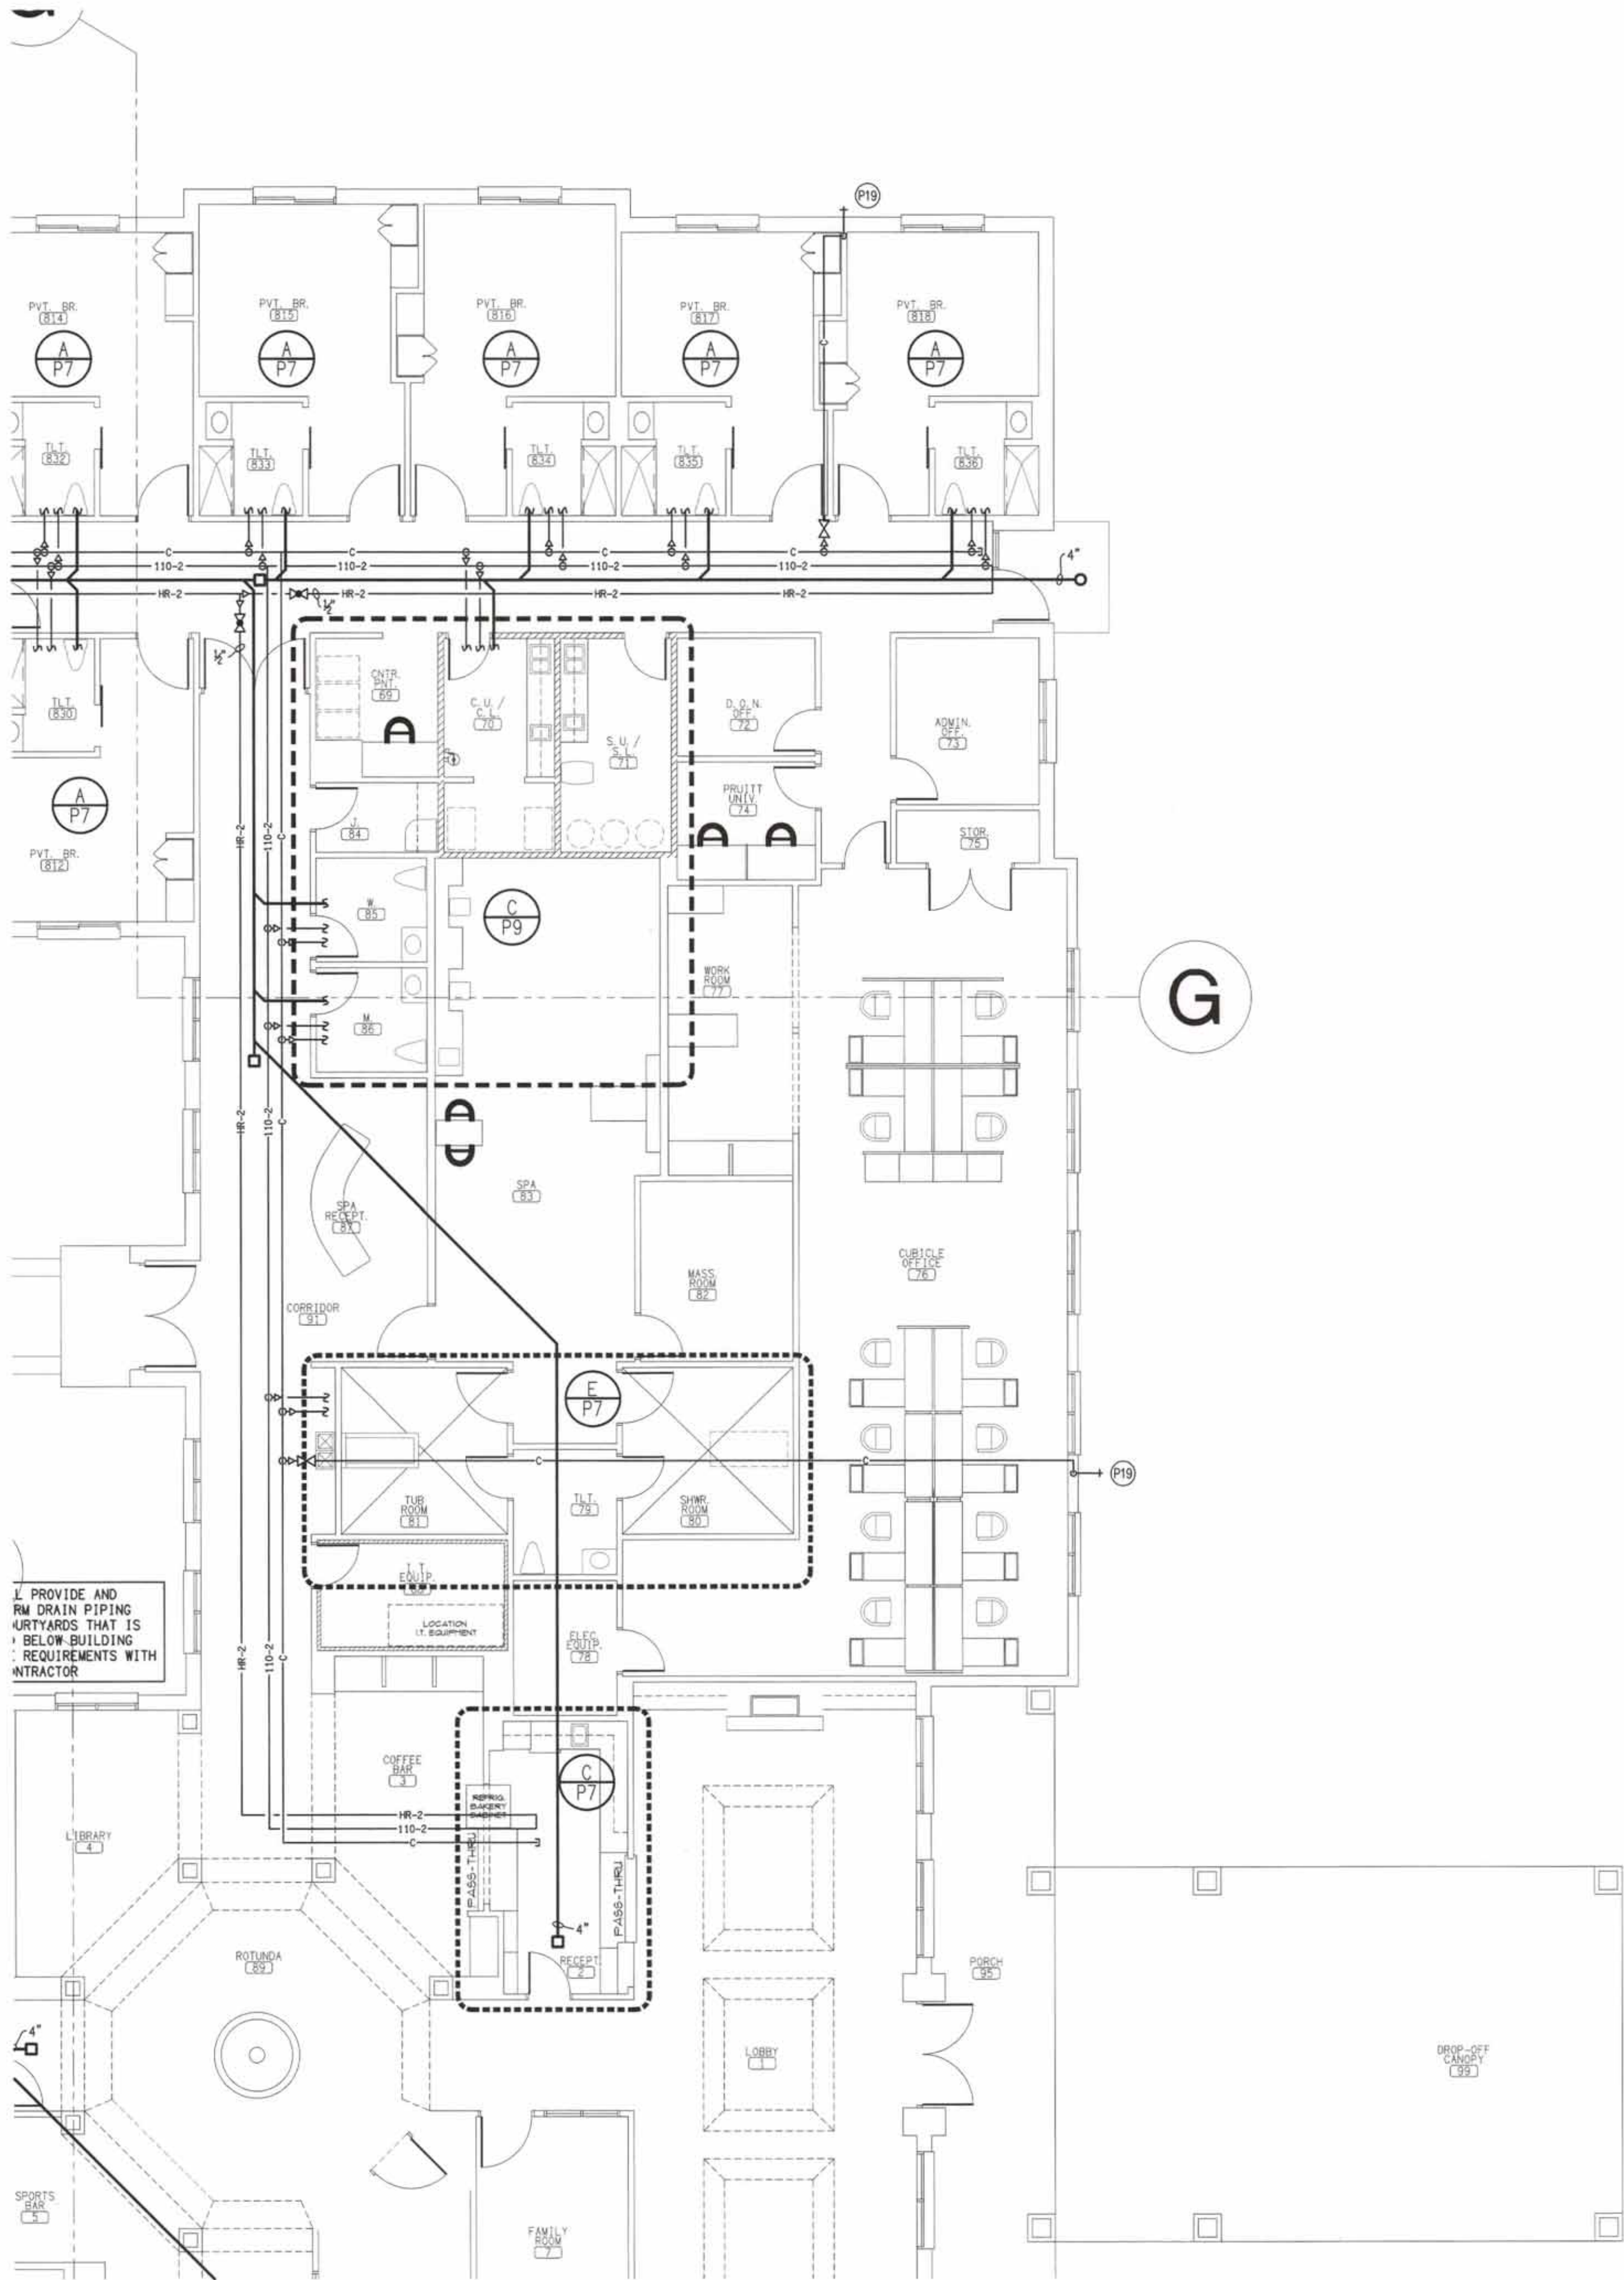

A PARTIAL PLUMBING PLAN
P2 SCALE: 1/8" = 1'-0"

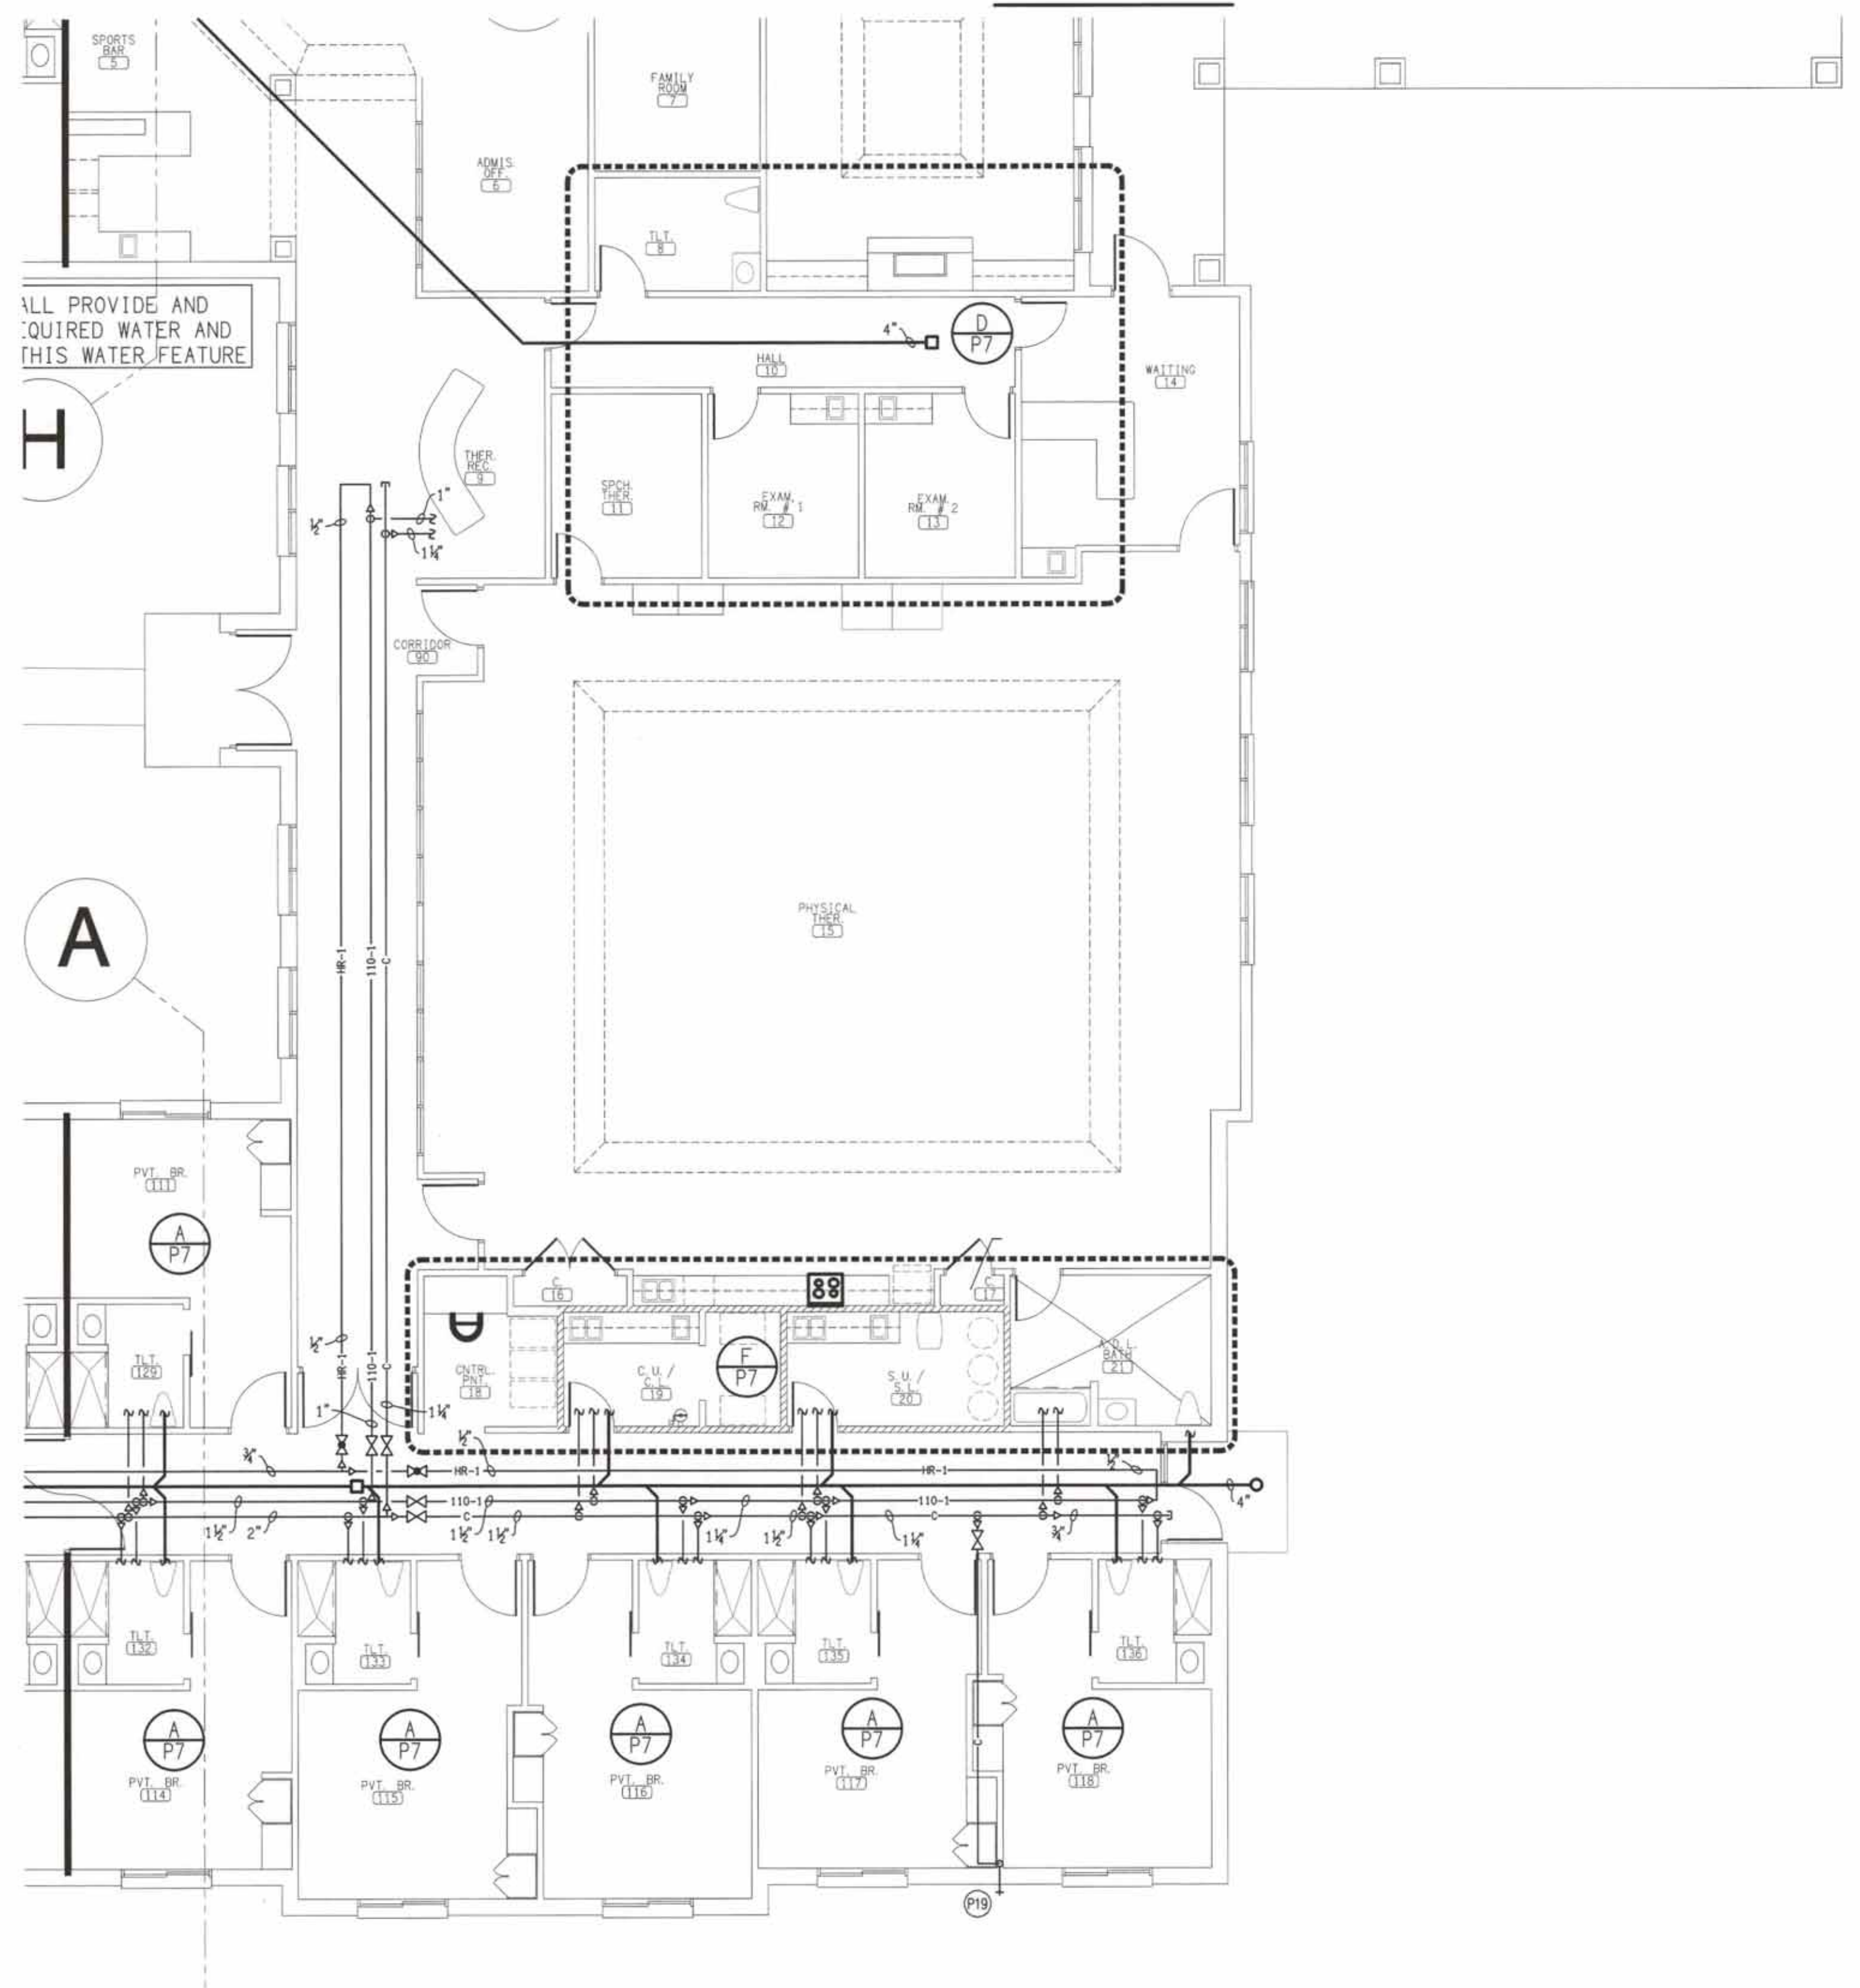

B PARTIAL PLUMBING PLAN
P2 SCALE: 1/8" = 1'-0"

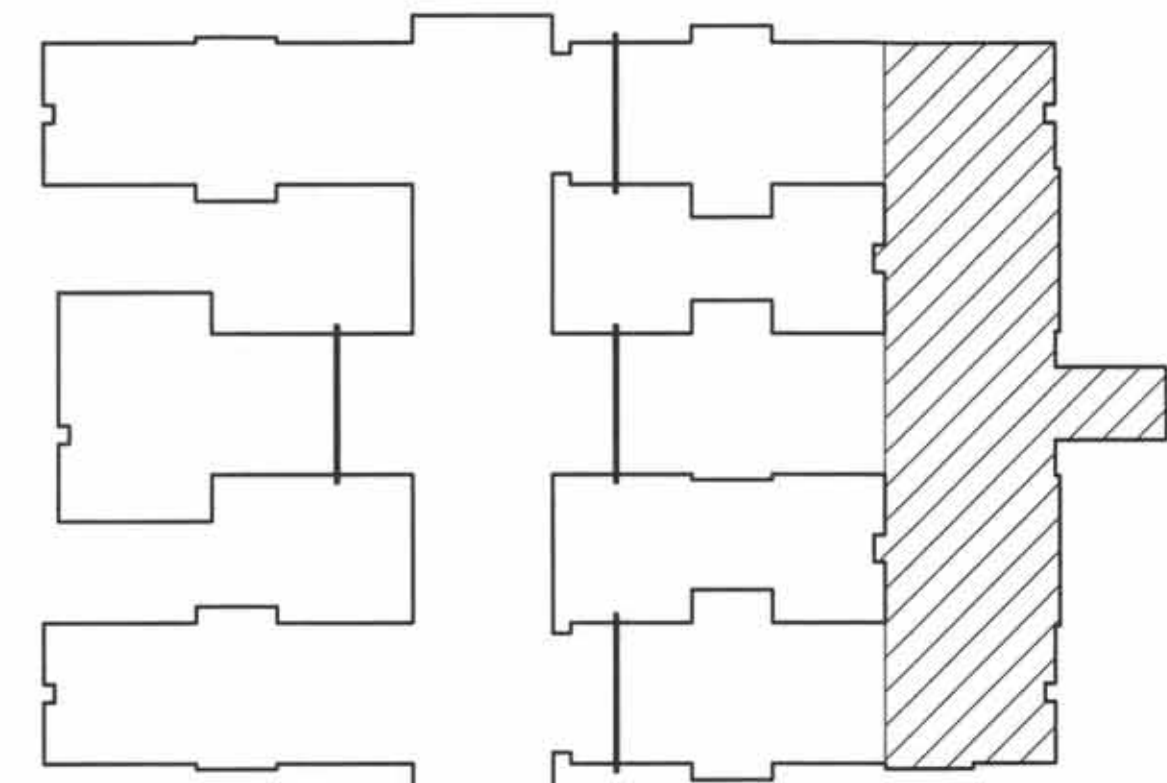

PLAN KEY

DSA
ENGINEERING

DAVID SIMS &
ASSOCIATES, P.C.
CONSULTING ENGINEERS

ARBORETUM CENTRE
108 GILES AVE, SUITE 100
WILMINGTON, NC 28403
910.791.8016
NC License: C-1150
www.dsaeng.com

NORTH CAROLINA
PROFESSIONAL
SEAL
007138
ENGINEER
DAVID SIMS
9/27/21


PRUITTHEALTH
CRYSTAL COAST
Beaufort, North Carolina

David R. Polston - Architect
3806 Park Ave. Suite 2-L, Wilmington, NC 28403
Architecture Planning Design


104 BED
NURSING FACILITY

P2


symbol	date	description	by
		REVISIONS	

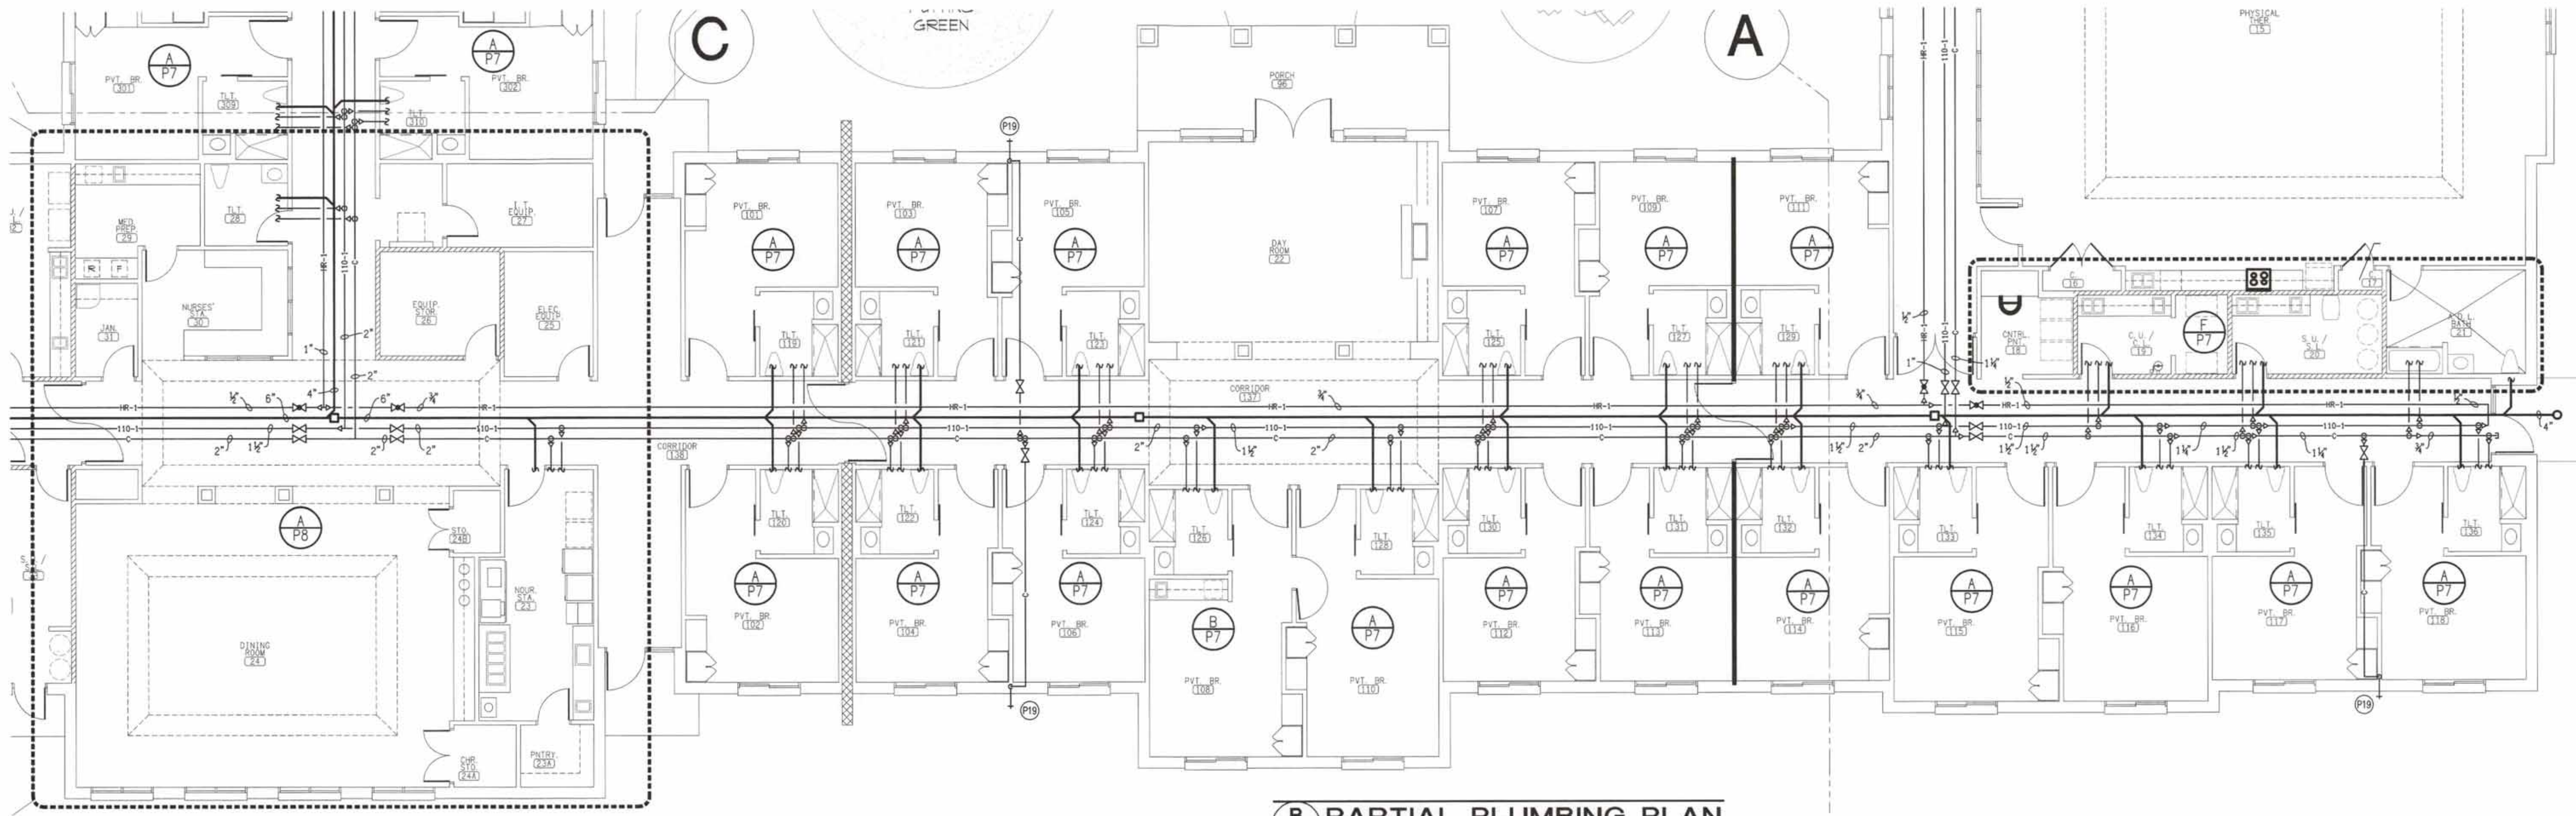

B PARTIAL PLUMBING PLAN
P3 SCALE: 1/8" = 1'-0"

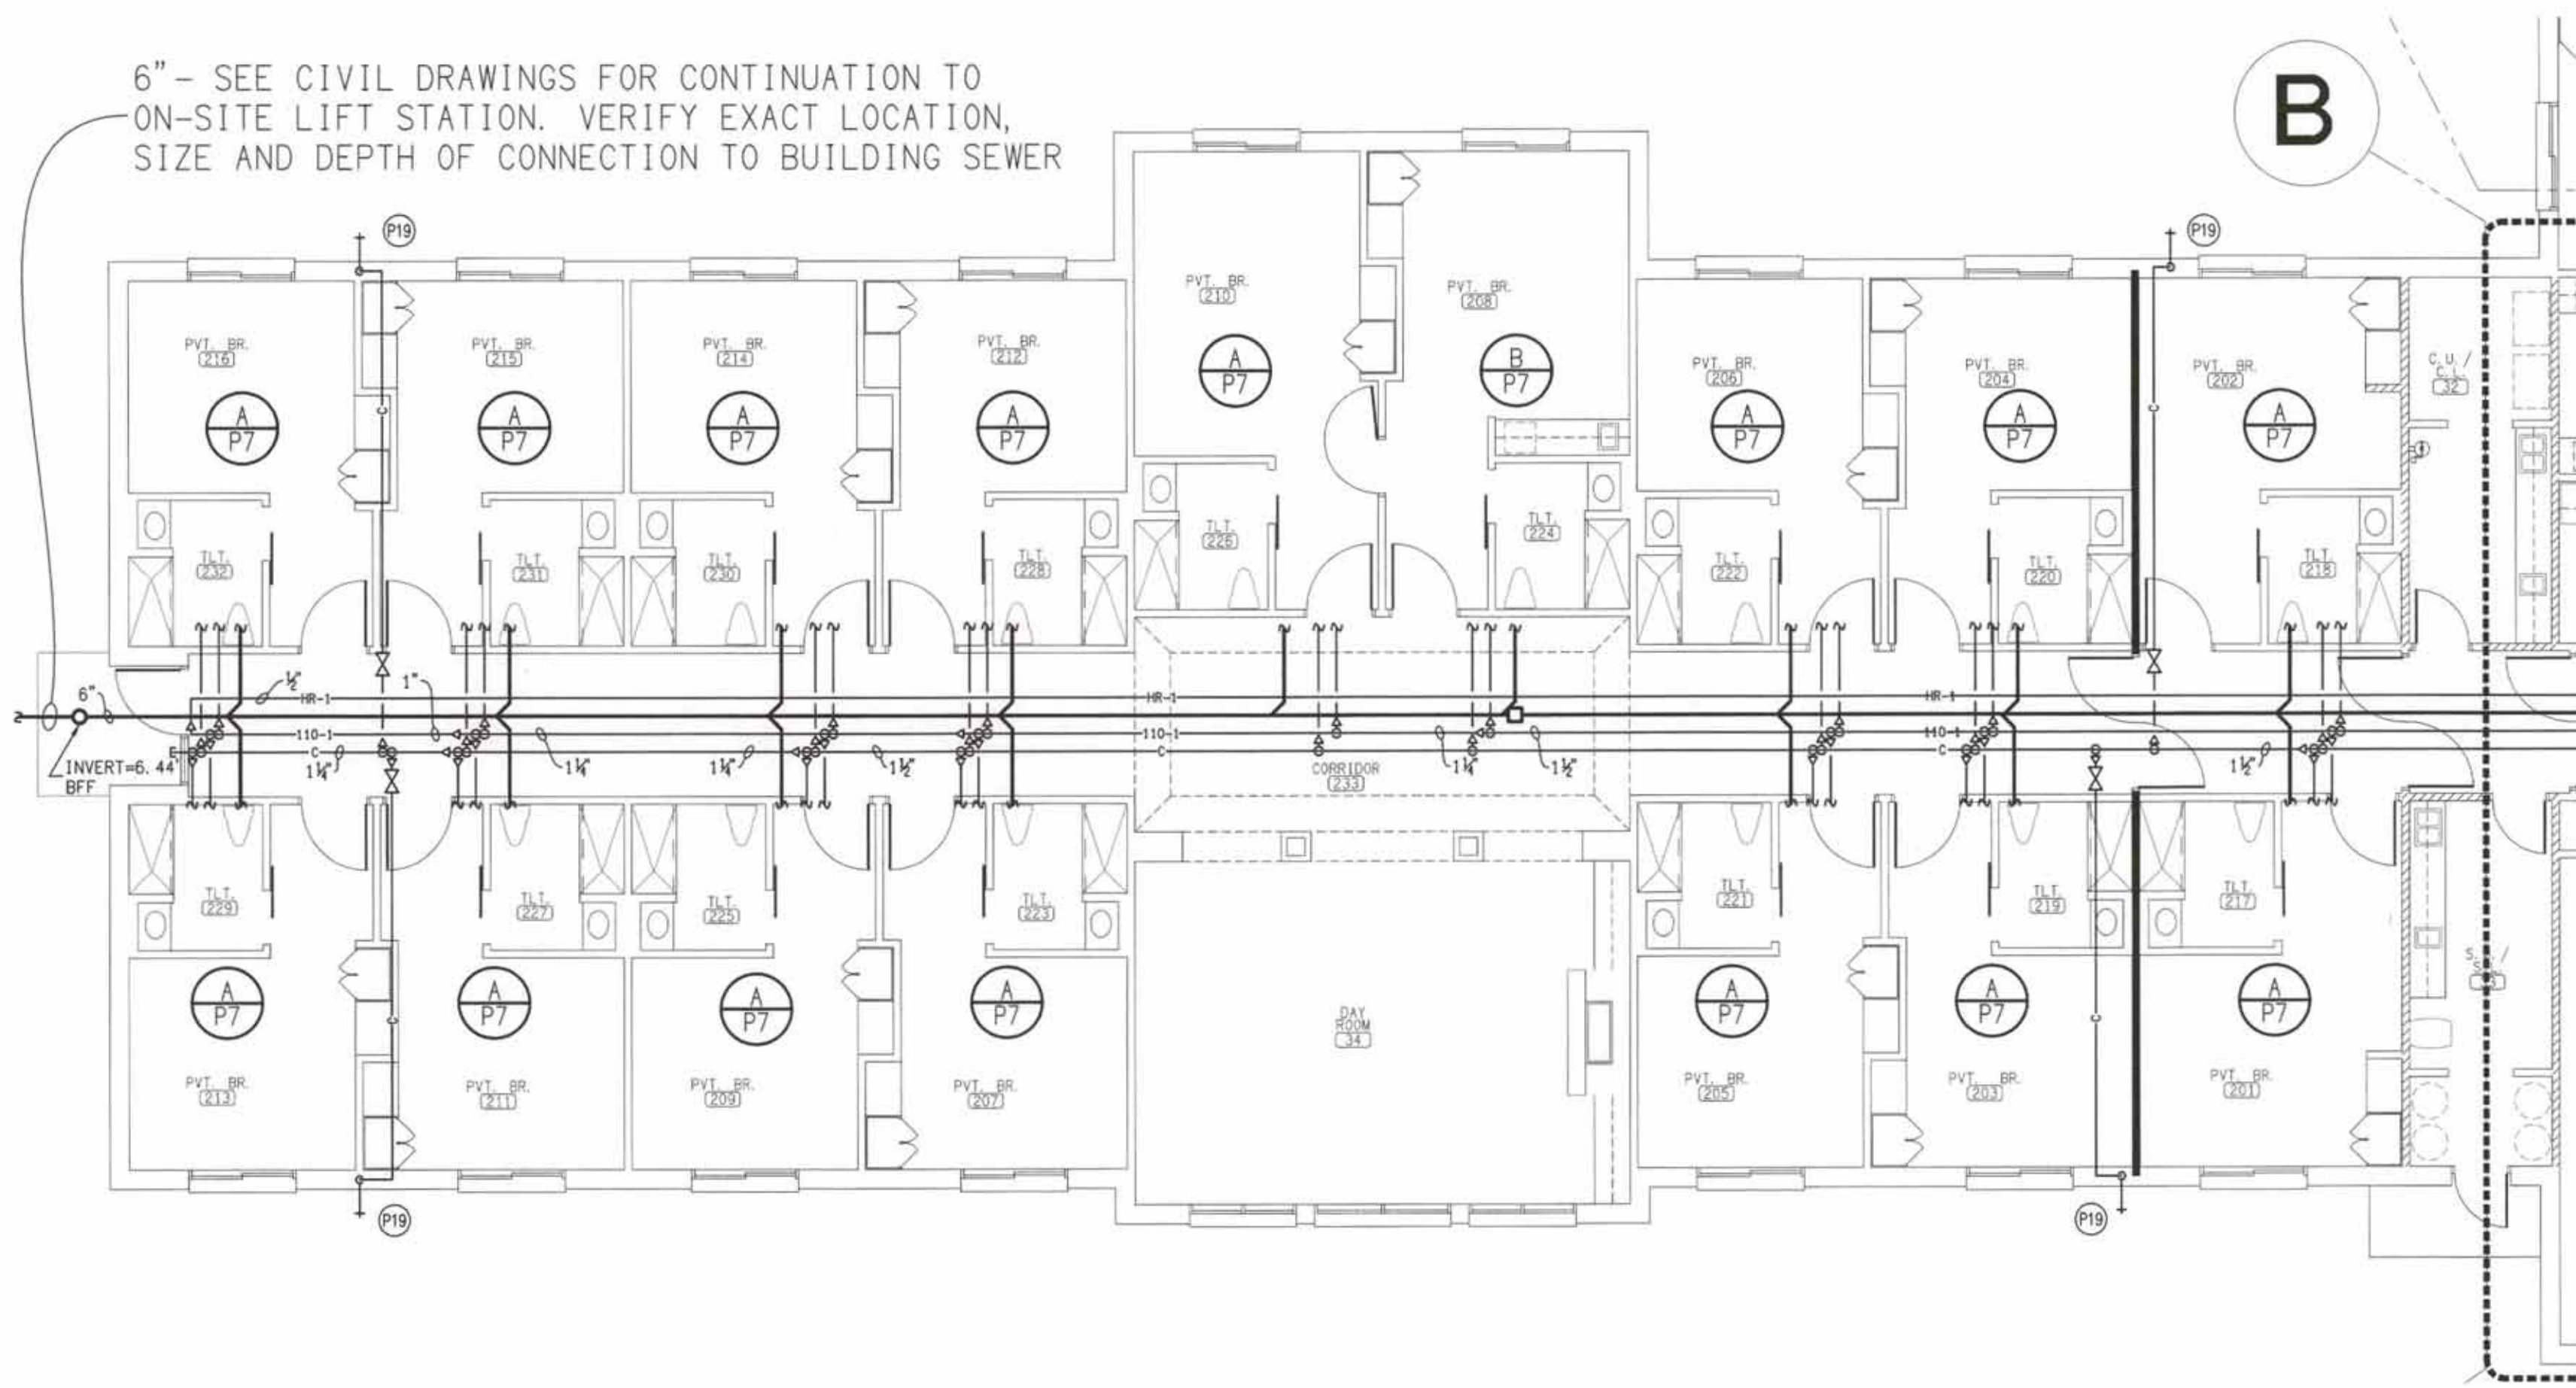

A PARTIAL PLUMBING PLAN
P3 SCALE: 1/8" = 1'-0"

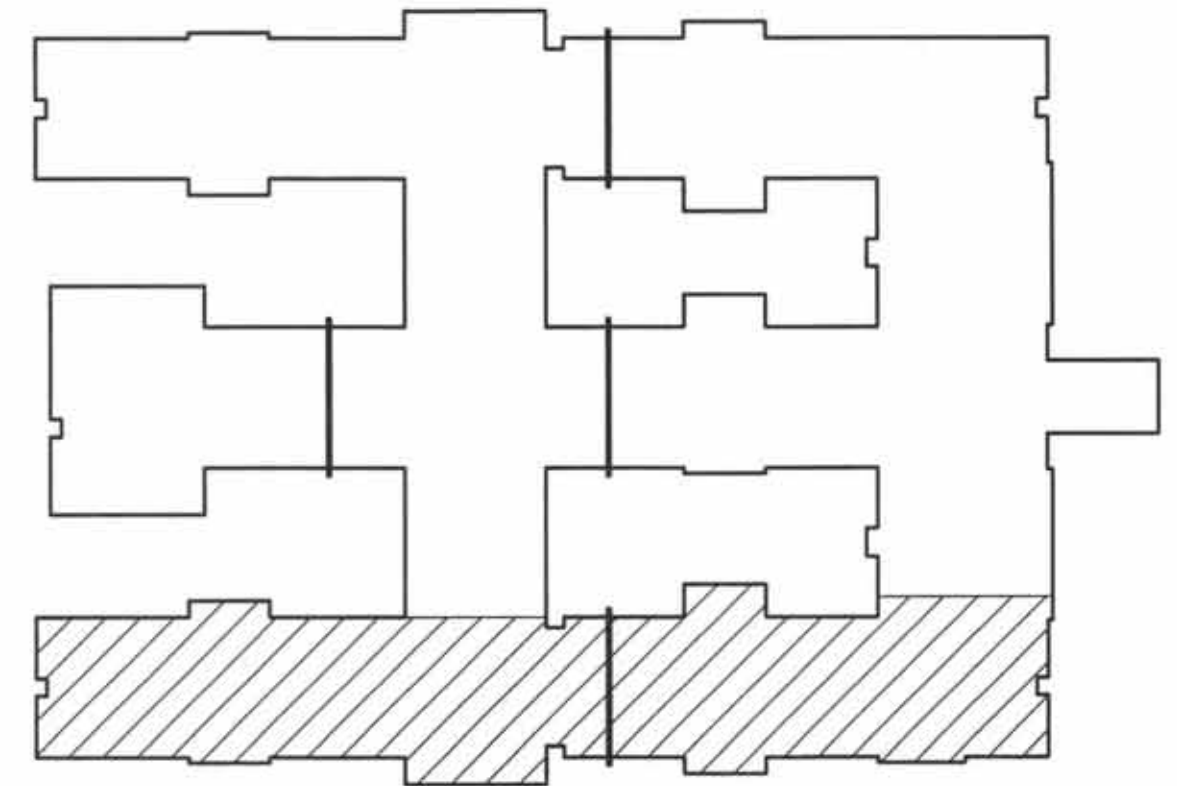

PLAN KEY

DSA ENGINEERING
DAVID SIMS & ASSOCIATES, P.C.
CONSULTING ENGINEERS
ARBORETUM CENTRE
108 GILES AVE, SUITE 100
WILMINGTON, NC 28403
910.791.8016
NC License: C-1150
www.dsaeng.com

PROFESSIONAL ENGINEER
DAVID R. SIMS, P.E.
SEAL 007138
9/27/21


PRUITTHEALTH CRYSTAL COAST
Beaufort, North Carolina

David R. Polston - Architect
3806 Park Ave, Suite 2-L, Wilmington, NC 28403
Architecture Planning Design

104 BED NURSING FACILITY

P3

symbol	date	description	by
REVISIONS			

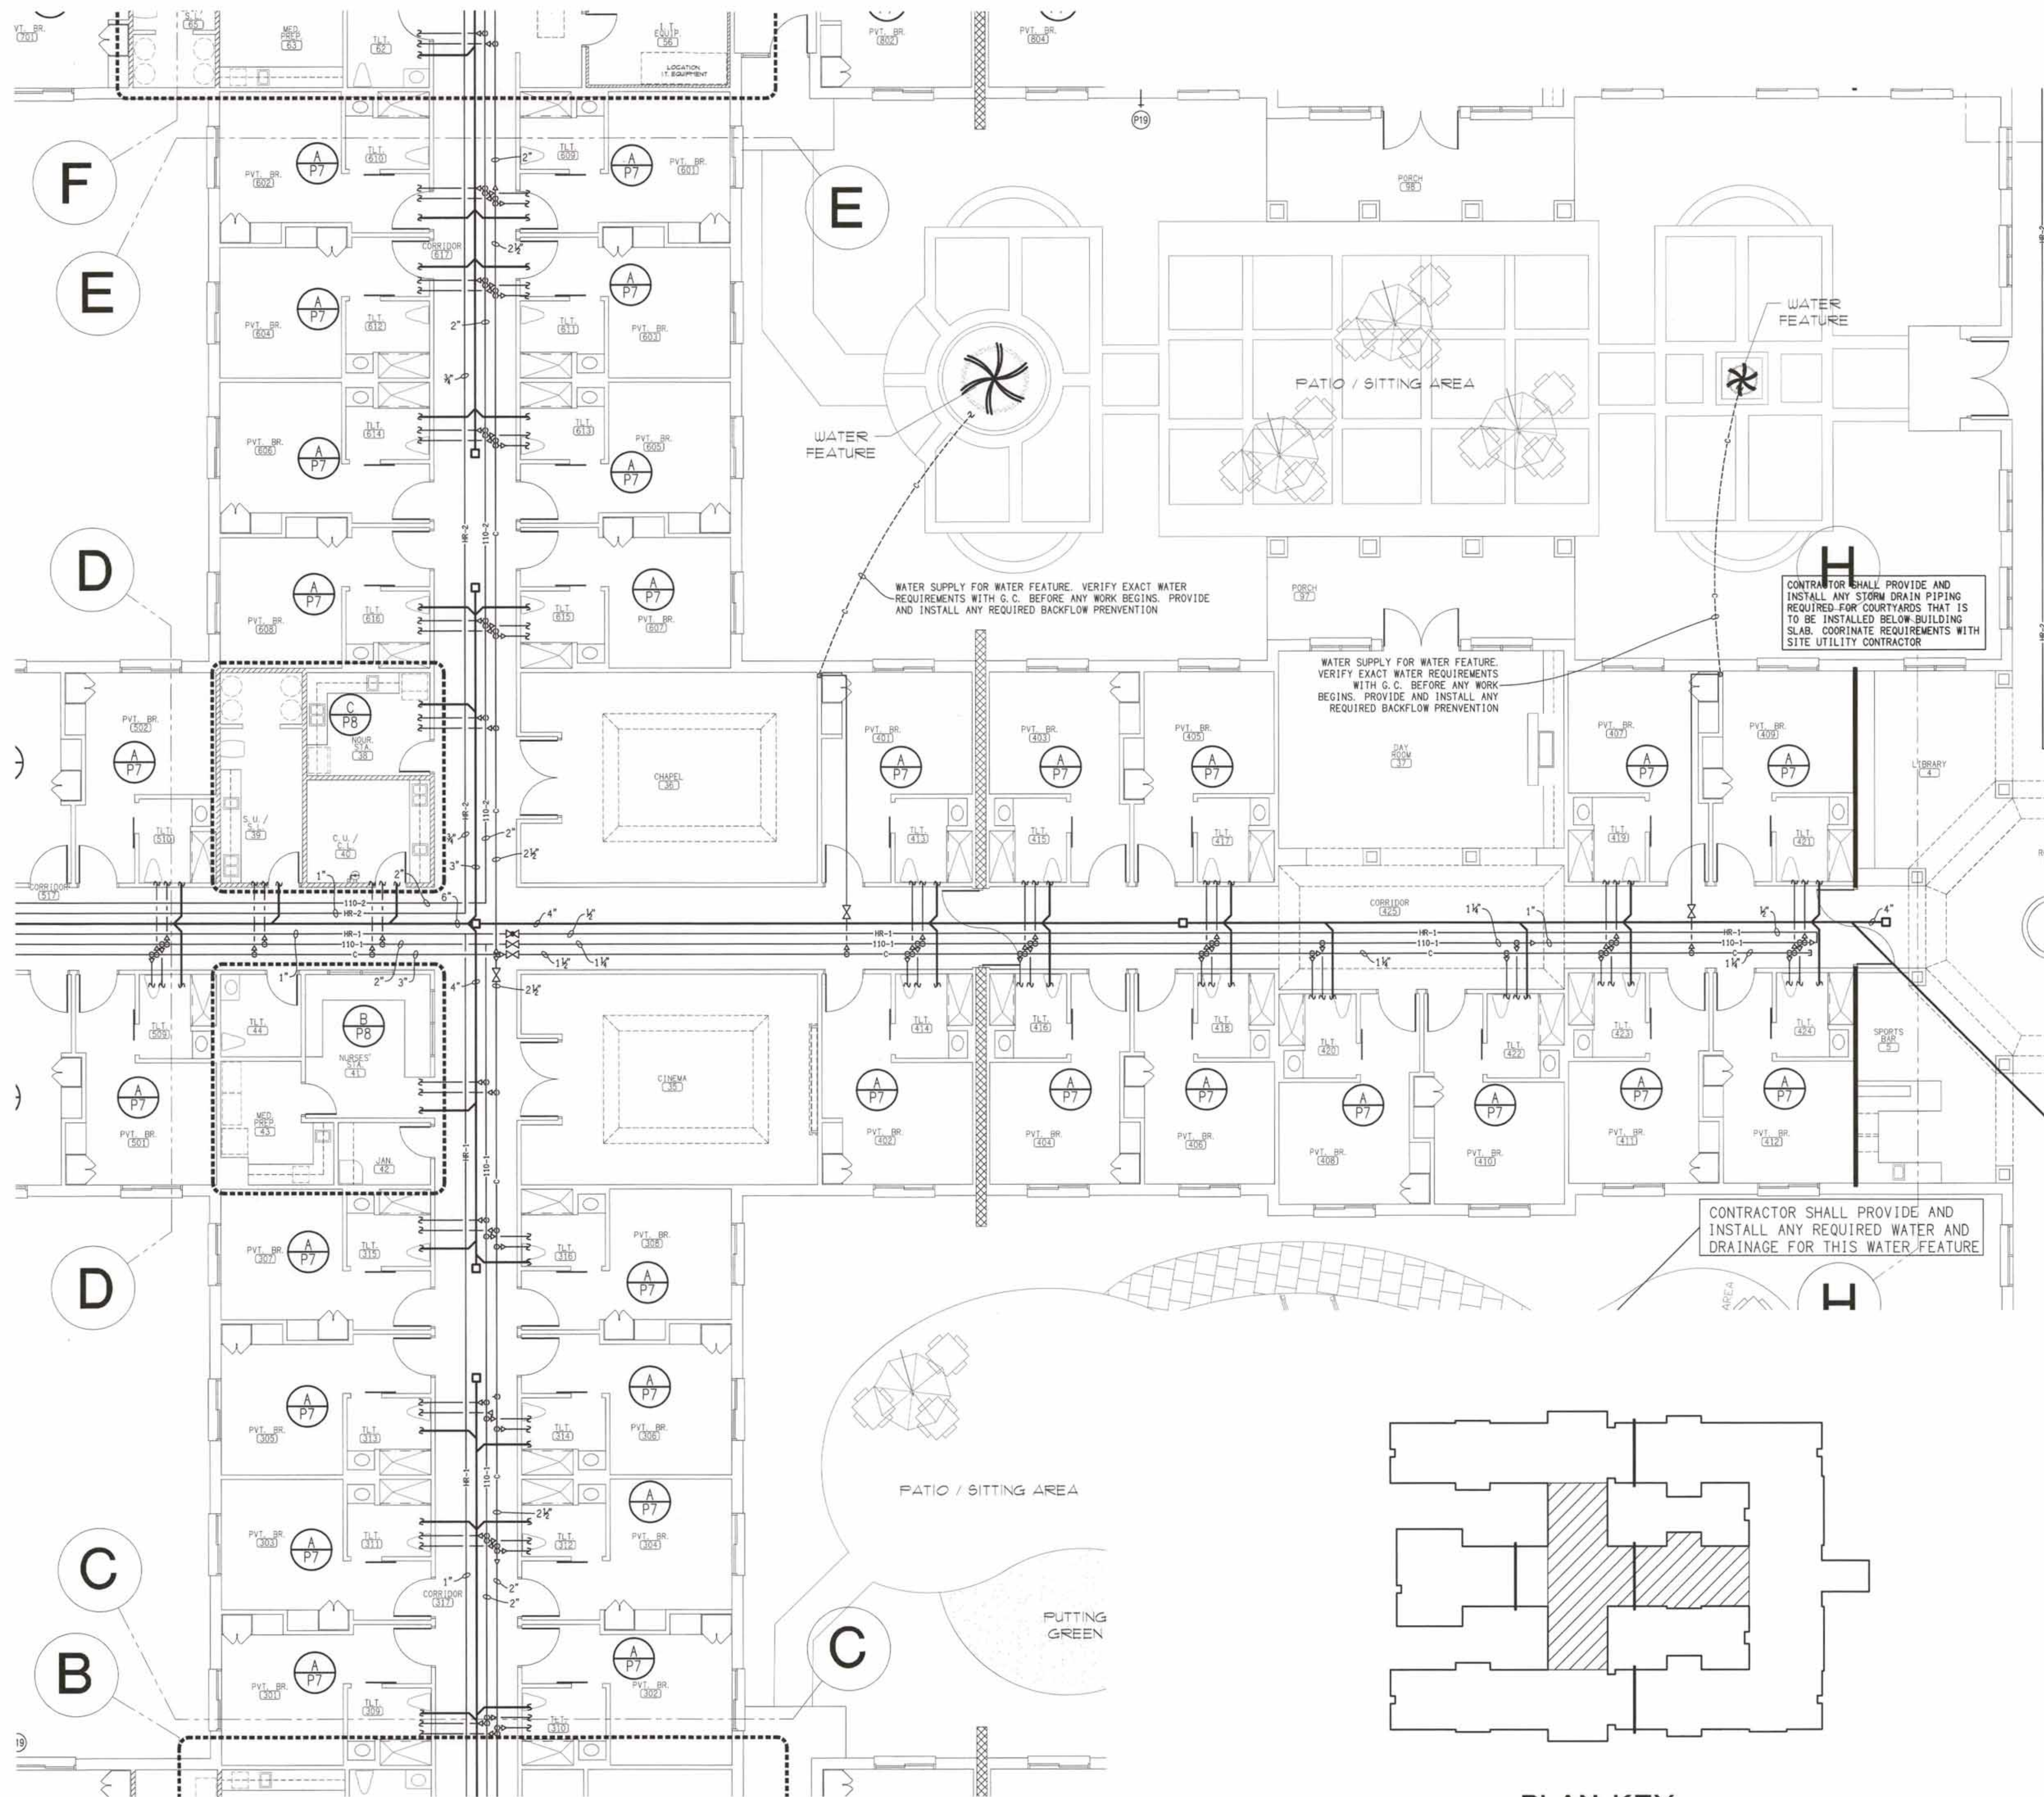

A PARTIAL PLUMBING PLAN
P4 SCALE: 1/8" = 1'-0"

PLAN KEY

symbol	date	description	by
REVISIONS			

DSA
ENGINEERING

DAVID SIMS &
ASSOCIATES, P.C.
CONSULTING ENGINEERS

ARBORETUM CENTRE
108 GILES AVE, SUITE 100
WILMINGTON, NC 28403
910.791.8016
NC License: C-1150
www.dsaeng.com




PRUITTHEALTH
CRYSTAL COAST
Beaufort, North Carolina


David R. Polston - Architect
3806 Park Ave. Suite 2-L, Wilmington, NC 28403
Architecture Planning Design

104 BED
NURSING FACILITY

P4

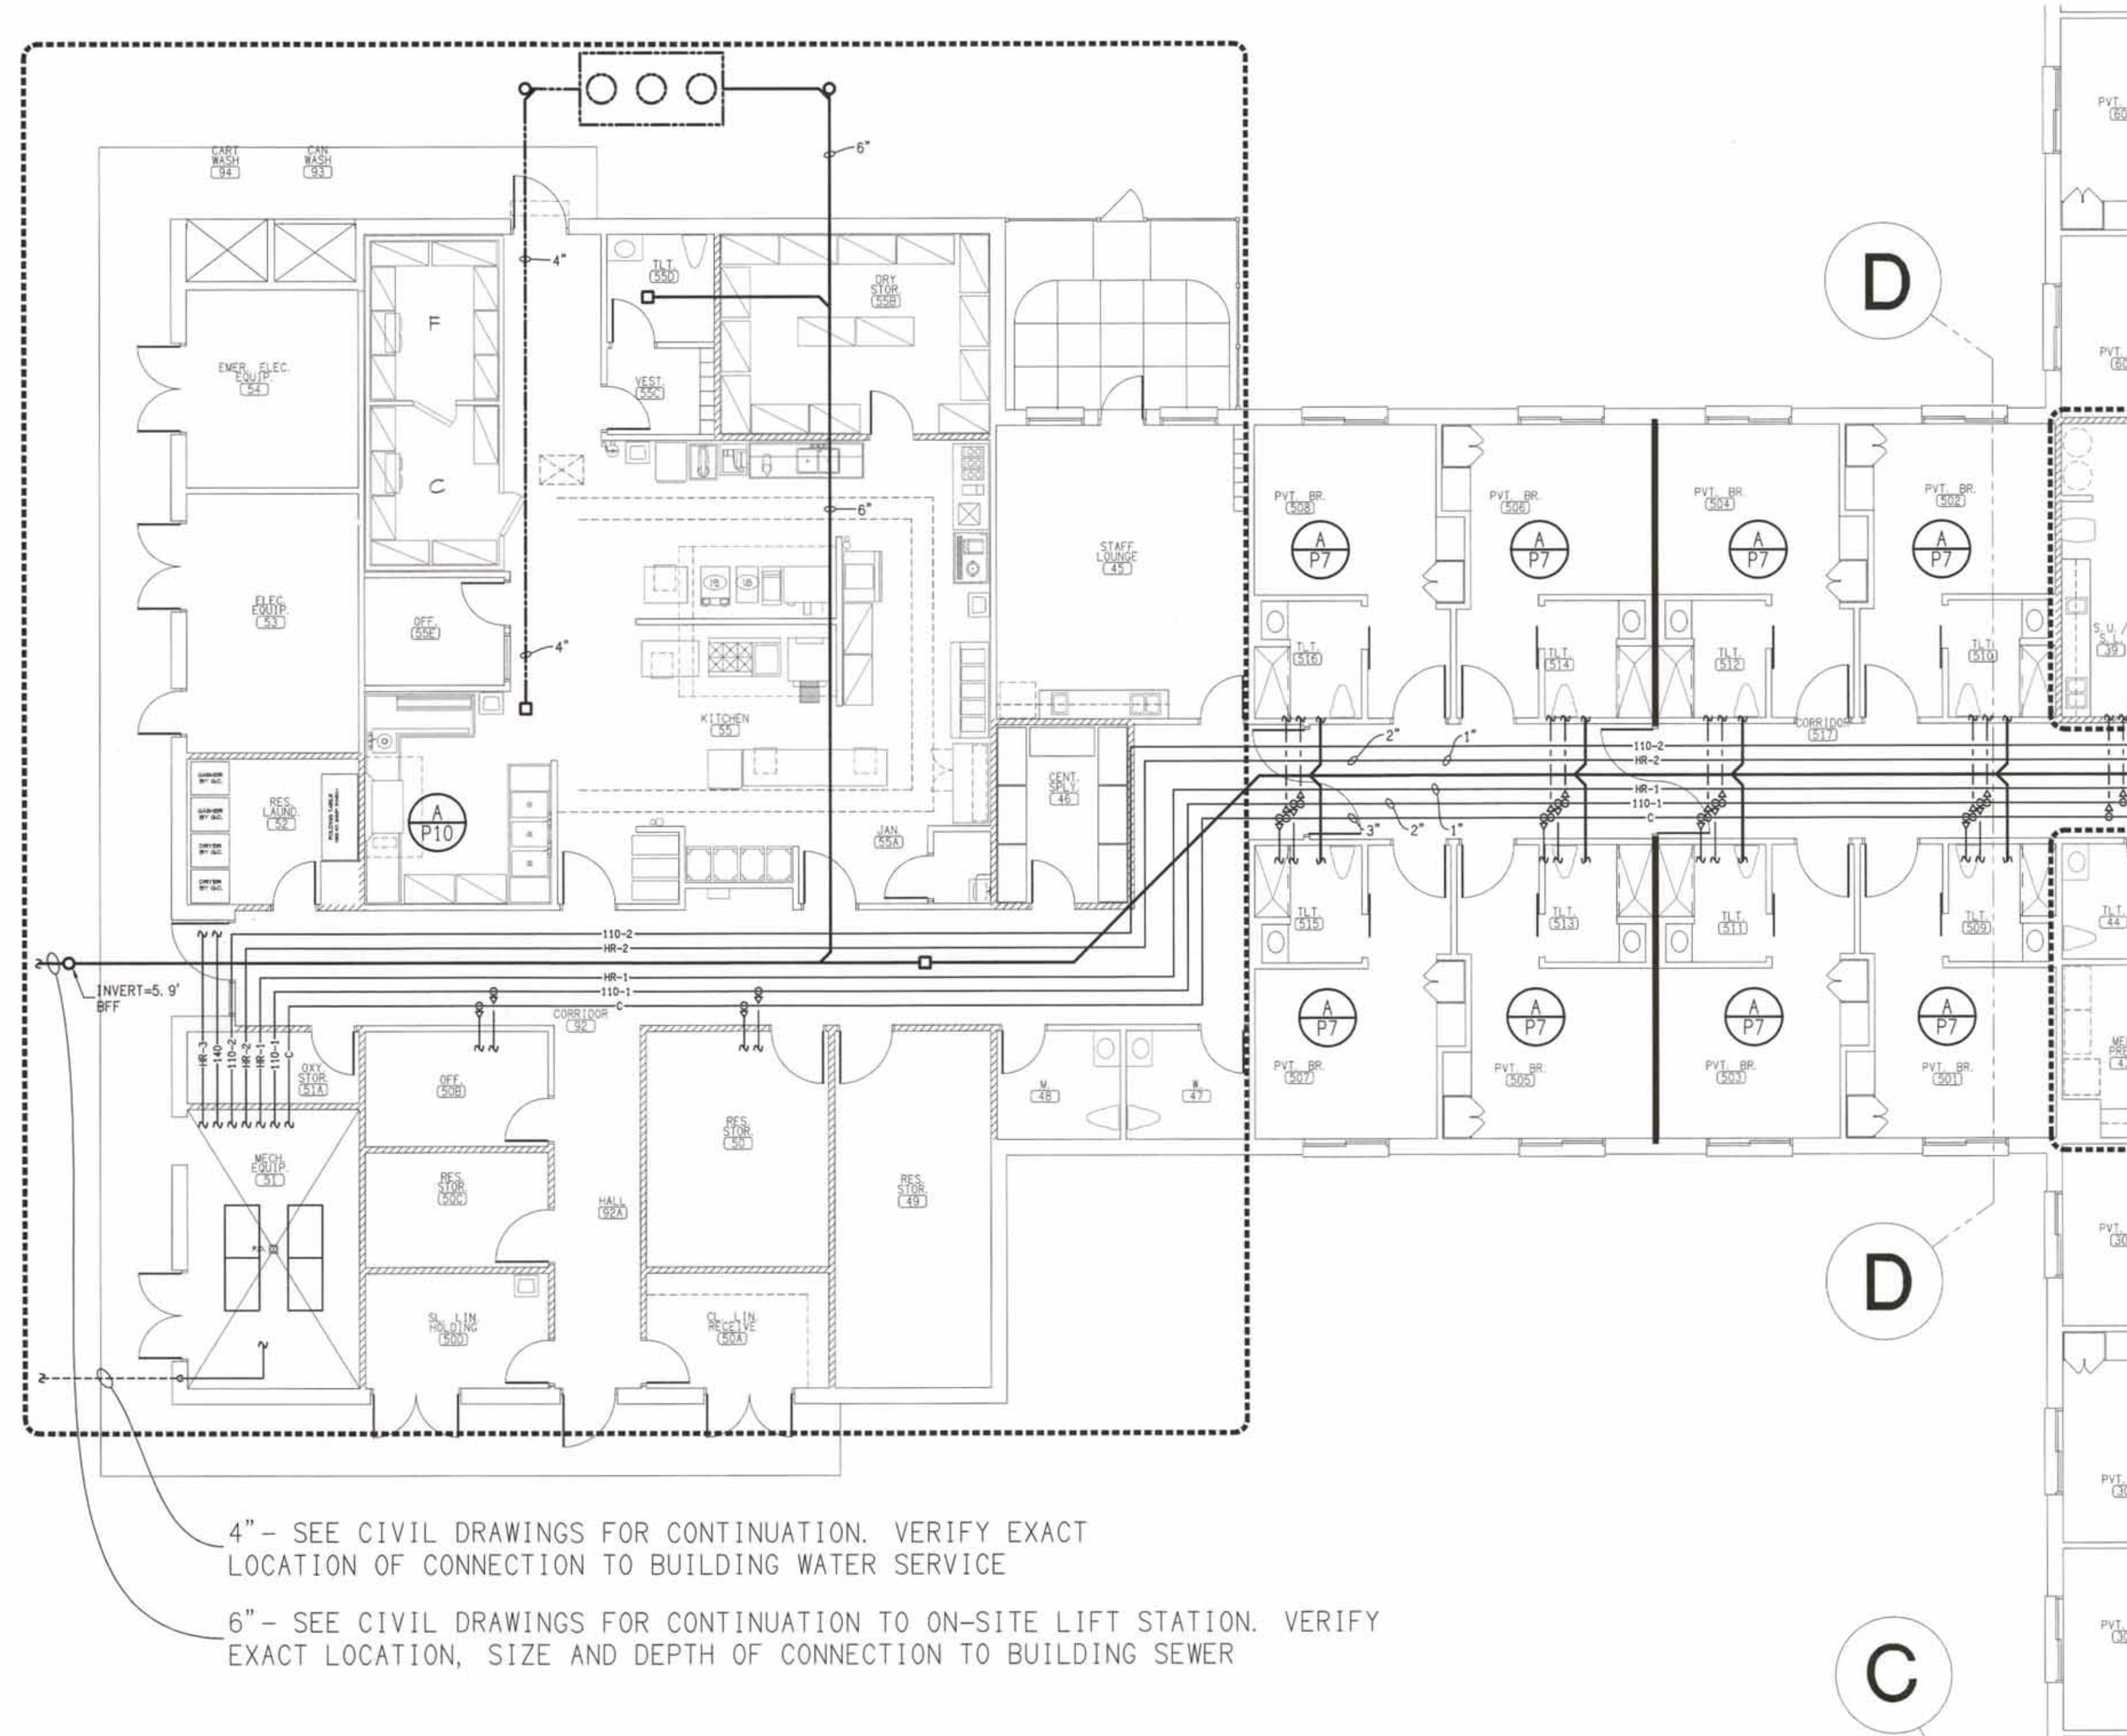

A PARTIAL PLUMBING PLAN
P5 SCALE: 1/8" = 1'-0"

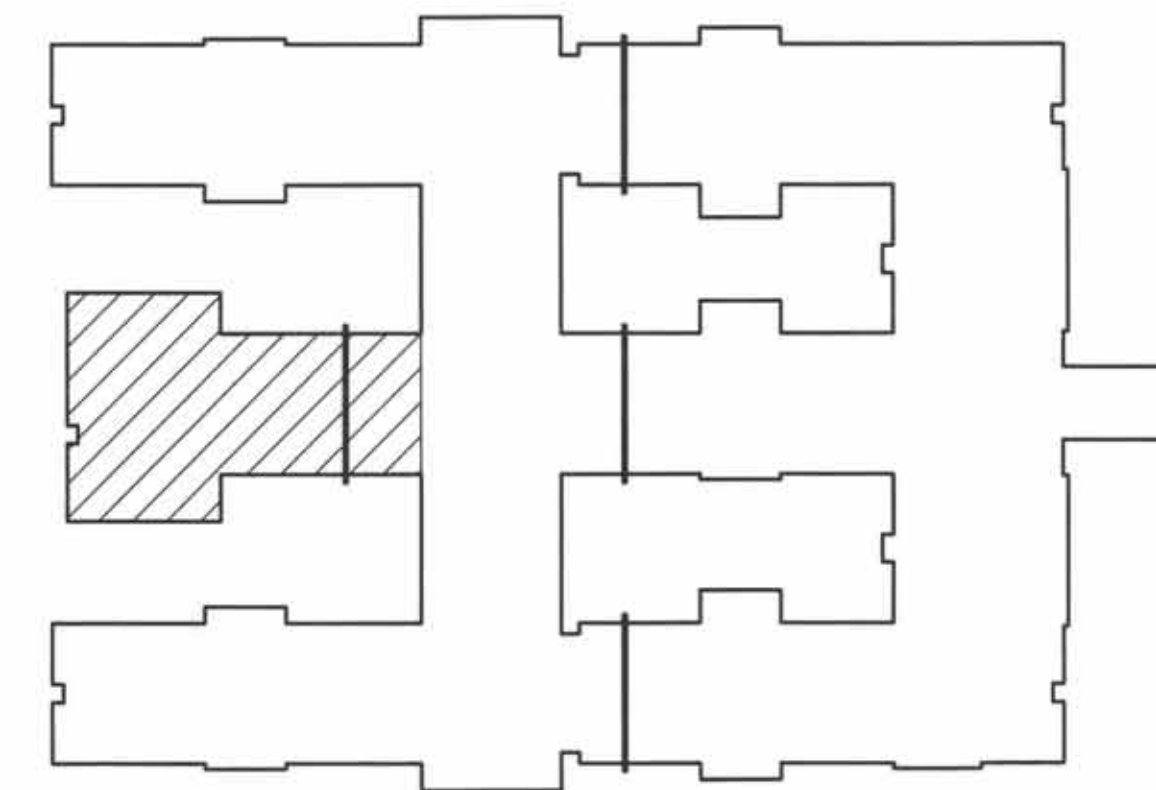

PLAN KEY

symbol	date	description	by
REVISIONS			

DAVID SIMS & ASSOCIATES, P.C.
CONSULTING ENGINEERS
ARBORETUM CENTRE
108 GILES AVE, SUITE 100
WILMINGTON, NC 28403
910.791.8014
NC License: C-1150
www.dsoeng.com


9/27/21

PRUITTHEALTH
CRYSTAL COAST
Beaufort, North Carolina


David R. Polston - Architect
3806 Park Ave. Suite 2-L, Wilmington, NC 28403
Architecture Planning Design

104 BED
NURSING FACILITY




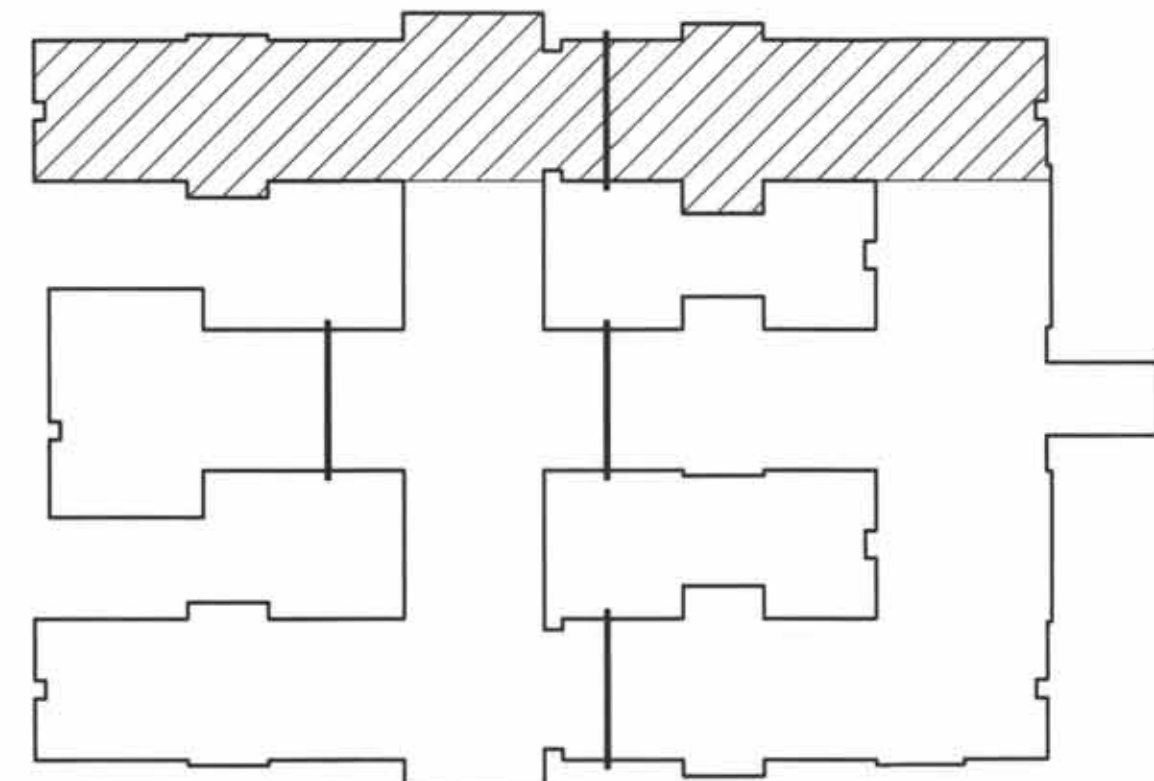

PLAN KEY

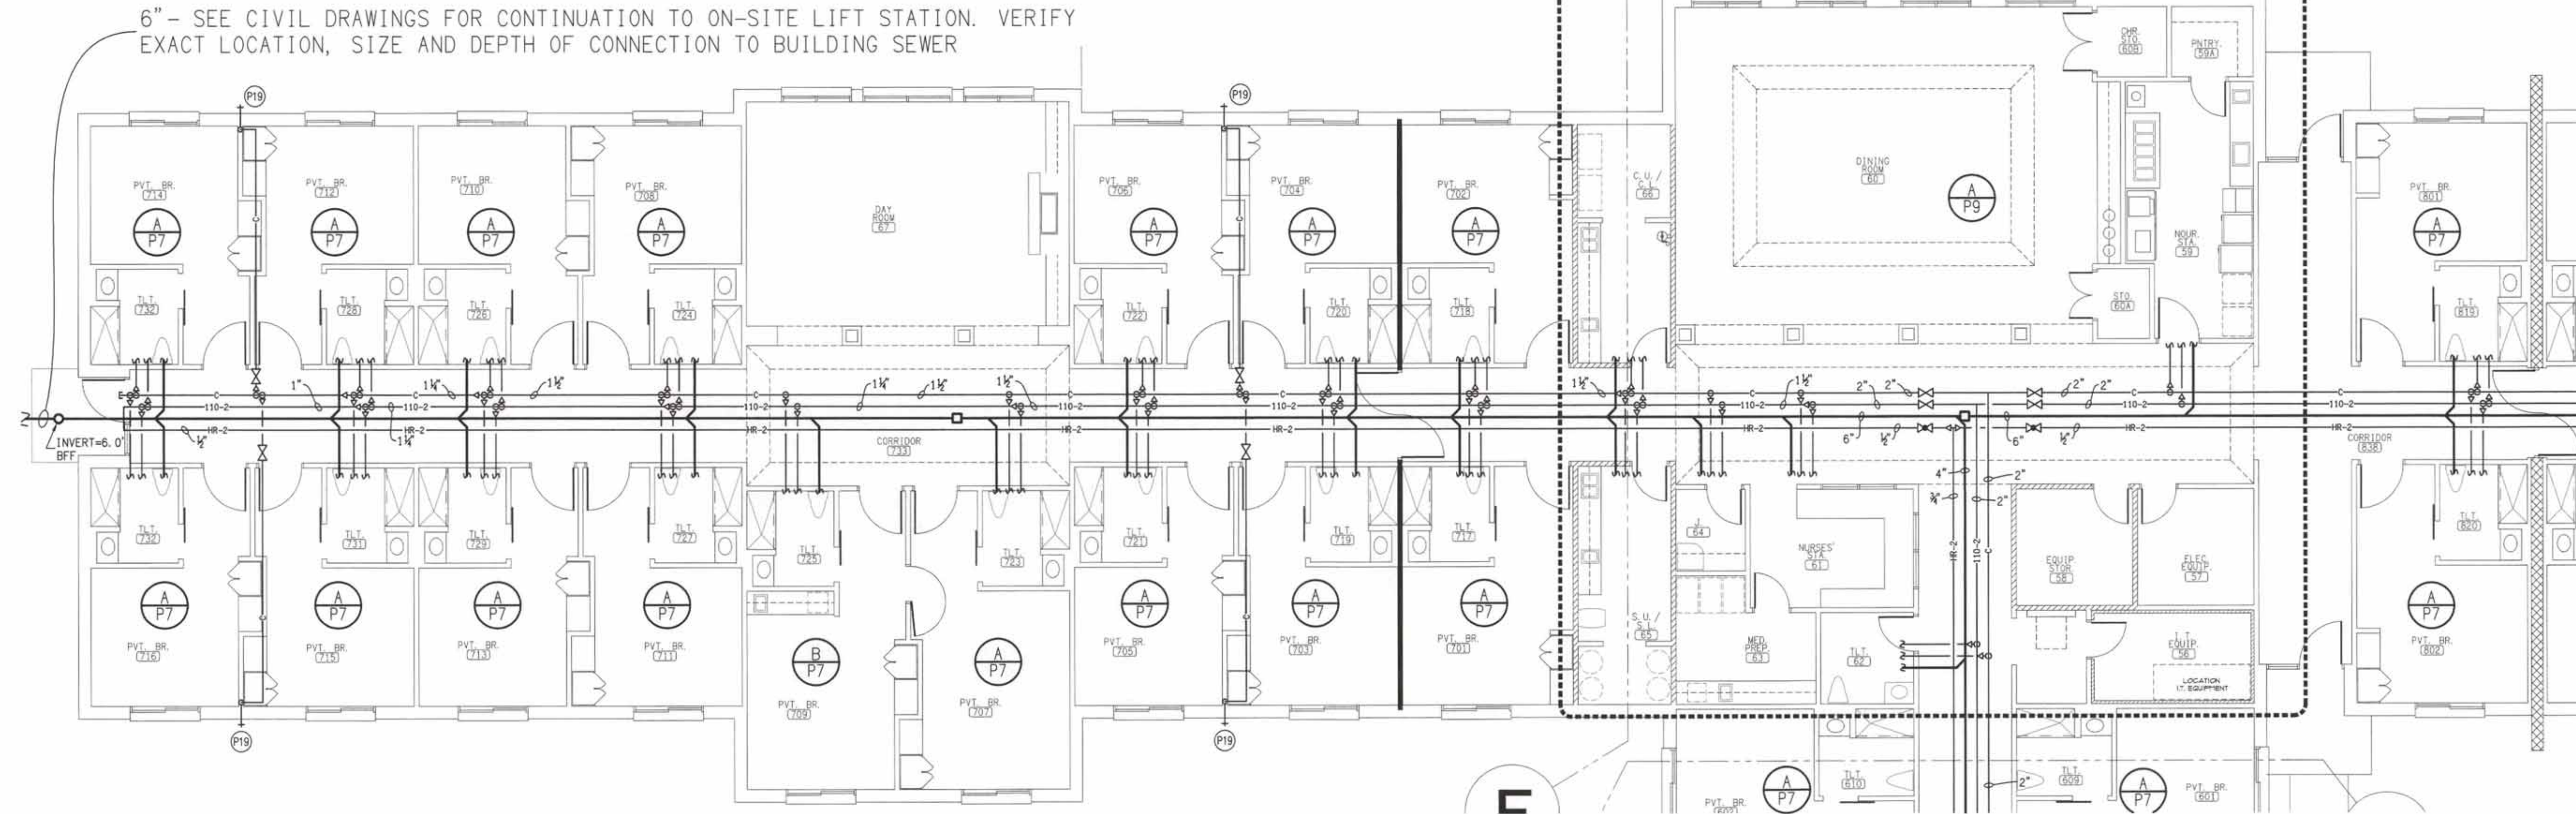

B PARTIAL PLUMBING PLAN
P6 SCALE: 1/8" = 1'-0"

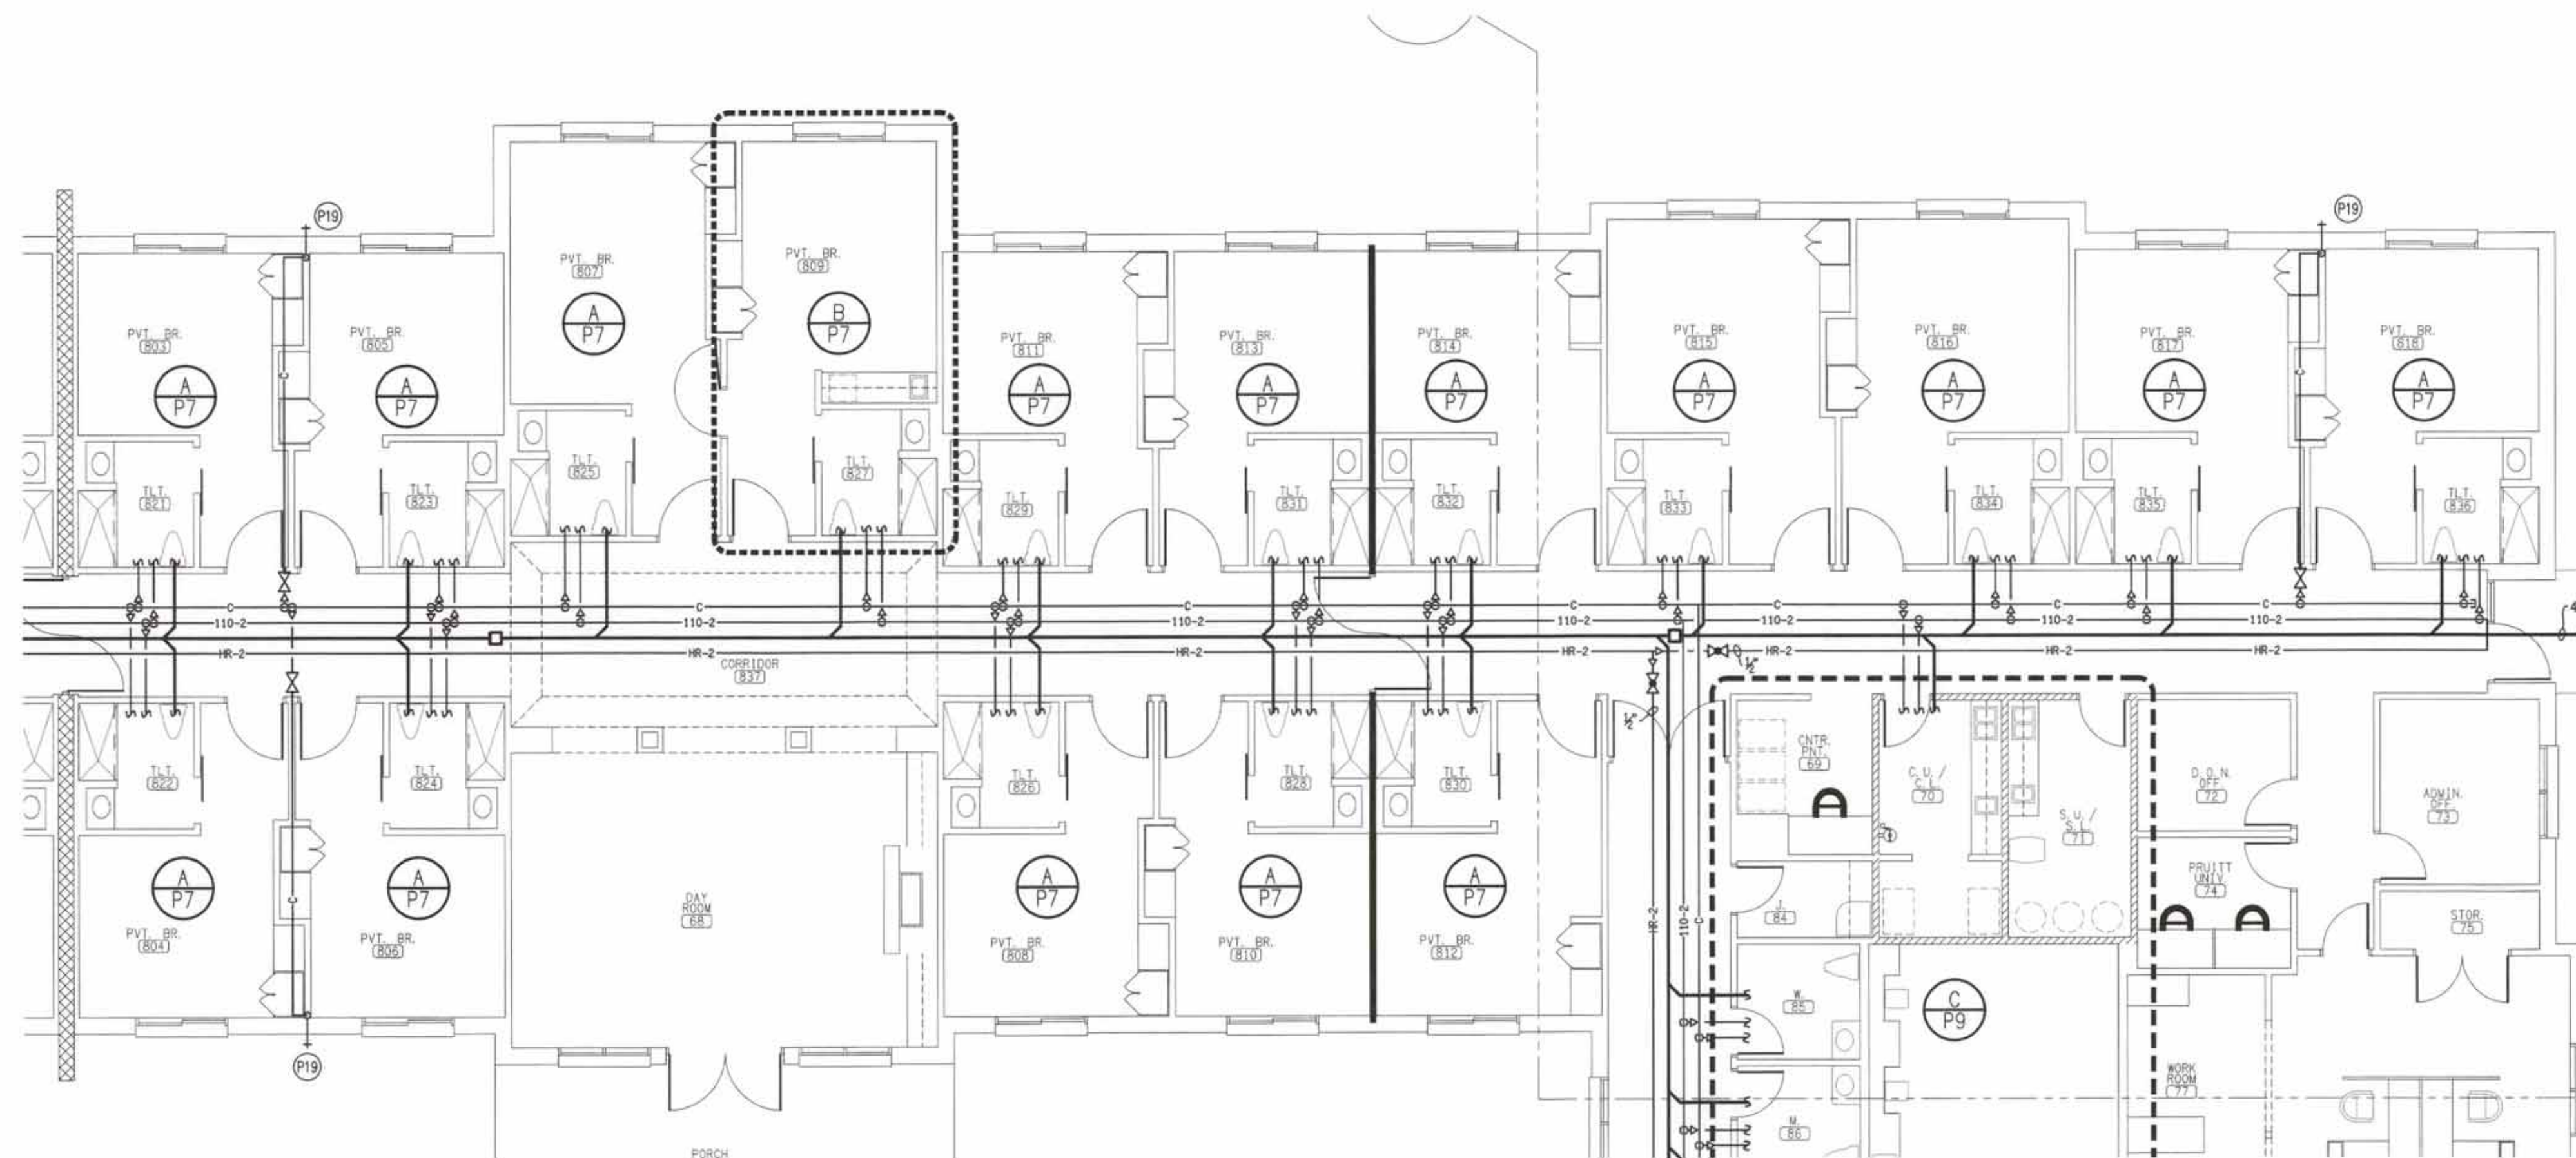

A PARTIAL PLUMBING PLAN
P6 SCALE: 1/8" = 1'-0"

symbol	date	description	by
		REVISIONS	

DSA
ENGINEERING

DAVID SIMS &
ASSOCIATES, P.C.
CONSULTING ENGINEERS

ARBORUM CENTRE
108 GILES AVE, SUITE 100
WILMINGTON, NC 28403
910.791.8016
NC License: C-1150
www.dsaeng.com


NORTH CAROLINA
PROFESSIONAL
ENGINEER
DAVID SIMS
SEAL 007138
9/27/21

PRUITTHEALTH
CRYSTAL COAST
Beaufort, North Carolina


David R. Polston - Architect
3806 Park Ave, Suite 2-L, Wilmington, NC 28403
Architecture Planning Design

104 BED
NURSING FACILITY


P6

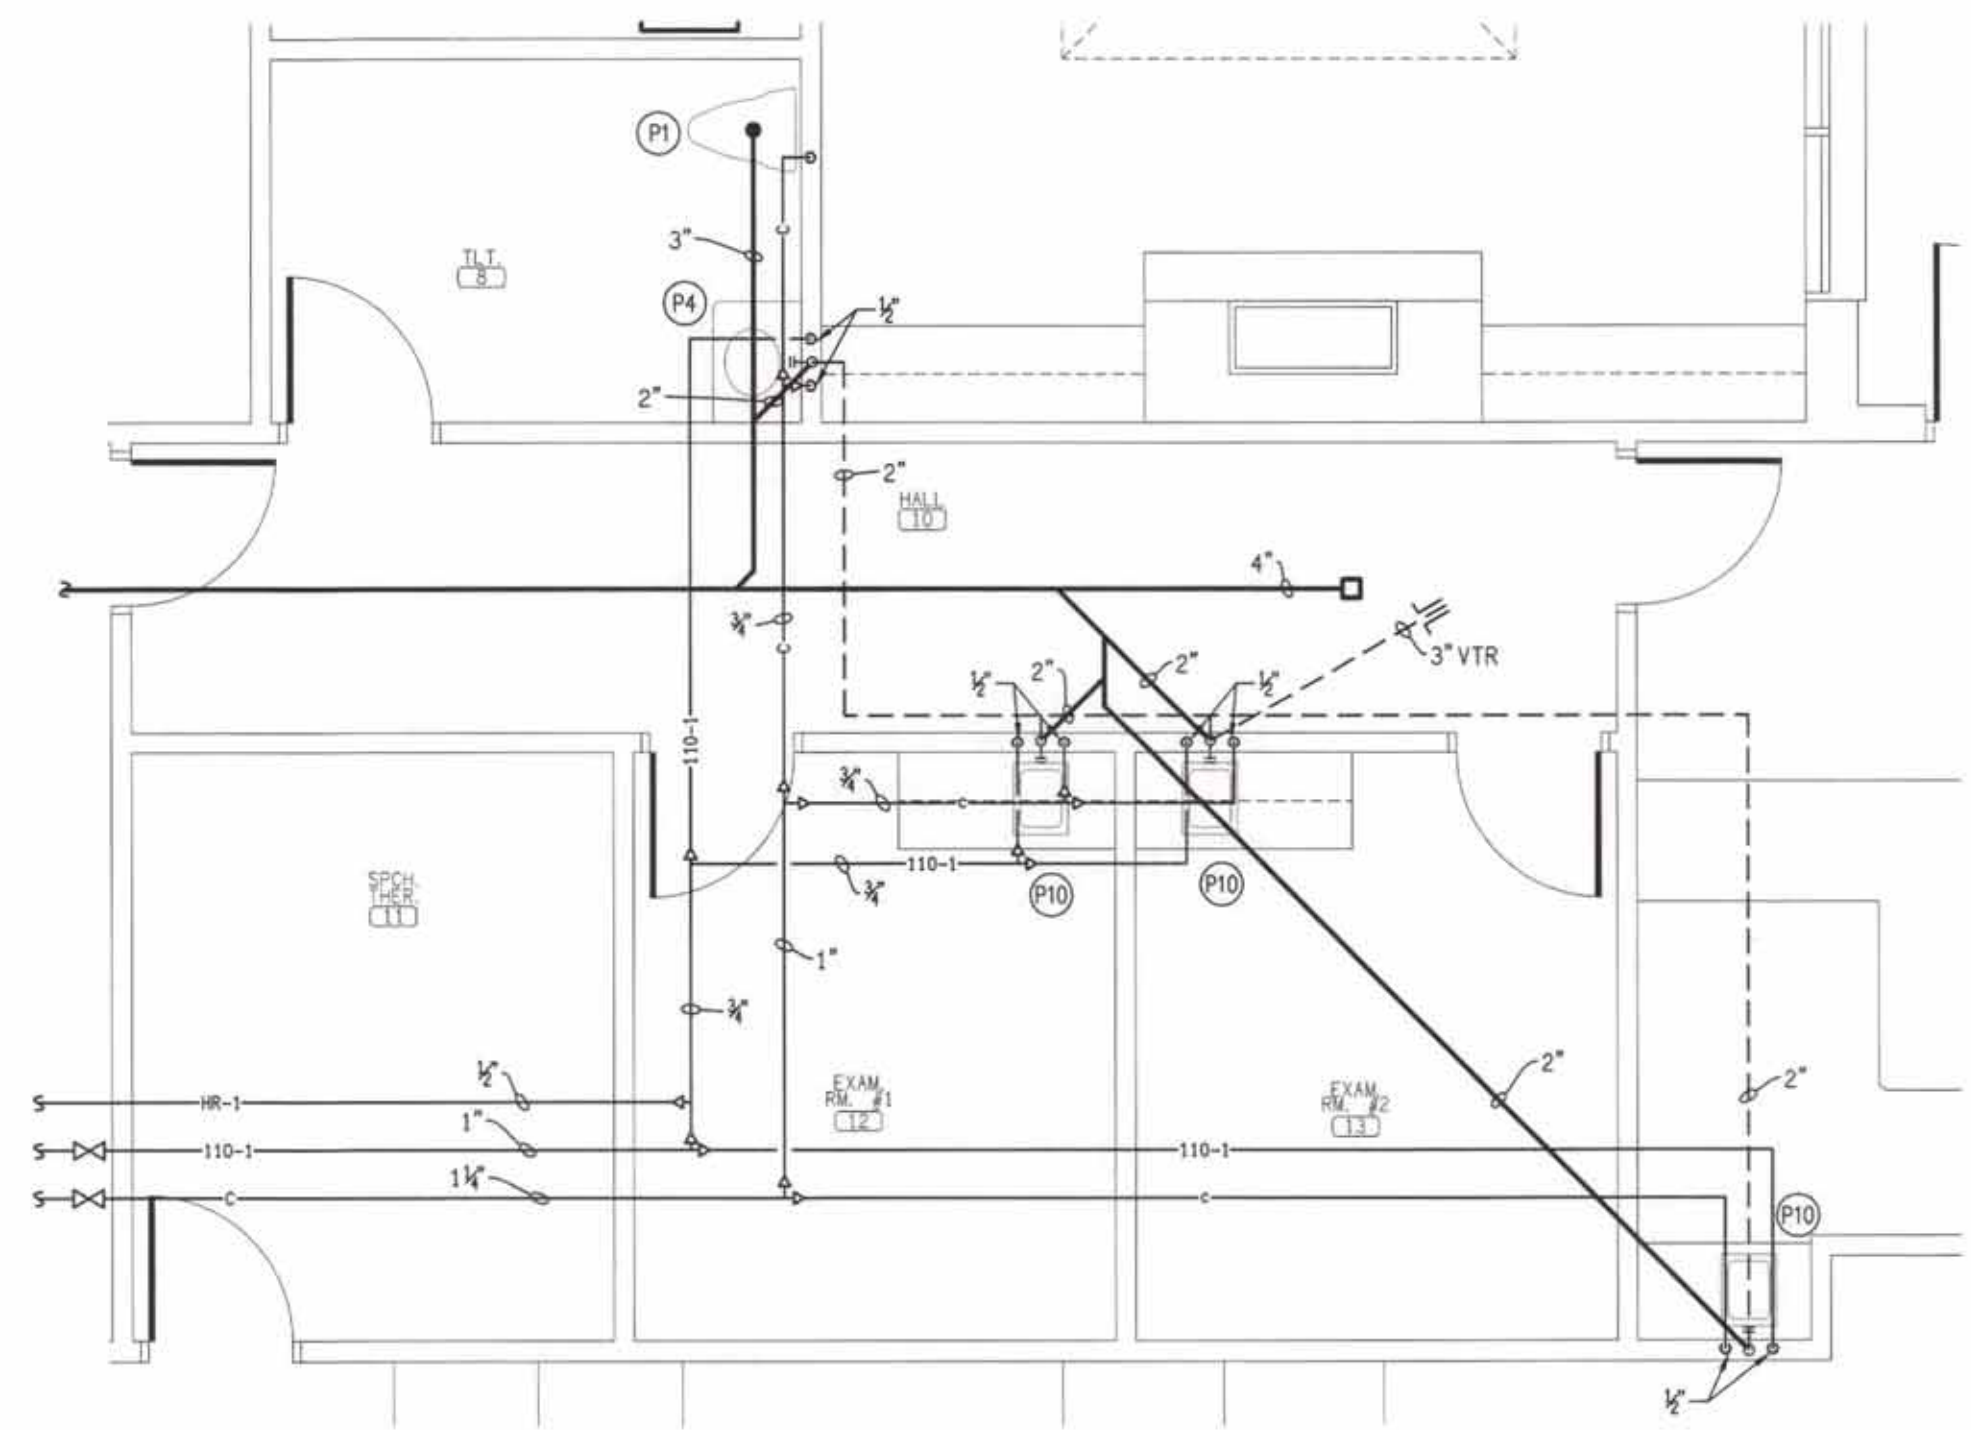


D ENLARGED PLUMBING PLAN
P7 SCALE: 1/4" = 1'-0"

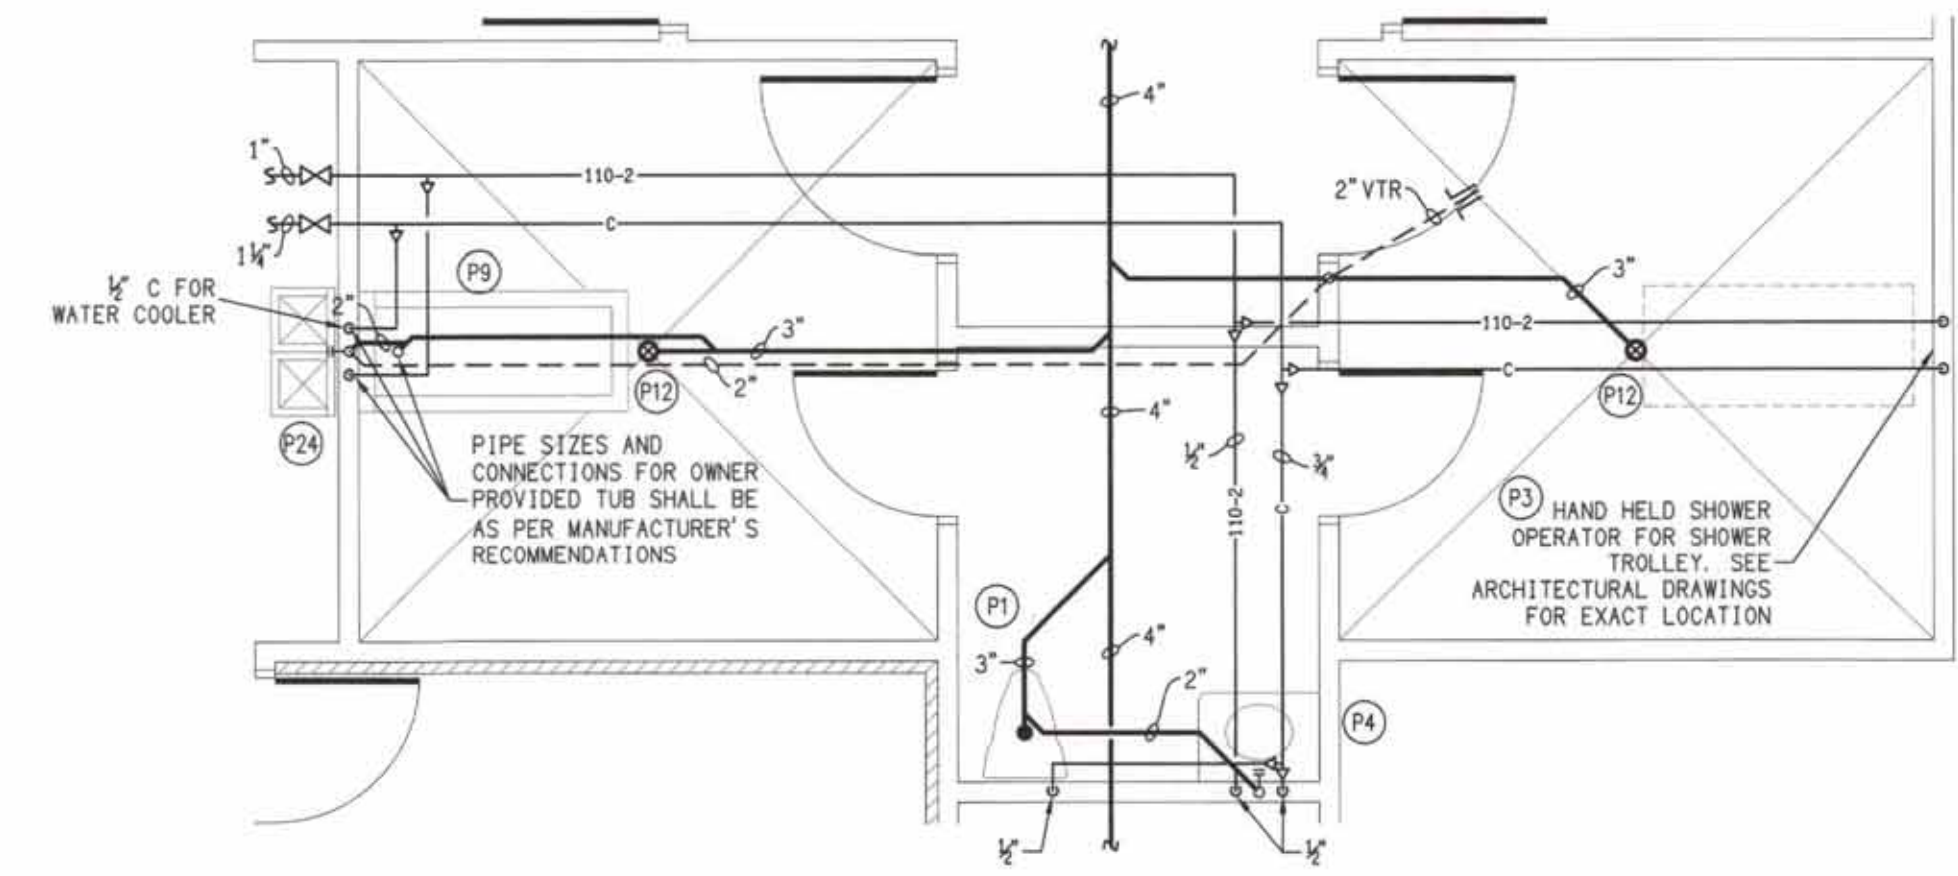


E ENLARGED PLUMBING PLAN
P7 SCALE: 1/4" = 1'-0"

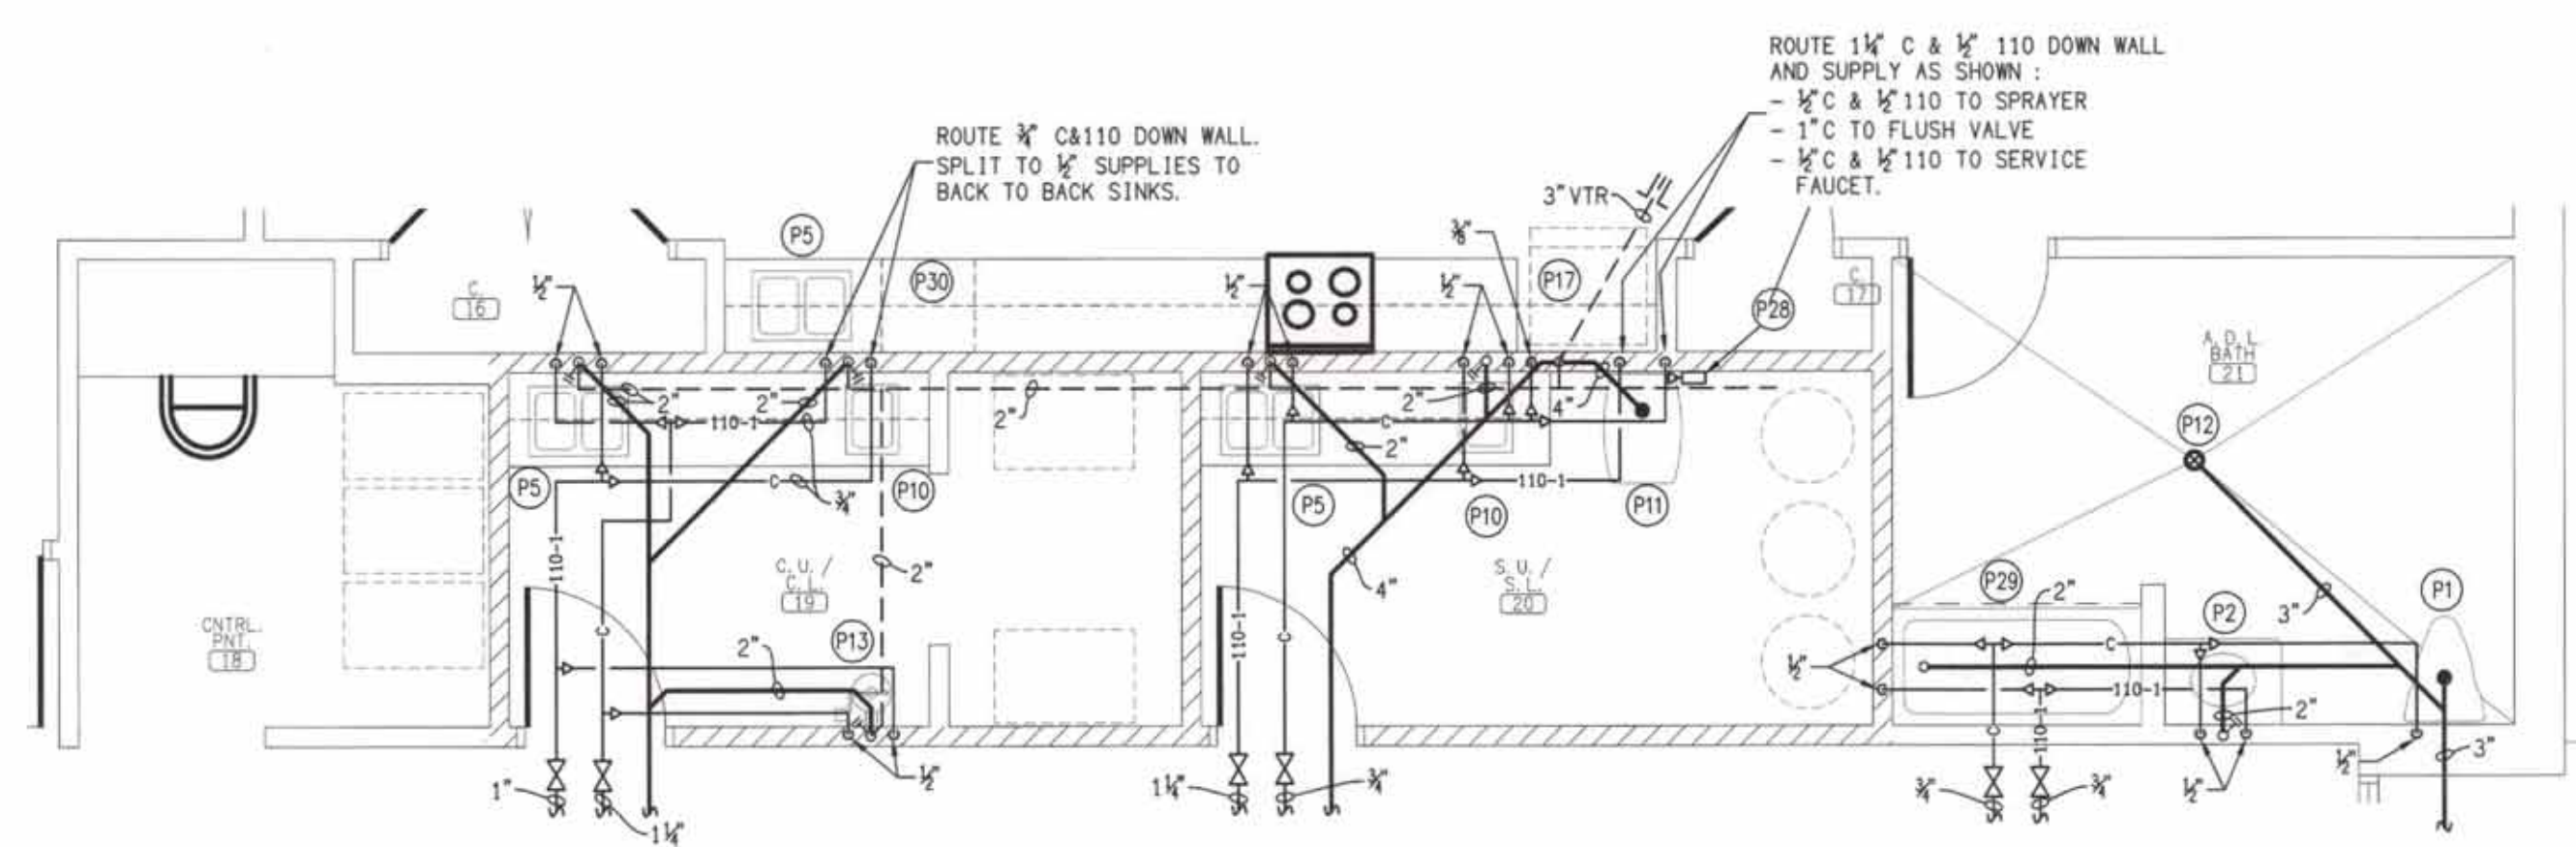


F ENLARGED PLUMBING PLAN
P7 SCALE: 1/4" = 1'-0"

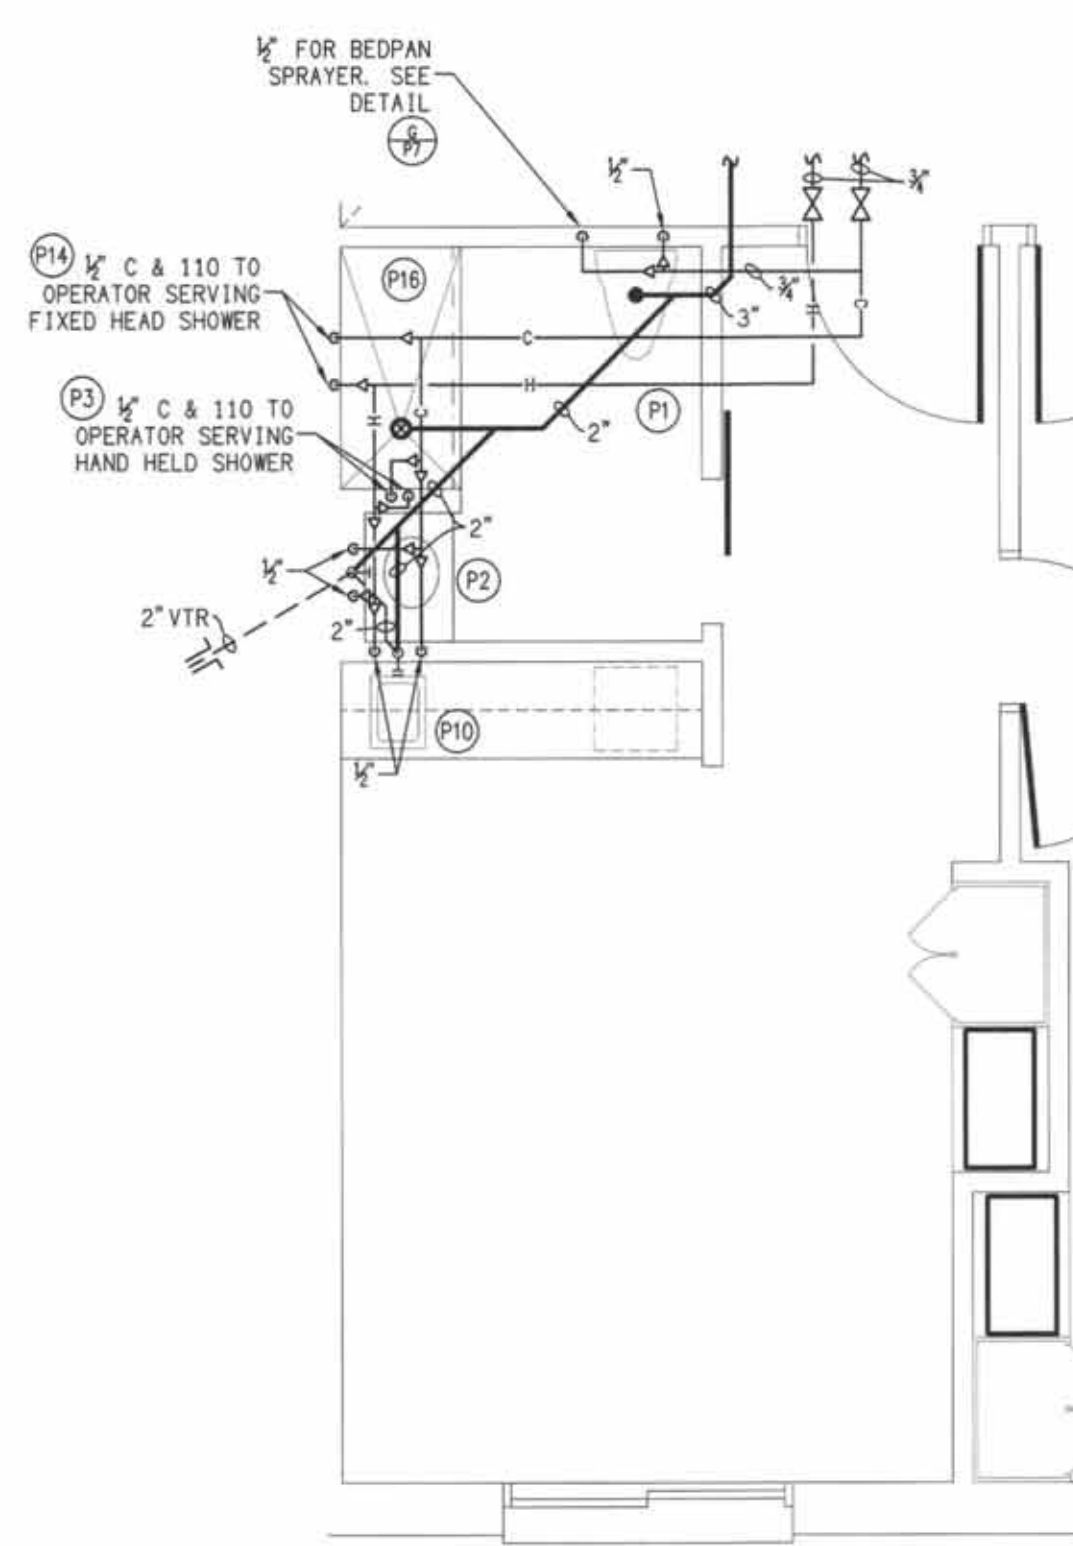


B ENLARGED PLUMBING PLAN
P7 SCALE: 1/4" = 1'-0" TYPICAL ROOM

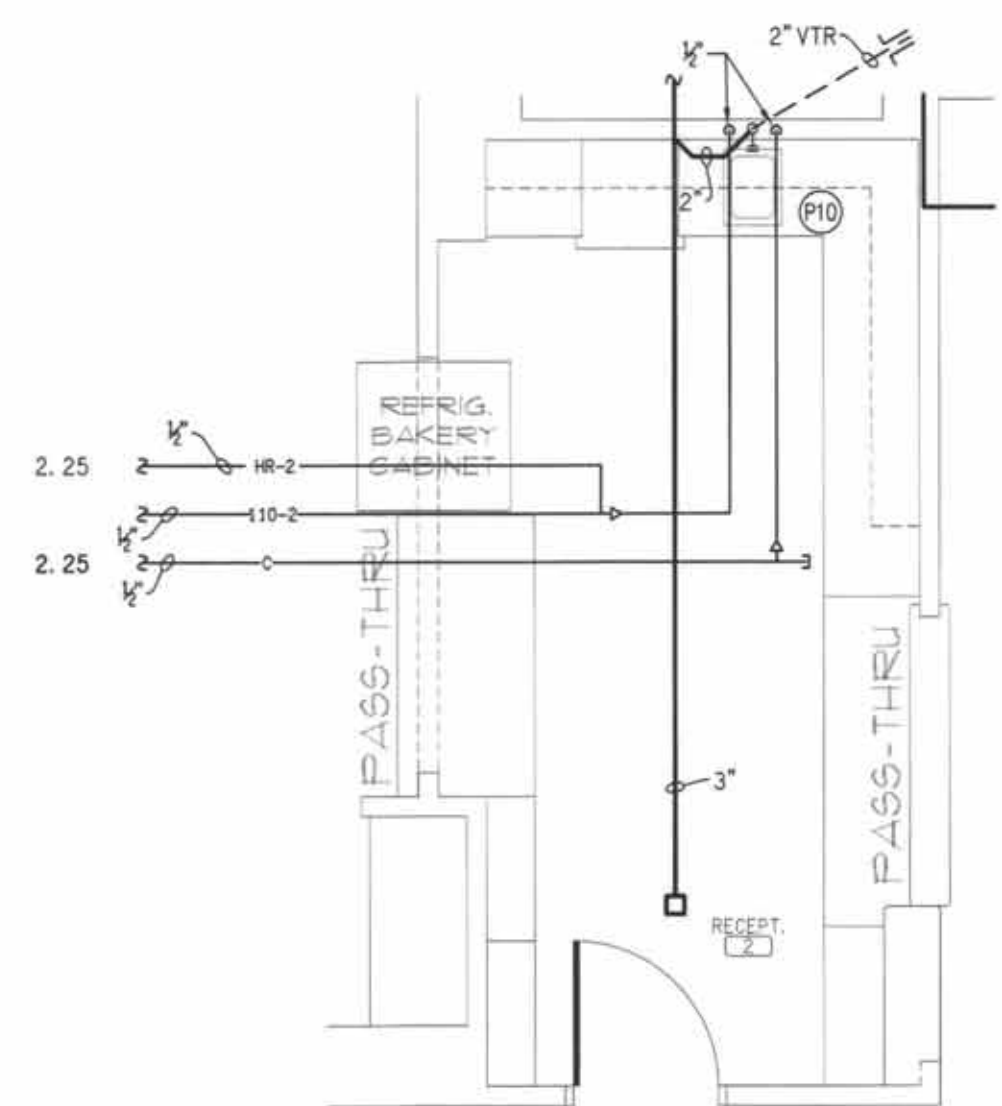

C ENLARGED PLUMBING PLAN
P7 SCALE: 1/4" = 1'-0" RECEPTION

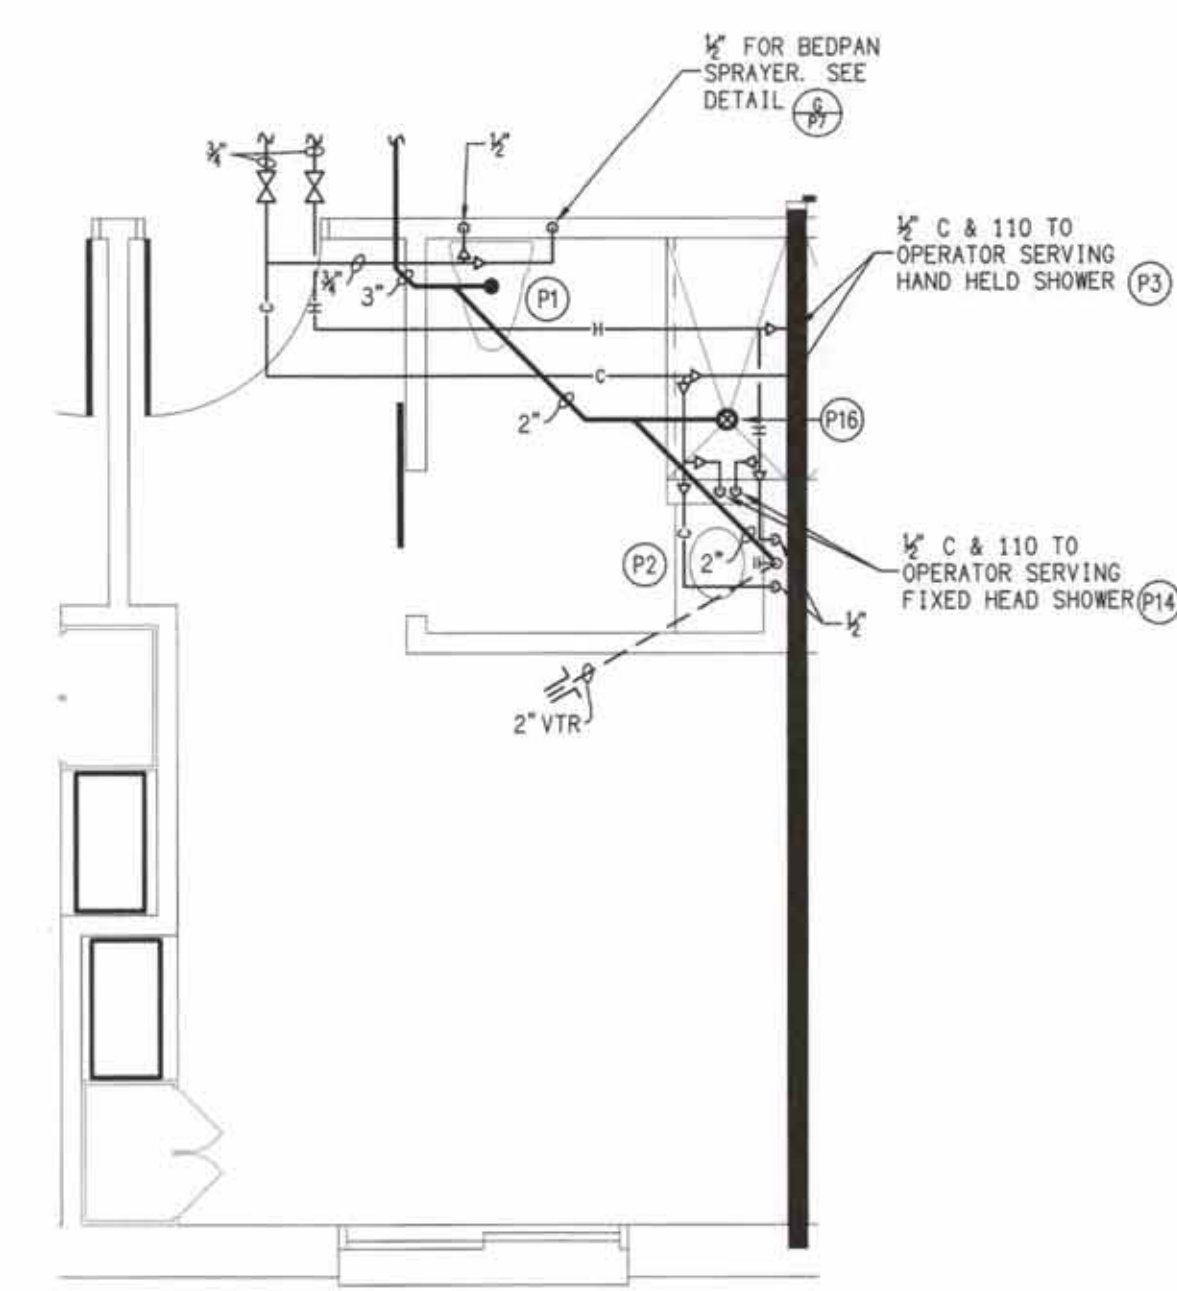

A ENLARGED PLUMBING PLAN
P7 SCALE: 1/4" = 1'-0" TYPICAL ROOM

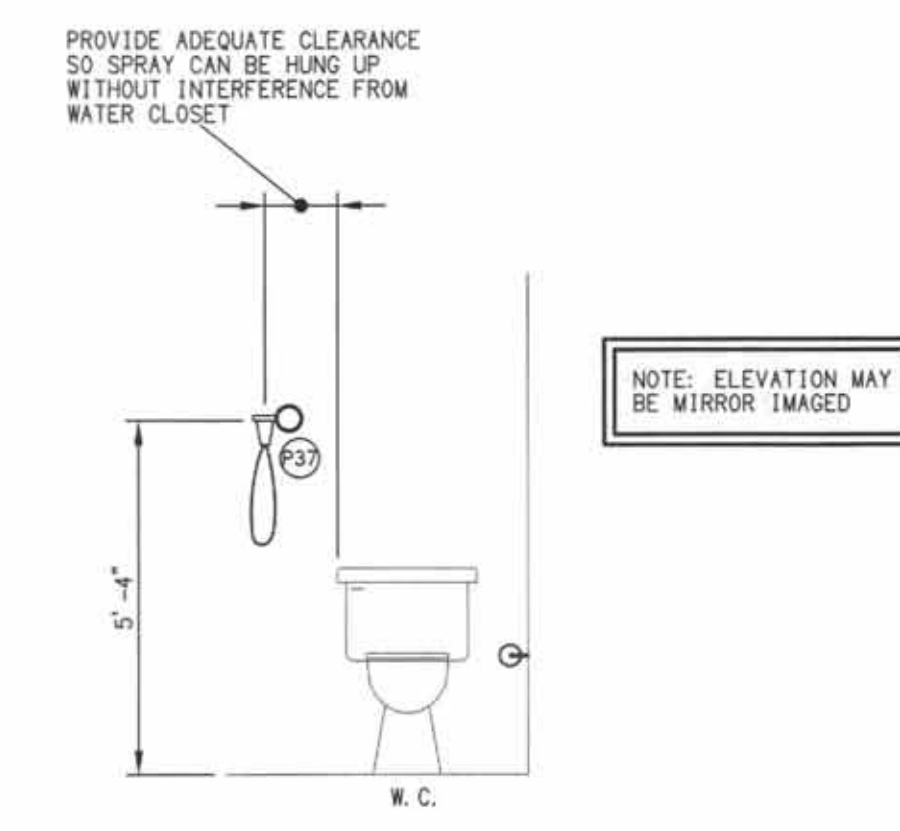

G BEDPAN CLEANSER
P7 NOT TO SCALE

symbol	date	description	by
REVISIONS			

DSA ENGINEERING

DAVID SIMS & ASSOCIATES, P.C.
CONSULTING ENGINEERS

ARBORETUM CENTRE
108 GILES AVE, SUITE 100
WILMINGTON, NC 28403
910.791.8016
NC License: C-1150
www.dsaeng.com


PROFESSIONAL SEAL
007138
DAVID R. POLSTON
9/27/21

PRUITTHEALTH CRYSTAL COAST
Beaufort, North Carolina


David R. Polston - Architect
3806 Park Ave, Suite 2-L, Wilmington, NC 28403
Architecture Planning Design

104 BED NURSING FACILITY


P7

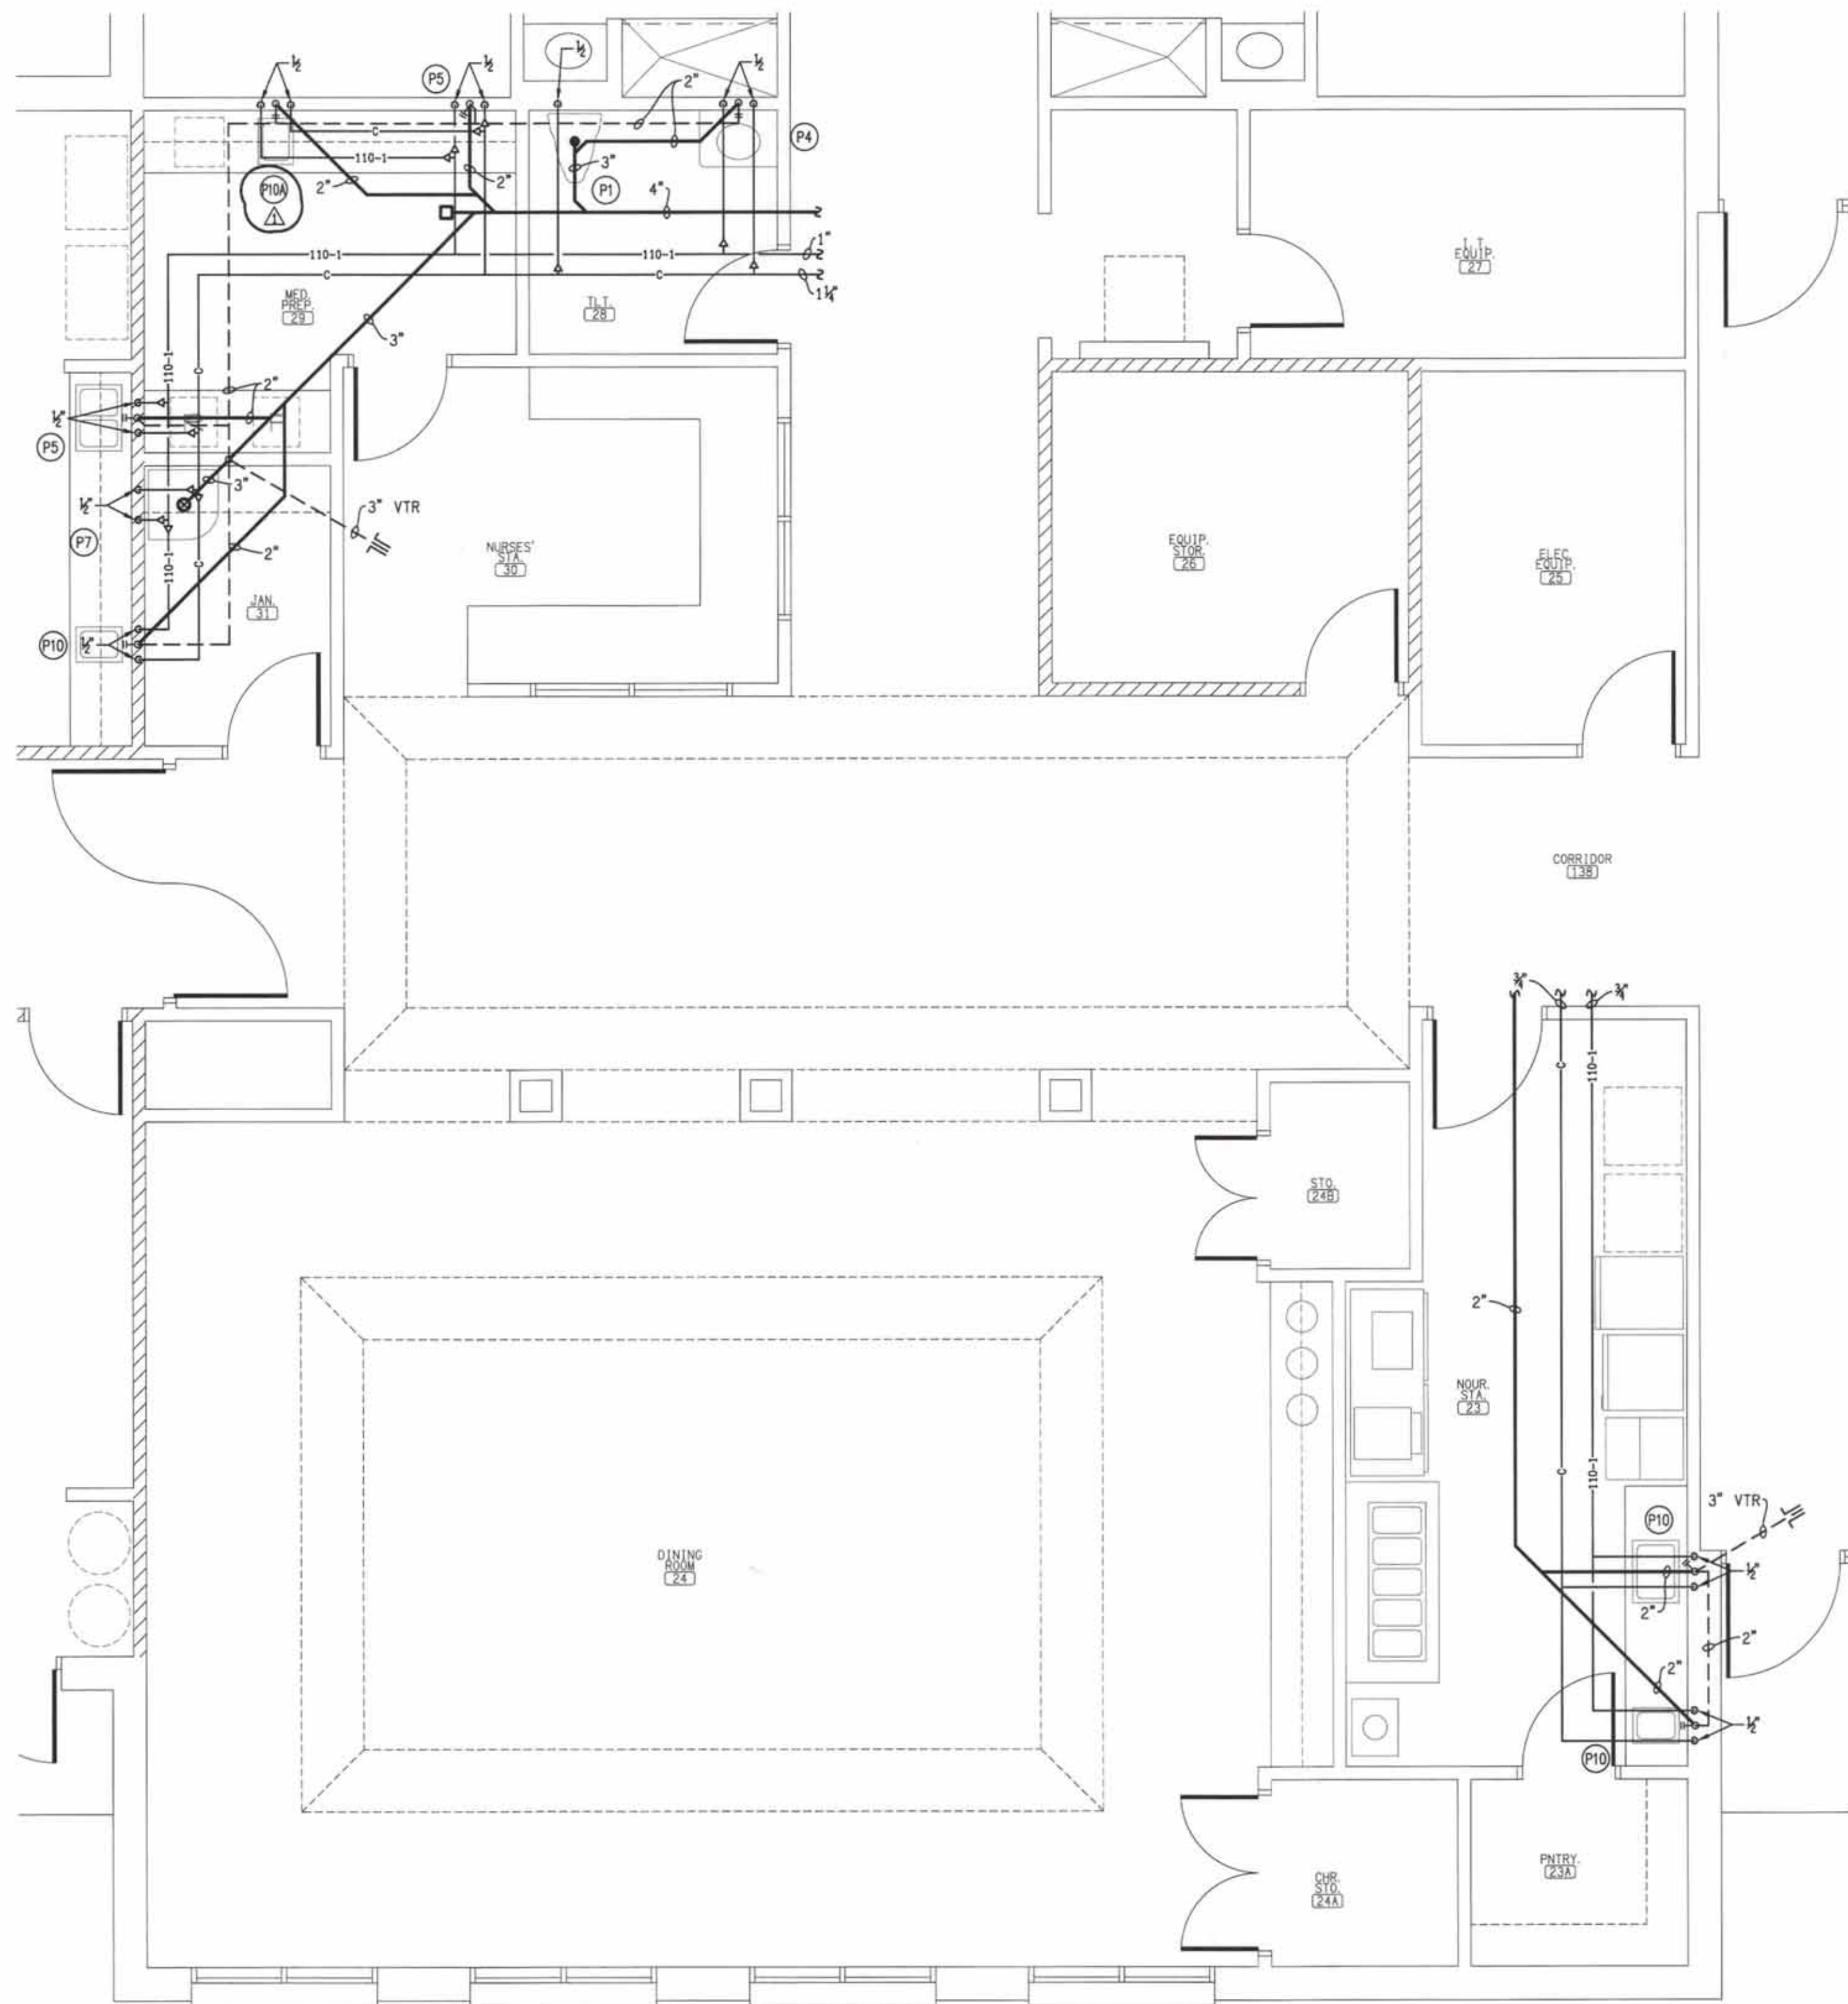

A ENLARGED PLUMBING PLAN
SCALE: 1/4" = 1'-0"
KITCHEN

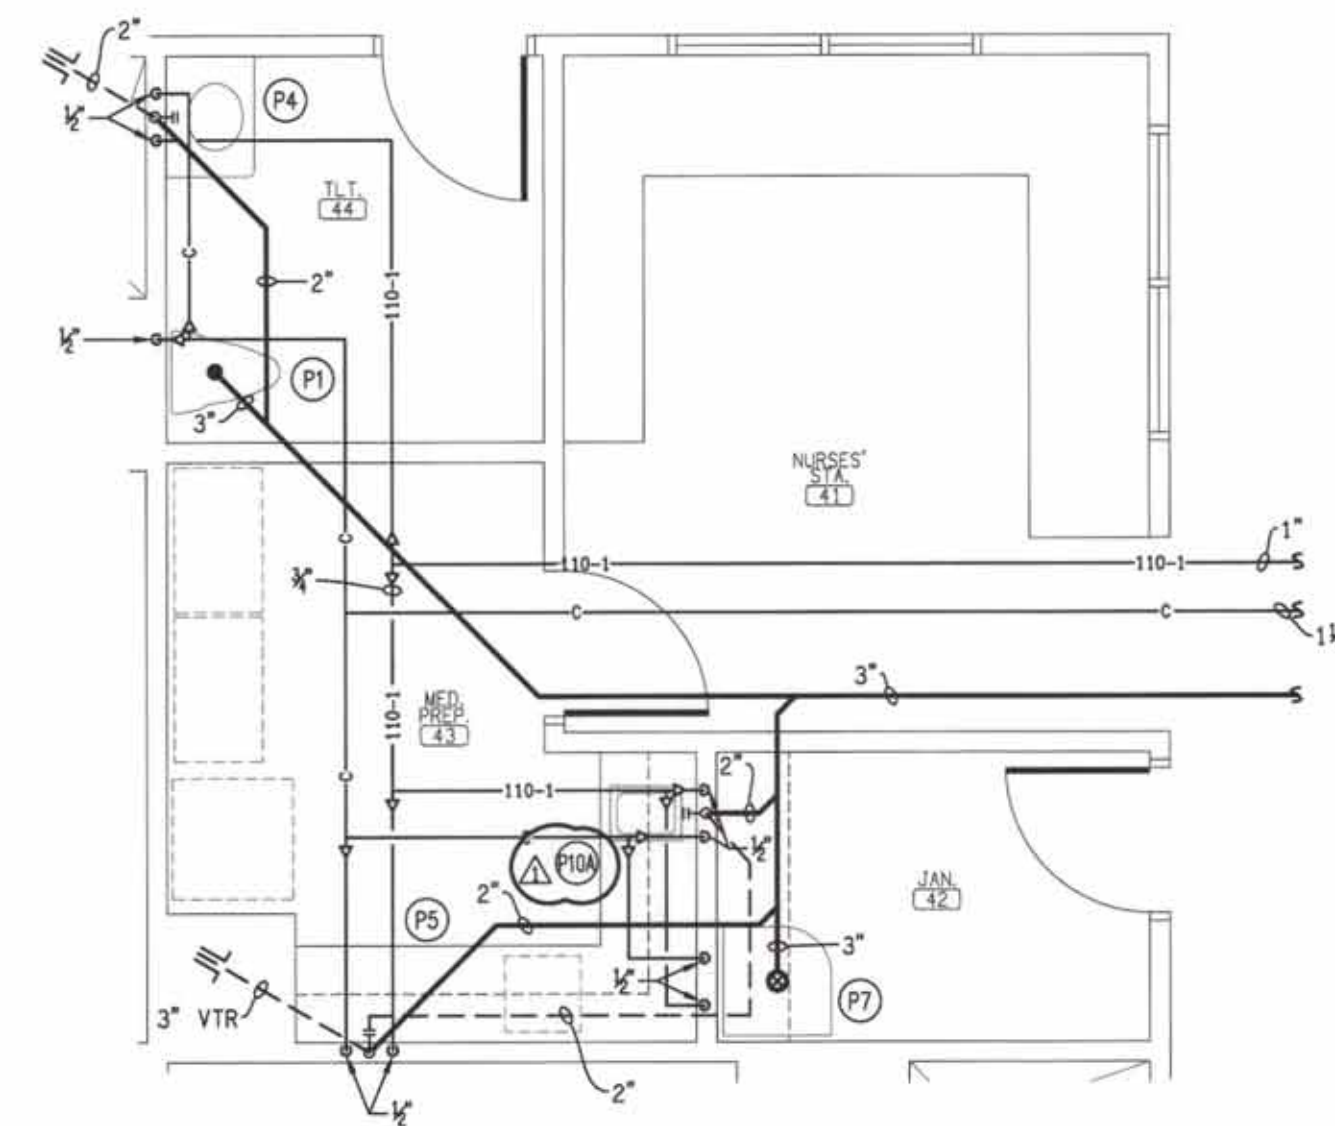

B ENLARGED PLUMBING PLAN
SCALE: 1/4" = 1'-0"
NURSE'S STATION

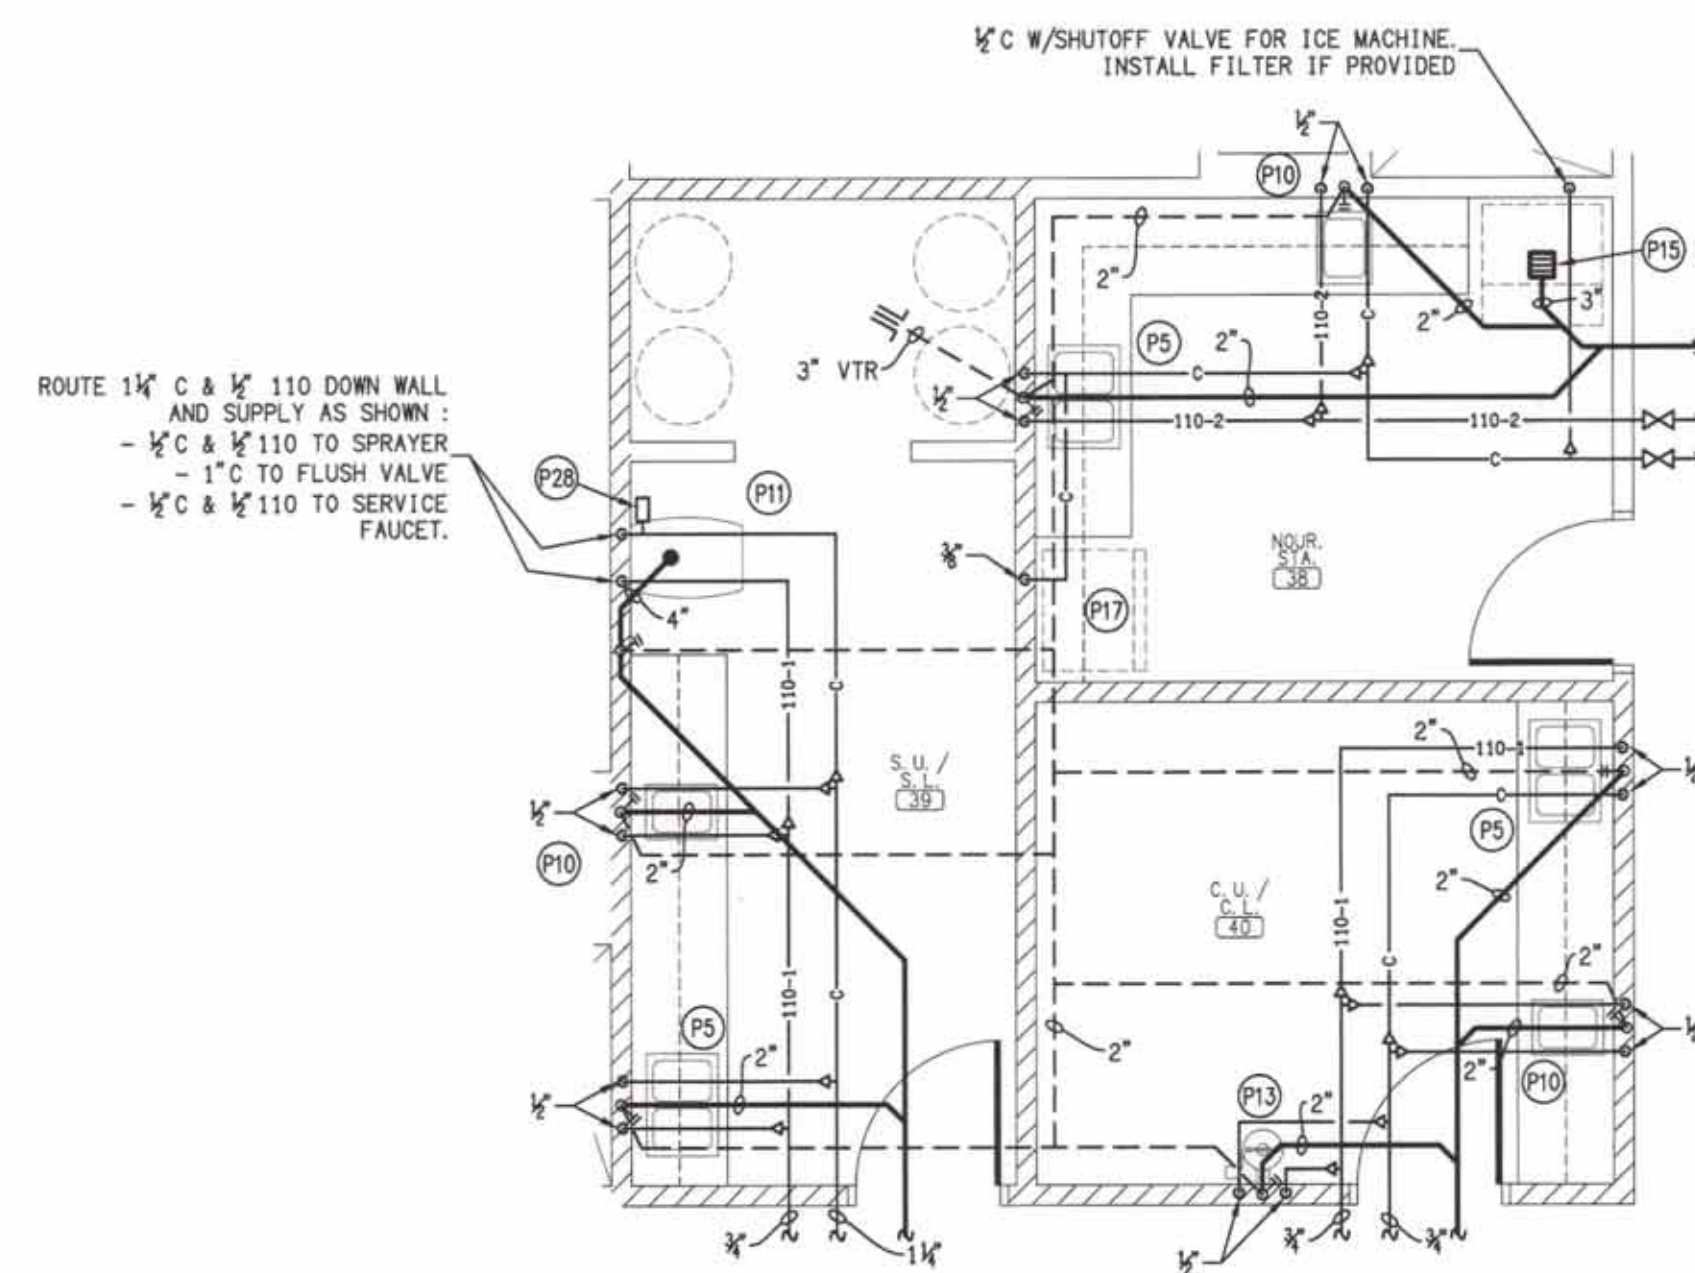

C ENLARGED PLUMBING PLAN
SCALE: 1/4" = 1'-0"

DS
ENGINEERING

DAVID SIMS &
ASSOCIATES, P.C.
CONSULTING ENGINEERS

ARBORETUM CENTRE
108 GILES AVE, SUITE 100
WILMINGTON, NC 28403
910.791.8016
NC License: C-1150
www.dsaeng.com

NORTH CAROLINA
PROFESSIONAL
SEAL
007138
DAVID R. POLSTON, P.E.
10/19/21


PRUITTHEALTH
CRYSTAL COAST
Beaufort, North Carolina

David R. Polston - Architect
3806 Park Ave. Suite 2-L, Wilmington, NC 28403
Architecture Planning Design


104 BED
NURSING FACILITY

P
8

symbol	date	description	by
Δ	10/19/21	DHSR REVIEW	DBS
REVISIONS			

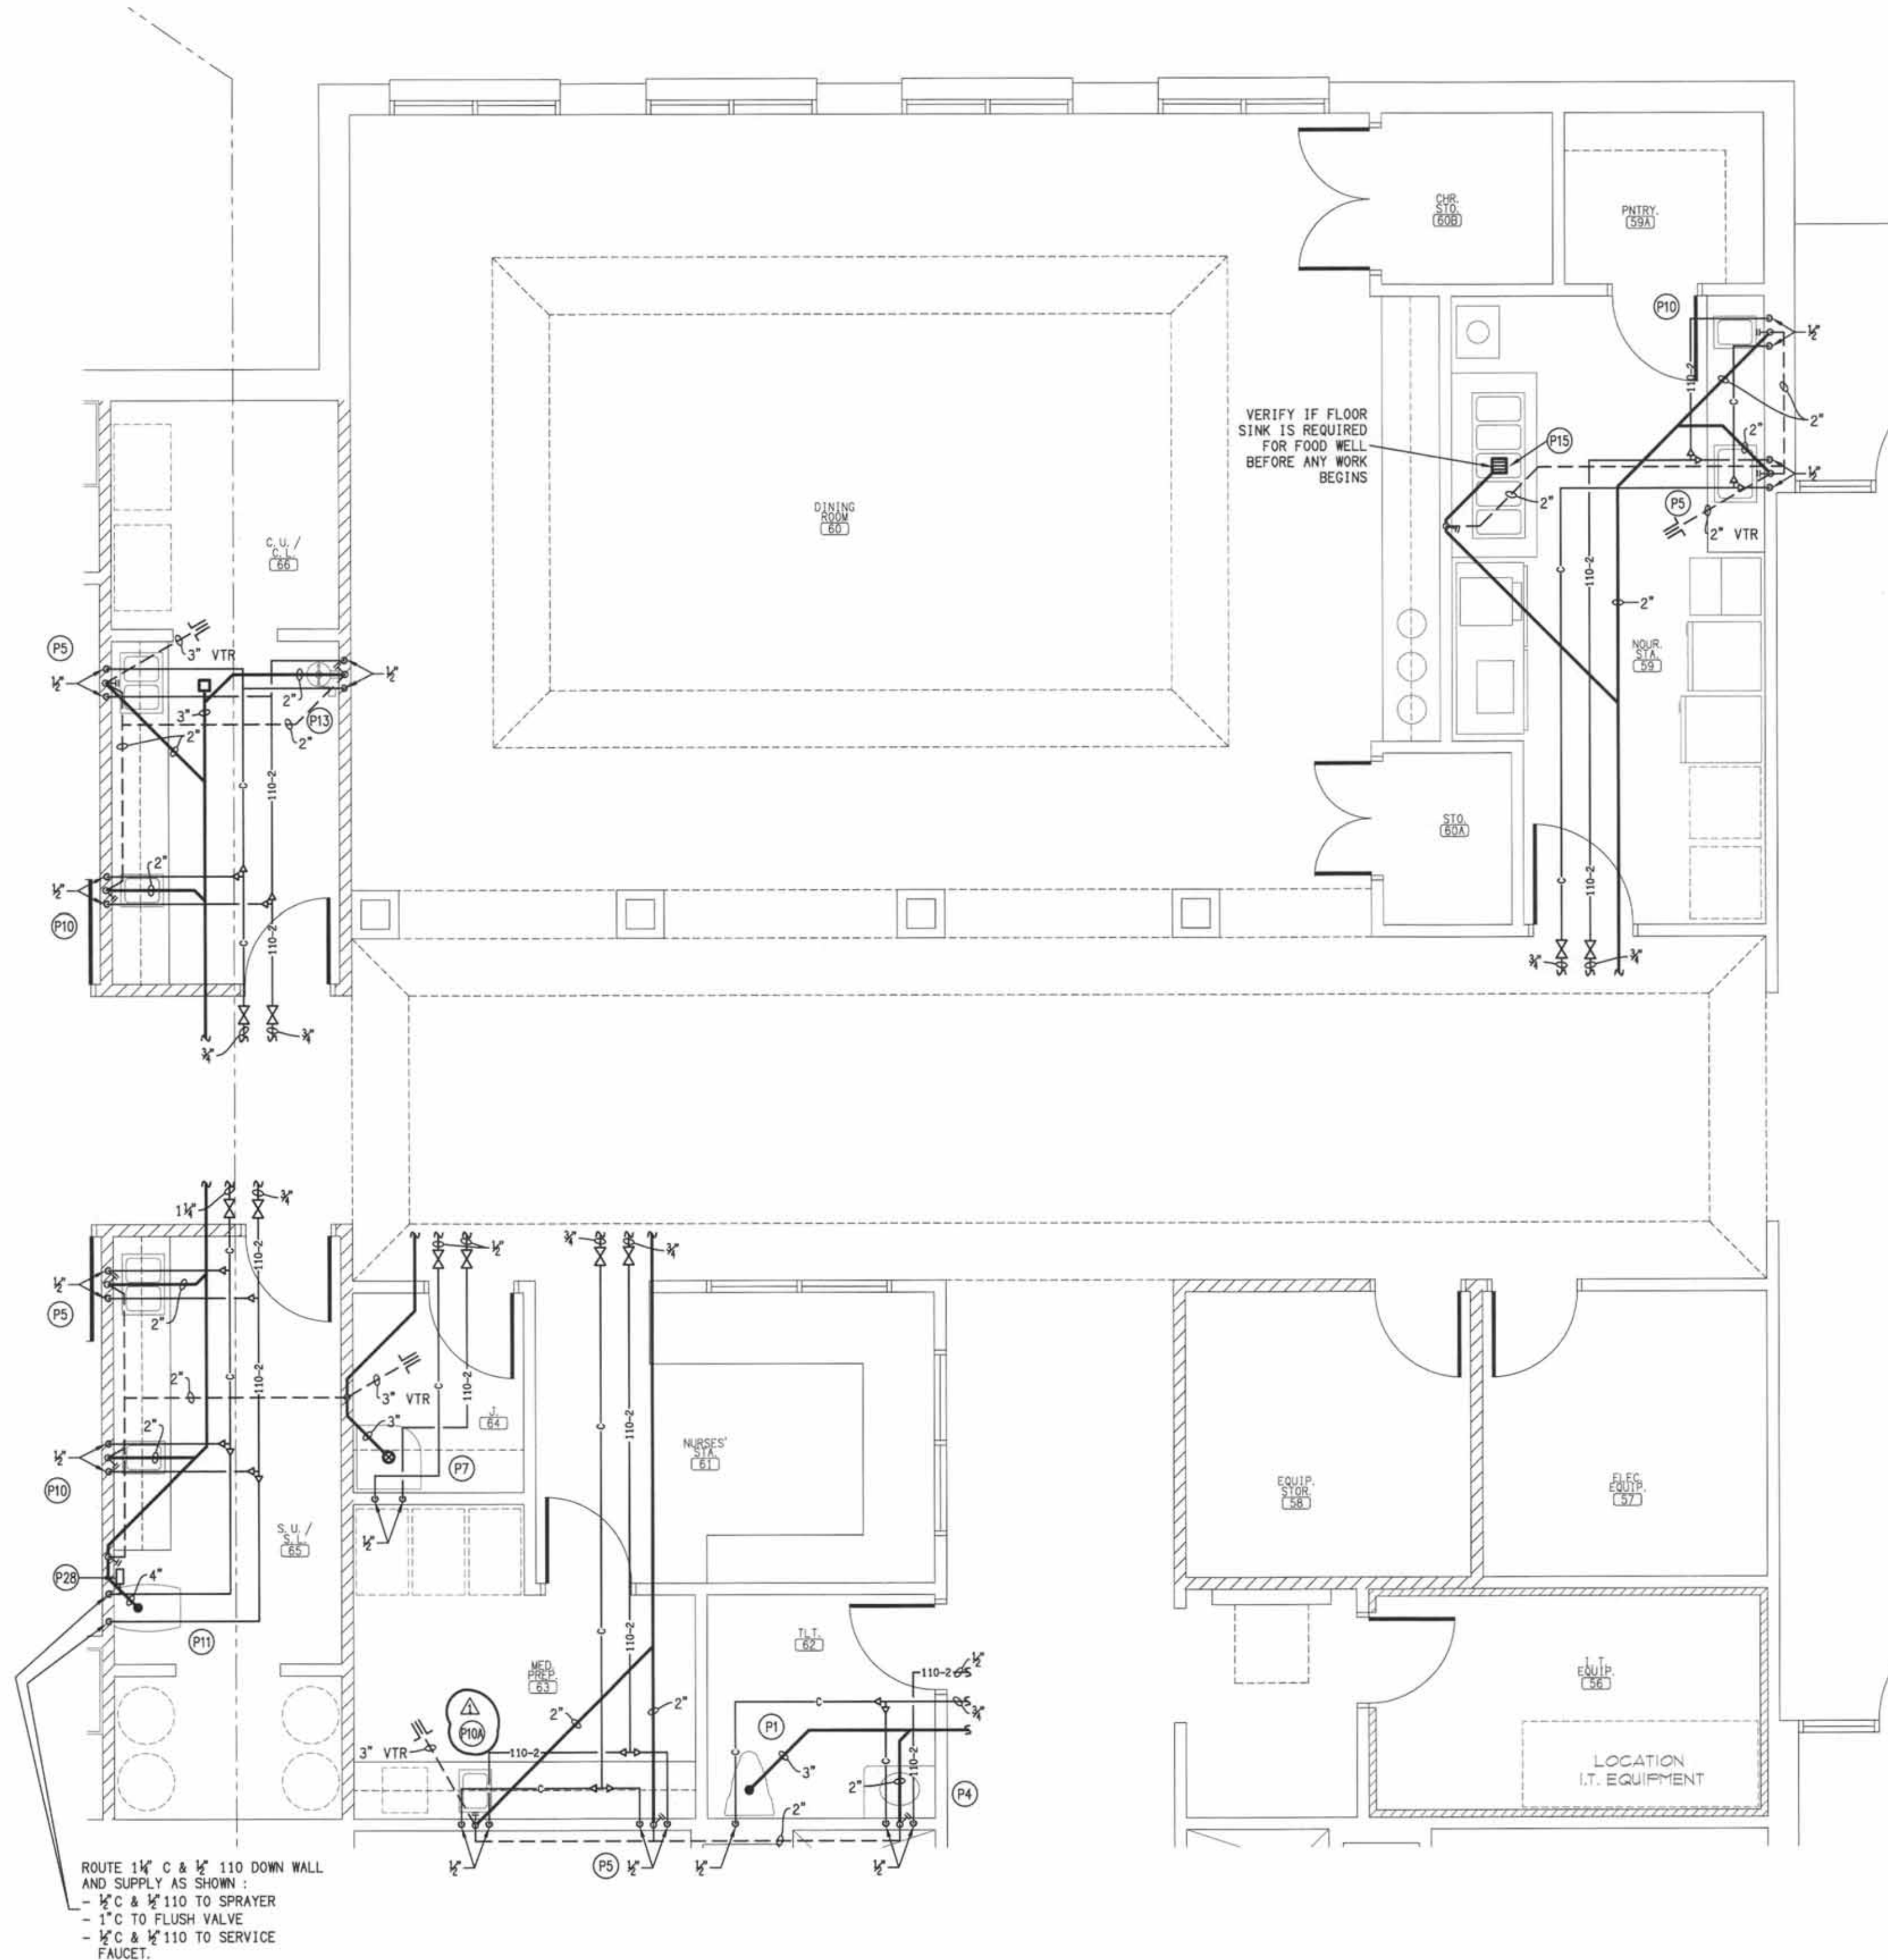

A ENLARGED PLUMBING PLAN
 P9 SCALE: 1/4\" = 1' - 0\" KITCHEN

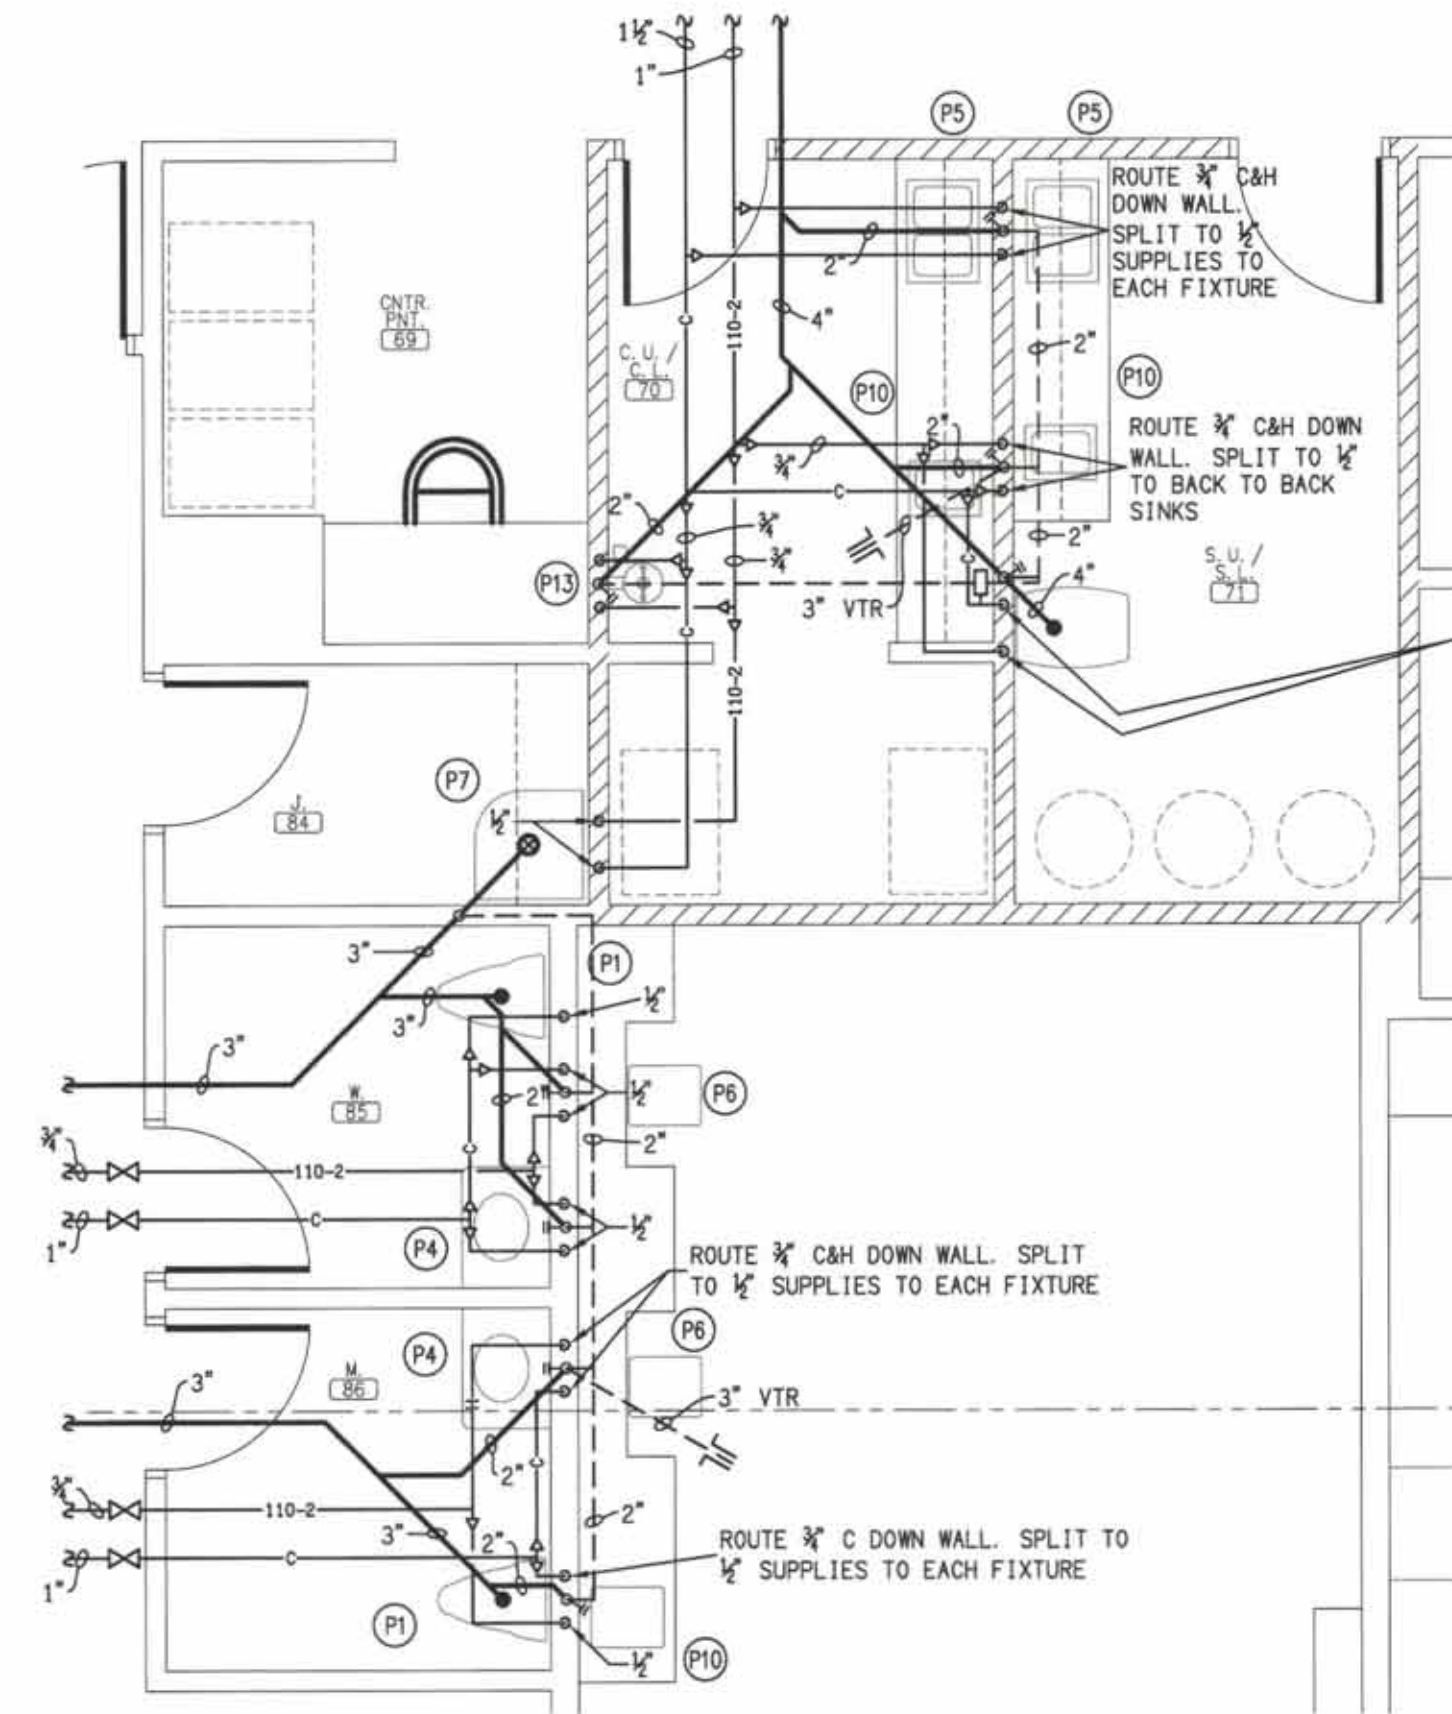

C ENLARGED PLUMBING PLAN
 P9 SCALE: 1/4\" = 1' - 0"

B NOT USED
 P9 NO SCALE

symbol	date	description	by
Δ	10/19/21	DHSR REVIEW	DBS
REVISIONS			

DS ENGINEERING
 DAVID SIMS & ASSOCIATES, P.C.
 CONSULTING ENGINEERS
 ARBORETUM CENTRE
 108 GILES AVE, SUITE 100
 WILMINGTON, NC 28403
 910.791.8016
 NC License: C-1150
 www.dsaeng.com

PRUITTHEALTH CRYSTAL COAST
 Beaufort, North Carolina

David R. Polston - Architect
 3806 Park Ave. Suite 2-L, Wilmington, NC 28403
 Architecture Planning Design





104 BED NURSING FACILITY

P9

PLUMBING FIXTURE SCHEDULE -									
	SYM.	FIXTURE	CW	HW	DRAIN	STOPS & VALVES	MANUF. (SEE NOTE 10)	MODEL (SEE NOTE 10)	REMARKS
	P-1	WATER CLOSET TANK - FLOOR MOUNT HANDICAP	1/2"	-	3"	1/2"x3/8" ANGLE	AMERICAN STANDARD	215AA. 004	INCLUDE BRASSCRAFT R19C SUPPLY VALVE W/CHROME PLATED RISER AND WALL FLANGE. CHURCH #295CTJ OPEN FRONT SEAT W/O COVER. SEE NOTES 1,2,8
	P-2	LAVATORY UNDERMOUNT HANDICAP	1/2"	1/2"	1-1/4"	1/2"x3/8" ANGLE	DAKOTA PLUMBING PRODUCTS	US-1714W-ADA	PLUMBER SHALL PROVIDE AND INSTALL AMERICAN STANDARD 5401.172H CHROME PLATED FAUCET WITH POP-UP DRAIN, 4" WRIST OPERATORS, BRASSCRAFT R19C SUPPLY VALVES W/CHROME PLATED RISERS AND WALL FLANGES, 1-1/4X1-1/4 TUBULAR P-TRAP CP. INSTALL A PROPERLY SIZED TEMPERATURE LIMITING DEVICE THAT CONFORMS TO ASSE 1070. SEE NOTES 1,3,11
	P-3	SHOWER OPERATOR (HAND HELD ONLY)	1/2"	1/2"	2"	INTEGRAL	-	-	DELTA T13H132 PRESSURE BALANCED MIX VALVE OPERATOR PACKAGE WITH R10000-UNWS VALVE, HAND HELD SHOWER W/60" HOSE WITH SLIDE BAR AND IN-LINE VACUUM BREAKER. SEE NOTES 1,5,8.
	P-4	LAVATORY COUNTER HANDICAP	1/2"	1/2"	1-1/4"	1/2"x3/8" ANGLE	-	-	INTGRAL BOWL BY OTHERS. PLUMBER SHALL PROVIDE AND INSTALL BRASSCRAFT R19C SUPPLY VALVES W/CHROME PLATED RISERS AND WALL FLANGES, 5401.172H CHROME PLATED FAUCET WITH GRID DRAIN, 4" WRIST OPERATORS 1-1/4X1-1/4 TUBULAR P-TRAP CP. INSTALL A PROPERLY SIZED TEMPERATURE LIMITING DEVICE THAT CONFORMS TO ASSE 1070. SEE NOTES 1,3,11
	P-5	TWO COMPARTMENT SINK - HANDICAP	1/2"	1/2"	1-1/2"	1/2x3/8 ANGLE	ELKAY	GEOR3321	INCLUDE AMERICAN STANDARD #6280.000 GOOSENECK FAUCET P-TRAP/CLEANOUT, STRAINER, BRASSCRAFT R19C SUPPLY VALVES, WRIST BLADE HANDLES. SEE NOTE 1.
△	P-5A	TWO COMPARTMENT SINK - HANDICAP (SOILED UTILITY)	1/2"	1/2"	1-1/2"	1/2x3/8 ANGLE	ELKAY	GEOR3321	INCLUDE AMERICAN STANDARD #6540.168 GOOSENECK FAUCET W/6" WRIST BLADE HANDLES SUPPLY VALVES, WRIST BLADE HANDLES. SEE NOTE 1.
	P-6	BEAUTY SINK	1/2"	1/2"	2"	1/2"x3/8" ANGLE	BELVEDERE	3800	7" HX 22" DIA. TOP. FAUCET W/HAIR STRAINER, SPRAY, VACUUM BREAKER, AND P-TRAP SUPPLY: BRASSCRAFT R19C
	P-7	MOP SINK	3/4"	3/4"	3"	-	FIAT	MSB2424	FAUCET: 830AA W/VACUUM BREAKER / HOSE: 832-AA MOP HANGER: 869-CC / STRAINER: E72-DD SEE NOTE 6
	P-8	LAVATORY WALL HUNG HANDICAP	1/2"	1/2"	1-1/4"	1/2"x3/8" ANGLE	AMERICAN STANDARD	0355.012	INCLUDE BRASSCRAFT R19C SUPPLY VALVES W/CHROME PLATED RISERS AND WALL FLANGES, 5401.172H CHROME PLATED FAUCET WITH POP-UP DRAIN, 4" WRIST OPERATORS 1-1/4X1-1/4 TUBULAR P-TRAP CP, CONCEALED ARM SUPPORTS SEE NOTES 1,3
	P-9	TUB	VERIFY	VERIFY	VERIFY	-	-	-	SPECIFIED BY OWNER. PROVIDED AND INSTALLED PER MANUFACTURERS INSTRUCTIONS BY PLUMBER. FOLLOW CODE REQUIREMENTS. SEE NOTE 9
	P-10	SINGLE COMPARTMENT SINK - HANDICAP	1/2"	1/2"	1-1/2"	1/2x3/8 ANGLE	ELKAY	LRAD1517	INCLUDE ELKAY LKA2437BH GOOSENECK FAUCET P-TRAP/CLEANOUT, STRAINER, BRASSCRAFT R19C SUPPLY VALVES, WRIST BLADE HANDLES. SEE NOTE 1.
△	P-10A	SINGLE COMPARTMENT SINK - HANDICAP (SOILED UTILITY)	1/2"	1/2"	1-1/2"	1/2x3/8 ANGLE	ELKAY	LRAD1517	INCLUDE AMERICAN STANDARD #6540.160 GOOSENECK FAUCET W/6" WRIST BLADE HANDLES P-TRAP/CLEANOUT, STRAINER, BRASSCRAFT R19C SUPPLY VALVES, WRIST BLADE HANDLES. SEE NOTE 1.
	P-11	CLINICAL SINK W/BEDPAN CLEANER & SERVICE FAUCET	1" 1/2"	1/2"	4"	-	AMERICAN STANDARD	9504.010	SLOW REWAK 1477-16 PUSH VALVE, RIM GUARD 7832.017, INCLUDE BEDPAN CLEANER 7880.024 W/VACUUM BREAKER 7837.024, NOZZLE AND HOOD 7886.015 PEDAL VALVE 7678.012, LOOSE KEY SUPPLY 7544.018, SERVICE SINK FAUCET 8345.118 W/6" ELBOW HANDLES. PROVIDE TERRAZZO BASE.
	P-12	FLOOR DRAIN	-	-	SEE PLAN FOR SIZE	-	ZURN	ZN-415-SB-P	NIKOLAY TOP DEEP SEAL TRAP, PROVIDE PRIMER TAP. SEE NOTE 5
	P-13	EMERGENCY EYE WASH	1/2"	1/2"	-	-	BRADLEY	S19-220T	INCLUDE BRADLEY S19-2000 EFX8 THERMOSTATIC MIX VALVE TO TEMPER EYEWASH WATER TO OSHA STANDARDS INCLUDE SHUTOFF VALVES ON HOT AND COLD WATER LINES. SEE (B) (12)
	P-14	SHOWER OPERATOR HANDICAP (FIXED HEAD ONLY)	1/2"	1/2"	2"	INTEGRAL	-	-	DELTA T13H132 PRESSURE BALANCED MIX VALVE OPERATOR PACKAGE WITH R10000-UNWS VALVE, THIS INCLUDES FIXED SHOWER HEAD. SEE NOTES 1,5,8.
	P-15	FLOOR SINK	-	-	3"	-	ZURN	ZN-1900-2-23-K	ALL WASTE PIPES DRAINING INTO FLOOR SINKS SHALL BE INSTALLED IN ACCORDANCE WITH NC98C-PC ARTICLE 802.2.1 HALF TOP GRATE, 12"X12" TOP, SEDIMENT BUCKET.
	P-16	SHOWER DRAIN	-	-	3"	-	ZURN	ZN-415-SB	NIKALOY TOP.
	P-17	REFRIGERATOR CONNECTION	3/8"	-	-	-	-	-	INCLUDE SHUTOFF VALVE AND RECESSED WALL BOX
	P-18	CAN/CART WASH	3/4"	3/4"	3"	GATE	ZURN	1325	FAUCET MUST POSSESS A THREADED MIXING FAUCET. DRAIN ZURN Z-550-Y. SEE NOTE 6
	P-19	HOSE BIBB	3/4"	-	-	-	WOODFORD	25	PROVIDE VACUUM BREAKER FREEZEPROOF
	P-20	INTERIOR HOSE BIBB	1/2"	-	-	GATE	WOODFORD	24	VACUUM BREAKER
	P-21	FINISHED FLOOR CLEANOUT	-	-	-	-	ZURN	ZN-1400-T	WITH NIKOLAY TOP
	P-22	EXTERIOR CLEANOUT	-	-	-	-	ZURN	Z-1400	WITH CAST IRON TOP. SEE (A) (25)
	P-23	WALL CLEANOUT COVERPLATE	-	-	-	-	ZURN	Z-1469	STAINLESS STEEL
	P-24	ELECTRIC WATER COOLER BI-LEVEL	1/2"	-	1-1/4"	-	ELKAY	EZSTL-B-C	COLOR BY ARCHITECT. SEE NOTE 1
	P-25	WATER HEATER INSTANTANEOUS	3/4"	3/4"	-	GATE	RINNAI	CU1991	INCLUDE FULL CONTROLS FOR MULTIPLE UNIT CONNECTION. AS PER MANUFACTURER INSTRUCTIONS. GAS, 199,000 BTUH. COORDINATE CONTROLS WITH PERTINENT RECIRCULATION PUMP.
	P-26	LAUNDRY SINK FIBERGLASS FLOOR MOUNT	1/2"	1/2"	2"	1/2"x3/8" ANGLE	MUSTEE	18F	INCLUDE FIBERGLASS STRAINER, EASTMAN SW60 SUPPLY VALVES W/CHROME PLATED RISERS AND WALL FLANGES, INDIANA BRASS FAUCET T1566.8. W/VACUUM BREAKER.
	P-27	HOT WATER CIRCULATION PUMP - 110° F	3/4"	-	-	-	TACO	0013B	5 GPM @ 33' TDH, 110 VOLT, 1/6 HP.
	P-28	WATER HAMMER ARRESTER	3/4"	-	-	-	ZURN	Z-1700-100	-
	P-29	ADL TUB	1/2"	1/2"	2"	INTEGRAL	BEST BATH	CTS6032A18	INCLUDE SEAT, GRAB BARS, DRAIN AND SYMMONS 96-400-B30-L-V PRESSURE BALANCED MIX VALVE OPERATOR, HAND HELD SHOWER W/60" HOSE, SLIDE BAR, DIVERTER VALVE. SEE NOTES 1,4, VERIFY OPERATOR
	P-30	DISHWASHER CONNECTION	-	1/2"	1"	-	-	-	CONNECT WATER & WASTE TO ADJACENT SINK IN

NOTES:

1. MATERIAL AND INSTALLATION SHALL BE PER STATE HANDICAP CODE REQUIREMENTS AND ADA REQUIREMENTS.
2. WATER AND WASTE SHALL FLUSH ON A MAXIMUM OF 1.6 GALLONS PER FLUSH.
3. LAVATORIES SHALL HAVE .5 GPM FLOW AERATORS.
4. BOTH FIXED HEAD AND HAND HELD SHOWER HEADS HAVE FLOW RESTRICTOR TO PASS A MAXIMUM OF 2.5 GPM.
5. FLOOR DRAIN SHALL BE PROVIDED WITH 1/2" PRIMER LINE FROM NEARBY CLEAR WATER FIXTURE (LAVATORY). TAP CLEAR WATER CONNECTION. WATER SAVING TRAP PRIMER AND ROUTE COPPER SUPPLY LINE UNDER SLAB TO DRAIN PRIMER CONNECTION. WATER SAVING TRAP PRIMER SHALL BE ACCESSIBLE AND CODE APPROVED. IF A CLEAR WATER FIXTURE SUCH AS A LAVATORY IS NOT AVAILABLE TAP NEARBY COLD WATER LINE AND ROUTE 1/2" PRIMER LINE THROUGH PRIMER VALVE CODE APPROVED TO WATER SAVING TRAP CONNECTION.
6. INSTALL CHECK VALVE ON COLD & HOT SUPPLY LINES SERVING MOP SINKS AND KANSASH.
7. PLUMBING CONTRACTOR SHALL PROVIDE MATERIAL AND FLUTE INSULATE HOT WATER TANK P26 WITH SYSTEM OF JOHNS MANVILLE FIBERGLASS LARGEDIAFLEX. PROVIDE COMMENTS REGARDING FIBERGLASS LARGEDIAFLEX. KRAFT PAPER JACKETS SHALL BE INSTALLED AS PER MANUFACTURERS INSTRUCTIONS AND INDUSTRY STANDARDS AS SET BY MIDWEST INSULATION CONTRACTORS ASSOCIATION. INSULATION SHALL BE STAPLED AND BANNED.
8. THE USE OF OFFSET WATER CLOSET FLANGES IS PROHIBITED. MISALIGNED WATER CLOSET FLANGES MUST BE RE-PIPED.
9. "QUALITY MANUFACTURING" COMMENTS REGARDING FIBERGLASS LARGEDIAFLEX. FIBERGLASS LARGEDIAFLEX SHALL BE INSTALLED AS PER MANUFACTURERS INSTRUCTIONS AND INDUSTRY STANDARDS AS SET BY MIDWEST INSULATION CONTRACTORS ASSOCIATION. INSULATION SHALL BE STAPLED AND BANNED.
10. THE USE OF OFFSET WATER CLOSET FLANGES IS PROHIBITED. MISALIGNED WATER CLOSET FLANGES MUST BE RE-PIPED.
11. WHEN LAVATORY IS LOCATED IN A PUBLIC ACCESS AREA CONTRACTOR SHALL PROVIDE AND INSTALL A PROPERLY SIZED TEMPERATURE LIMITING DEVICE THAT CONFORMS TO ASSE 1070 OR CSA B125.3.

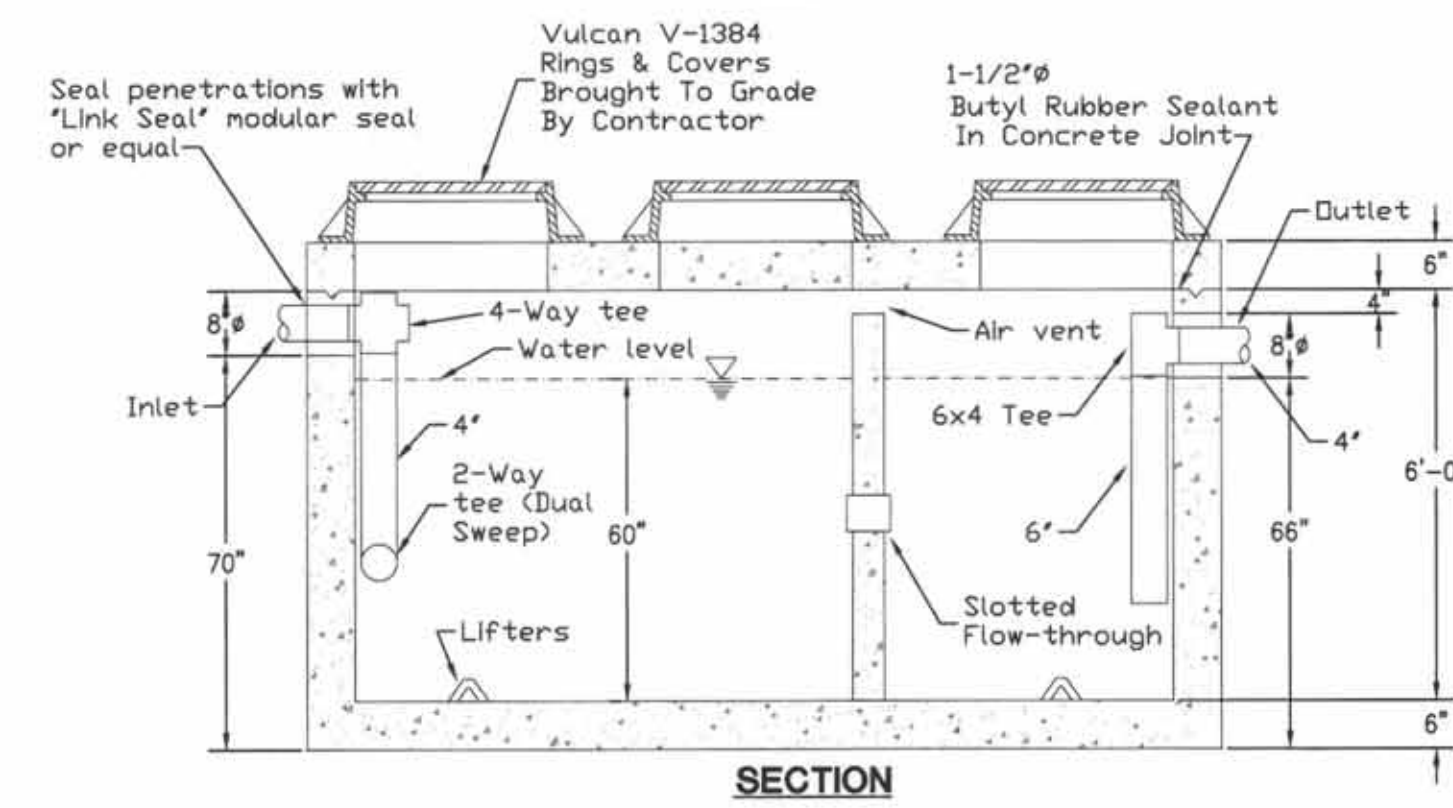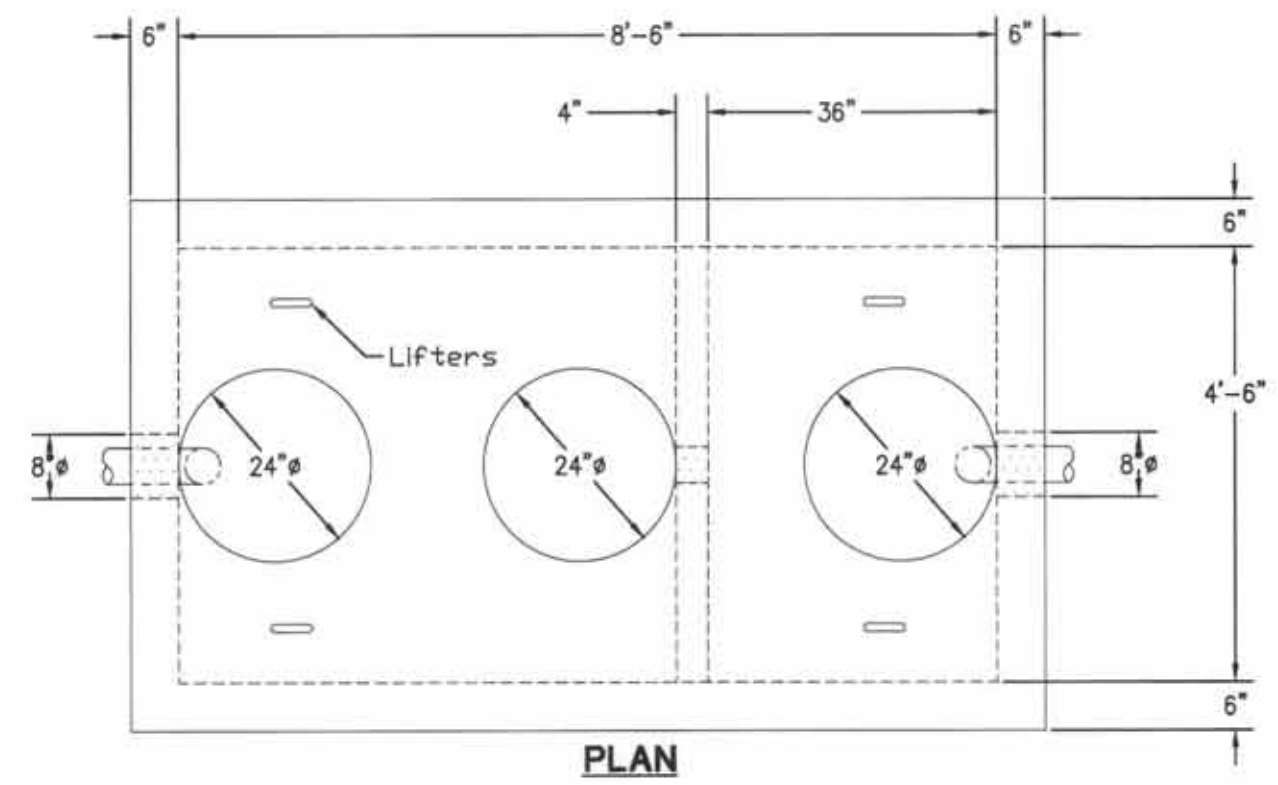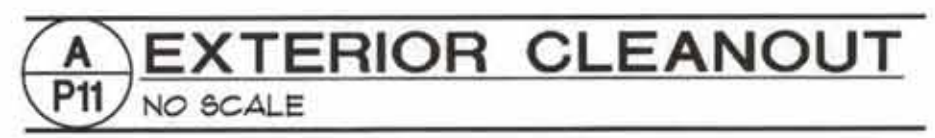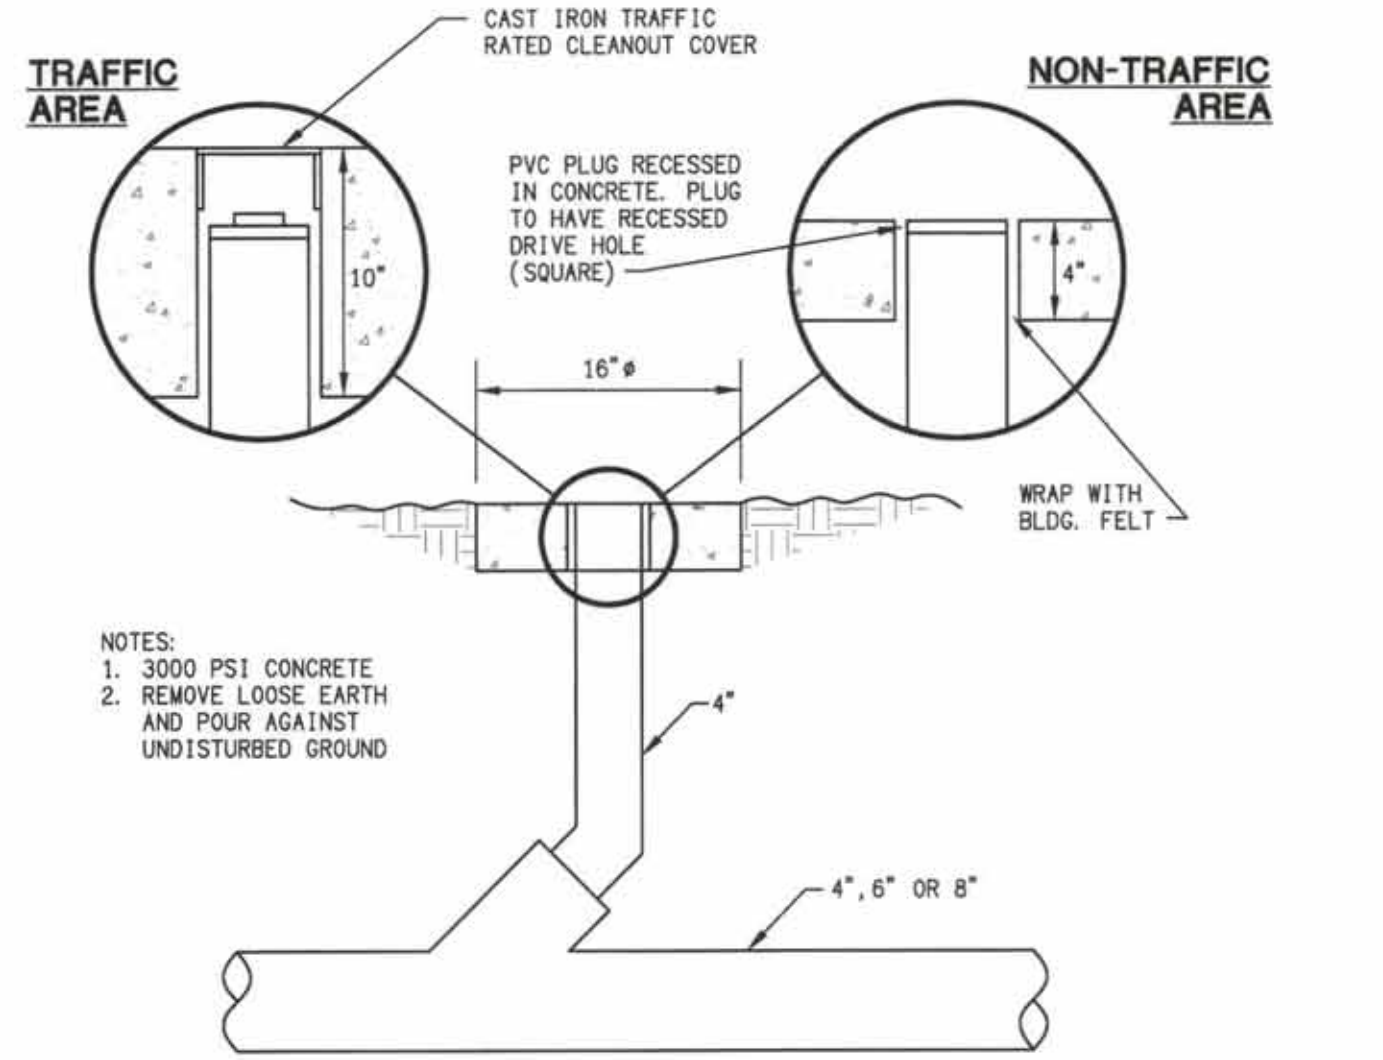

B P11 1500 GAL. GREASE INTERCEPTOR NO SCALE BY PLUMBING CONTRACTOR

	10/19/21	DHSR REVIEW	DB:
symbol	date	description	by
REVISIONS			

 DAVID SIMS & ASSOCIATES, P.C. CONSULTING ENGINEERS ARBORETUM CENTRE 108 GILES AVE., SUITE 100 WILMINGTON, NC 28403 910.791.8016 NC License: C-1150 www.dseng.com		 10/20/21	
		PRUITTHEALTH CRYSTAL COAST Beaufort, North Carolina	
		David R. Polston - Architect 3806 Park Ave. Suite 2-L, Wilmington, NC 28403 Architecture Planning Design	
		104 BED NURSING FACILITY	
		P 11	
DHSR REVIEW		DBS	
description		by	

REVISIONS

	4-15-22	GENERAL REVISION	DBS
symbol	date	description	by
REVISIONS			