

PruittHealth

PENSACOLA - NURSE CALL



PROJECT DISCIPLINES INCLUDED

- COMMUNICATIONS
- STRUCTURED CABLING
- AUDIO/VISUAL
- SECURITY
- ACCESS CONTROL
- NURSE CALL

Sheet List Table	
Sheet Number	Sheet Title
GENERAL	
T-0-000	COVER SHEET
T-0-001	NOTES & LEGEND
ARCHITECTURAL	
TNC-1-101	NURSE CALL FLOOR PLAN
ELEVATIONS	
TNC-2-001	NURSE CALL DEVICE ELEVATIONS
WIRING	
TNC-6-101	JERON IP NETWORK WIRING DIAGRAM
TNC-6-102	TYPICAL CABLE RUN

DRAWING PACKAGE RELEASES		
NUMBER	RELEASE DESCRIPTION	DATE
1	APPROVED PROJECT SET	10/11/2022

NetPlanner
SYSTEMS, INC.[®]
Your Pathway to Connectivity

Atlanta, GA 770-662-5482 Augusta, GA 706-364-4190
 Raleigh, NC 919-290-8010 Columbus, GA 706-571-9090
 Toll Free 800-795-1975 Savannah, GA 912-748-8960
 www.netplanner.com

CLIENT LOGO

PROJECT INFO

PruittHealth
PENSACOLA, FLORIDA

SHEET INFO





 
 
 
 







 
 

PENSACOLA
COVER SHEET

REVISIONS		
REV.	DESCRIPTION	DATE

ENGINEER APPROVAL	ENGINEER	DRAWING NAME
	MM	T-0-000
	PHB	PROJECT NUMBER
		AM22316
	PROJECT MANAGER	APPROVED DRAWING DATE
	AP	10/11/22
		RELEASE NUMBER
		1

A B C D E F G H J K

NURSE CALL EQUIPMENT SYMBOLS

-  7924 ENHANCED DUAL PATIENT STATION (WALL)
-  7923 ENHANCED SINGLE PATIENT STATION (WALL)
-  9779 J-BUS SPLITTER (CEILING)
-  9777 POWER SPLITTER (CEILING)
-  7932 BATH(PERIPHERAL STATIONS)(NON AUDIO, WALL)
-  7992/7993- GATEWAY
-  7965 NURSE CONSOLE (TABLE)
-  7995 POWER SUPPLY
-  7953 ROOM CONTROLLER WITH DOME LIGHT (CEILING)
-  7950 ROOM CONTROLLER (DOMELESS/CEILING)
-  7963 CONSOLE CONTROLLER W/ZONE LIGHT (CEILING)
-  7927 STAFF DUTY (WALL)
-  7932 PUSH/PULL DEVICE (WALL)
-  ZONE DOME LIGHT (CEILING)
-  CAT6 23 AWG (J BUS)
-  CAT5/5e/6 (R BUS)
-  (1) 22 AWG TWISTED PAIR (P BUS)
-  CAT6 23 AWG (M BUS)

DRAWING NAME CONVENTION

T[X]-[NUMBER]-###

T[X] = SYSTEM TYPE
 TA = TELECOMMUNICATIONS AUDIO-VISUAL [AV]
 TN = TELECOMMUNICATIONS DATA NETWORKS [COM]
 TY = TELECOMMUNICATIONS SECURITY [SEC]
 TNC = TELECOMMUNICATIONS NURSE CALL [NC]

[NUMBER] = DRAWING TYPE
 0 = GENERAL (INDEX, LEGENDS, NOTES)
 1 = PLANS (FLOOR PLANS, RCPS)
 2 = ELEVATIONS (VERTICAL VIEWS)
 5 = DETAIL SHEETS
 6 = WIRING DIAGRAMS

= UNIQUE SHEET IDENTIFIER [FOR ARCH DWGS]
 1ST NUMBER IS THE FLOOR NUMBER
 2ND & 3RD NUMBER IS A SEQUENTIAL NUMBERING (01,02, ETC)

= UNIQUE SHEET IDENTIFIER [FOR WIRING DWGS]
 ALL NUMBERS ARE A SEQUENTIAL NUMBERING (001,002, ETC)

DRAWING NAME CONVENTION

- DOME LIGHTS 6" OUT FROM WALL.
- DOME AND ZONE LIGHT NEED TO HAVE AN ADDITIONAL 6" STAND TO HANG BELOW LIGHT FIXTURES.
- ZONE LIGHTS NEED TO BE 1' OF CENTER LINE.

1 2 3 4 5 6 7



NetPlanner SYSTEMS, INC.
 Your Pathway to Connectivity
 Atlanta, GA 770-662-5482
 Raleigh, NC 919-290-8010
 Toll Free 800-795-1975
 www.netplanner.com

CLIENT LOGO



PruittHealth

PROJECT INFO

PruittHealth
 PENSACOLA, FLORIDA

SHEET INFO


PENSACOLA
 NOTES & LEGEND

REVISIONS		
REV.	DESCRIPTION	DATE

ENGINEER APPROVAL	ENGINEER MM	DRAWING NAME T-0-001	
	CAD PHB	PROJECT NUMBER AM22316	
	PROJECT MANAGER AP	APPROVED DRAWING DATE 10/11/22	RELEASE NUMBER 1

A B C D E F G H J K

NOTES:
 1. SEE DRAWING T-0-001 FOR SYMBOL LEGEND AND GENERAL NOTES

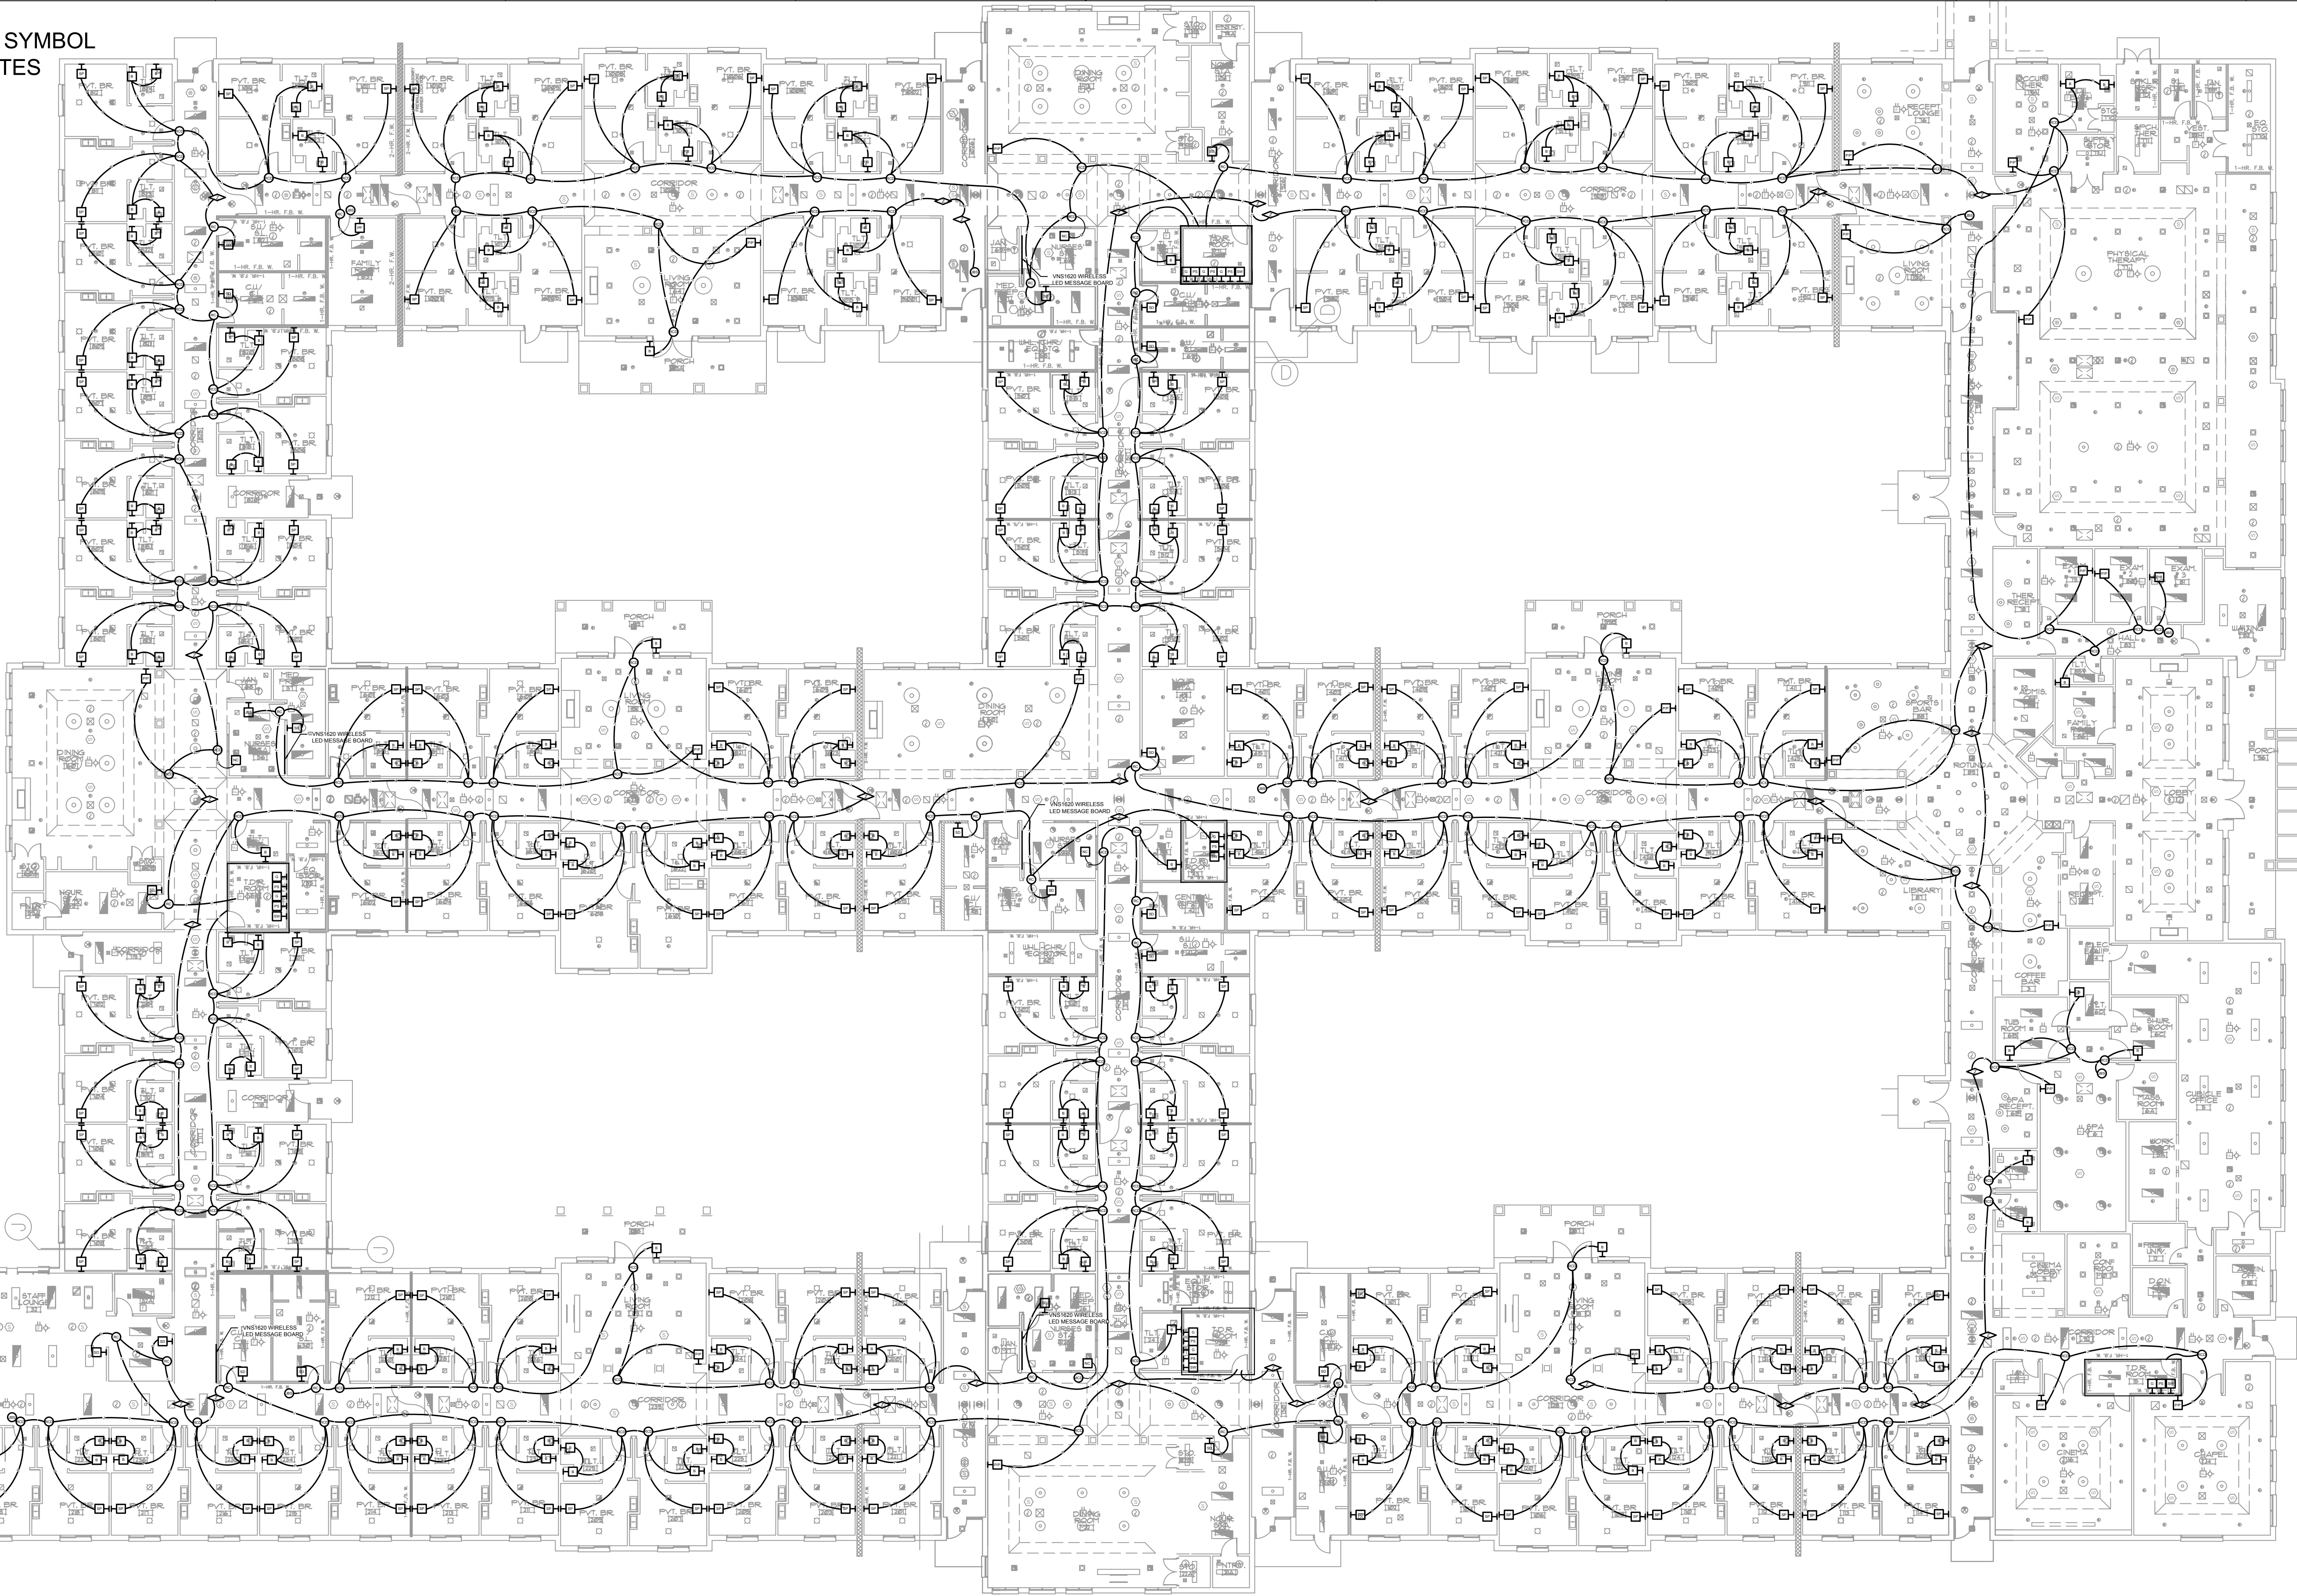

1 NURSE CALL FLOOR PLAN
 SCALE: 1/16" = 1'-0"

NetPlanner
 SYSTEMS, INC.[®]
Your Pathway to Connectivity
 Atlanta, GA 770-662-5482 Augusta, GA 706-364-4190
 Raleigh, NC 919-290-8010 Columbus, GA 706-571-9090
 Toll Free 800-795-1975 Savannah, GA 912-748-8960
 www.netplanner.com

CLIENT LOGO

PROJECT INFO
 PruittHealth
 PENSACOLA, FLORIDA

SHEET INFO
 PENSACOLA
 NURSE CALL FLOOR PLAN

REVISIONS		
REV.	DESCRIPTION	DATE


ENGINEER APPROVAL

ENGINEER
 MM
 CAD
 PHB
 PROJECT MANAGER
 AP


DRAWING NAME TNC-1-101	RELEASE NUMBER 1
PROJECT NUMBER AM22316	APPROVED DRAWING DATE 10/11/22

A B C D E F G H J K


NOTES:
 1. SEE DRAWING T-0-001 FOR SYMBOL LEGEND AND GENERAL NOTES.

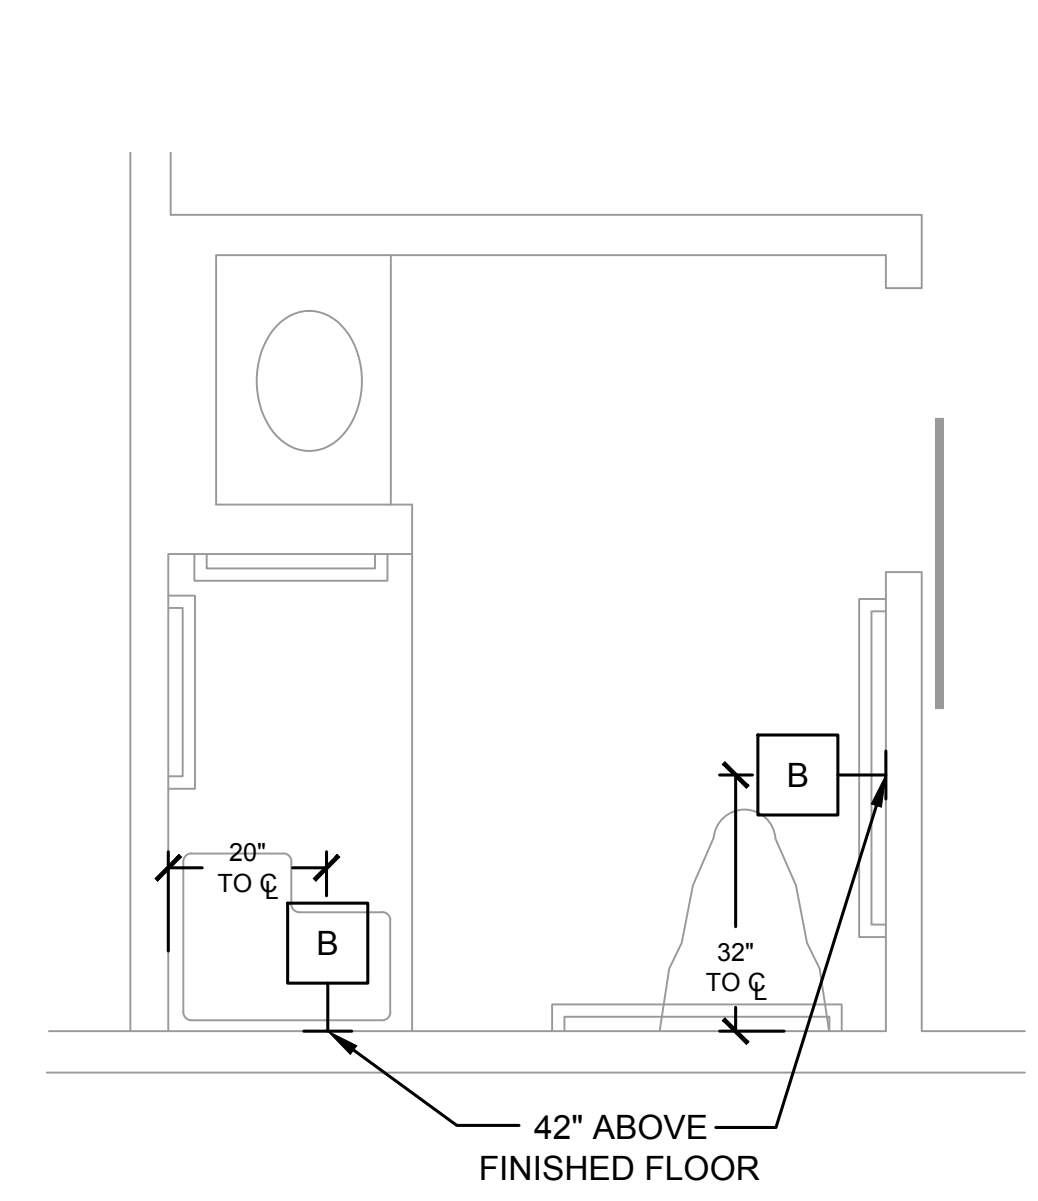


1 TYP. PATIENT TOILET ROOM FLOOR PLAN
 SCALE: NTS

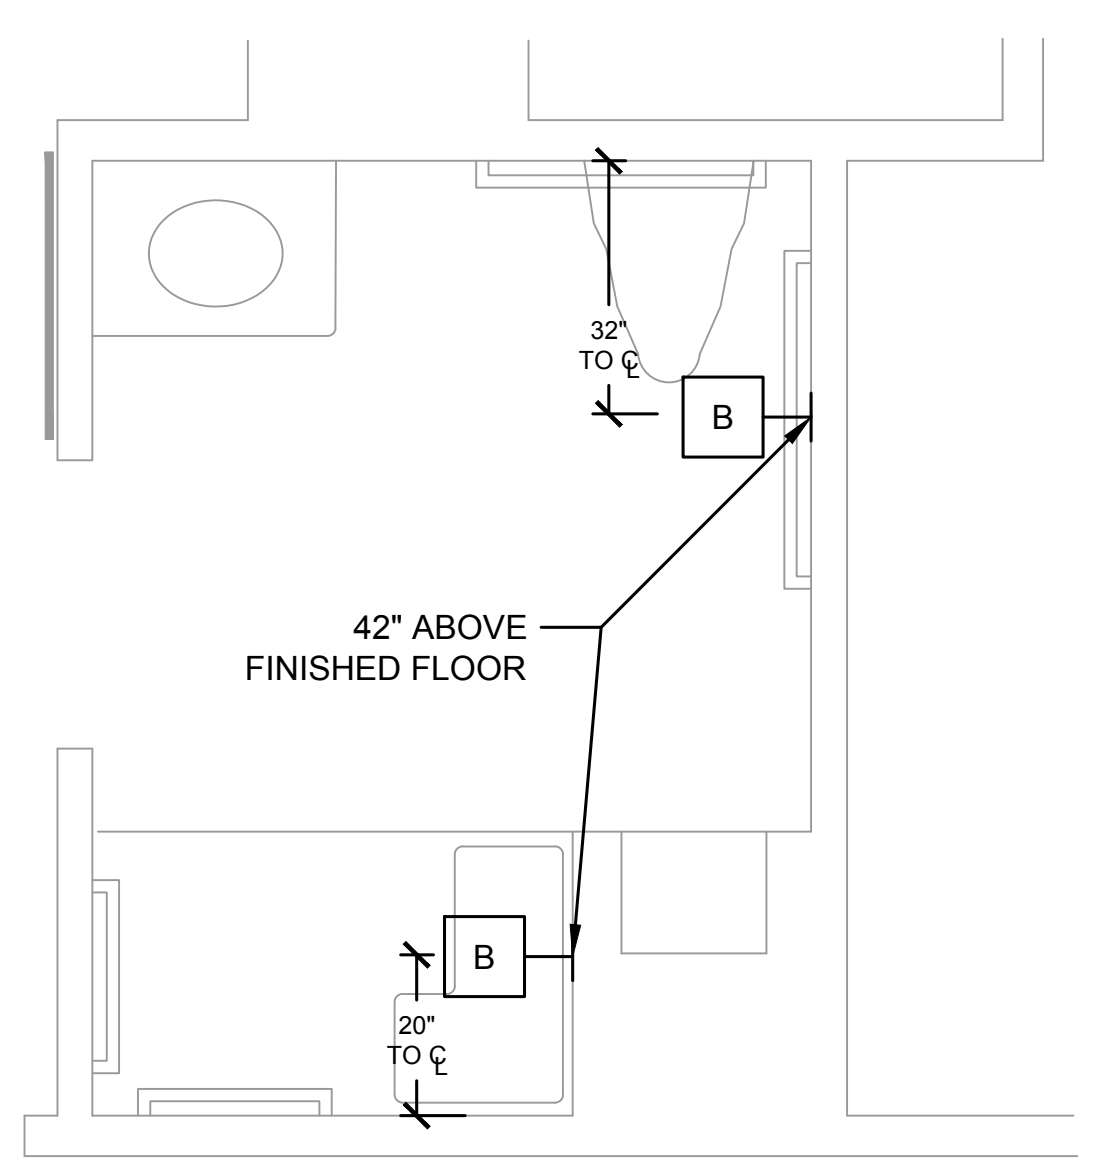

2 TYP. CONCIERGE TOILET ROOM FLOOR PLAN
 SCALE: NTS

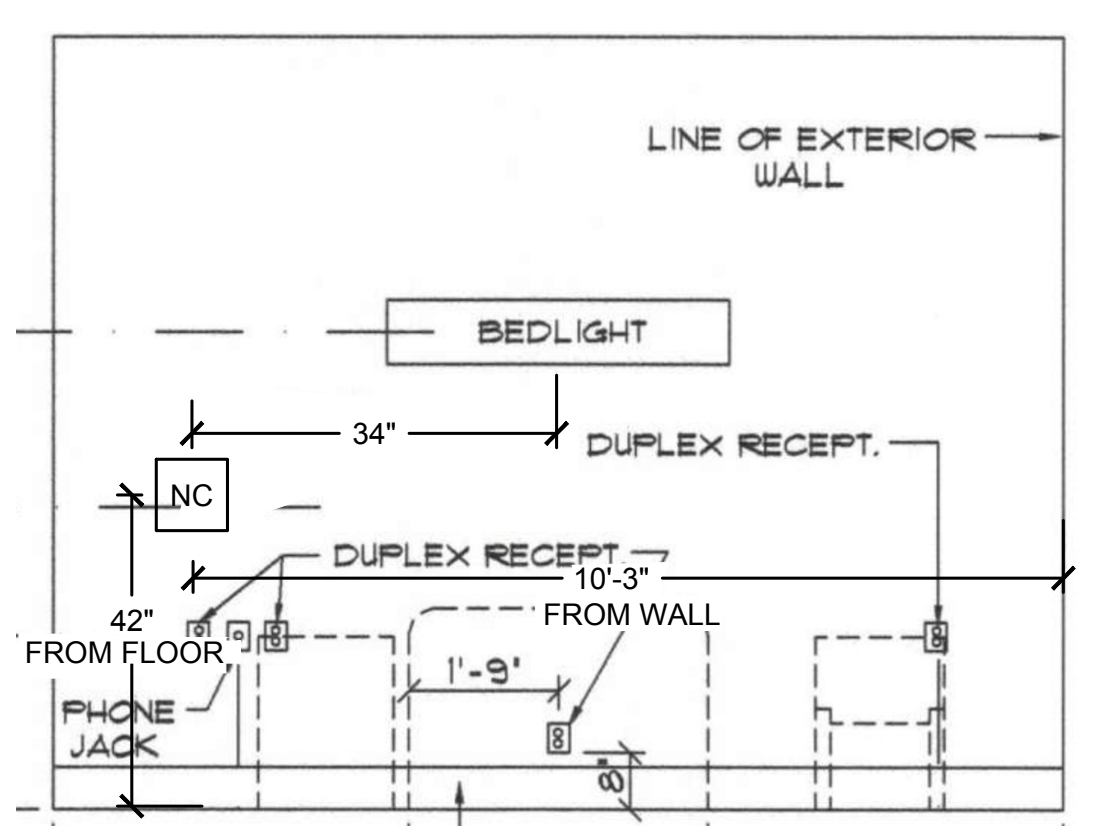

3 TYP. BEDWALL FOR TYP. BEDROOM SUITE
 SCALE: NTS

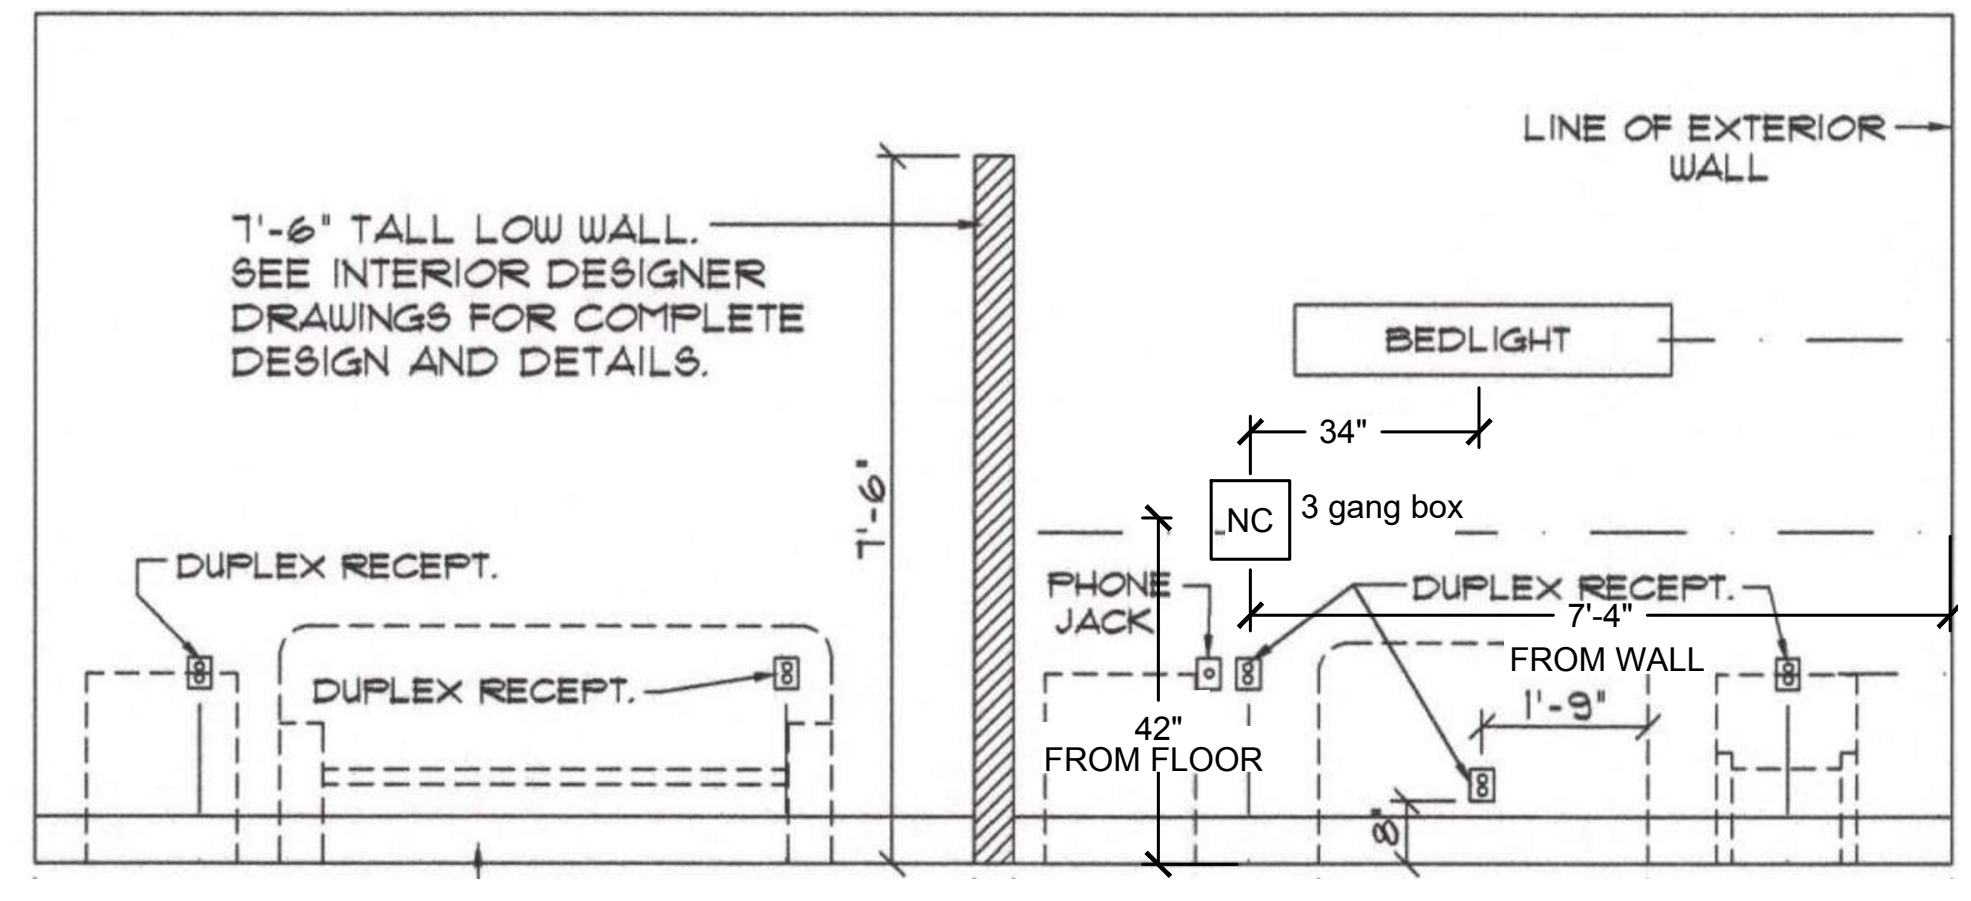

4 TYP. BEDWALL FOR TYP. CONCIERGE SUITE
 SCALE: NTS

NetPlanner
 SYSTEMS, INC.[®]
 Your Pathway to Connectivity
 Atlanta, GA 770-662-5482
 Raleigh, NC 919-290-8010
 Toll Free 800-795-1975
 www.netplanner.com








PROJECT INFO
 PruittHealth
 TYPICAL

SHEET INFO
 NURSE CALL DEVICE ELEVATIONS

REVISIONS		
REV.	DESCRIPTION	DATE

ENGINEER APPROVAL	ENGINEER MM	DRAWING NAME TNC-2-001	
	CAD PHB	PROJECT NUMBER AM22316	
	PROJECT MANAGER AP	APPROVED DRAWING DATE 10/11/22	RELEASE NUMBER 1

NOTES:
 1. SEE DRAWING T-0-001 FOR SYMBOL LEGEND AND GENERAL NOTES

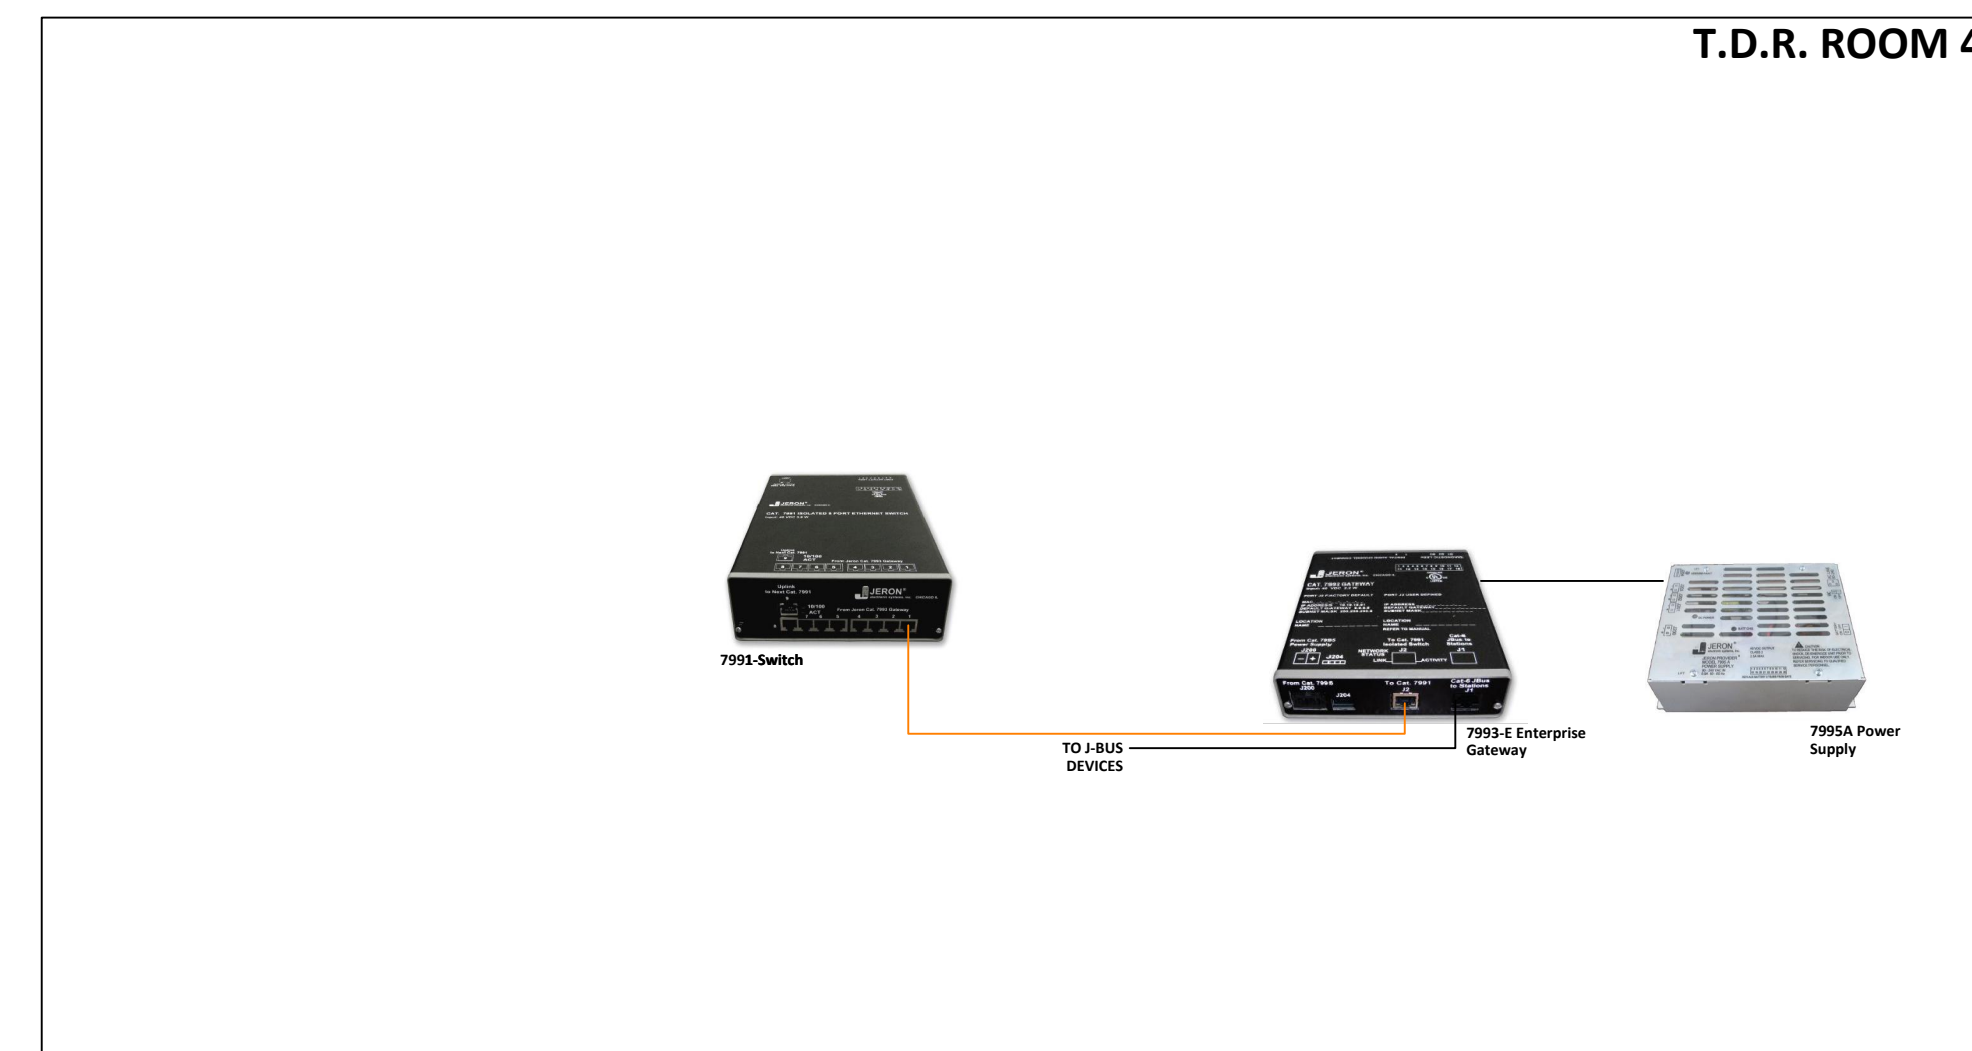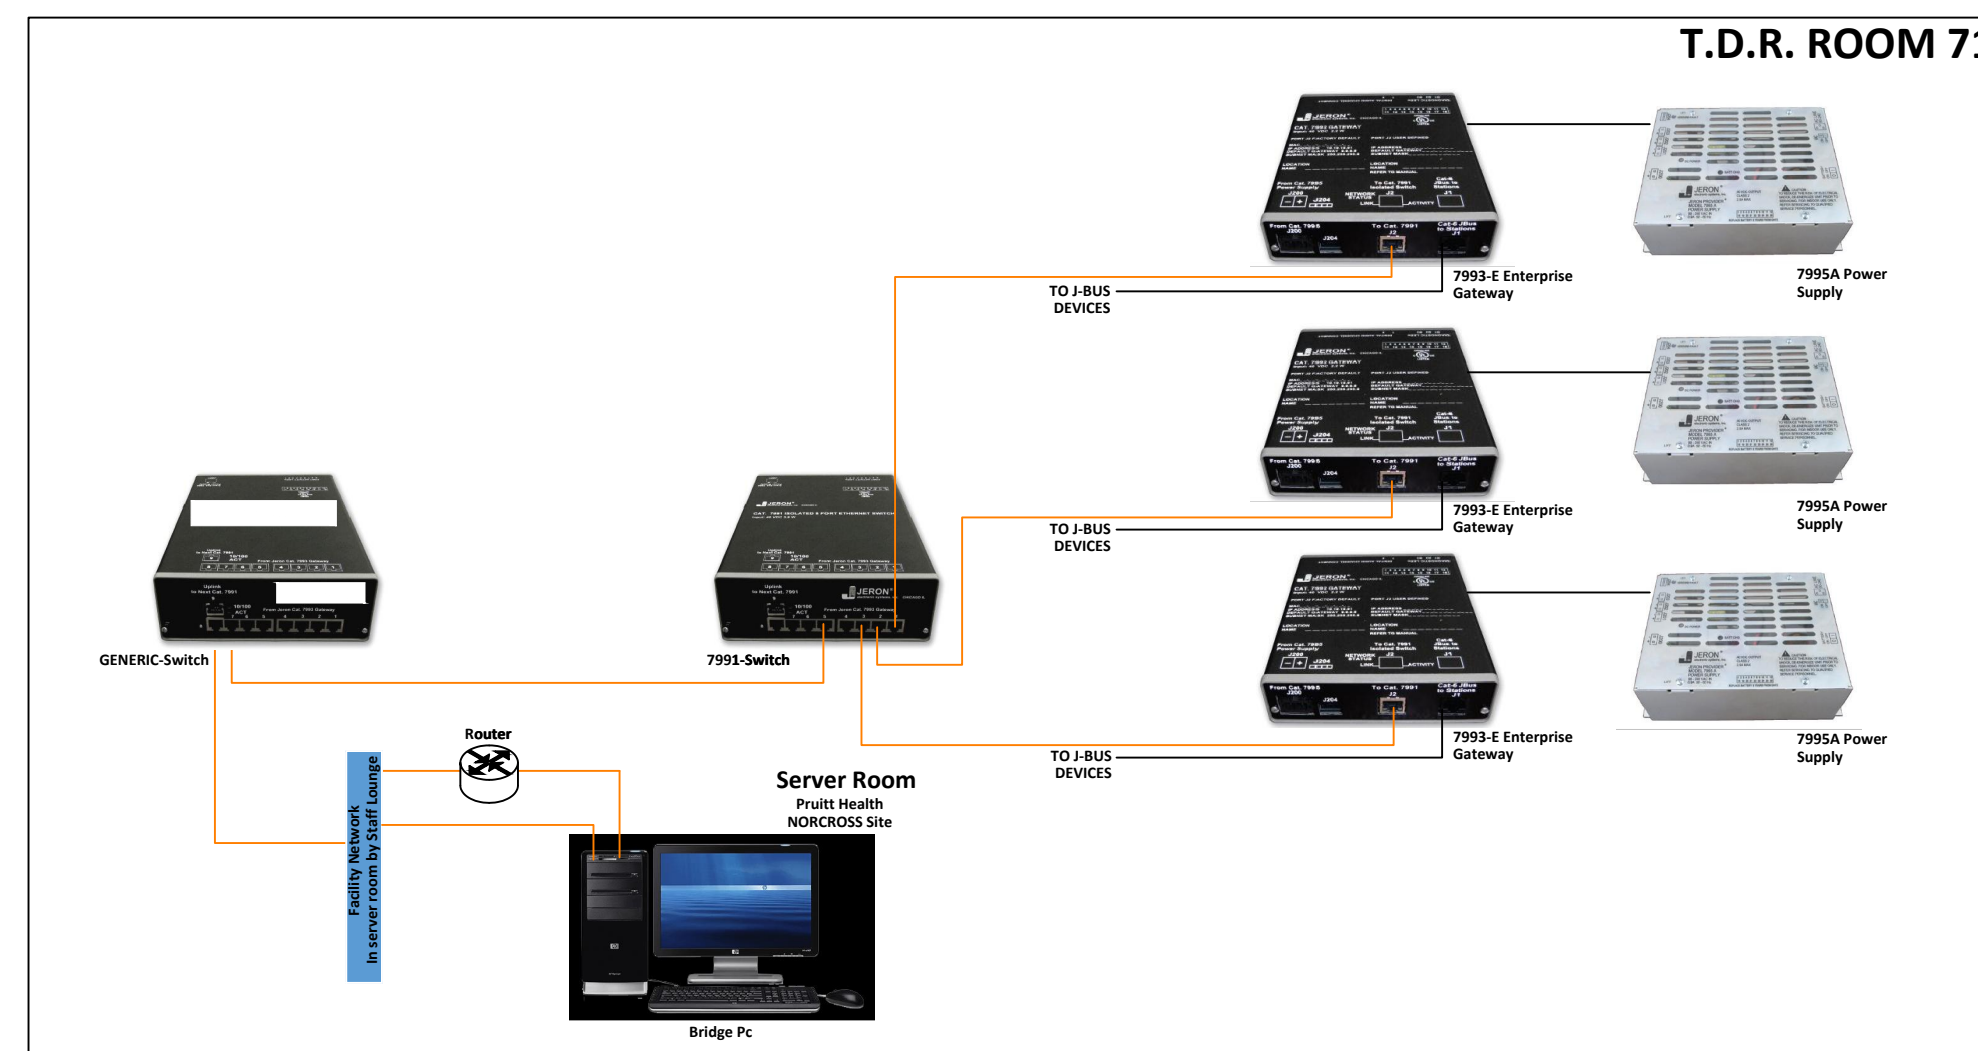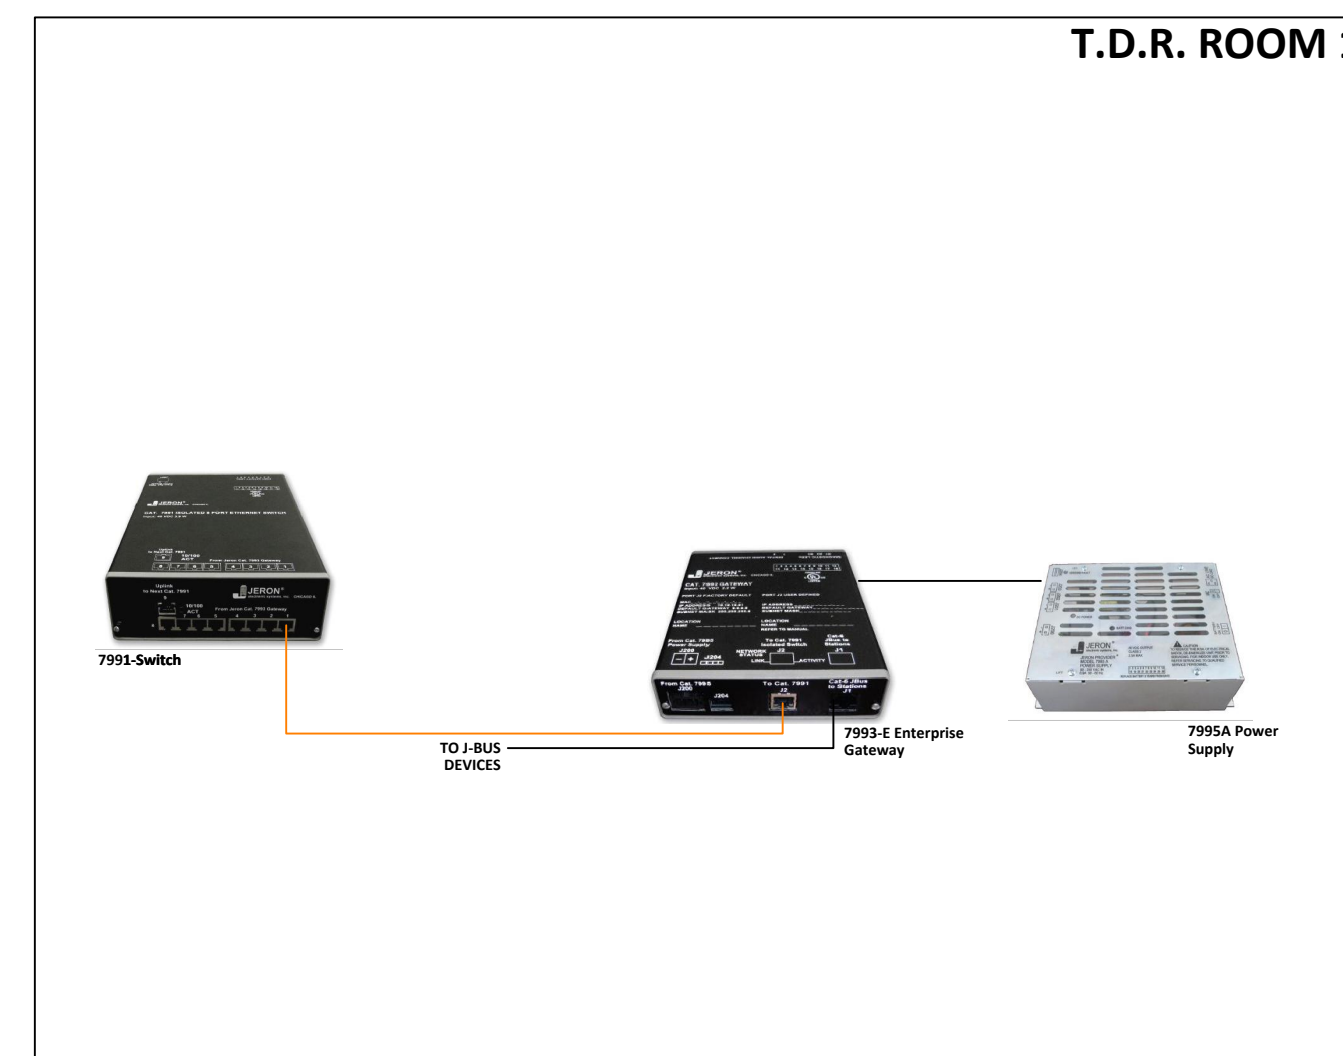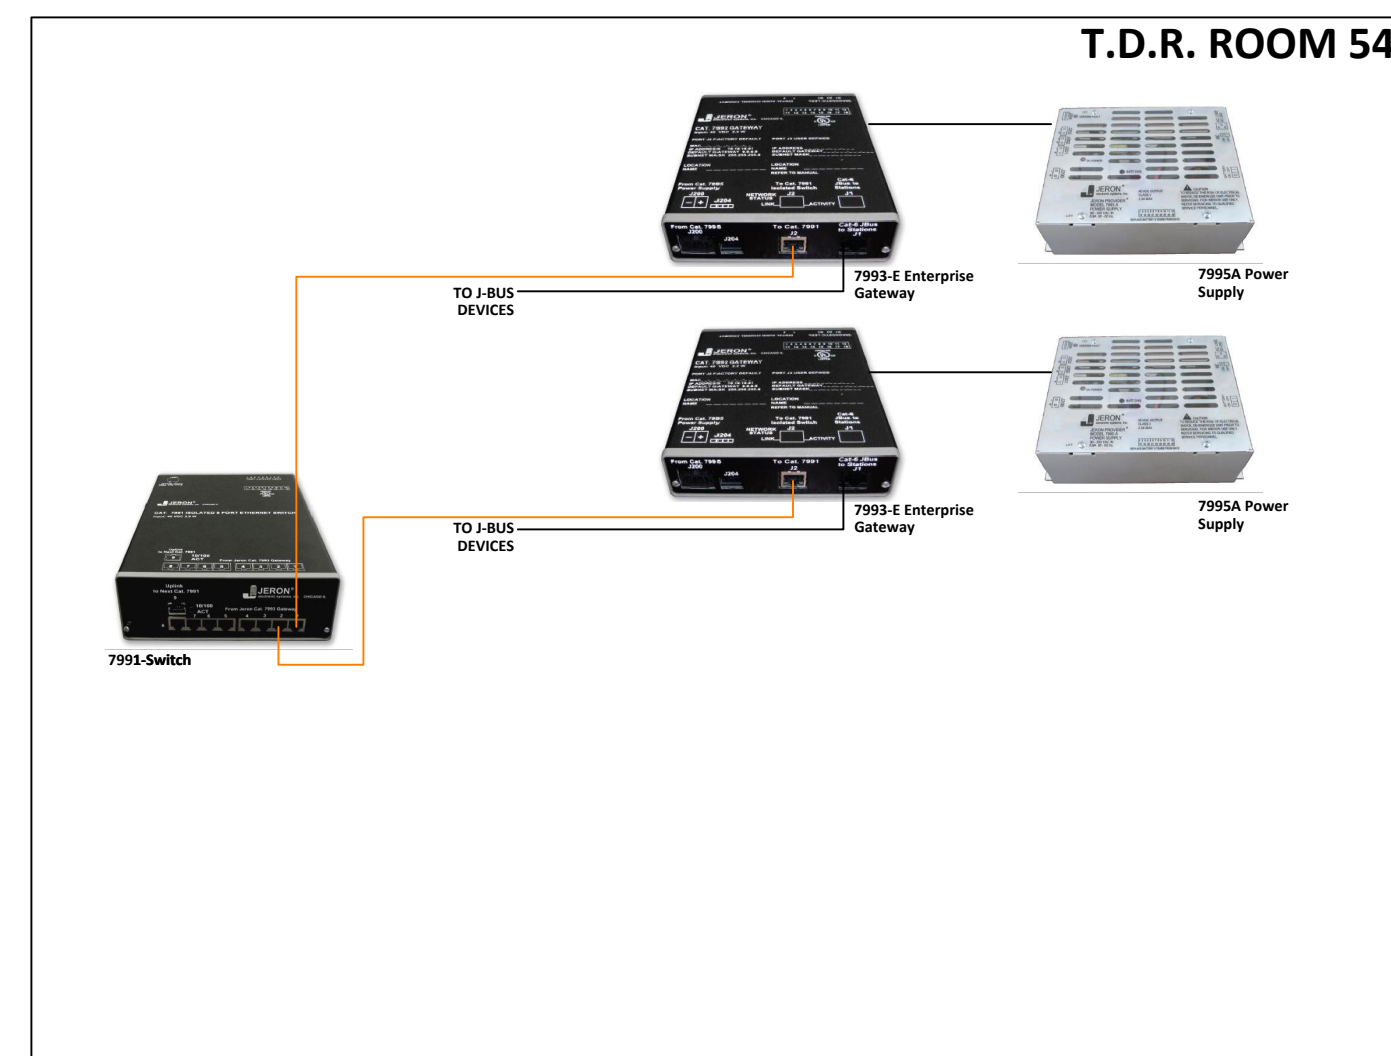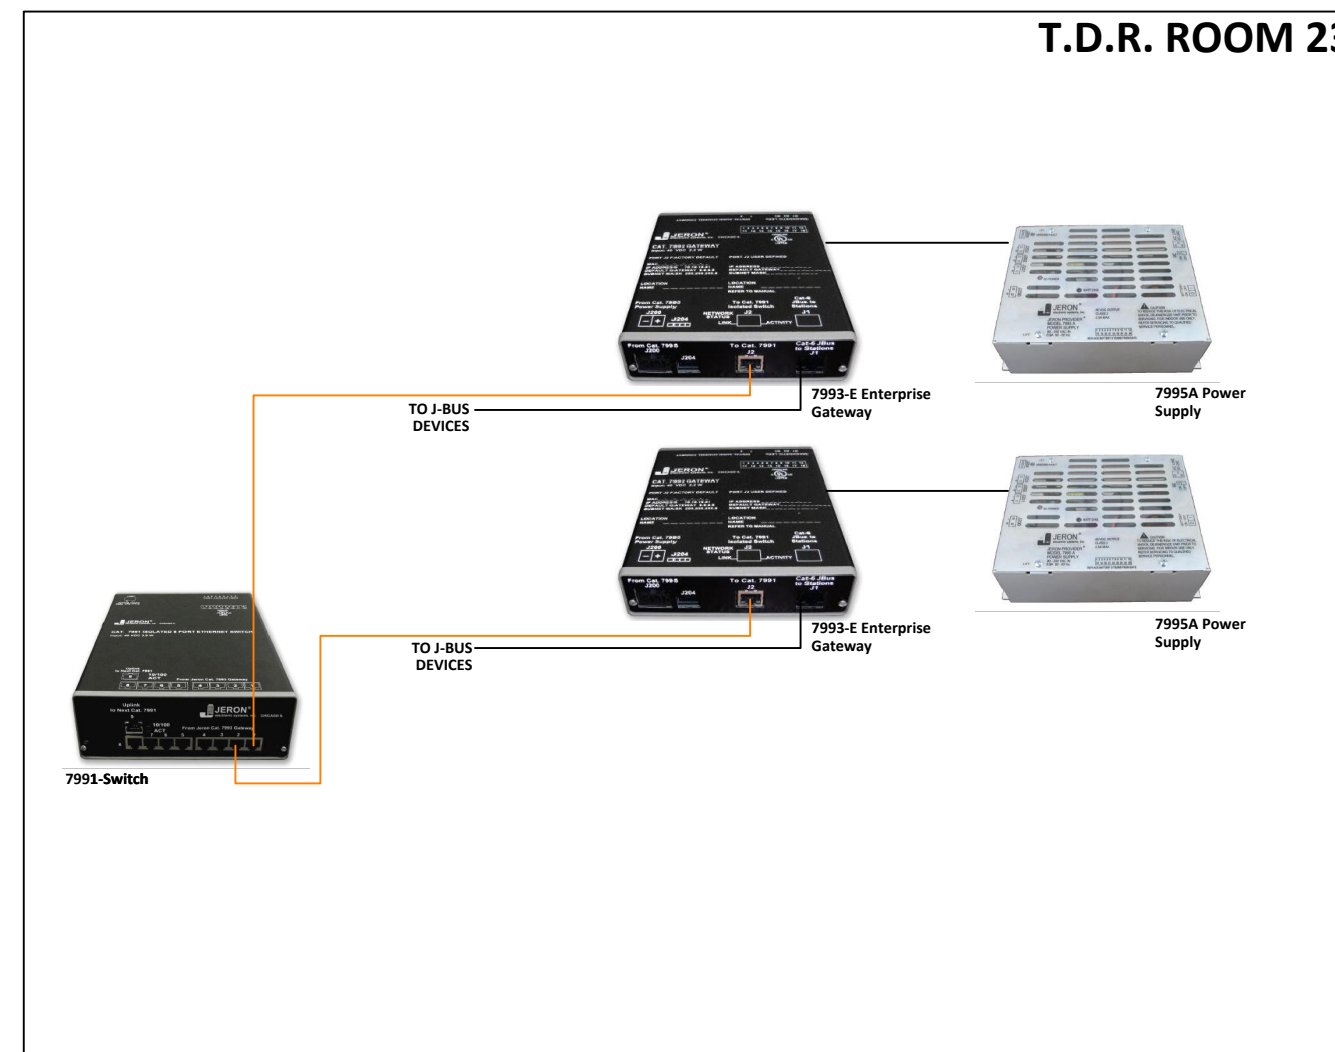

1 JERON IP NETWORK WIRING DIAGRAM
 SCALE: NTS

NetPlanner
 SYSTEMS, INC.[®]
Your Pathway to Connectivity
 Atlanta, GA 770-662-5482 Augusta, GA 706-364-4190
 Raleigh, NC 919-290-8010 Columbus, GA 706-571-9090
 Toll Free 800-795-1975 Savannah, GA 912-748-8960
 www.netplanner.com

CLIENT LOGO

PROJECT INFO
 PruittHealth
 PENSACOLA, FLORIDA


SHEET INFO
 PENSACOLA
 JERON IP NETWORK WIRING DIAGRAM

REVISIONS		
REV.	DESCRIPTION	DATE

ENGINEER APPROVAL		DRAWING NAME	
ENGINEER	MM	TNC-6-101	
CAD	PHB	PROJECT NUMBER	
PROJECT MANAGER	AP	AM22316	RELEASE NUMBER
APPROVED DRAWING DATE		10/11/22	1

NOTES:
 1. SEE DRAWING T-0-001 FOR SYMBOL LEGEND AND GENERAL NOTES

TYP. CABLE RUN

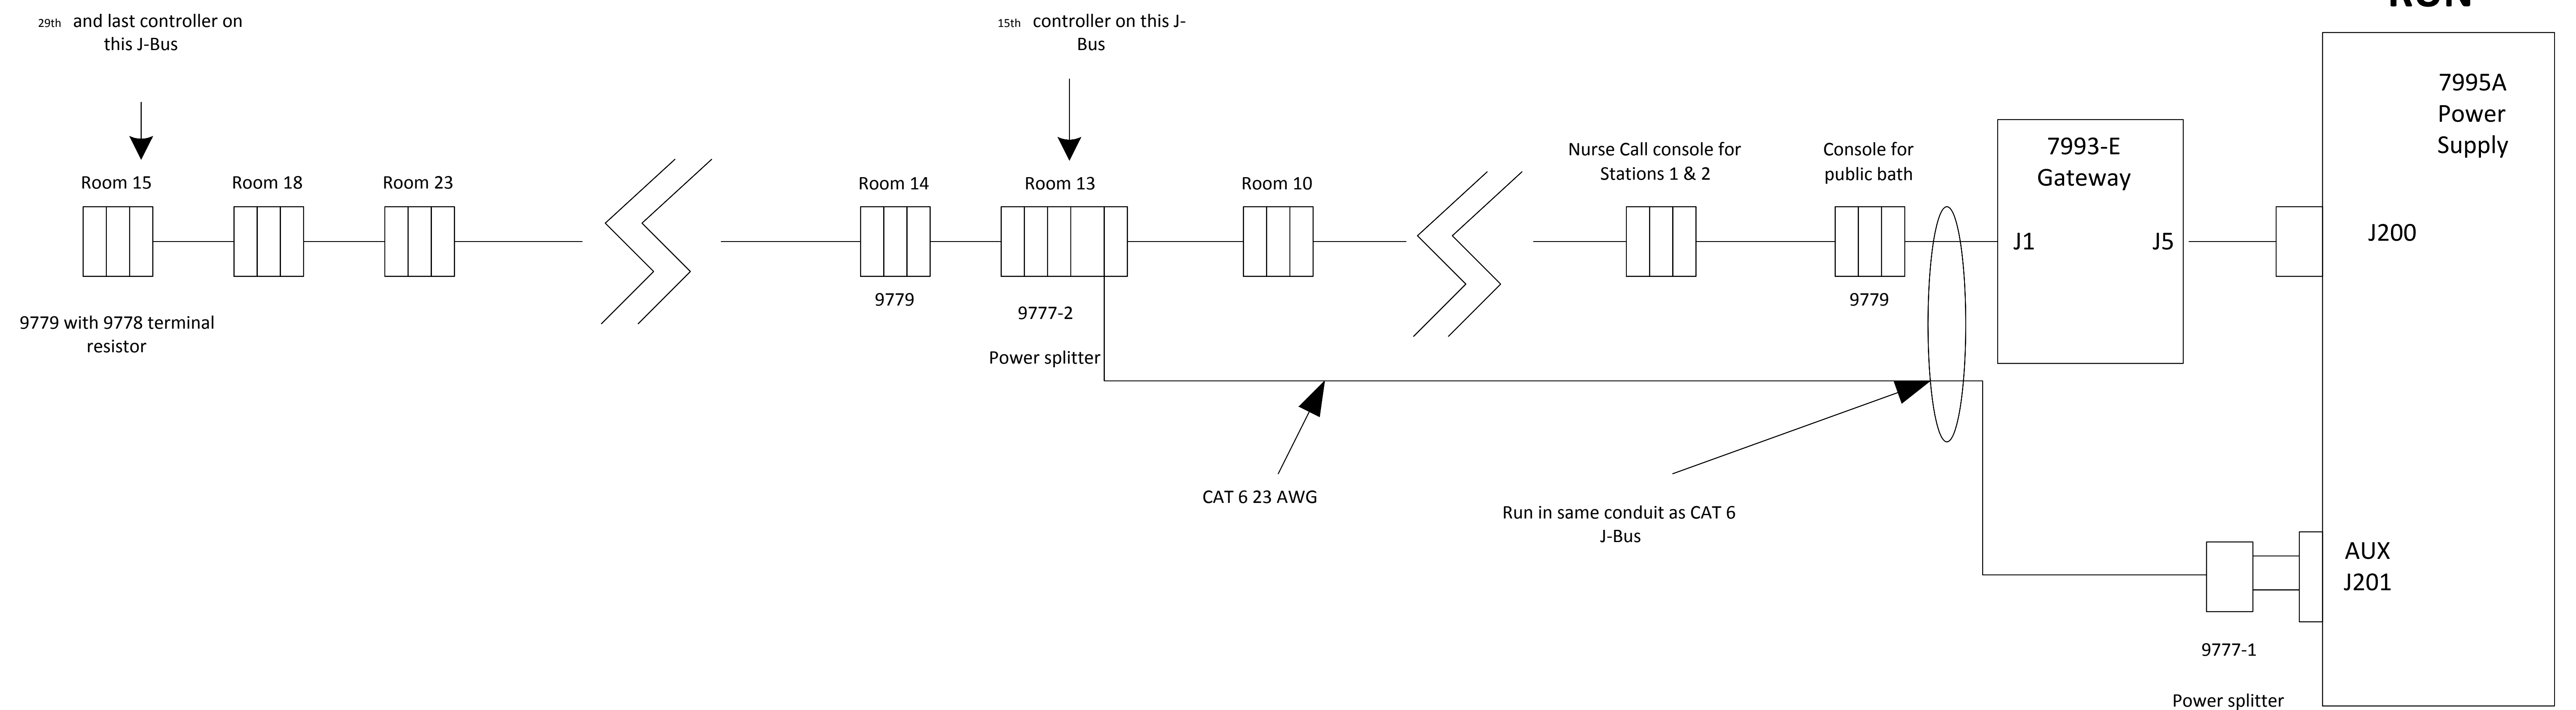

1 TYPICAL CABLE RUN
 SCALE: NTS

NetPlanner
 SYSTEMS, INC.[®]
Your Pathway to Connectivity
 Atlanta, GA 770-662-5482 Augusta, GA 706-364-4190
 Raleigh, NC 919-290-8010 Columbus, GA 706-571-9090
 Toll Free 800-795-1975 Savannah, GA 912-748-8960
 www.netplanner.com



PROJECT INFO
 PruittHealth
 PENSACOLA, FLORIDA

SHEET INFO
 PENSACOLA
 TYPICAL CABLE RUN

REVISIONS		
REV.	DESCRIPTION	DATE

ENGINEER APPROVAL	ENGINEER MM	DRAWING NAME TNC-6-102	
	CAD PHB	PROJECT NUMBER AM22316	
	PROJECT MANAGER AP	APPROVED DRAWING DATE 10/11/22	RELEASE NUMBER 1