


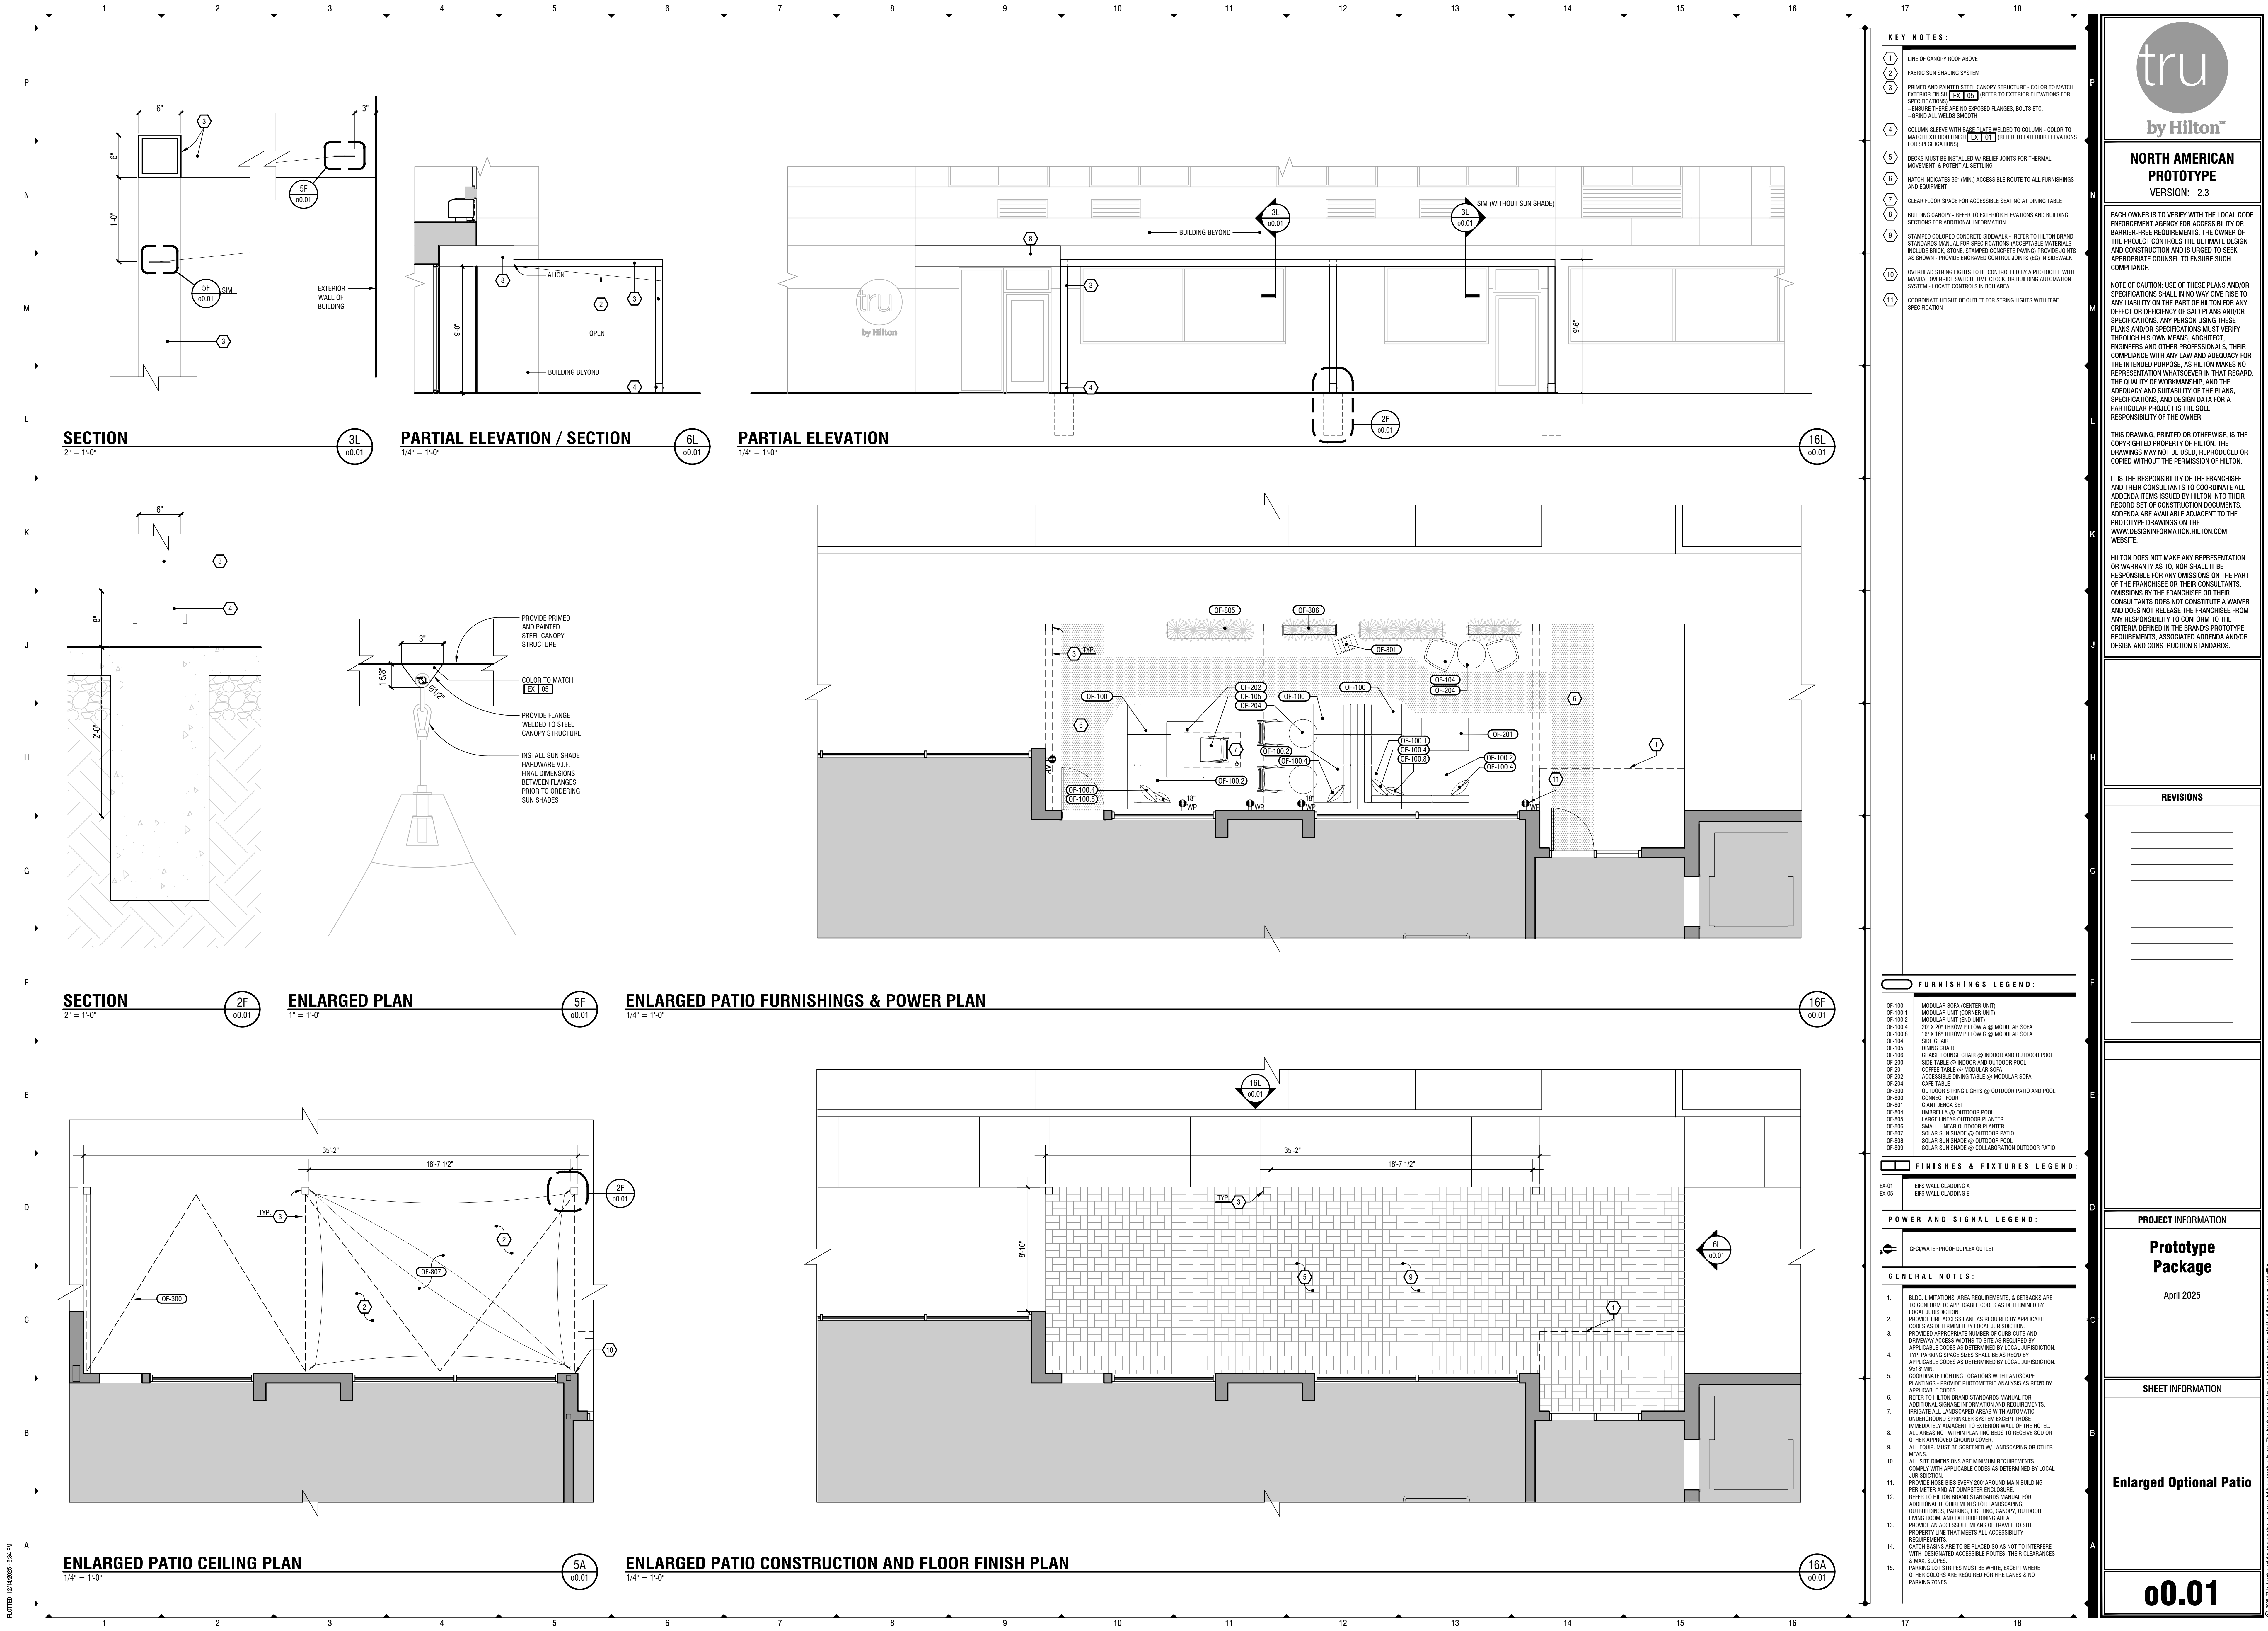

tru

by Hilton™

NORTH AMERICAN

PROTOTYPE

VERSION: 2.3

EACH OWNER IS TO VERIFY WITH THE LOCAL CODE ENFORCEMENT AGENCY FOR ACCESSIBILITY OR BARRIER-FREE REQUIREMENTS. THE OWNER OF THE PROJECT CANNOT BE THE ULTIMATE DESIGN AND CONSTRUCTION AND IS URGED TO SEEK APPROPRIATE COUNSEL TO ENSURE SUCH COMPLIANCE.

NOTE OF CAUTION: USE OF THESE PLANS AND/OR SPECIFICATIONS SHALL IN NO WAY GIVE RISE TO ANY LIABILITY ON THE PART OF HILTON FOR ANY DEFECT OR DEFICIENCY OF SAID PLANS AND/OR SPECIFICATIONS. ANY PERSON USING THESE PLANS AND/OR SPECIFICATIONS MUST VERIFY THROUGH HIS OWN MEANS, ARCHITECT, ENGINEERS AND OTHER PROFESSIONALS, THEIR COMPLIANCE WITH ANY LAW AND ADEQUACY FOR THE INTENDED PURPOSE. AS HILTON MAKES NO REPRESENTATION WHATSOEVER IN THAT REGARD, THE QUALITY OF WORKMANSHIP, AND THE ADEQUACY AND SUITABILITY OF THE PLANS, SPECIFICATIONS, AND DESIGN DATA FOR A PARTICULAR PROJECT IS THE SOLE RESPONSIBILITY OF THE OWNER.

THIS DRAWING, PRINTED OR OTHERWISE, IS THE COPYRIGHTED PROPERTY OF HILTON. THE DRAWINGS MAY NOT BE USED, REPRODUCED OR COPIED WITHOUT THE PERMISSION OF HILTON.

IT IS THE RESPONSIBILITY OF THE FRANCHISEE AND THEIR CONSULTANTS TO COORDINATE ALL ADDENDA ITEMS ISSUED BY HILTON INTO THEIR RECORD SET OF CONSTRUCTION DOCUMENTS. ADDENDA ARE AVAILABLE ADJACENT TO THE PROTOTYPE DRAWINGS ON THE WWW.DESIGNINFORMATION.HILTON.COM WEBSITE.

HILTON DOES NOT MAKE ANY REPRESENTATION OR WARRANTY AS TO, NOR SHALL IT BE RESPONSIBLE FOR ANY OMISSIONS ON THE PART OF THE FRANCHISEE OR THEIR CONSULTANTS. OMISSIONS BY THE FRANCHISEE OR THEIR CONSULTANTS DOES NOT CONSTITUTE A WAIVER AND DOES NOT RELEASE THE FRANCHISEE FROM ANY RESPONSIBILITY TO CONFORM TO THE CRITERIA DEFINED IN THE BRAND'S PROTOTYPE REQUIREMENTS. ASSOCIATED ADDENDA AND/OR DESIGN AND CONSTRUCTION STANDARDS.

REVISIONS

PROJECT INFORMATION

Prototype Package


April 2025

SHEET INFORMATION

Enlarged Optional Patio


00.01


PL011702-12/24/2025-5:54 PM

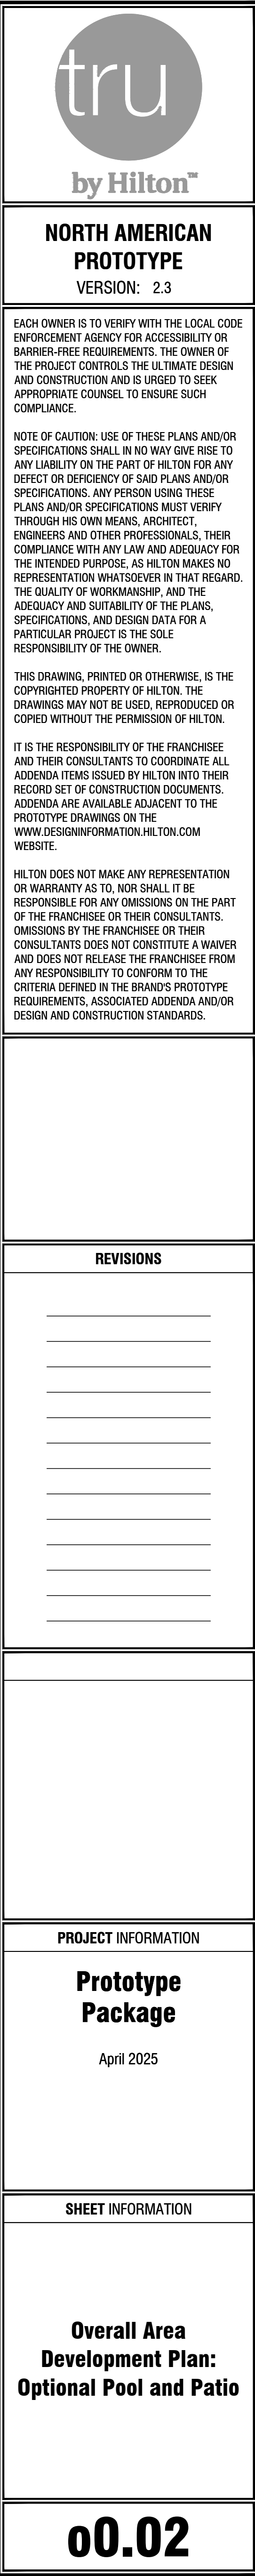

GENERAL ACCESSIBILITY NOTES:

1. ALL CONTROLS FOR USE BY GUESTS MUST BE MOUNTED BETWEEN 15" AND 48" AND MUST HAVE A 30"X48" MINIMUM CLEAR FLOOR SPACE FOR FORWARD OR PARALLEL APPROACH. CONTROLS MOUNTED OVER AN OBSTRUCTION THAT IS BETWEEN 10" AND 24" DEEP MAY BE NO HIGHER THAN 48" AFF IF PARALLEL APPROACH IS PROVIDED. WHERE OBSTRUCTIONS ARE BETWEEN 20" AND 25" DEEP FOR A FORWARD APPROACH, CONTROLS ARE NO HIGHER THAN 48" MAX AFF. CONTROLS MUST NOT REQUIRE TIGHT GRASPING, PINCHING OR TWISTING OF THE WRIST.
2. ACCESSIBLE FEATURES ON ACCESSIBLE ROUTES IN COMMON SPACES: CONTROLS (EMER. PHONES, CARD READERS, ETC.) MUST BE WITHIN REACH RANGE AND MUST COMPLY WITH STANDARDS FOR CONTROLS AS DERIVED IN THE GOVERNING ACCESSIBILITY STANDARDS OR LOCAL CODE, WHICHEVER IS STRICTER. WITHIN EMPLOYEE AREAS AT LEAST ONE OF EACH TYPE OF STORAGE AND 5% OF WORK COUNTERS AND LOCKERS MUST BE WITHIN REACH RANGE AND MUST COMPLY WITH STANDARDS.
3. FIRE ALARM SYSTEM SHALL HAVE PERMANENTLY INSTALLED AUDIBLE AND VISIBLE ALARMS COMPLYING WITH NFPA 72 (1999 OR 2010, ADOPTION) AND AS REQUIRED BY LOCAL AUTHORITIES. ALARMS MUST BE LOCATED IN PUBLIC AND COMMON USE AREAS AND GUEST ROOMS DESIGNATED AS GUEST ROOMS WITH COMMUNICATIONS FEATURES AT A MINIMUM. WHERE EMPLOYEE AREAS HAVE AUDIBLE ALARMS, THE WIRING SHALL BE DESIGNED SO VISIBLE ALARMS CAN BE INTEGRATED INTO THE SYSTEM, UNLESS GREATER STANDARDS ARE REQUIRED BY LOCAL AUTHORITIES.
4. ALL ISOC IDENTIFYING PERMANENT ROOMS OR SPACES ARE REQUIRED TO HAVE VISUAL AND RAISED CHARACTERS AND BRAILLE. SIGNAGE TO BE MOUNTED ON LATCH SIDE OF DOOR WITH THE LOWEST TACTILE CHARACTERS NO LOWER THAN 48" AND THE BOTTOM OF THE HIGHEST TACTILE CHARACTERS NO HIGHER THAN 60" AFF.
5. ALL EQUIPMENT, FURNITURE AND MILLWORK INTENDED FOR GUEST USE MUST MEET ALL CLEARANCES AND REACH RANGES AS DERIVED BY THE GOVERNING ACCESSIBILITY CODE OR LOCAL CODE, WHICHEVER IS STRICTER.
6. PROVIDE ACCESSIBLE FLOOR TRANSITIONS AT ALL LOCATIONS WHERE THERE IS A CHANGE IN FLOORING MATERIAL OR AT DOOR THRESHOLDS. THE CHANGE OF LEVEL BETWEEN MATERIALS MUST BE NO MORE THAN 1/4" OR UP TO 1/2" IF SLOPED AT 1:2.
7. ALL DATA AND POWER RECEPTACLES INTENDED FOR GUEST ACCESS USE MUST BE INSTALLED WITHIN ACC. REACH RANGES - REFER TO GENERAL NOTE #1.
8. WALL MOUNTED EQUIPMENT, FIXTURES, LIGHTING, ETC. BETWEEN 27" AND 80" AFF SHALL NOT PROTRUDE MORE THAN 6" FROM WALL PER ACCESSIBILITY REQUIREMENTS - CONSULT THE HADG FOR FURTHER REQUIREMENTS.
9. ALL EQUIPMENT INTENDED FOR GUEST USE MUST BE PLACED SO THAT CONTROLS REQUIRED FOR USE ARE WITHIN THE ACCESSIBLE REACH RANGE AS DERIVED IN THE GENERAL NOTES ON THE ACCESSIBILITY PLANS. OWNER MUST VERIFY THAT ALL EQUIPMENT MEETS THESE REQUIREMENTS PRIOR TO INSTALLATION.
10. REFER TO HADG FOR ADDITIONAL REQUIREMENTS FOR PUBLIC SOFAS & EQUIPMENT.

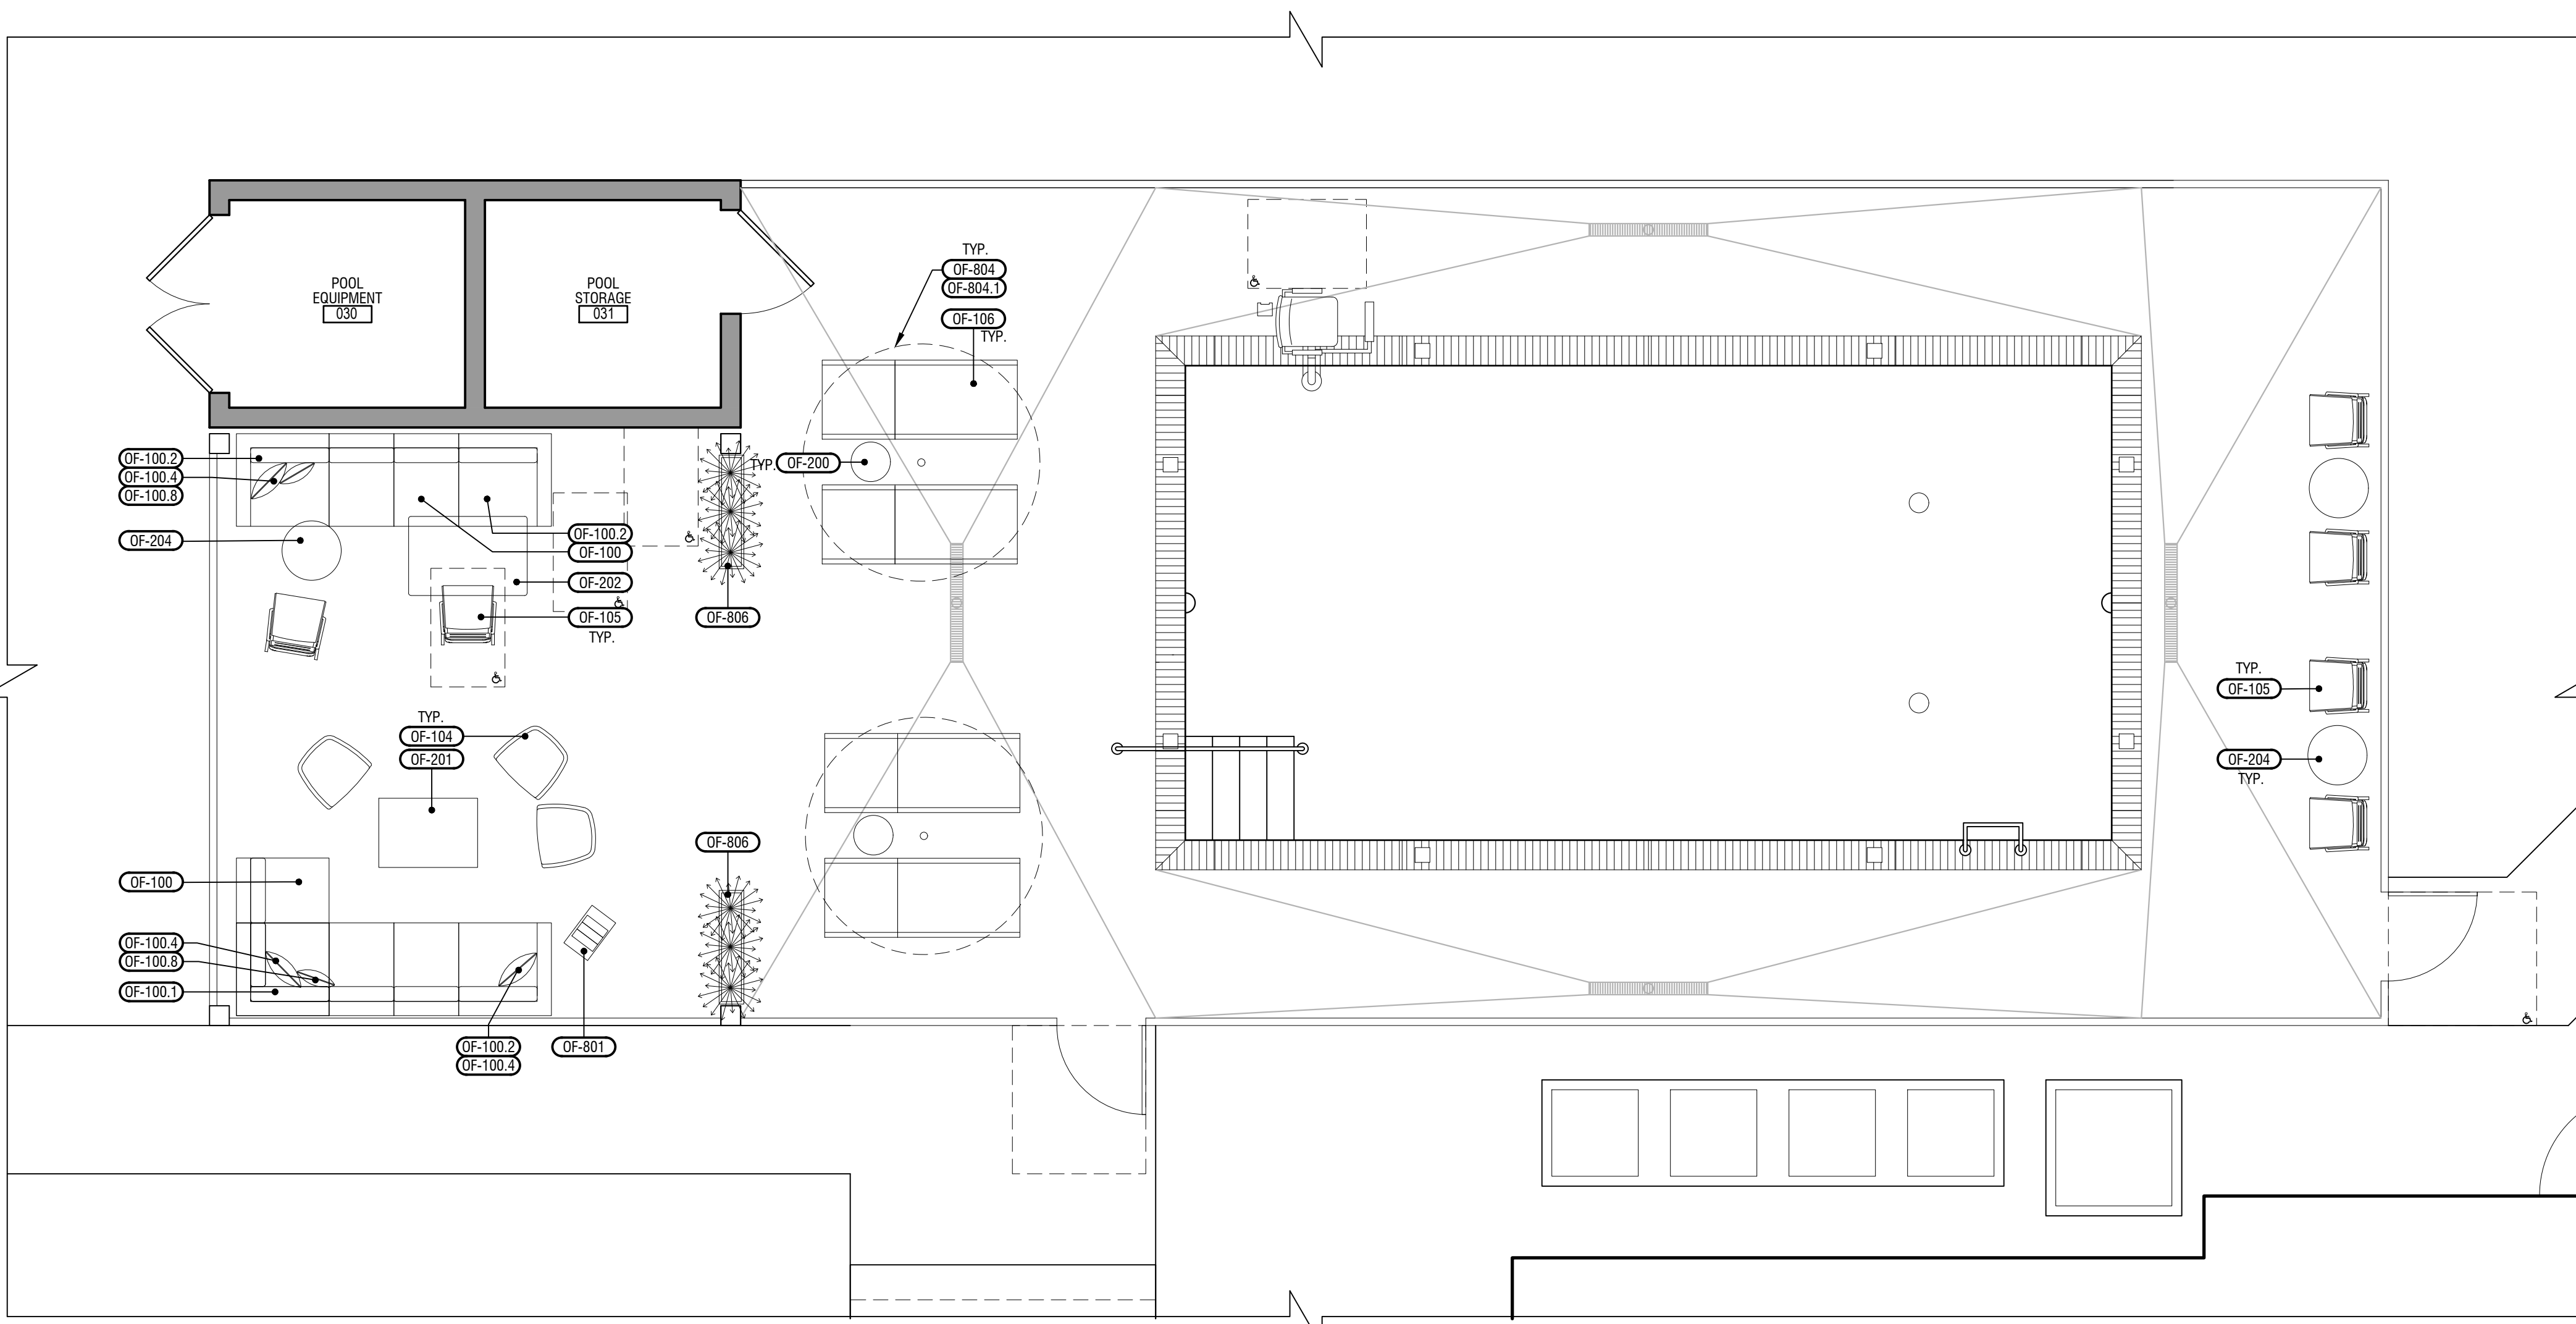

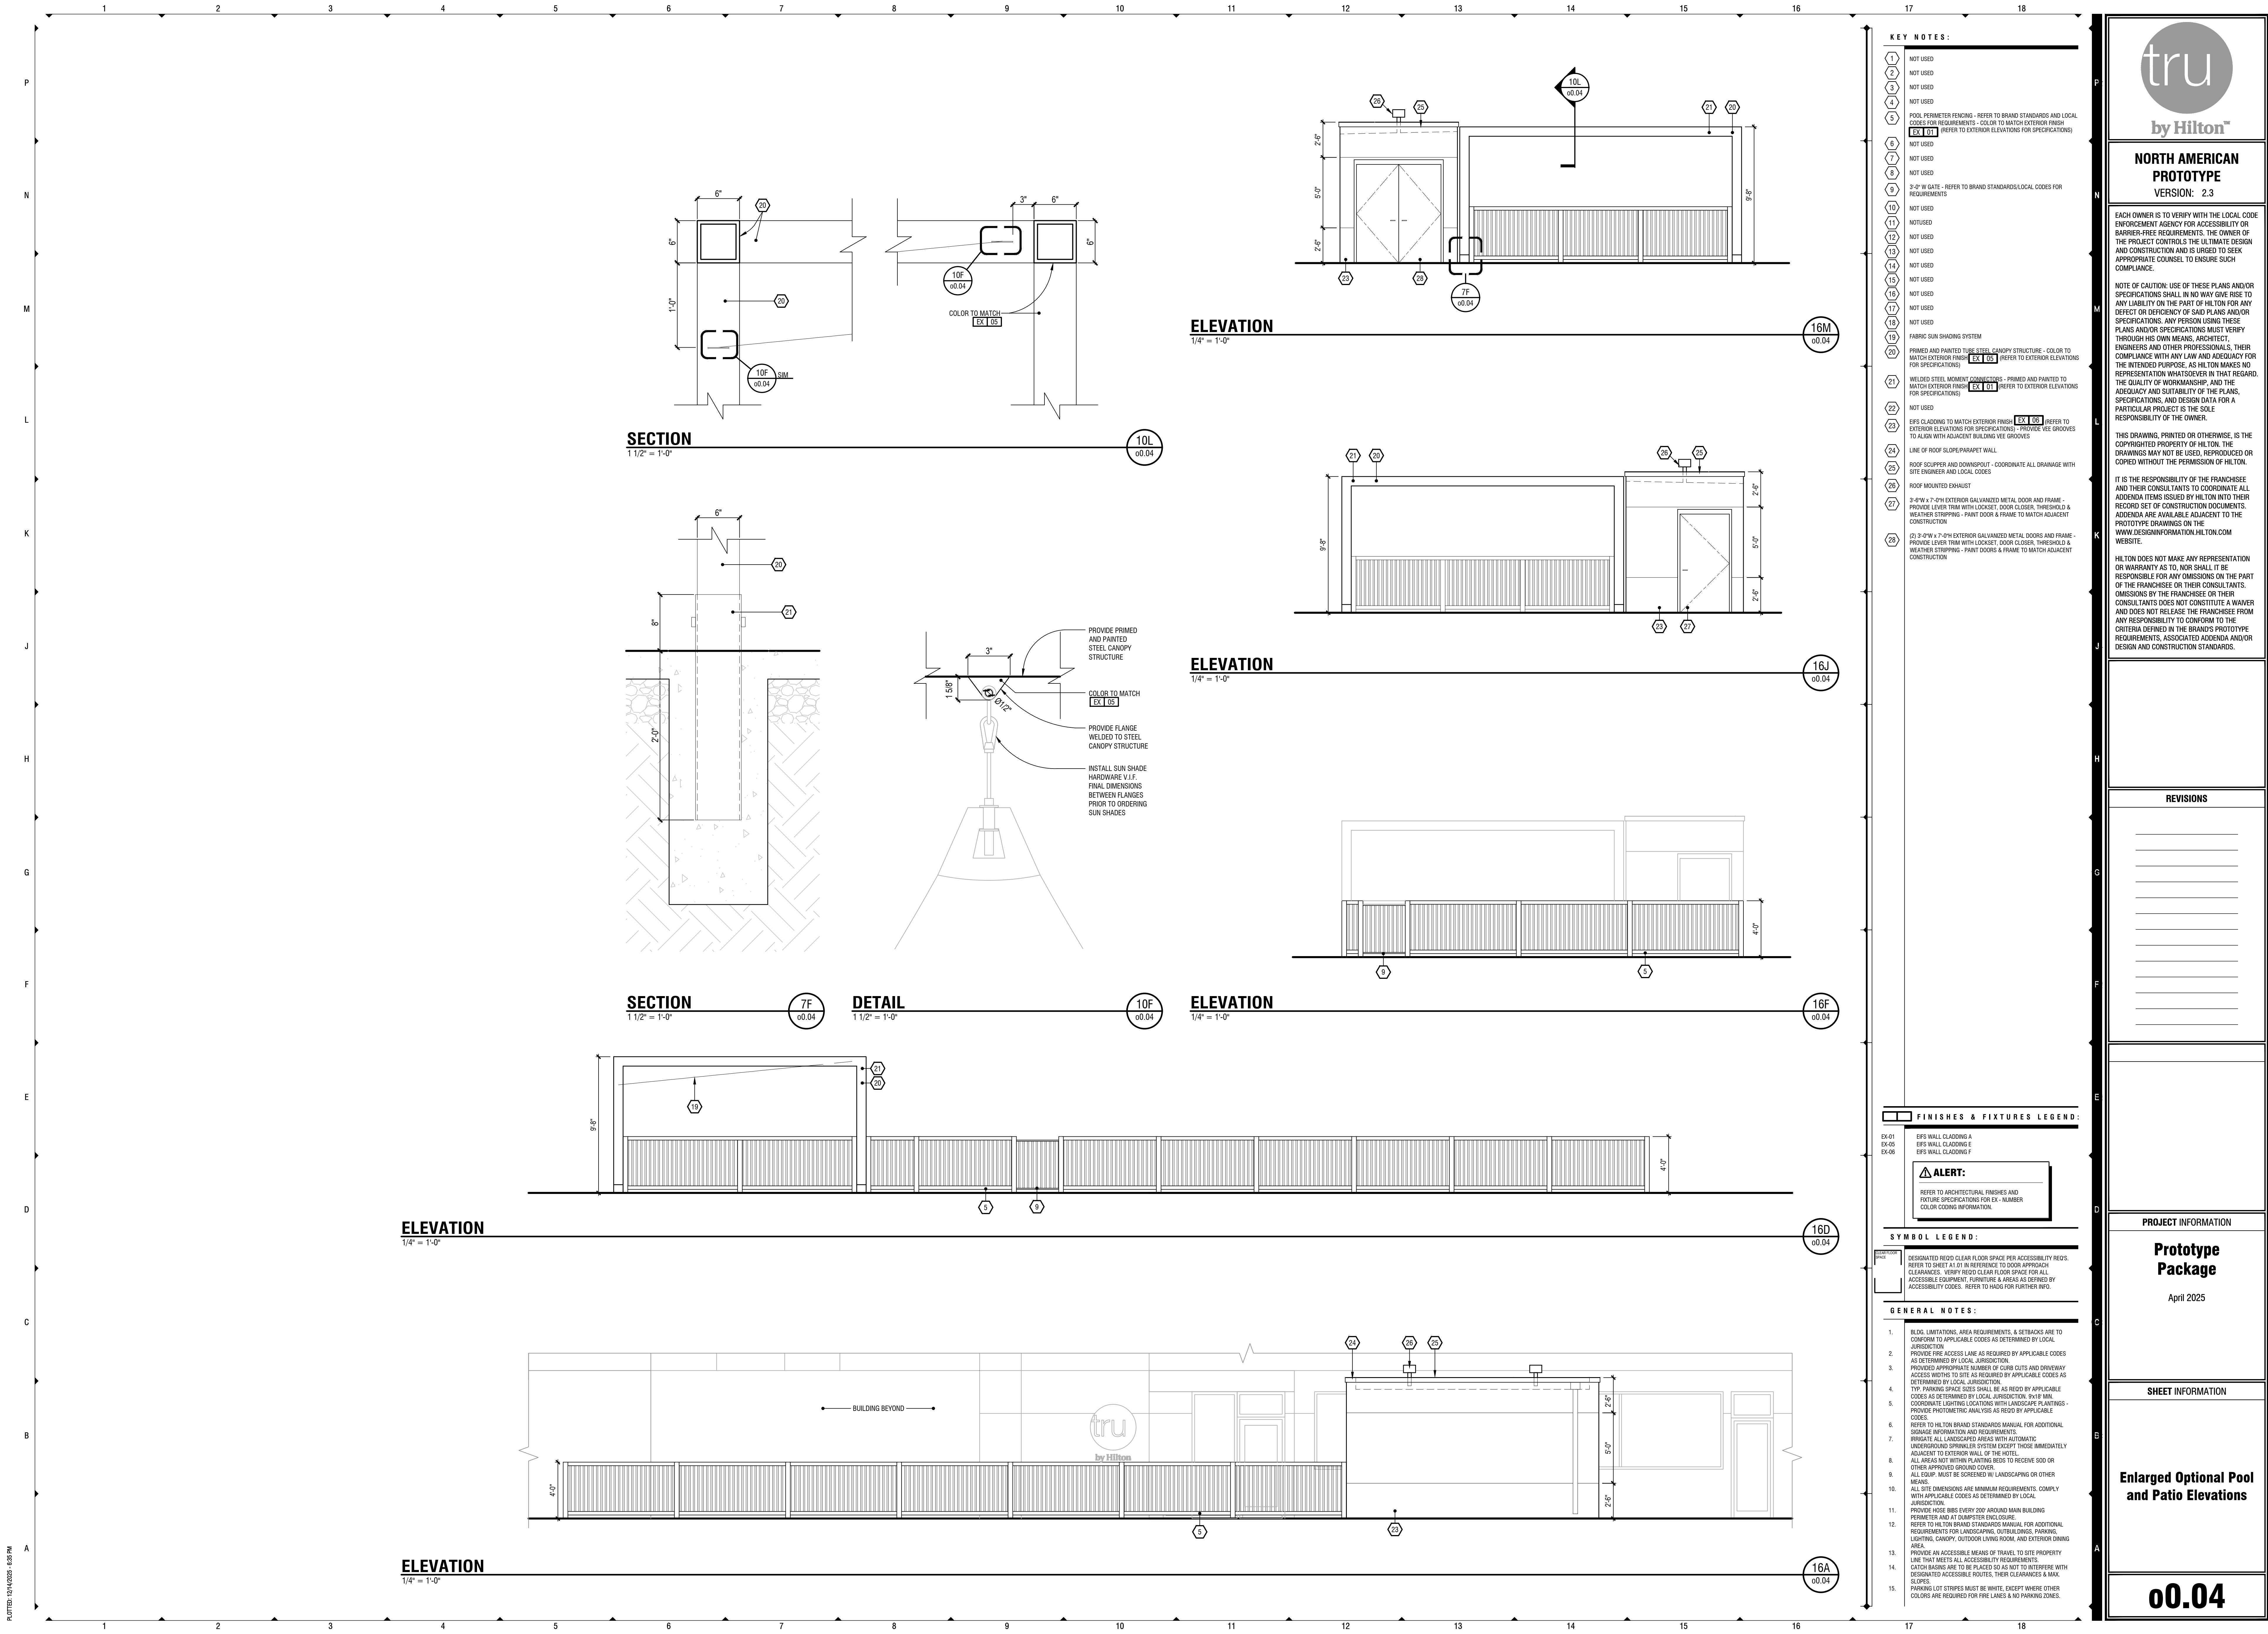

tru

by Hilton™

NORTH AMERICAN

PROTOTYPE

VERSION: 2.3

EACH OWNER IS TO VERIFY WITH THE LOCAL CODE ENFORCEMENT AGENCY FOR ACCESSIBILITY OR BARRIER-FREE REQUIREMENTS. THE OWNER OF THE PROJECT CONTROLS THE ULTIMATE DESIGN AND CONSTRUCTION AND IS URGED TO SEEK APPROPRIATE COUNSEL TO ENSURE SUCH COMPLIANCE.

NOTE OF CAUTION: USE OF THESE PLANS AND/OR SPECIFICATIONS SHALL IN NO WAY GIVE RISE TO ANY LIABILITY ON THE PART OF HILTON FOR ANY DEFECT OR DEFICIENCY OF SAID PLANS AND/OR SPECIFICATIONS. ANY PERSON USING THESE PLANS AND/OR SPECIFICATIONS MUST VERIFY THROUGH HIS OWN MEANS, ARCHITECT, ENGINEERS AND OTHER PROFESSIONALS, THEIR COMPLIANCE WITH ANY LAW AND ADEQUACY FOR THE INTENDED PURPOSE, AS HILTON MAKES NO REPRESENTATION WHATSOEVER IN THAT REGARD. THE QUALITY OF WORKMANSHIP, AND THE ADEQUACY AND SUITABILITY OF THE PLANS, SPECIFICATIONS, AND DESIGN DATA FOR A PARTICULAR PROJECT IS THE SOLE RESPONSIBILITY OF THE OWNER.

THIS DRAWING, PRINTED OR OTHERWISE, IS THE COPYRIGHTED PROPERTY OF HILTON. THE DRAWINGS MAY NOT BE USED, REPRODUCED OR COPIED WITHOUT THE PERMISSION OF HILTON.

IT IS THE RESPONSIBILITY OF THE FRANCHISEE AND THEIR CONSULTANTS TO COORDINATE ALL ADDENDA ITEMS ISSUED BY HILTON INTO THEIR RECORD SET OF CONSTRUCTION DOCUMENTS. ADDENDA ARE AVAILABLE ADJACENT TO THE PROTOTYPE DRAWINGS ON THE WWW.DESIGNINFORMATION.HILTON.COM WEBSITE.

HILTON DOES NOT MAKE ANY REPRESENTATION OR WARRANTY AS TO, NOR SHALL IT BE RESPONSIBLE FOR ANY OMISSIONS ON THE PART OF THE FRANCHISEE OR THEIR CONSULTANTS. OMISSIONS BY THE FRANCHISEE OR THEIR CONSULTANTS DOES NOT CONSTITUTE A WAIVER AND DOES NOT RELEASE THE FRANCHISEE FROM ANY RESPONSIBILITY TO CONFORM TO THE CRITERIA DEFINED IN THE BRAND'S PROTOTYPE REQUIREMENTS. ASSOCIATED ADDENDA AND/OR DESIGN AND CONSTRUCTION STANDARDS.

REVISIONS

PROJECT INFORMATION

Prototype Package

April 2025

SHEET INFORMATION

Enlarged Optional Pool and Patio Elevations


00.04

PL011020-12/24/2025-6:58 PM



- 

00.05

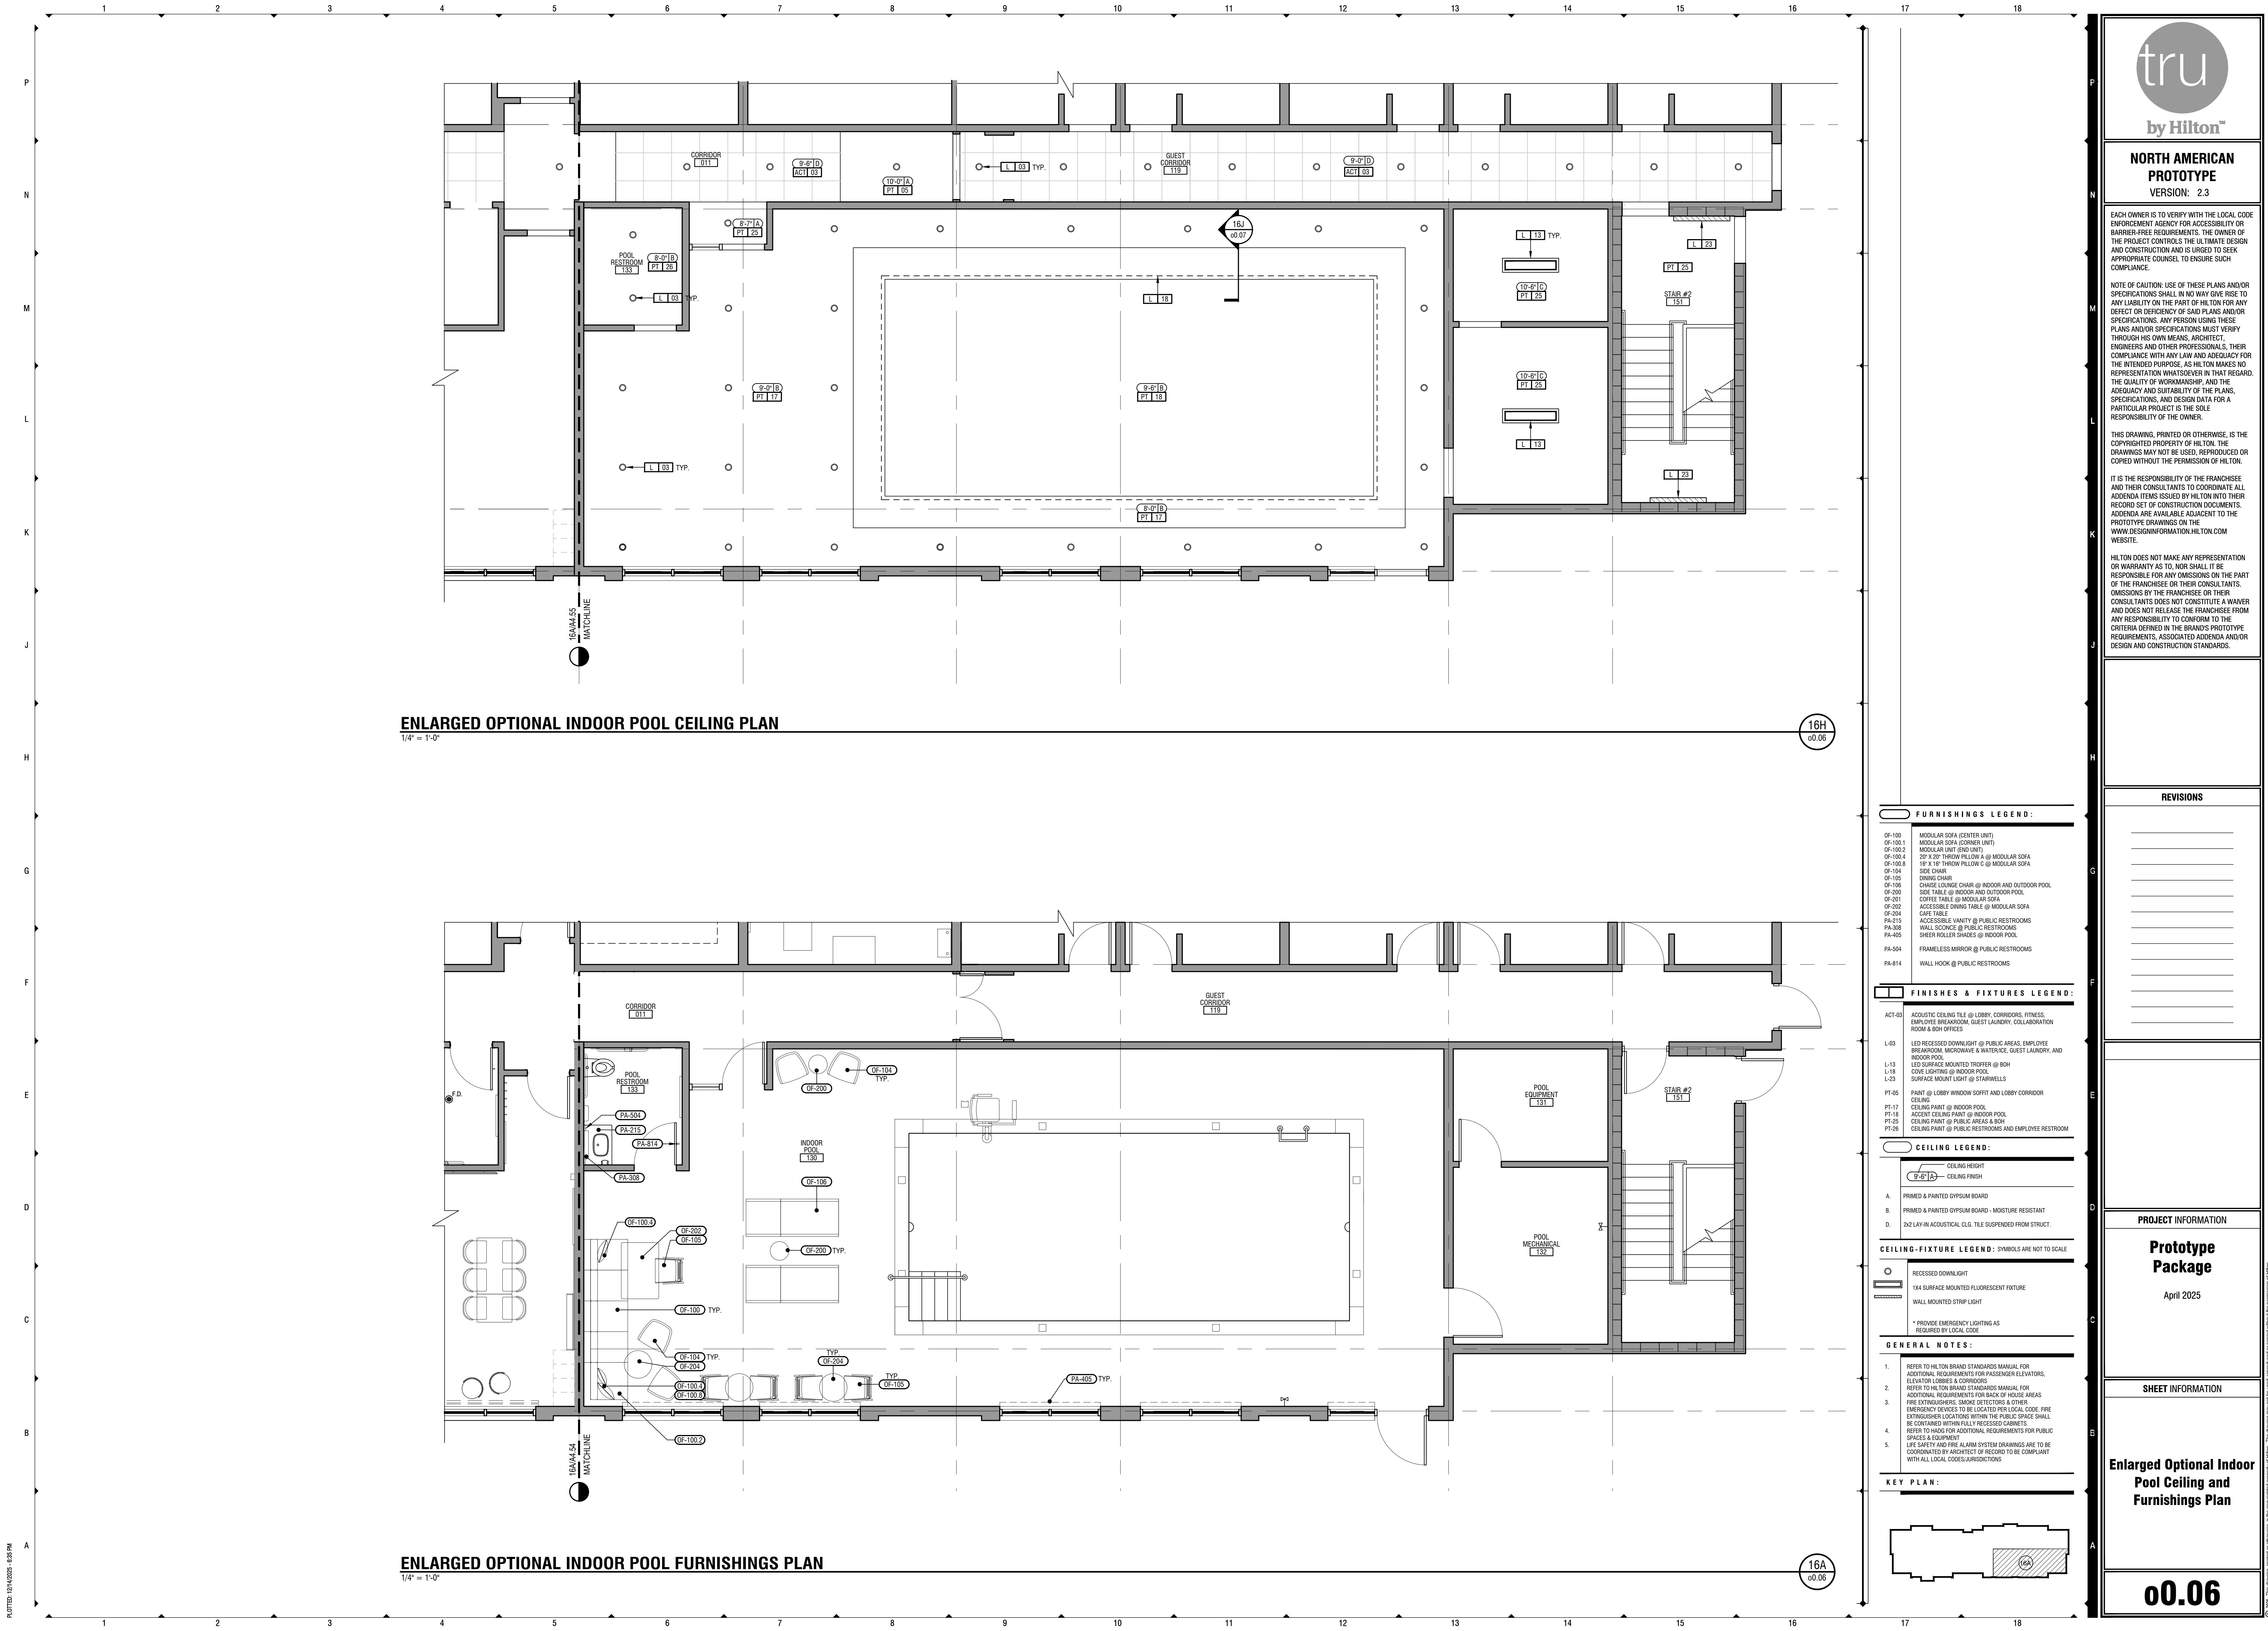

ENLARGED OPTIONAL INDOOR POOL CEILING PLAN
1/4" = 1'-0"

ENLARGED OPTIONAL INDOOR POOL FURNISHINGS PLAN
1/4" = 1'-0"

NORTH AMERICAN
PROTOTYPE
VERSION: 2.3

EACH OWNER IS TO VERIFY WITH THE LOCAL CODE ENFORCEMENT AGENCY FOR ACCESSIBILITY OR BARRIER-FREE REQUIREMENTS. THE OWNER OF THE PROJECT CONTROLS THE ULTIMATE DESIGN AND CONSTRUCTION AND IS URGED TO SEEK APPROPRIATE COUNSEL TO ENSURE SUCH COMPLIANCE.

NOTE OF CAUTION: USE OF THESE PLANS AND/OR SPECIFICATIONS SHALL IN NO WAY GIVE RISE TO ANY LIABILITY ON THE PART OF HILTON FOR ANY DEFECT OR DEFICIENCY OF SAID PLANS AND/OR SPECIFICATIONS. ANY PERSON USING THESE PLANS AND/OR SPECIFICATIONS MUST VERIFY THROUGH HIS OWN MEANS, ARCHITECT, ENGINEERS AND OTHER PROFESSIONALS, THEIR COMPLIANCE WITH ANY LAW AND ADEQUACY FOR THE INTENDED PURPOSE. AS HILTON MAKES NO REPRESENTATION WHATSOEVER IN THAT REGARD, THE QUALITY OF WORKMANSHIP, AND THE ADEQUACY AND SUITABILITY OF THE PLANS, SPECIFICATIONS, AND DESIGN DATA FOR A PARTICULAR PROJECT IS THE SOLE RESPONSIBILITY OF THE OWNER.

THIS DRAWING, PRINTED OR OTHERWISE, IS THE COPYRIGHTED PROPERTY OF HILTON. THE DRAWINGS MAY NOT BE USED, REPRODUCED OR COPIED WITHOUT THE PERMISSION OF HILTON.

IT IS THE RESPONSIBILITY OF THE FRANCHISEE AND THEIR CONSULTANTS TO COORDINATE ALL ADDENDA ITEMS ISSUED BY HILTON INTO THEIR RECORD SET OF CONSTRUCTION DOCUMENTS. ADDENDA ARE AVAILABLE ADJACENT TO THE PROTOTYPE DRAWINGS ON THE WWW.DESIGNINFORMATION.HILTON.COM WEBSITE.

HILTON DOES NOT MAKE ANY REPRESENTATION OR WARRANTY AS TO, NOR SHALL IT BE RESPONSIBLE FOR ANY OMISSIONS ON THE PART OF THE FRANCHISEE OR THEIR CONSULTANTS. OMISSIONS BY THE FRANCHISEE OR THEIR CONSULTANTS DOES NOT CONSTITUTE A WAIVER AND DOES NOT RELEASE THE FRANCHISEE FROM ANY RESPONSIBILITY TO CONFORM TO THE CRITERIA DEFINED IN THE BRAND'S PROTOTYPE REQUIREMENTS. ASSOCIATED ADDENDA AND/OR DESIGN AND CONSTRUCTION STANDARDS.

REVISIONS	

PROJECT INFORMATION	
Prototype Package	
April 2025	

SHEET INFORMATION	
Enlarged Optional Indoor Pool Ceiling and Furnishings Plan	
00.06	

FURNISHINGS LEGEND:

OF-100 MODULAR SOFA (CENTER UNIT)
OF-100.1 MODULAR SOFA (CORNER UNIT)
OF-100.2 MODULAR UNIT (END UNIT)
OF-100.4 20" X 20" THROW PILLOW A @ MODULAR SOFA
OF-100.8 16" X 16" THROW PILLOW C @ MODULAR SOFA
OF-104 SIDE CHAIR
OF-105 DINING CHAIR
OF-106 CHAIR LOUNGE CHAIR @ INDOOR AND OUTDOOR POOL
OF-200 SIDE TABLE @ INDOOR AND OUTDOOR POOL
OF-201 COFFEE TABLE @ MODULAR SOFA
OF-202 ACCESSIBLE DINING TABLE @ MODULAR SOFA
OF-204 CAFE TABLE
PA-215 ACCESSIBLE VANITY @ PUBLIC RESTROOMS
PA-308 WALL SCONCE @ PUBLIC RESTROOMS
PA-405 SHEER ROLLER SHADES @ INDOOR POOL
PA-504 FRAMELESS MIRROR @ PUBLIC RESTROOMS
PA-814 WALL HOOK @ PUBLIC RESTROOMS

FINISHES & FIXTURES LEGEND:

ACT-03 ACOUSTIC CEILING TILE @ LOBBY, CORRIDORS, FITNESS, EMPLOYEE BREAKROOM, GUEST LAUNDRY, COLLABORATION ROOM & BOH OFFICES
L-03 LED RECESSED DOWNLIGHT @ PUBLIC AREAS, EMPLOYEE BREAKROOM, MICROWAVE & WATERVIEW, GUEST LAUNDRY, AND INDOOR POOL
L-13 LED SURFACE MOUNTED TROFFER @ BOH
L-18 COVE LIGHTING @ INDOOR POOL
L-23 SURFACE MOUNT LIGHT @ STAIRWELLS
PT-05 PAINT @ LOBBY WINDOW SOFFIT AND LOBBY CORRIDOR
PT-17 CEILING PAINT @ INDOOR POOL
PT-18 ACCENT CEILING PAINT @ INDOOR POOL
PT-25 CEILING PAINT @ PUBLIC AREAS & BOH
PT-26 CEILING PAINT @ PUBLIC RESTROOMS AND EMPLOYEE RESTROOM

CEILING LEGEND:

CEILING HEIGHT
9'-8" (A) CEILING FINISH
A. PRIMED & PAINTED GYPSUM BOARD
B. PRIMED & PAINTED GYPSUM BOARD - MOISTURE RESISTANT
D. 2x2 LAY-IN ACOUSTICAL CLG. TILE SUSPENDED FROM STRUCT.


CEILING-FIXTURE LEGEND: SYMBOLS ARE NOT TO SCALE


RECESSED DOWNLIGHT
1X4 SURFACE MOUNTED FLUORESCENT FIXTURE
WALL MOUNTED STRIP LIGHT
* PROVIDE EMERGENCY LIGHTING AS REQUIRED BY LOCAL CODE

GENERAL NOTES:

- REFER TO HILTON BRAND STANDARDS MANUAL FOR ADDITIONAL REQUIREMENTS FOR PASSENGER ELEVATORS, ELEVATOR LOBBIES & CORRIDORS.
- REFER TO HILTON BRAND STANDARDS MANUAL FOR ADDITIONAL REQUIREMENTS FOR BACK OF HOUSE AREAS.
- FIRE EXTINGUISHERS, SMOKE DETECTORS & OTHER EMERGENCY DEVICES TO BE LOCATED PER LOCAL CODE. FIRE EXTINGUISHERS LOCATING WITHIN THE PUBLIC SPACE SHALL BE CONTAINED WITHIN FULLY RECESSED CABINETS.
- REFER TO HAD FOR ADDITIONAL REQUIREMENTS FOR PUBLIC SPACES & EQUIPMENT.
- LIFE SAFETY AND FIRE ALARM SYSTEM DRAWINGS ARE TO BE COORDINATED BY ARCHITECT OF RECORD TO BE COMPLIANT WITH ALL LOCAL CODES/JURISDICTIONS.

KEY PLAN:

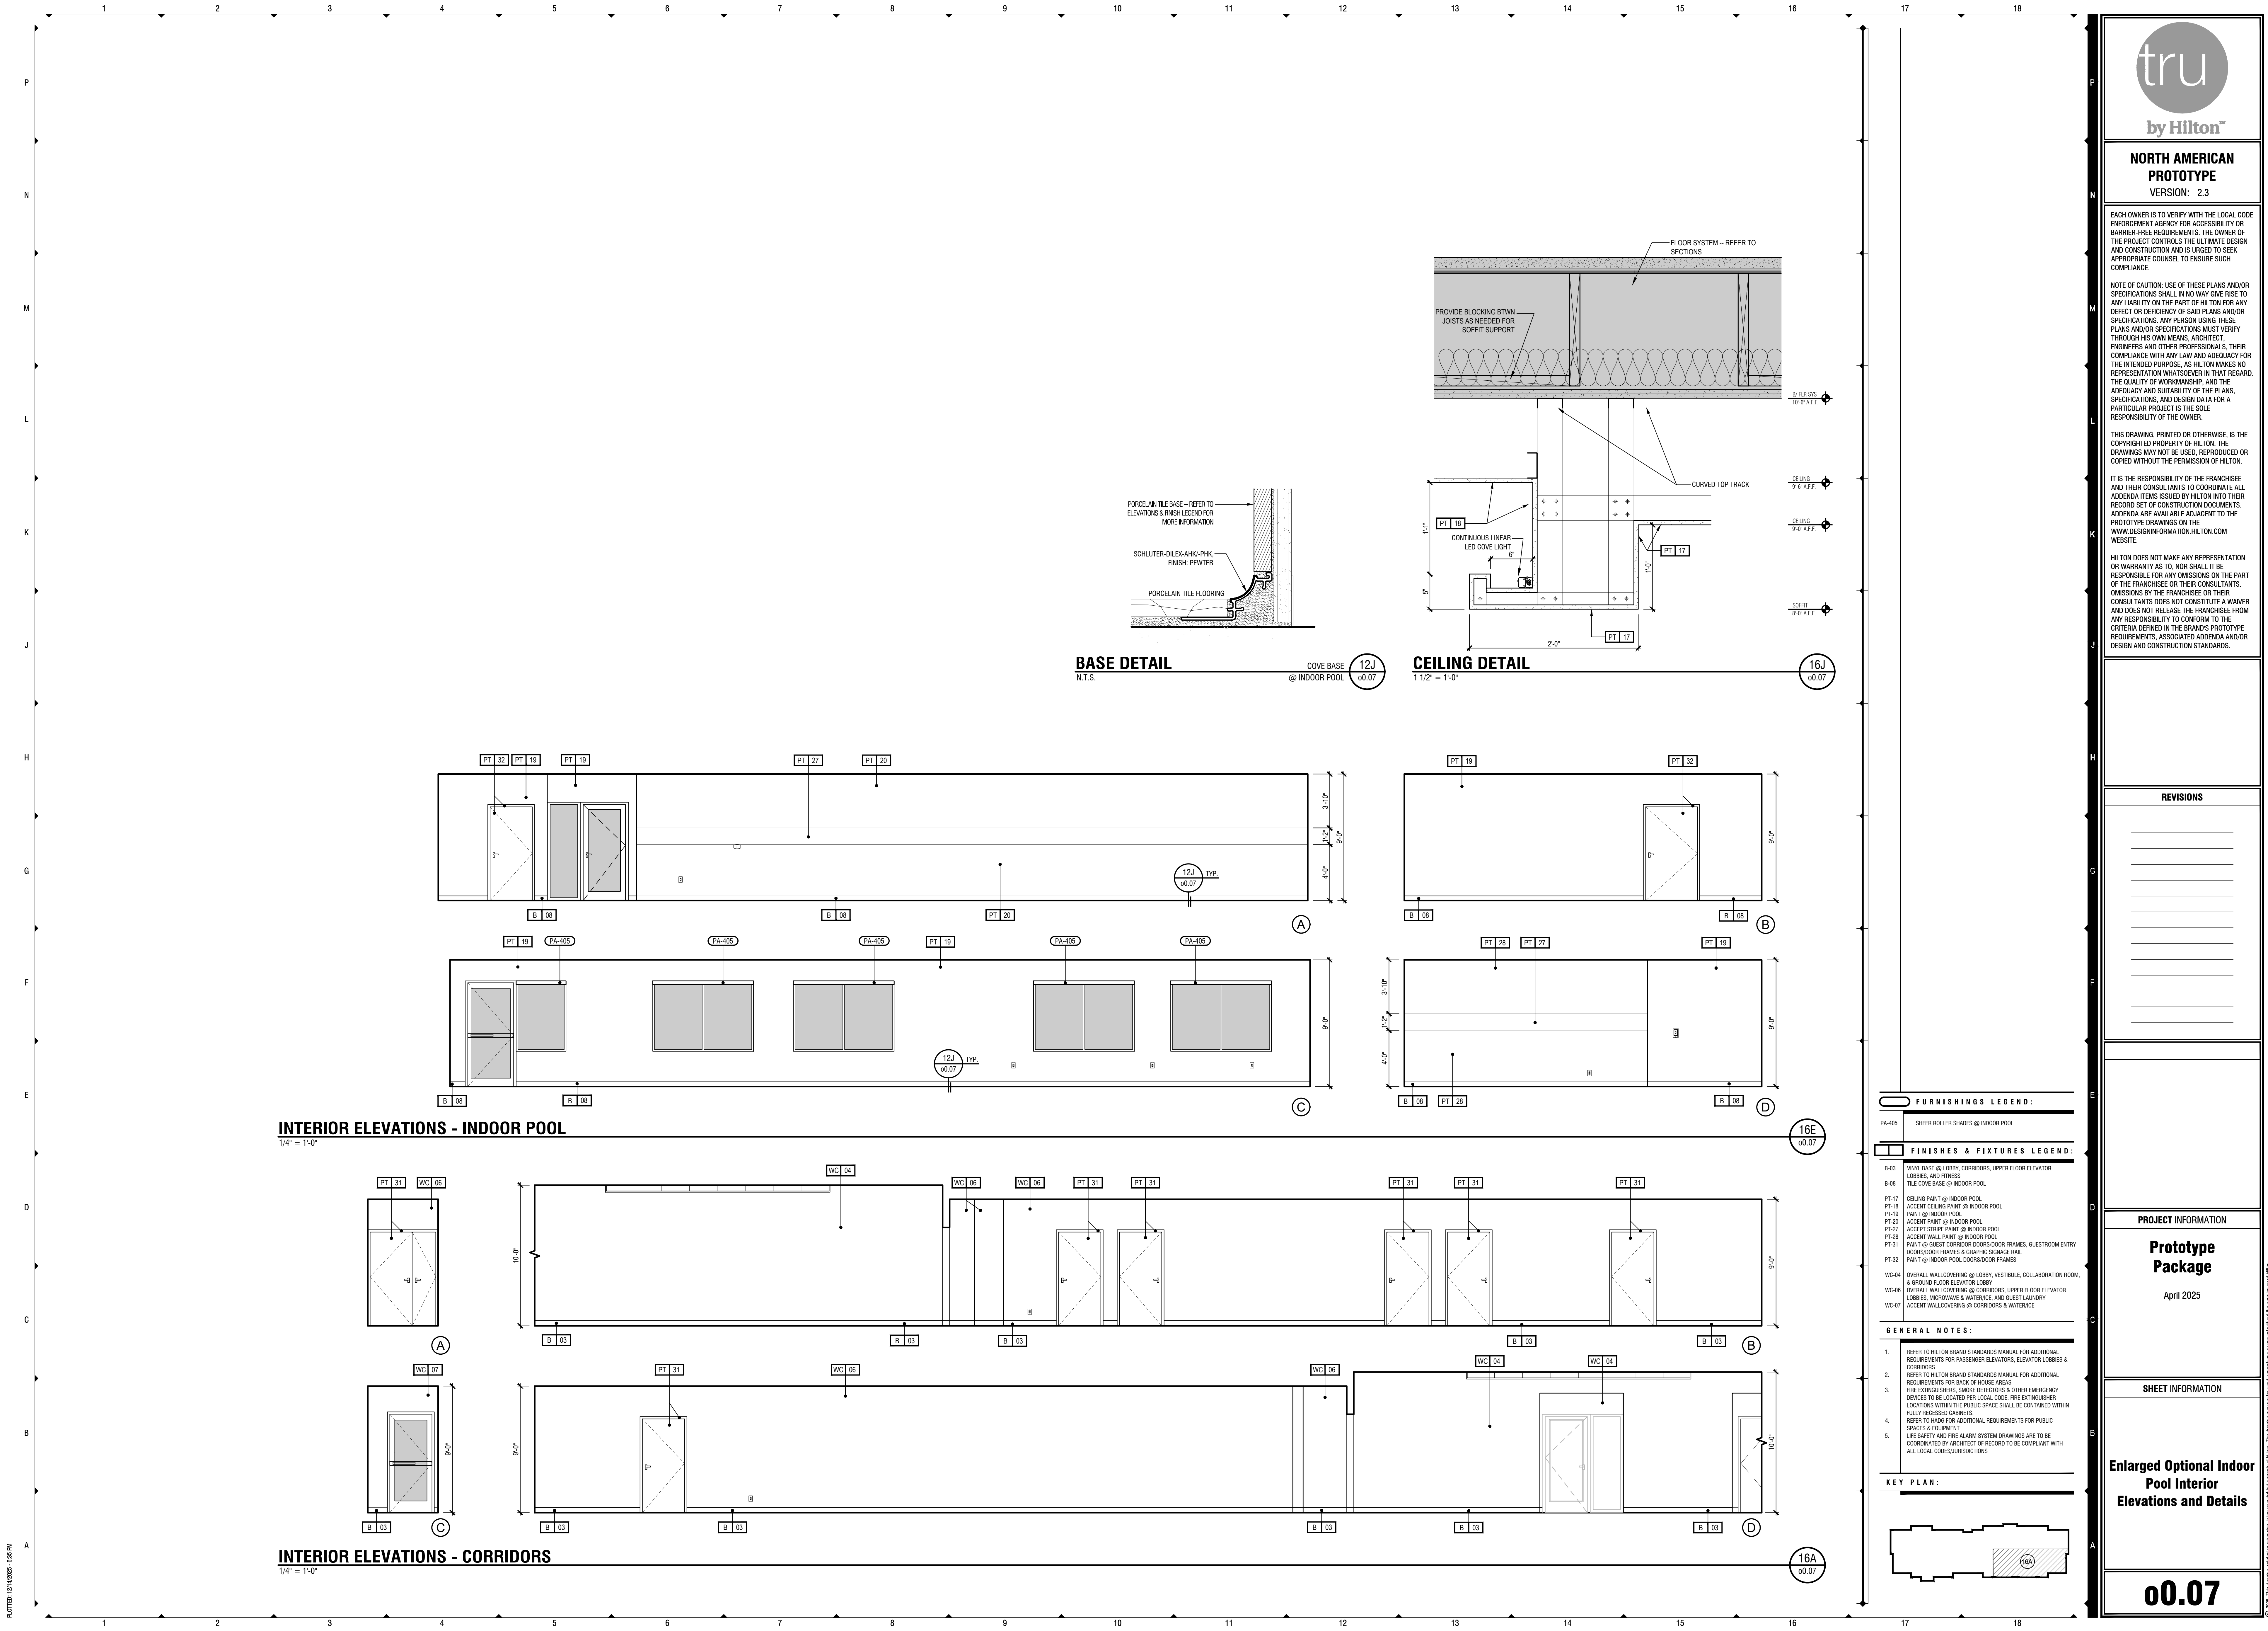

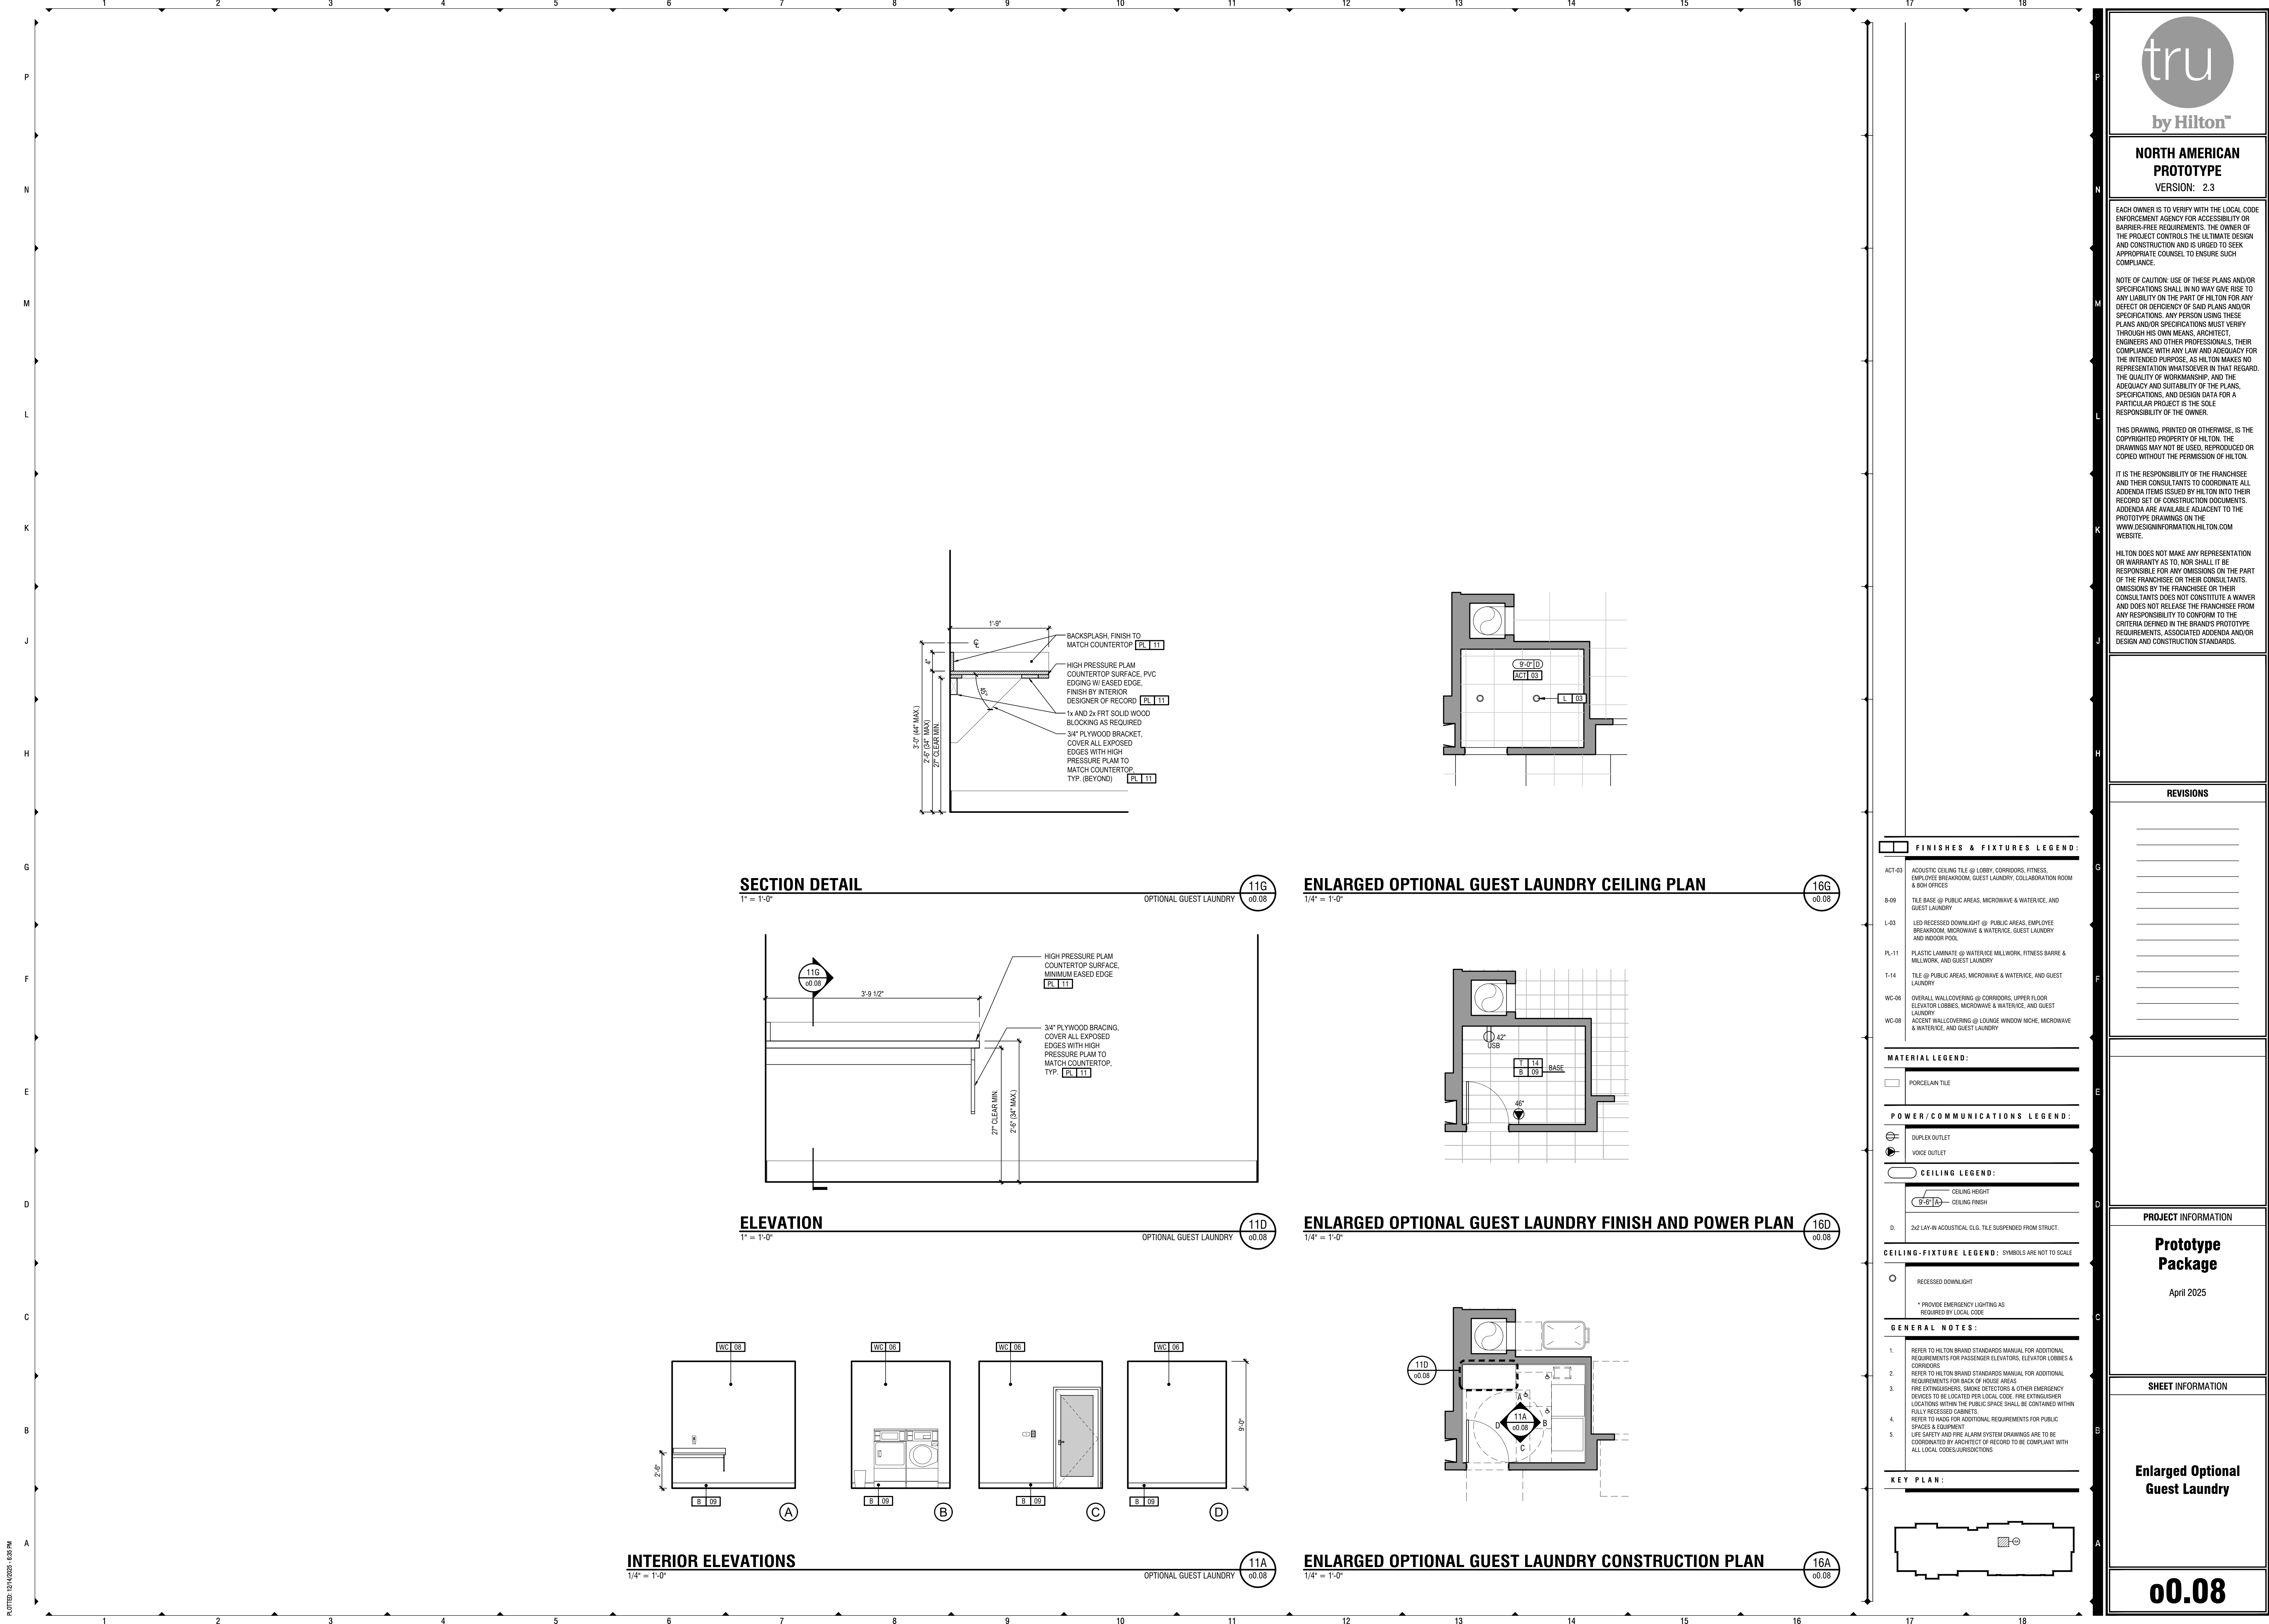

NORTH AMERICAN
PROTOTYPE
VERSION: 2.3

EACH OWNER IS TO VERIFY WITH THE LOCAL CODE ENFORCEMENT AGENCY FOR ACCESSIBILITY OR BARRIER-FREE REQUIREMENTS. THE OWNER OF THE PROJECT CONTROLS THE ULTIMATE DESIGN AND CONSTRUCTION AND IS URGED TO SEEK APPROPRIATE COUNSEL TO ENSURE SUCH COMPLIANCE.

NOTE OF CAUTION: USE OF THESE PLANS AND/OR SPECIFICATIONS SHALL IN NO WAY GIVE RISE TO ANY LIABILITY ON THE PART OF HILTON FOR ANY DEFECT OR DEFICIENCY OF SAID PLANS AND/OR SPECIFICATIONS. ANY PERSON USING THESE PLANS AND/OR SPECIFICATIONS MUST VERIFY THROUGH HIS OWN MEANS, ARCHITECT, ENGINEERS AND OTHER PROFESSIONALS, THEIR COMPLIANCE WITH ANY LAW AND ADEQUACY FOR THE INTENDED PURPOSE, AS HILTON MAKES NO REPRESENTATION WHATSOEVER IN THAT REGARD. THE QUALITY OF WORKMANSHIP, AND THE ADEQUACY AND SUITABILITY OF THE PLANS, SPECIFICATIONS, AND DESIGN DATA FOR A PARTICULAR PROJECT IS THE SOLE RESPONSIBILITY OF THE OWNER.

THIS DRAWING, PRINTED OR OTHERWISE, IS THE COPYRIGHTED PROPERTY OF HILTON. THE DRAWINGS MAY NOT BE USED, REPRODUCED OR COPIED WITHOUT THE PERMISSION OF HILTON.

IT IS THE RESPONSIBILITY OF THE FRANCHISEE AND THEIR CONSULTANTS TO COORDINATE ALL ADDENDA ITEMS ISSUED BY HILTON INTO THEIR RECORD SET OF CONSTRUCTION DOCUMENTS. ADDENDA ARE AVAILABLE ADJACENT TO THE PROTOTYPE DRAWINGS ON THE WWW.DESIGNINFORMATION.HILTON.COM WEBSITE.

HILTON DOES NOT MAKE ANY REPRESENTATION OR WARRANTY AS TO, NOR SHALL IT BE RESPONSIBLE FOR ANY OMISSIONS ON THE PART OF THE FRANCHISEE OR THEIR CONSULTANTS. OMISSIONS BY THE FRANCHISEE OR THEIR CONSULTANTS DOES NOT CONSTITUTE A WAIVER AND DOES NOT RELEASE THE FRANCHISEE FROM ANY RESPONSIBILITY TO CONFORM TO THE CRITERIA DEFINED IN THE BRAND'S PROTOTYPE REQUIREMENTS. ASSOCIATED ADDENDA AND/OR DESIGN AND CONSTRUCTION STANDARDS.

NO.	REVISIONS

PROJECT INFORMATION

Prototype Package


April 2025

SHEET INFORMATION


Enlarged Optional Guest Laundry

00.08

© 2025. This drawing is a prototype or otherwise, is the copyrighted property of Hilton. This drawing may not be used, reproduced or copied without the permission of Hilton.

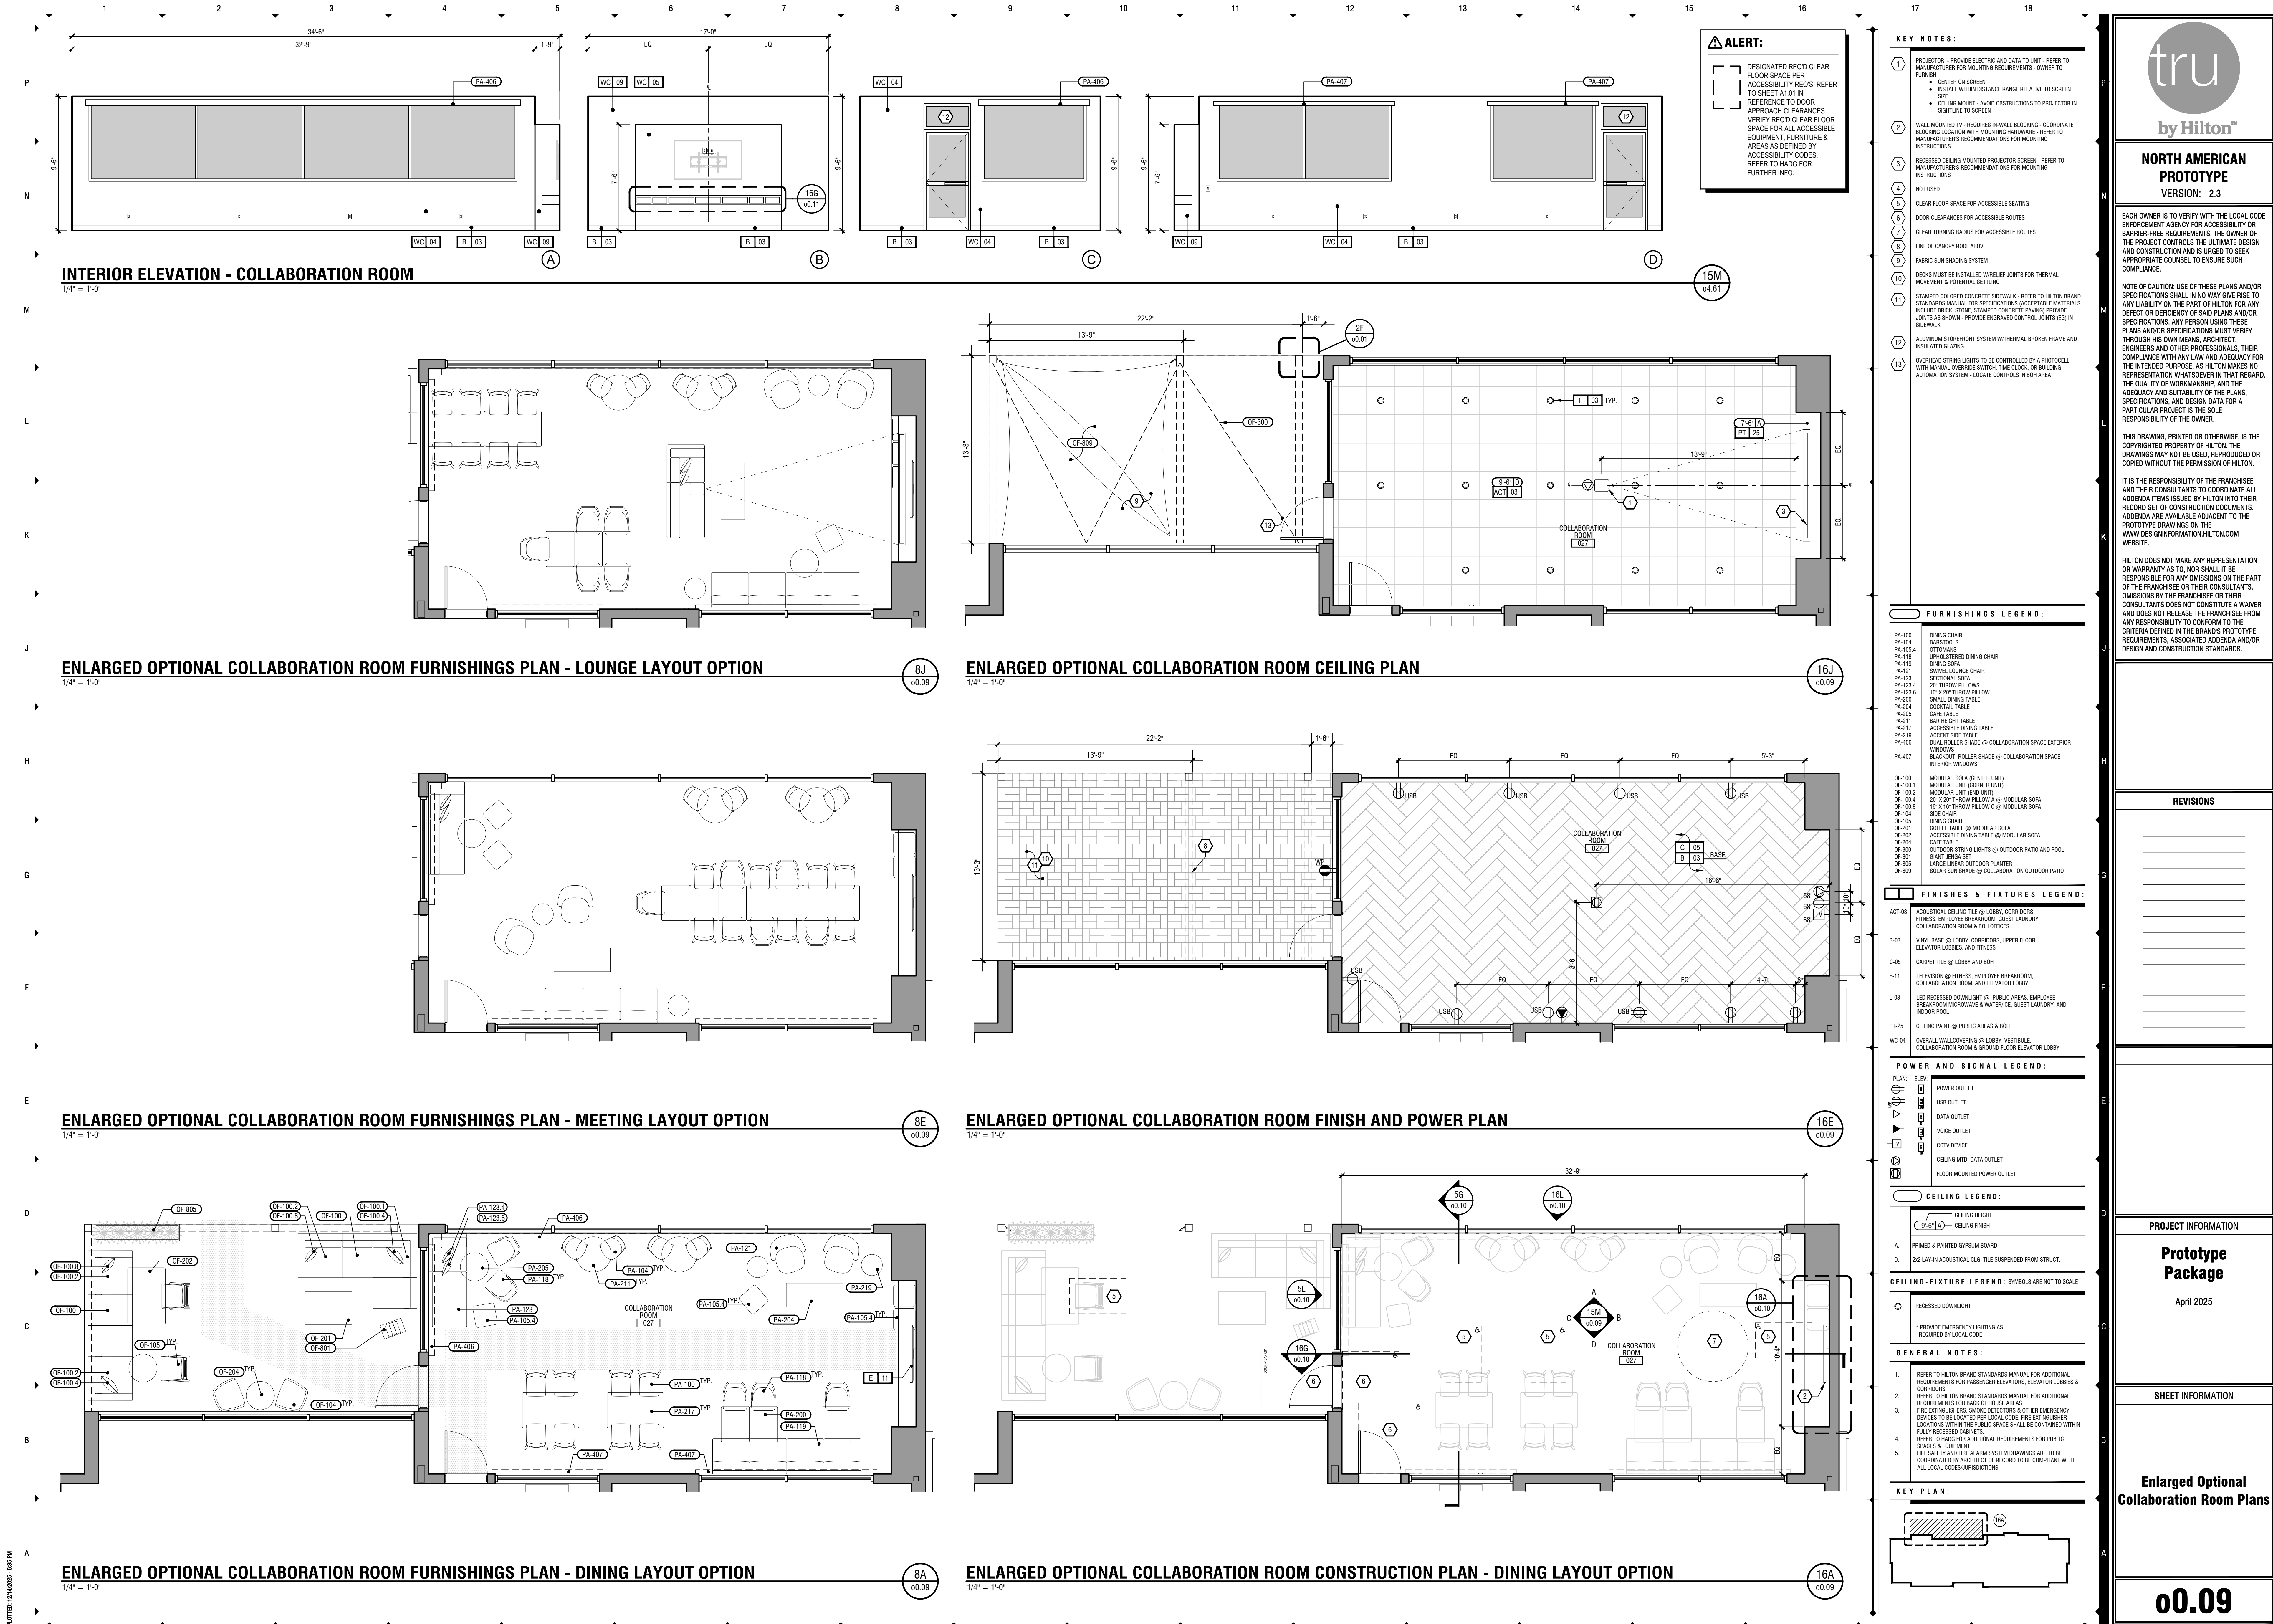


PL0110D-12/24/2025-5:58 PM

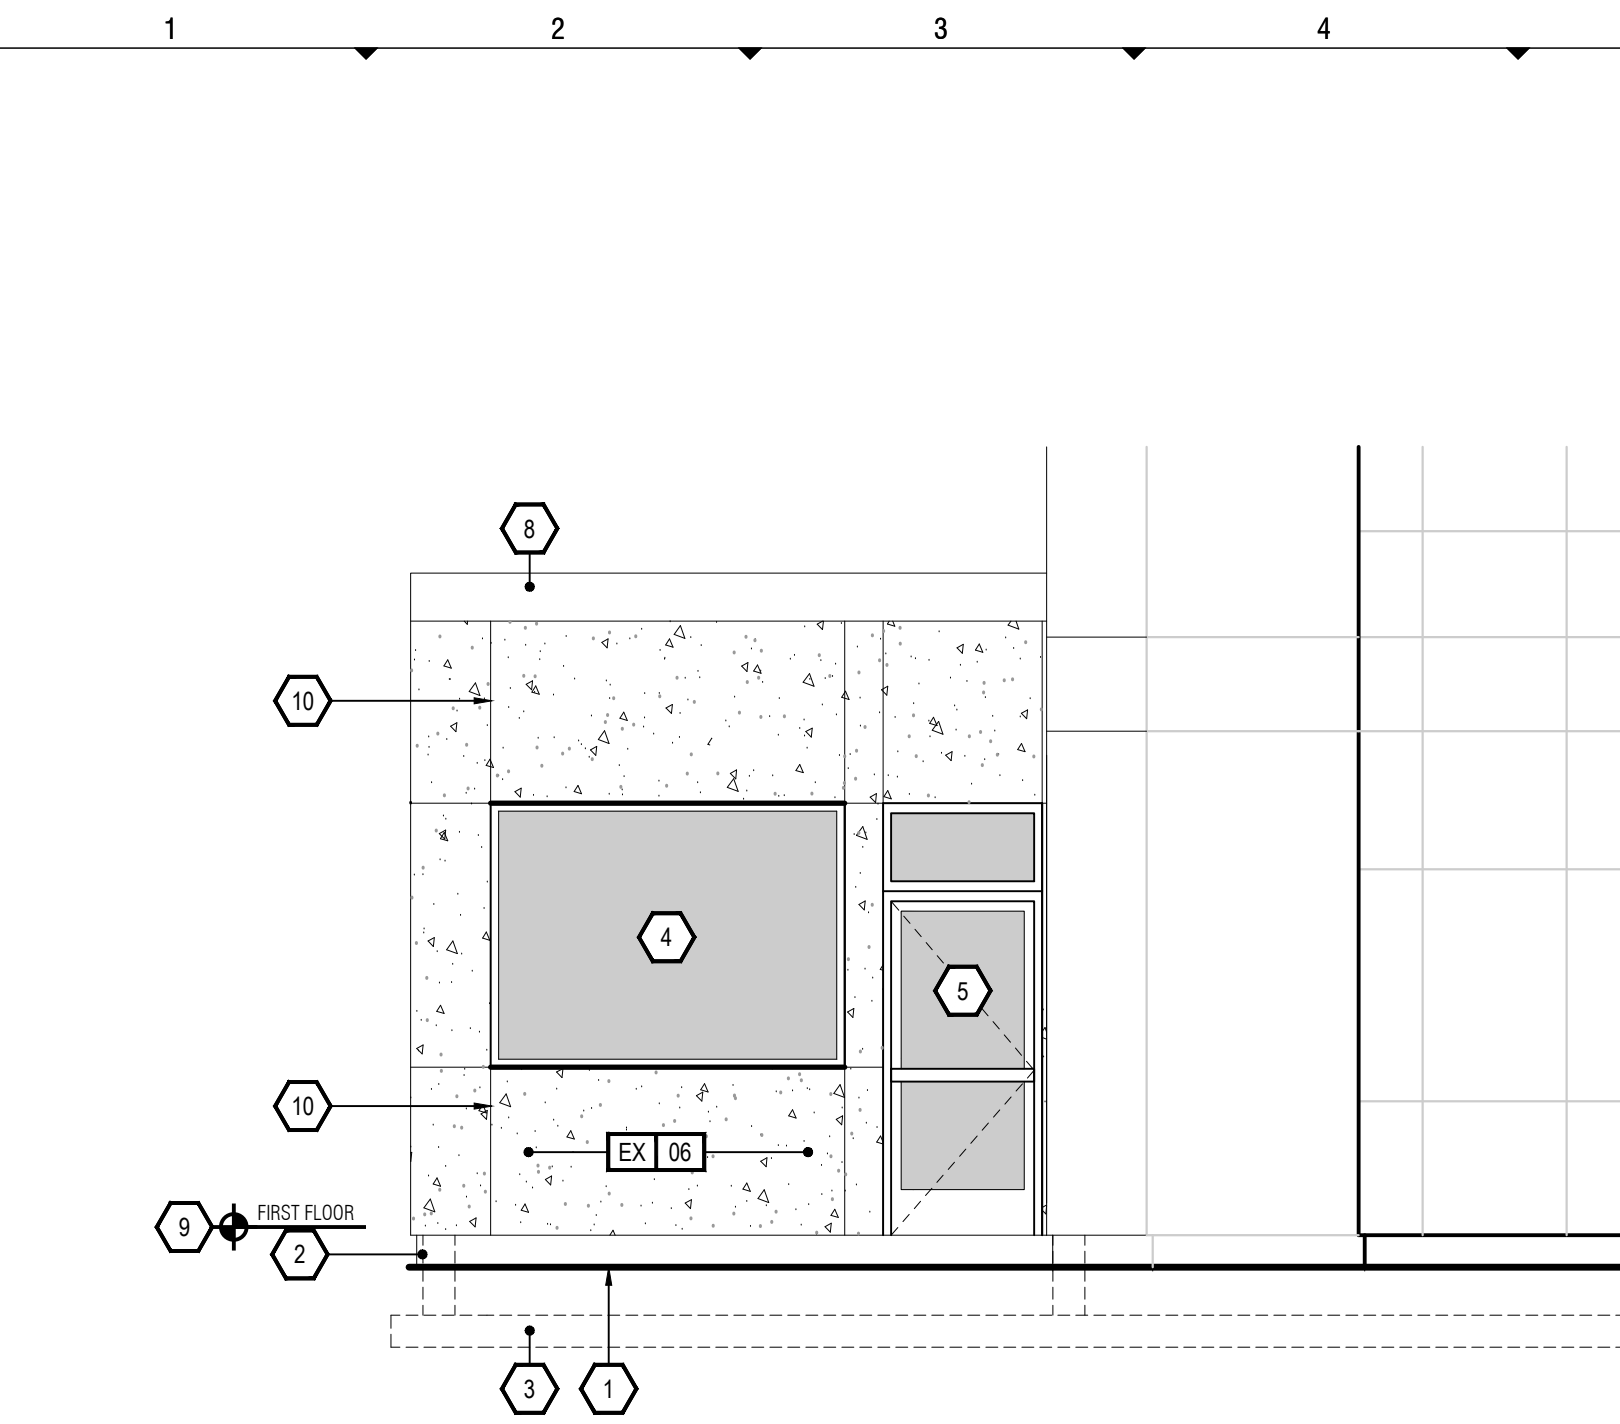


EXTERIOR ELEVATION
1/4" = 1'-0"

5L
00.10

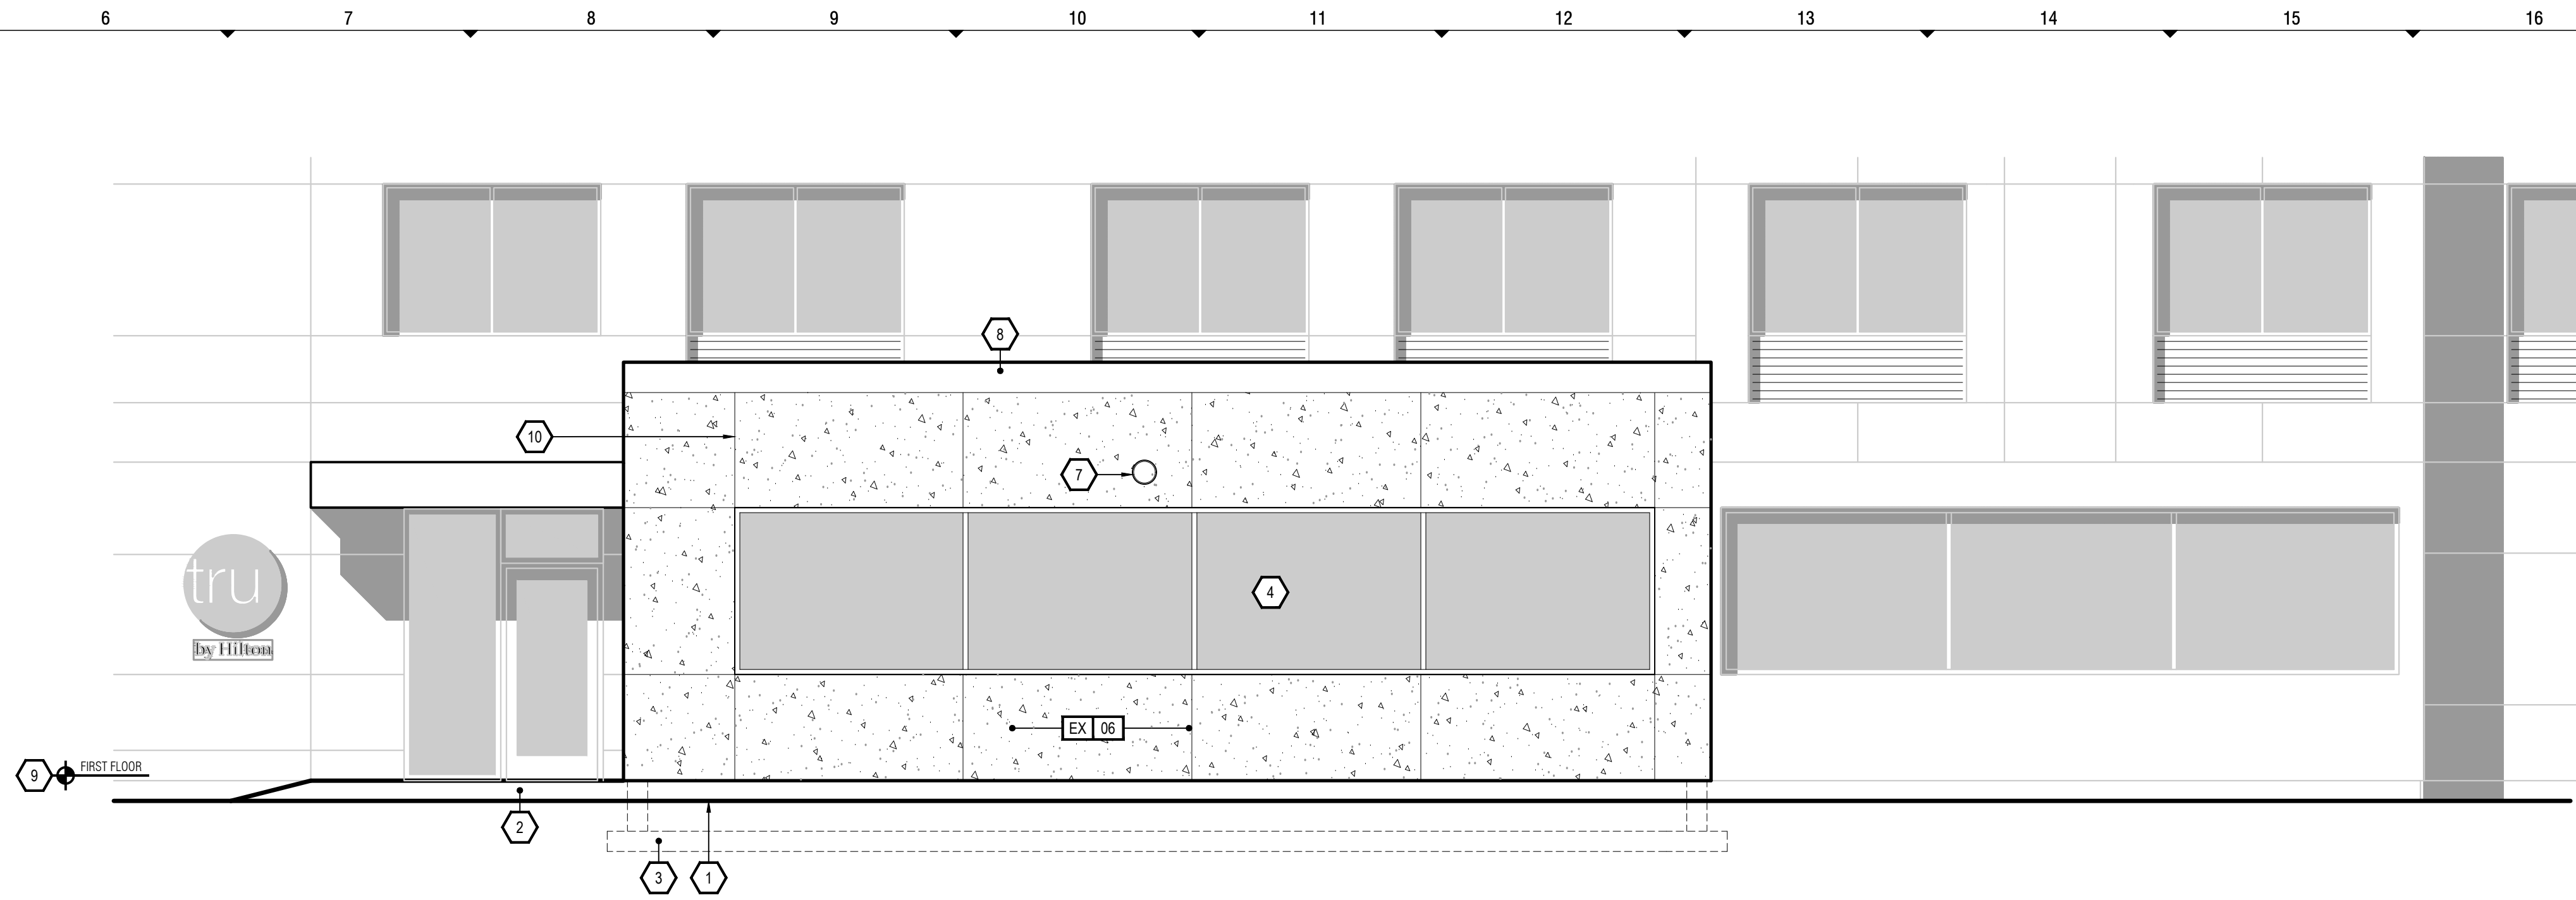


EXTERIOR ELEVATION
1/4" = 1'-0"

16L
00.10

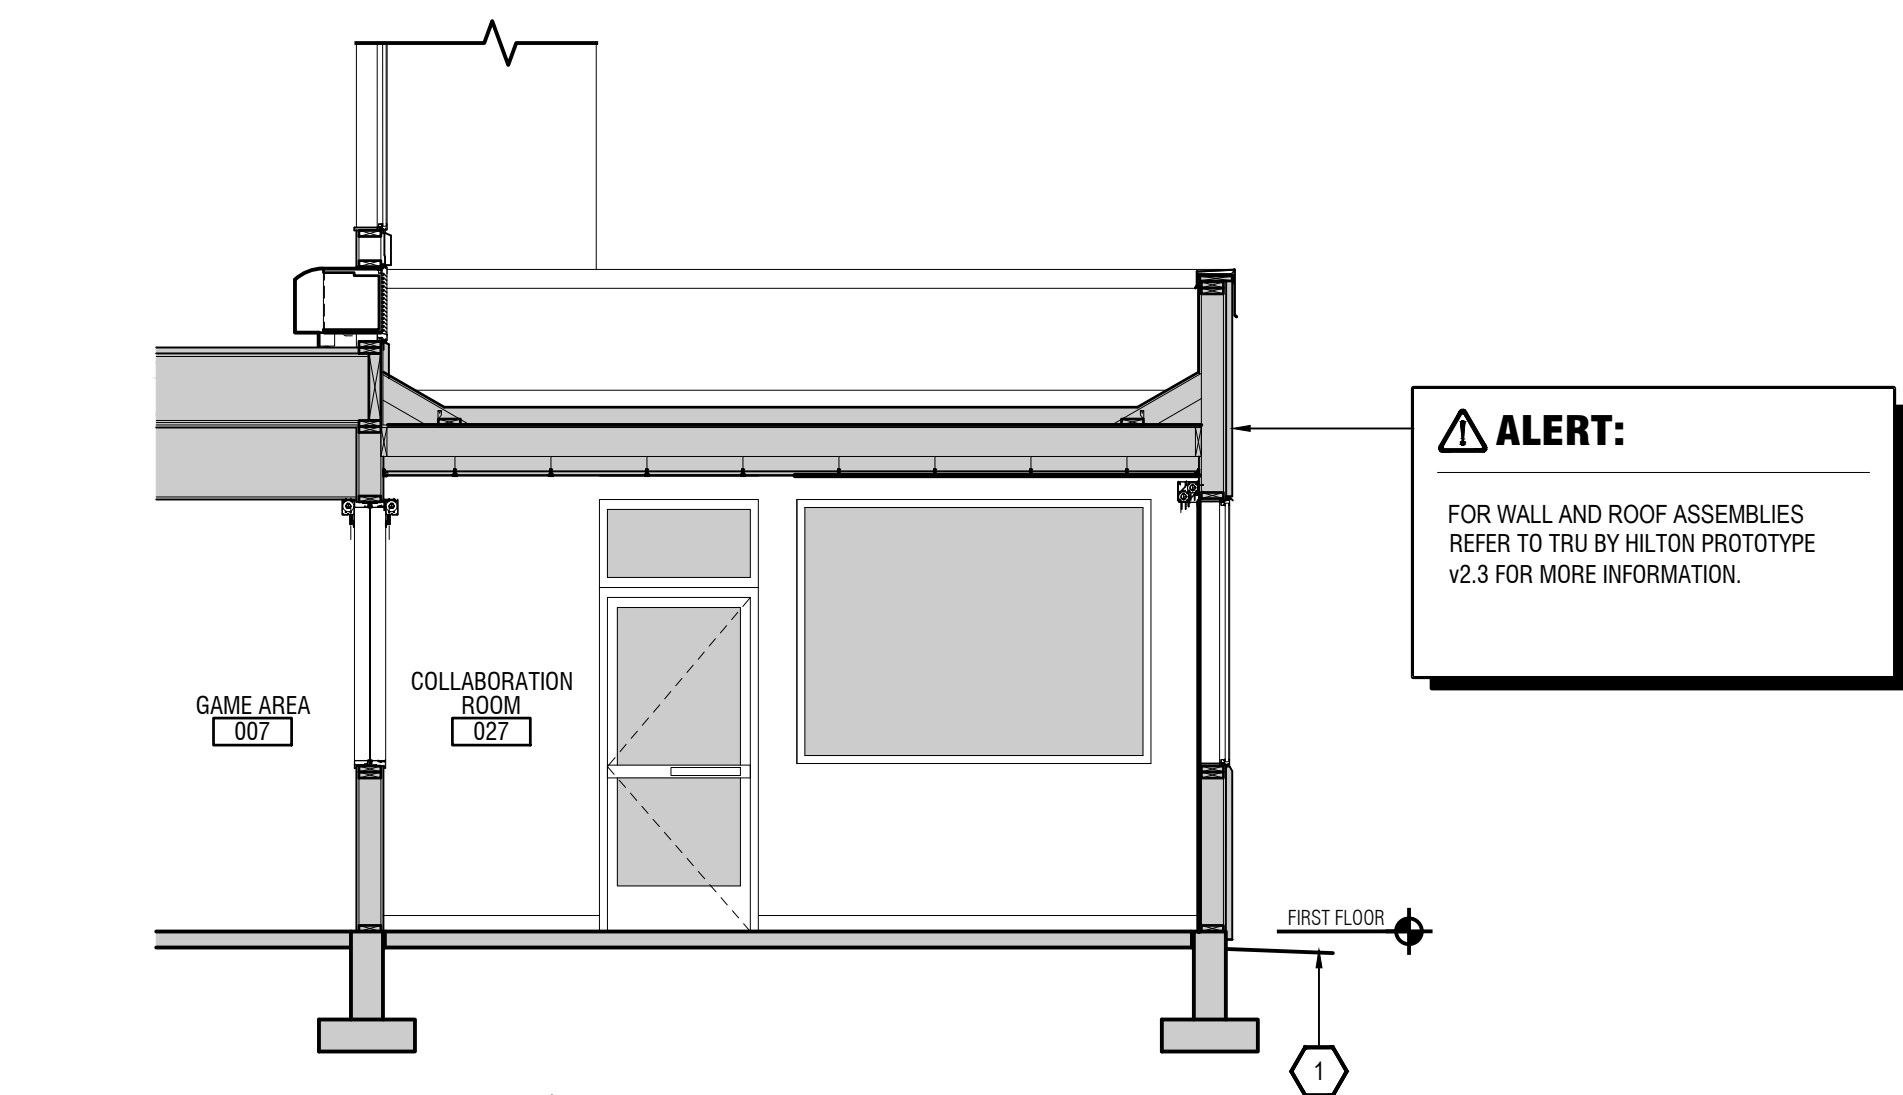


BUILDING SECTION
1/4" = 1'-0"

5G
00.10

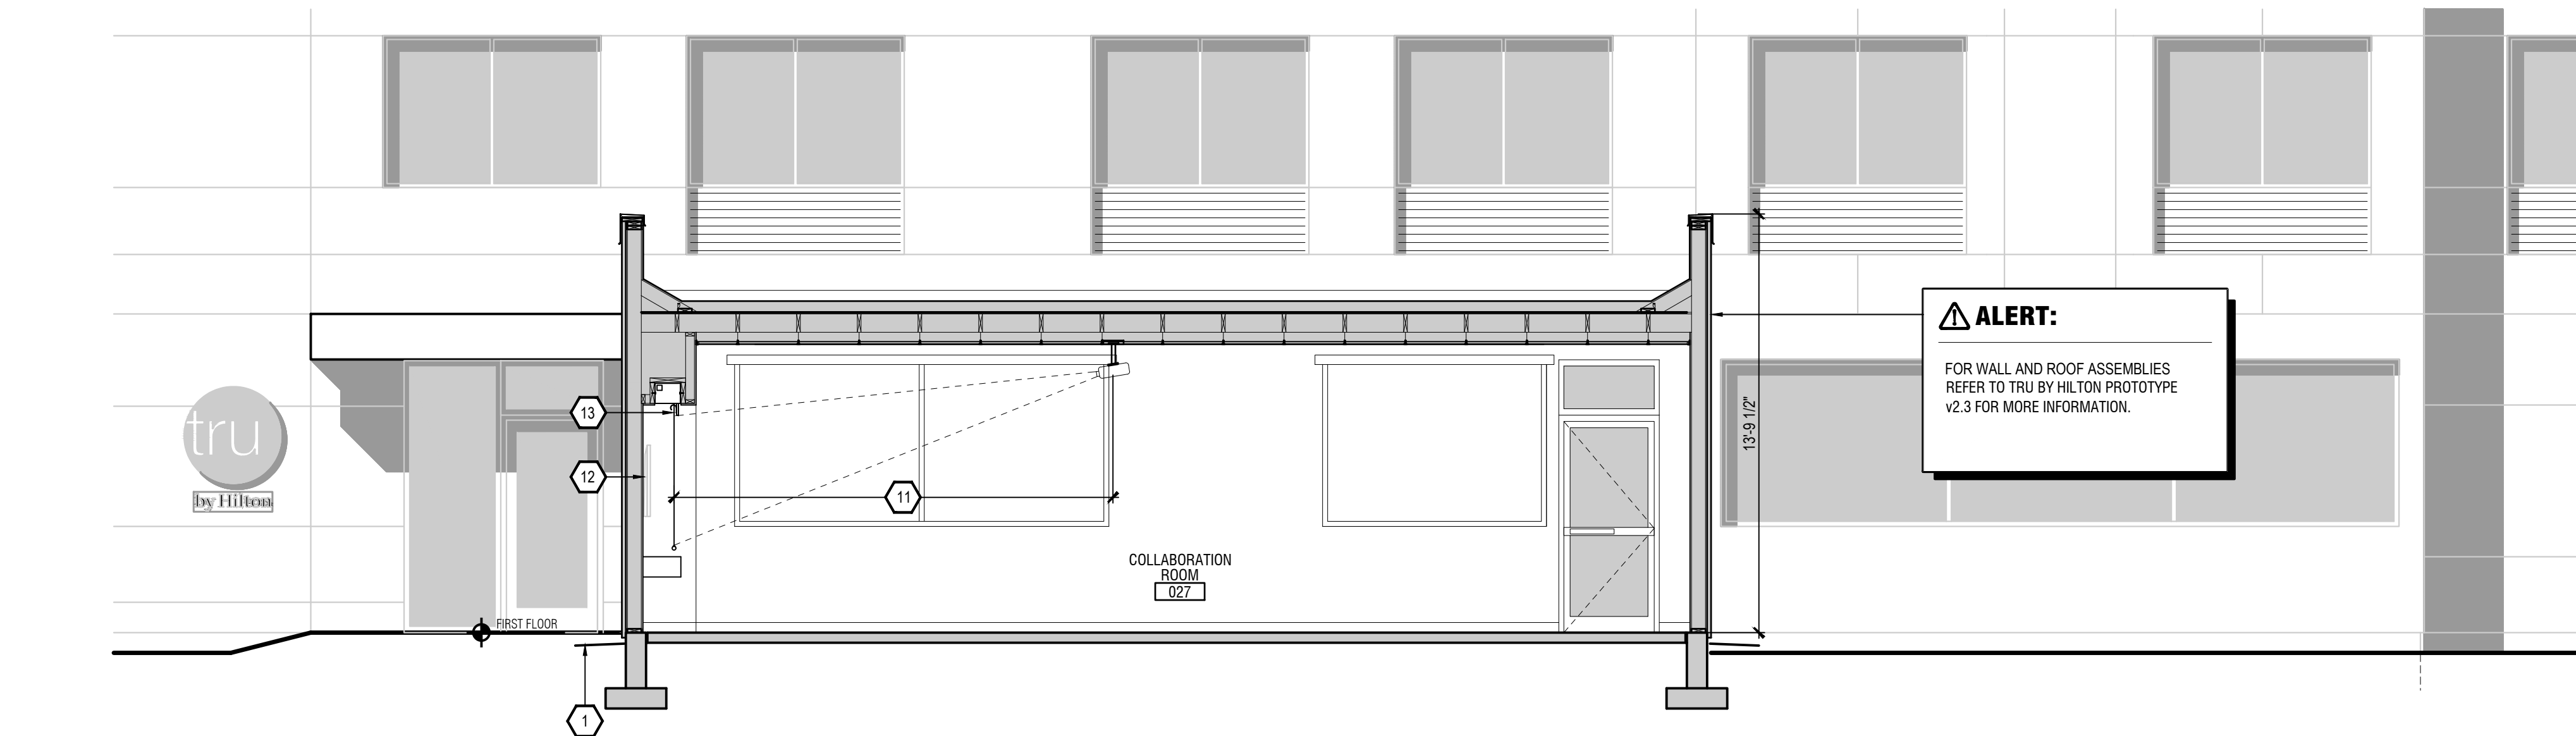

BUILDING SECTION
1/4" = 1'-0"

16G
00.10

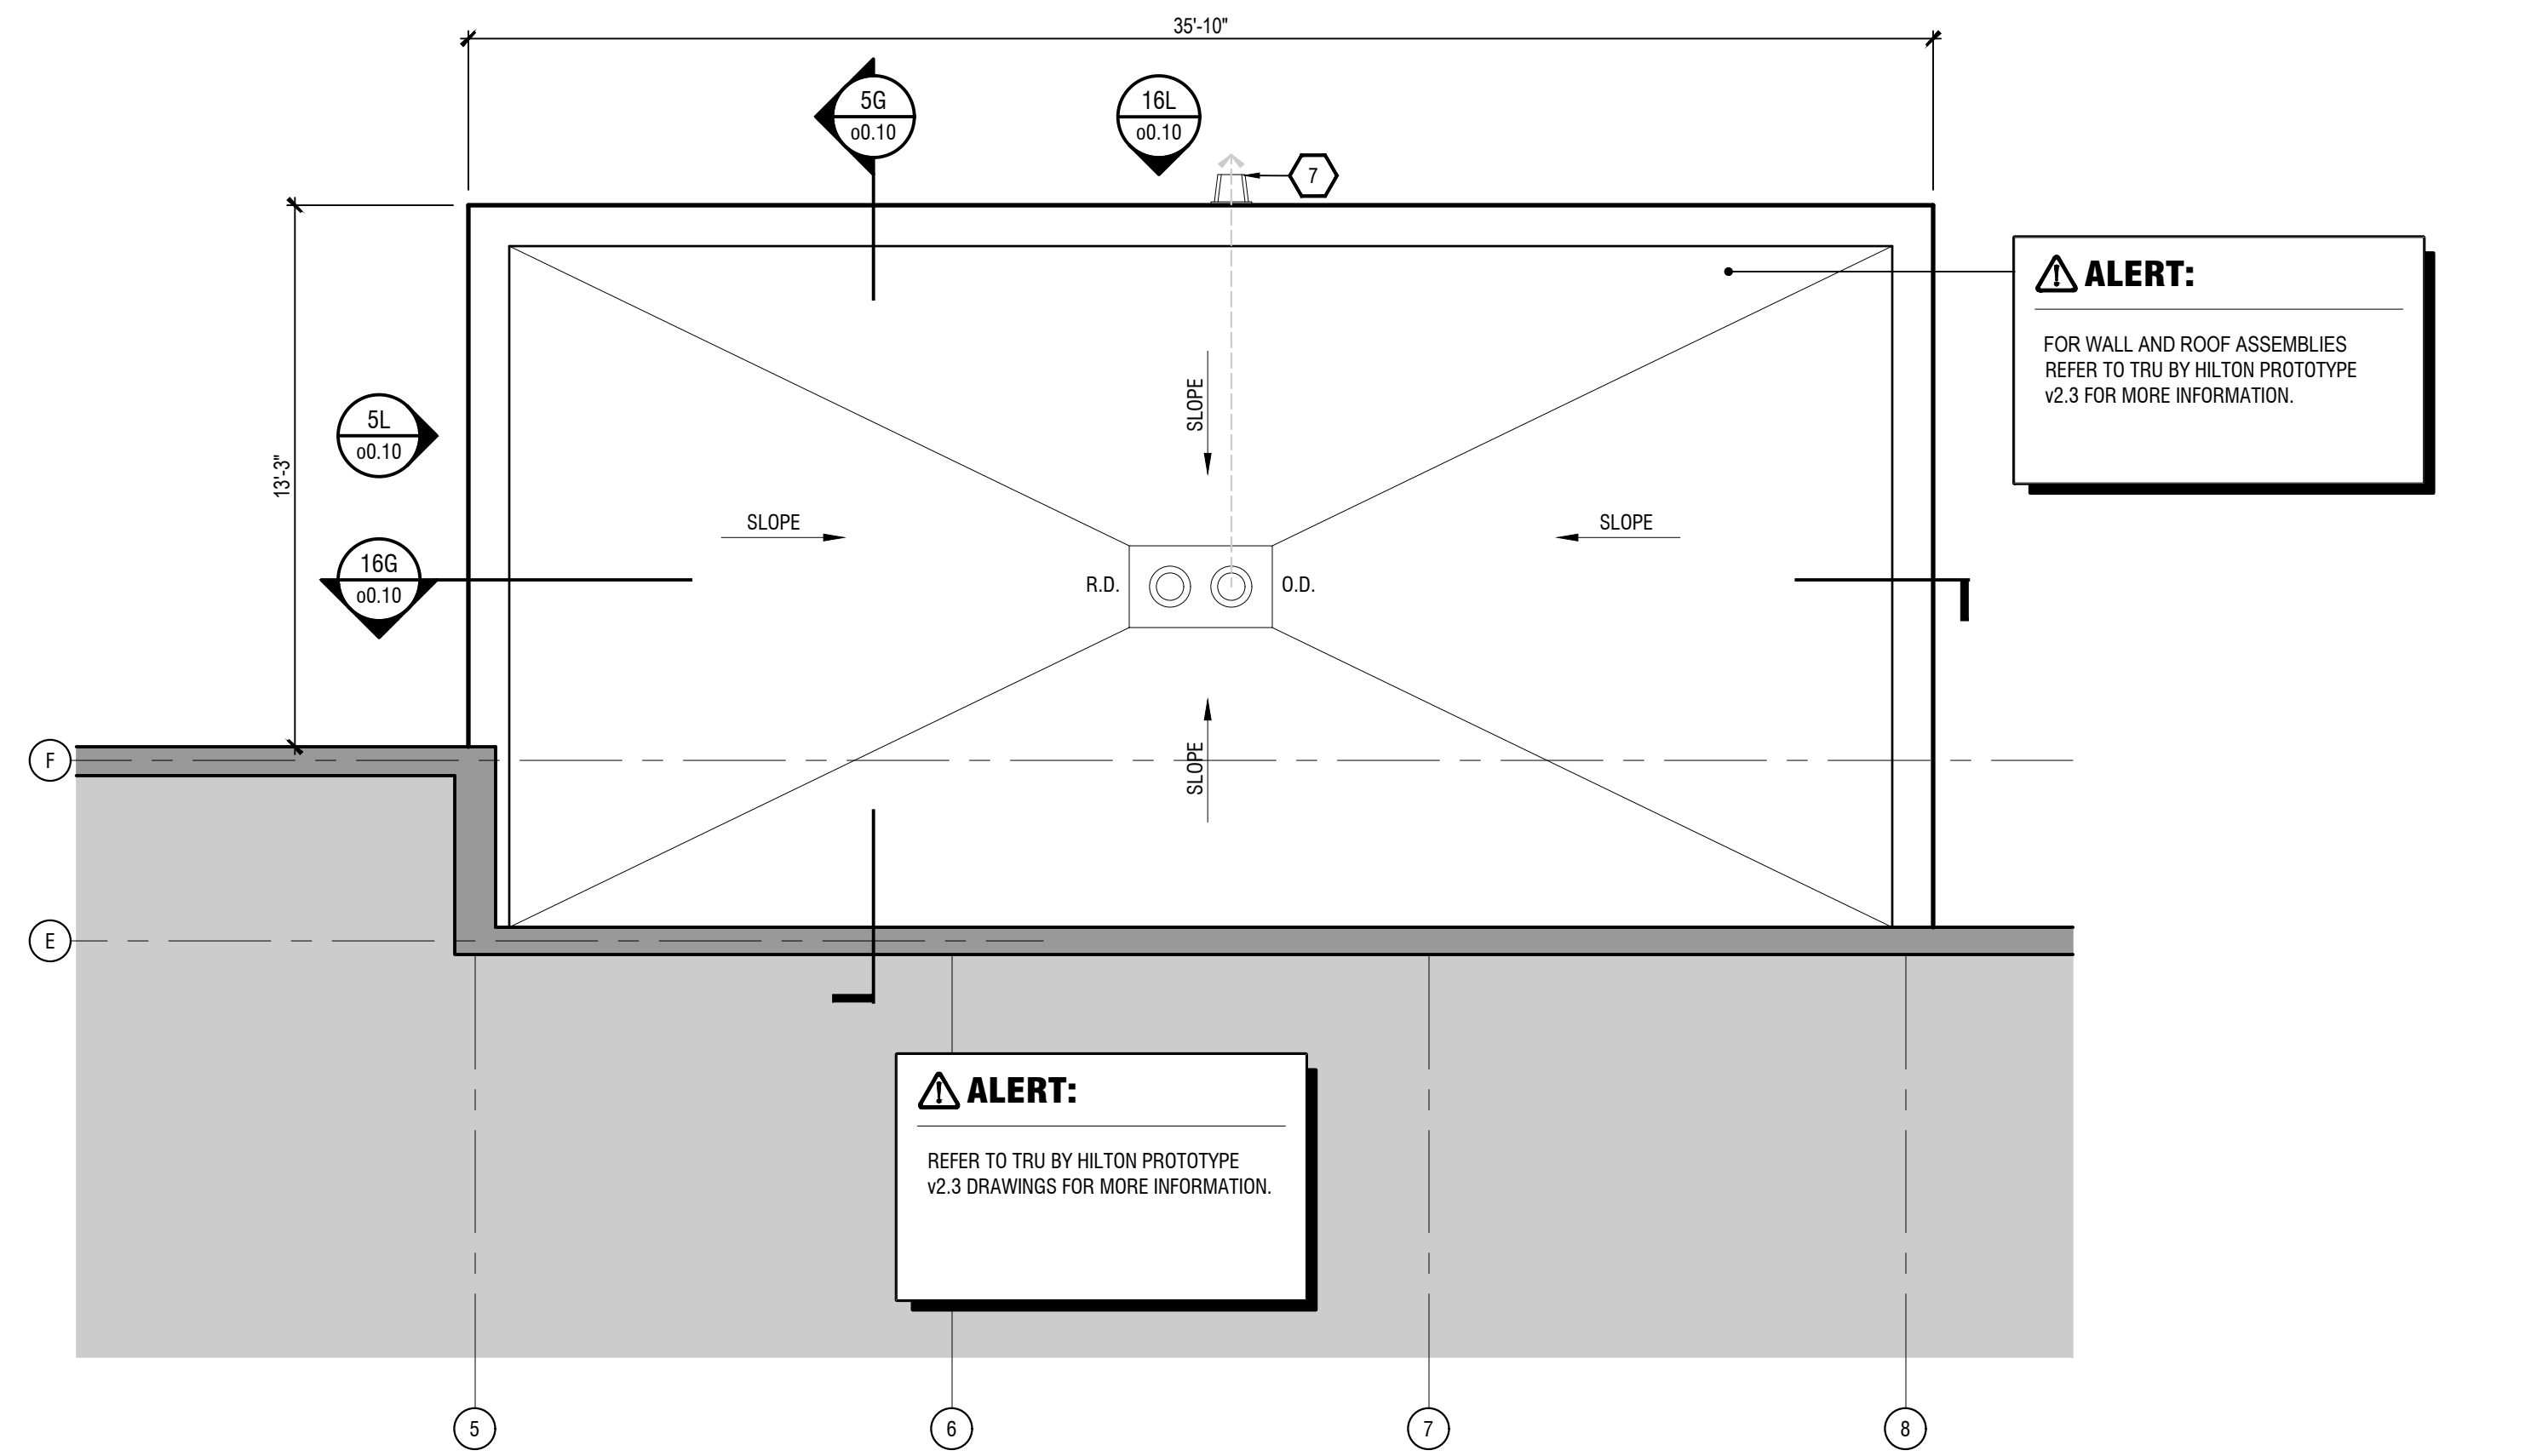

ROOF PLAN
1/4" = 1'-0"

8A
00.10

KEY NOTES:

1. APPROXIMATE LINE OF GRADE - SLOPE GRADE 2% MIN. AWAY FROM BUILDING
2. ABOVE GRADE EXPOSED FOUNDATION WALL
3. CONCRETE FOOTING AND FOUNDATION WALL AS REQUIRED PER LOCAL FROST DEPTHS
4. ALUMINUM FIXED WINDOW W/ THERMAL BROKEN FRAME AND INSULATED GLAZING
5. ALUMINUM STOREFRONT SYSTEM W/ THERMAL BROKEN FRAME AND INSULATED GLAZING
6. NOT USED
7. OVERFLOW SCUPPER
BASIS OF DESIGN NESCO MFG INC. - MODEL # SCT01-4R
8. KYNAR FINISH ALUMINUM COPING/ GRAVEL STOP SYSTEM - COLOR TO MATCH ADJACENT MATERIAL
9. BUILDING HEIGHT DIMENSIONS ARE BASED ON WOOD FRAME CONSTRUCTION
10. ACENT "J" JOINT
11. CEILING MOUNT PROJECTOR WITHIN RECOMMENDED DISTANCE RANGE RELATIVE TO PROJECTOR SCREEN SIZE - VERIFY WITH MODELS AND SIZES WITH OWNER PRIOR TO INSTALLATION
12. WALL MOUNTED TV - REQUIRES IN-WALL BLOCKING - COORDINATE BLOCKING LOCATION WITH MOUNTING HARDWARE - REFER TO MANUFACTURERS RECOMMENDATIONS FOR MOUNTING INSTRUCTIONS
13. RECESSED CEILING MOUNTED PROJECTOR SCREEN - REFER TO MANUFACTURERS RECOMMENDATIONS FOR MOUNTING INSTRUCTIONS

FINISHES & FIXTURES LEGEND:

EIFS CLADDING SYSTEM (EO - BASIS OF DESIGN - "OUTSULATION PLUS MO EIFS" BY DRYVIT SYSTEMS, INC.
PROVIDE EIFS HIGH IMPACT MESH ASSEMBLY FOR LOWER 4'-0" OF WALL AREAS AT GRADE, BASIS OF DESIGN - DRYVIT
"STANDARD" MESH OVER "PANDER 20 OZ." HIGH IMPACT MESH
COORDINATE FOR MINIMUM EXTERIOR CONTINUOUS INSULATION THICKNESS, R-VALUE REQUIREMENTS IN ACCORDANCE WITH ADOPTED ENERGY CODE REQUIREMENTS FOR ALL CLADDING AREAS.

EX-06 EIFS WALL CLADDING F


ALERT:

REFER TO ARCHITECTURAL FINISHES AND FIXTURE SPECIFICATIONS FOR EX - NUMBER
COLOR CODING INFORMATION

GENERAL NOTES:

1. REFER TO HILTON BRAND STANDARDS MANUAL AND STYLE GUIDE FOR ADDITIONAL INFORMATION REGARDING EXTERIOR MATERIALS, CONSTRUCTION REQUIREMENTS AND FINISH REQUIREMENTS
2. BUILDING HEIGHT DIMENSIONS ARE BASED ON WOOD FRAME CONSTRUCTION - THESE DIMENSIONS WILL VARY BASED ON FINAL BUILDING CONSTRUCTION. INTERIOR CEILING HEIGHTS ARE CRITICAL TO MAINTAIN AS MINIMUMS

KEY PLAN:

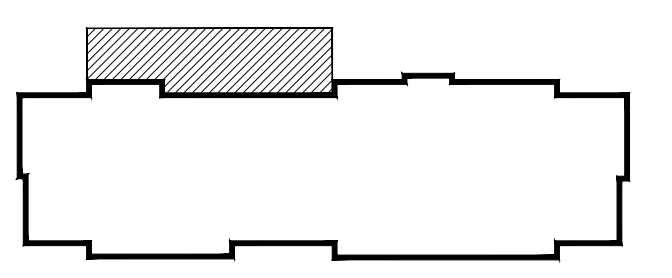

NORTH AMERICAN
PROTOTYPE
VERSION: 2.3

EACH OWNER IS TO VERIFY WITH THE LOCAL CODE ENFORCEMENT AGENCY FOR ACCESSIBILITY OR BARRIER-FREE REQUIREMENTS. THE OWNER OF THE PROJECT CONTROLS THE ULTIMATE DESIGN AND CONSTRUCTION AND IS URGED TO SEEK APPROPRIATE COUNSEL TO ENSURE SUCH COMPLIANCE.

NOTE OF CAUTION: USE OF THESE PLANS AND/OR SPECIFICATIONS SHALL IN NO WAY GIVE RISE TO ANY LIABILITY ON THE PART OF HILTON FOR ANY DEFECT OR DEFICIENCY OF SAID PLANS AND/OR SPECIFICATIONS. ANY PERSON USING THESE PLANS AND/OR SPECIFICATIONS MUST VERIFY THROUGH HIS OWN MEANS, ARCHITECT, ENGINEERS AND OTHER PROFESSIONALS, THEIR COMPLIANCE WITH ANY LAW AND ADEQUACY FOR THE INTENDED PURPOSE, AS HILTON MAKES NO REPRESENTATION WHATSOEVER IN THAT REGARD. THE QUALITY OF WORKMANSHIP, AND THE ADEQUACY AND SUITABILITY OF THE PLANS, SPECIFICATIONS, AND DESIGN DATA FOR A PARTICULAR PROJECT IS THE SOLE RESPONSIBILITY OF THE OWNER.

THIS DRAWING, PRINTED OR OTHERWISE, IS THE COPYRIGHTED PROPERTY OF HILTON. THE DRAWINGS MAY NOT BE USED, REPRODUCED OR COPIED WITHOUT THE PERMISSION OF HILTON.

IT IS THE RESPONSIBILITY OF THE FRANCHISEE AND THEIR CONSULTANTS TO COORDINATE ALL ADDENDA ITEMS ISSUED BY HILTON INTO THEIR RECORD SET OF CONSTRUCTION DOCUMENTS. ADDENDA ARE AVAILABLE ADJACENT TO THE PROTOTYPE DRAWINGS ON THE WWW.DESIGNINFORMATION.HILTON.COM WEBSITE.

HILTON DOES NOT MAKE ANY REPRESENTATION OR WARRANTY AS TO, NOR SHALL IT BE RESPONSIBLE FOR ANY OMISSIONS ON THE PART OF THE FRANCHISEE OR THEIR CONSULTANTS. OMISSIONS BY THE FRANCHISEE OR THEIR CONSULTANTS DOES NOT CONSTITUTE A WAIVER AND DOES NOT RELEASE THE FRANCHISEE FROM ANY RESPONSIBILITY TO CONFORM TO THE CRITERIA DEFINED IN THE BRAND'S PROTOTYPE REQUIREMENTS. ASSOCIATED ADDENDA AND/OR DESIGN AND CONSTRUCTION STANDARDS.

REVISIONS

NO.	DESCRIPTION	DATE

PROJECT INFORMATION

Prototype
Package

April 2025

SHEET INFORMATION

Optional Collaboration
Room Details

00.10

EACH OWNER IS TO VERIFY WITH THE LOCAL CO-ENFORCEMENT AGENCY FOR ACCESSIBILITY OR BARRIER-FREE REQUIREMENTS. THE OWNER OF THE PROJECT CONTROLS THE ULTIMATE DESIGN AND CONSTRUCTION AND IS URGED TO SEEK APPROPRIATE COUNSEL TO ENSURE SUCH COMPLIANCE.

NOTE OF CAUTION: USE OF THESE PLANS AND/OR SPECIFICATIONS SHALL IN NO WAY GIVE RISE TO ANY LIABILITY ON THE PART OF HILTON FOR ANY DEFECT OR DEFICIENCY OF SAID PLANS AND/OR SPECIFICATIONS. ANY PERSON USING THESE PLANS AND/OR SPECIFICATIONS MUST VERIFY THROUGH HIS OWN MEANS, ARCHITECT, ENGINEERS AND OTHER PROFESSIONALS, THEIR COMPLIANCE WITH ANY LAW AND ADEQUACY FOR THE INTENDED PURPOSE, AS HILTON MAKES NO REPRESENTATION WHATSOEVER IN THAT REGARD. THE QUALITY OF WORKMANSHIP, AND THE ADEQUACY AND SUITABILITY OF THE PLANS, SPECIFICATIONS, AND DESIGN DATA FOR A PARTICULAR PROJECT IS THE SOLE

THIS DRAWING, PRINTED OR OTHERWISE, IS THE
COPYRIGHTED PROPERTY OF HILTON. THE
DRAWINGS MAY NOT BE USED, REPRODUCED OR
COPIED WITHOUT THE PERMISSION OF HILTON.

IT IS THE RESPONSIBILITY OF THE FRANCHISEE AND THEIR CONSULTANTS TO COORDINATE ALL ADDENDA ITEMS ISSUED BY HILTON INTO THEIR RECORD SET OF CONSTRUCTION DOCUMENTS. ADDENDA ARE AVAILABLE ADJACENT TO THE PROTOTYPE DRAWINGS ON THE WWW.DESIGNINFORMATION.HILTON.COM WEBSITE

HILTON DOES NOT MAKE ANY REPRESENTATION OR WARRANTY AS TO, NOR SHALL IT BE RESPONSIBLE FOR ANY OMISSIONS ON THE PART OF THE FRANCHISEE OR THEIR CONSULTANTS. OMISSIONS BY THE FRANCHISEE OR THEIR CONSULTANTS DOES NOT CONSTITUTE A WAIVER AND DOES NOT RELEASE THE FRANCHISEE FROM ANY RESPONSIBILITY TO CONFORM TO THE CRITERIA DEFINED IN THE BRAND'S PROTOTYPE REQUIREMENTS, ASSOCIATED ADDENDA AND/OR DESIGN AND CONSTRUCTION STANDARDS.

REVISIONS

[illegible]

PROJECT INFORMATION

Prototype Package

April 2025

SHEET INFORMATION

Optional Collaboration Room Millwork

o0.11



COLLABORATION ROOM LEDGE

16G
ø0.11



COLLABORATION ROOM LEDGE

16D
ø0.11




COLLABORATION ROOM LEDGE

16A
p0.11



COLLABORATION ROOM LEDGE

8A
p0.11

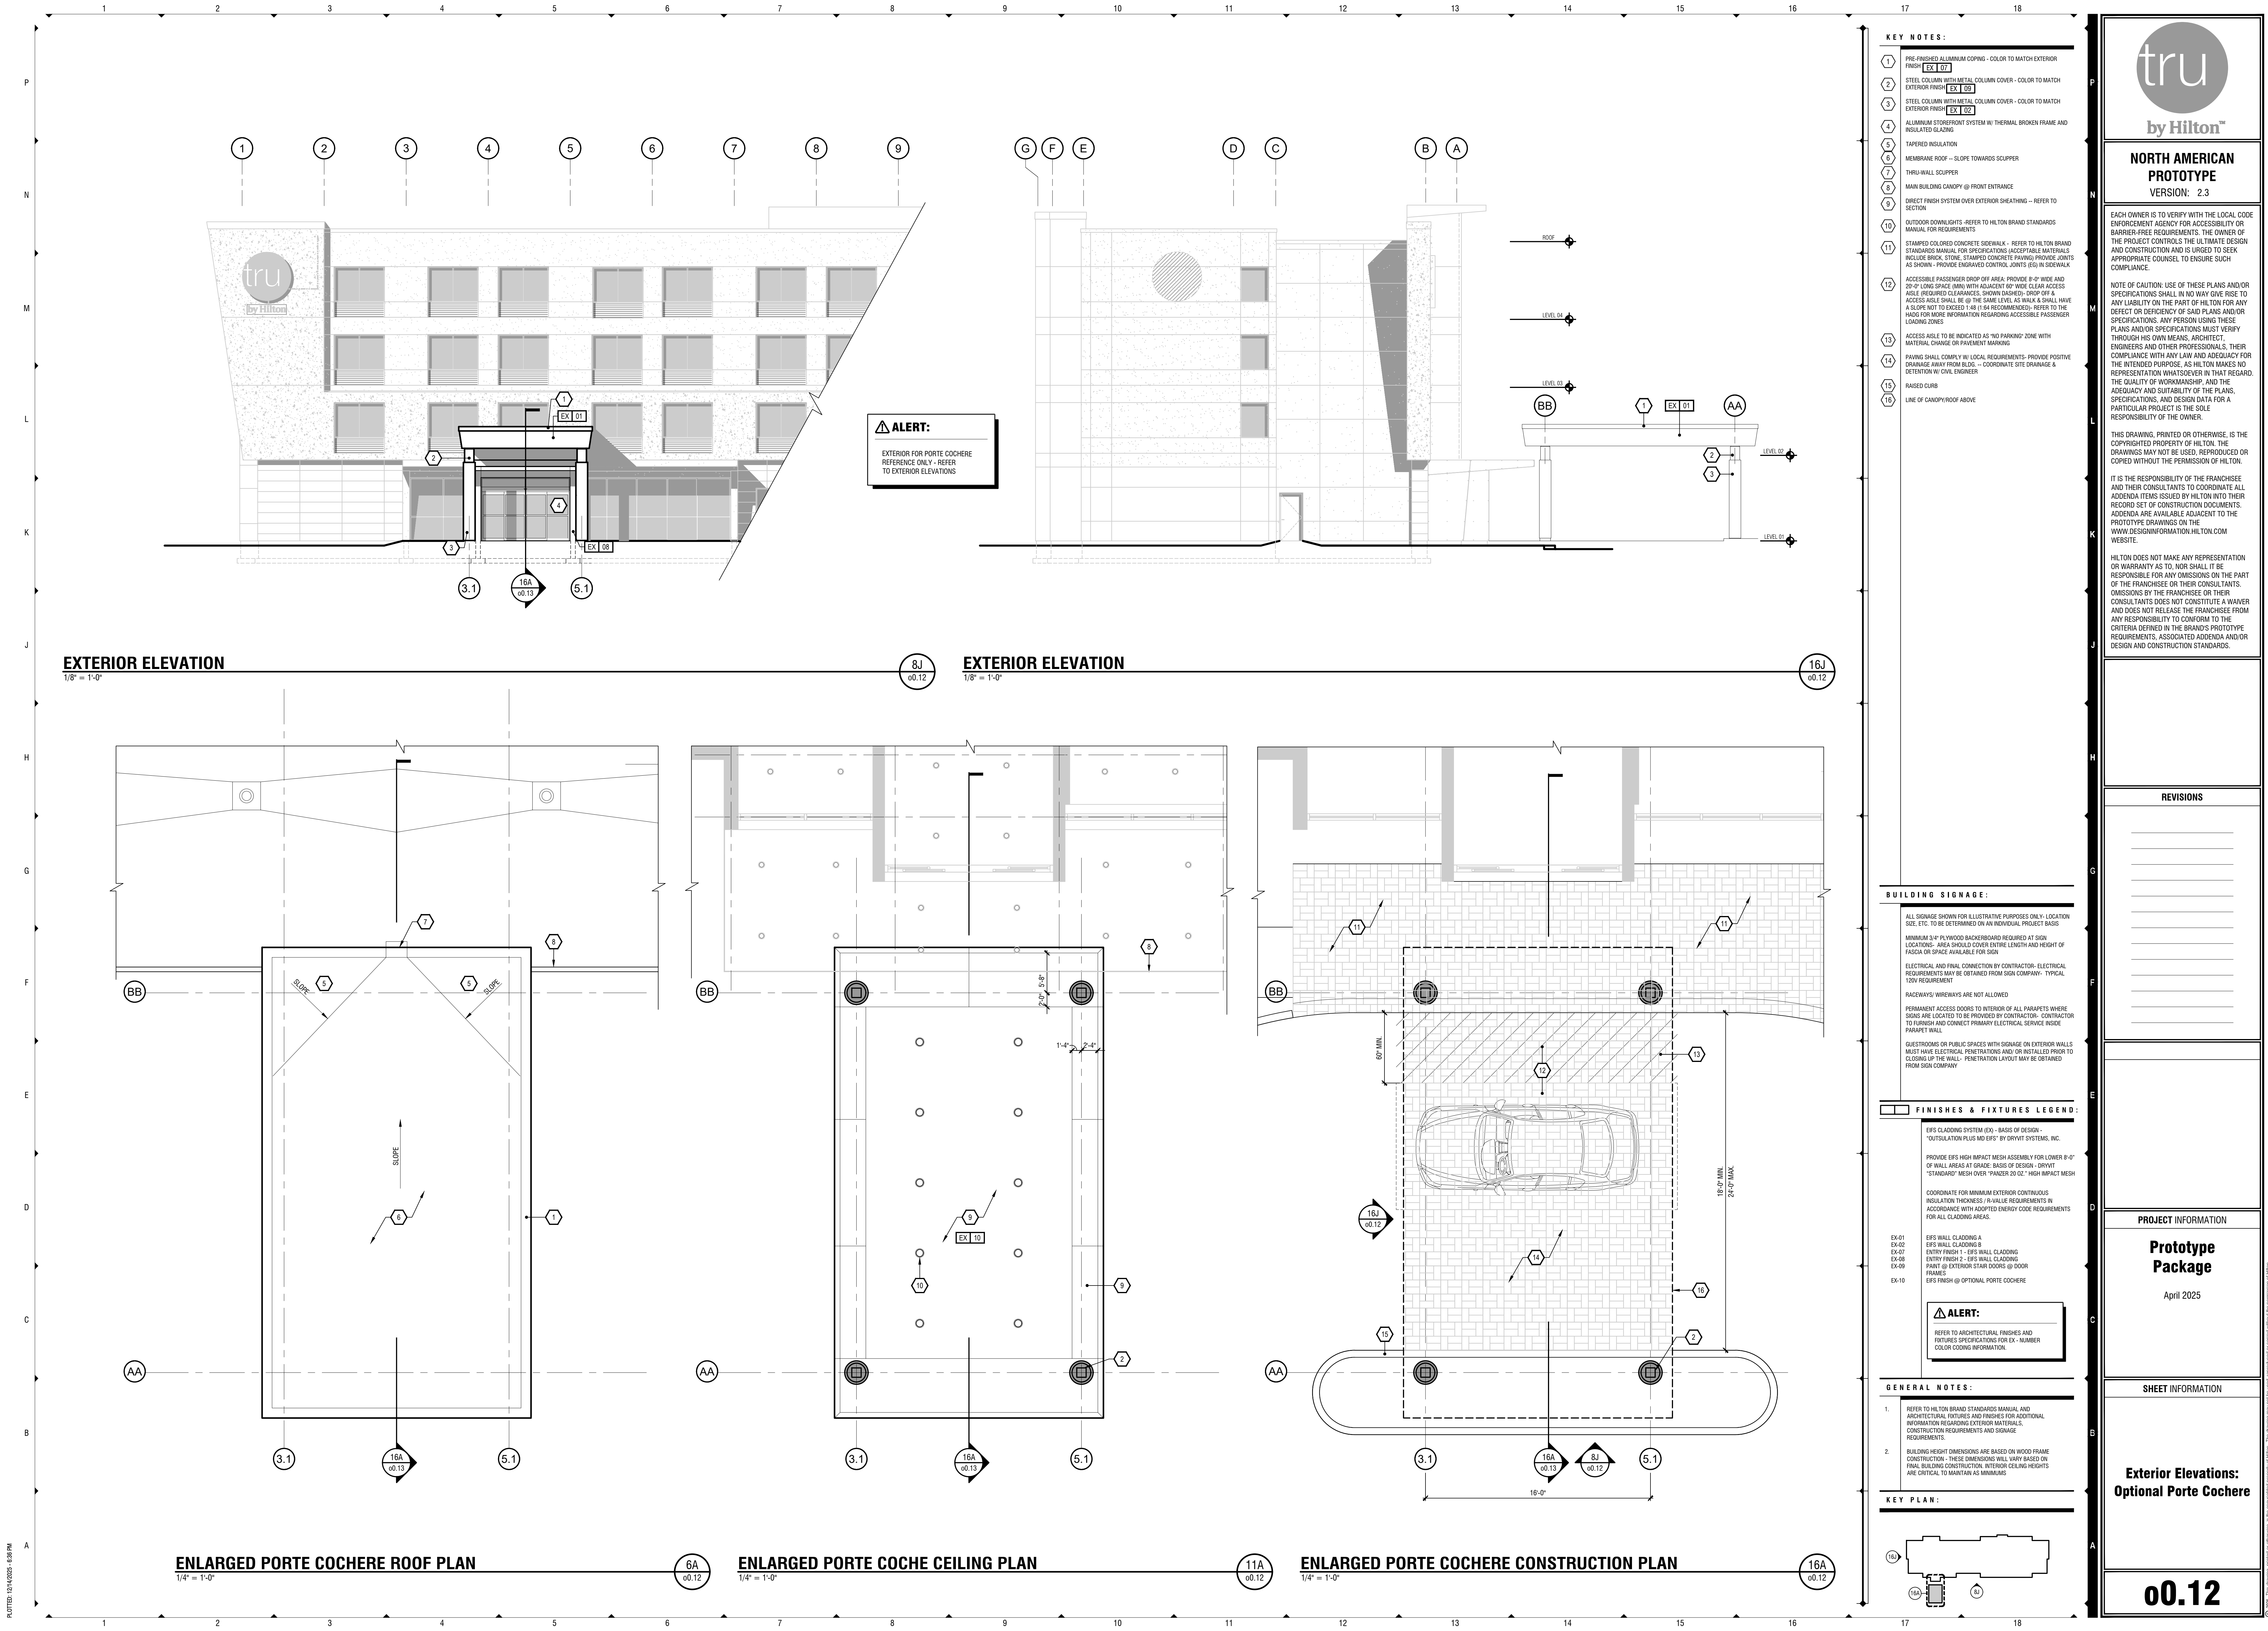

tru

by Hilton™

NORTH AMERICAN

PROTOTYPE

VERSION: 2.3

EACH OWNER IS TO VERIFY WITH THE LOCAL CODE ENFORCEMENT AGENCY FOR ACCESSIBILITY OR BARRIER-FREE REQUIREMENTS. THE OWNER OF THE PROJECT CONTROLS THE ULTIMATE DESIGN AND CONSTRUCTION AND IS URGED TO SEEK APPROPRIATE COUNSEL TO ENSURE SUCH COMPLIANCE.

NOTE OF CAUTION: USE OF THESE PLANS AND/OR SPECIFICATIONS SHALL IN NO WAY GIVE RISE TO ANY LIABILITY ON THE PART OF HILTON FOR ANY DEFECT OR DEFICIENCY OF SAID PLANS AND/OR SPECIFICATIONS. ANY PERSON USING THESE PLANS AND/OR SPECIFICATIONS MUST VERIFY THROUGH HIS OWN MEANS, ARCHITECT, ENGINEERS AND OTHER PROFESSIONALS, THEIR COMPLIANCE WITH ANY LAW AND ADEQUACY FOR THE INTENDED PURPOSE, AS HILTON MAKES NO REPRESENTATION WHATSOEVER IN THAT REGARD. THE QUALITY OF WORKMANSHIP, AND THE ADEQUACY AND SUITABILITY OF THE PLANS, SPECIFICATIONS, AND DESIGN DATA FOR A PARTICULAR PROJECT IS THE SOLE RESPONSIBILITY OF THE OWNER.

THIS DRAWING, PRINTED OR OTHERWISE, IS THE COPYRIGHTED PROPERTY OF HILTON. THE DRAWINGS MAY NOT BE USED, REPRODUCED OR COPIED WITHOUT THE PERMISSION OF HILTON.

IT IS THE RESPONSIBILITY OF THE FRANCHISEE AND THEIR CONSULTANTS TO COORDINATE ALL ADDENDA ITEMS ISSUED BY HILTON INTO THEIR RECORD SET OF CONSTRUCTION DOCUMENTS. ADDENDA ARE AVAILABLE ADJACENT TO THE PROTOTYPE DRAWINGS ON THE WWW.DESIGNINFORMATION.HILTON.COM WEBSITE.

HILTON DOES NOT MAKE ANY REPRESENTATION OR WARRANTY AS TO, NOR SHALL IT BE RESPONSIBLE FOR ANY OMISSIONS ON THE PART OF THE FRANCHISEE OR THEIR CONSULTANTS. OMISSIONS BY THE FRANCHISEE OR THEIR CONSULTANTS DOES NOT CONSTITUTE A WAIVER AND DOES NOT RELEASE THE FRANCHISEE FROM ANY RESPONSIBILITY TO CONFORM TO THE CRITERIA DEFINED IN THE BRAND'S PROTOTYPE REQUIREMENTS. ASSOCIATED ADDENDA AND/OR DESIGN AND CONSTRUCTION STANDARDS.

REVISIONS

PROJECT INFORMATION

Prototype Package

April 2025

SHEET INFORMATION

Exterior Elevations:

Optional Porte Cochere

00.12

KEY NOTES:

- PRE-FINISHED ALUMINUM COPING - COLOR TO MATCH EXTERIOR FINISH [EX 07]
- STEEL COLUMN WITH METAL COLUMN COVER - COLOR TO MATCH EXTERIOR FINISH [EX 08]
- STEEL COLUMN WITH METAL COLUMN COVER - COLOR TO MATCH EXTERIOR FINISH [EX 09]
- ALUMINUM STOREFRONT SYSTEM W/ THERMAL BROKEN FRAME AND INSULATED GLAZING
- TAPERED INSULATION
- MEMBRANE ROOF - SLOPE TOWARDS SCUPPER
- THRU-WALL SCUPPER
- MAIN BUILDING CANOPY @ FRONT ENTRANCE
- DIRECT FINISH SYSTEM OVER EXTERIOR SHEATHING - REFER TO SECTION
- OUTDOOR DOWNLIGHTS-REFER TO HILTON BRAND STANDARDS MANUAL FOR REQUIREMENTS
- STAMPED COLORED CONCRETE SIDEWALK - REFER TO HILTON BRAND STANDARDS MANUAL FOR SPECIFICATIONS; ACCEPTABLE MATERIALS INCLUDE BRICK, STONE, STAMPED CONCRETE PAVING; PROVIDE JOINTS AS SHOWN - PROVIDE ENGRAVED CONTROL JOINTS (CJ) IN SIDEWALK
- ACCESSIBLE PASSENGER DROP OFF AREA: PROVIDE 8'-0" WIDE AND 20'-0" LONG SPACE (MIN) WITH ADJACENT 60" WIDE CLEAR ACCESSIBLE REQUIRED CLEARANCES, SHOWN DASHED- DROP OFF & ACCESSIBLE SHALL BE @ THE SAME LEVEL AS WALK & SHALL HAVE A SLOPE NOT TO EXCEED 1:40 (1/4% RECOMMENDED); REFER TO THE HSDI FOR MORE INFORMATION REGARDING ACCESSIBLE PASSENGER LOADING ZONES
- ACCESSIBLE TO BE INDICATED AS "NO PARKING" ZONE WITH MATERIAL CHANGE OR PAVEMENT MARKING
- PAVING SHALL COMPLY W/ LOCAL REQUIREMENTS; PROVIDE POSITIVE DRAINAGE AWAY FROM BLDG - COORDINATE SITE DRAINAGE & DETENTION W/ CIVIL ENGINEER
- RAISED CURB
- LINE OF CANOPY/ROOF ABOVE

BUILDING SIGNAGE:

ALL SIGNAGE SHOWN FOR ILLUSTRATIVE PURPOSES ONLY. LOCATION, SIZE, ETC. TO BE DETERMINED ON AN INDIVIDUAL PROJECT BASIS.

MINIMUM 3/4" PLYWOOD BACKERBOARD REQUIRED AT SIGN LOCATION- AREA SHOULD COVER ENTIRE LENGTH AND HEIGHT OF FACE OR SPACE AVAILABLE FOR SIGN.

ELECTRICAL AND FINAL CONNECTION BY CONTRACTOR- ELECTRICAL REQUIREMENTS MAY BE OBTAINED FROM SIGN COMPANY- TYPICAL 120V REQUIREMENT.

RACEWAYS/ WIREWAYS ARE NOT ALLOWED.

PERMANENT ACCESS DOORS TO INTERIOR OF ALL PARAPETS WHERE SIGNS ARE LOCATED TO BE PROVIDED BY CONTRACTOR- CONTRACTOR TO FURNISH AND CONNECT PRIMARY ELECTRICAL SERVICE INSIDE PARAPET WALL.

QUESTROOMS OR PUBLIC SPACES WITH SIGNAGE ON EXTERIOR WALLS MUST HAVE ELECTRICAL PENETRATIONS AND/OR INSTALLED PRIOR TO CLOSING UP THE WALL- PENETRATION LAYOUT MAY BE OBTAINED FROM SIGN COMPANY.

FINISHES & FIXTURES LEGEND:

EX-01	EPS CLADDING SYSTEM (EX - BASIS OF DESIGN - "OUTSULATION PLUS MD EPS" BY DRYVIT SYSTEMS, INC.
EX-02	PROVIDE EPS HIGH IMPACT MESH ASSEMBLY FOR LOWER 8'-0" OF WALL AREAS AT GRADE: BASIS OF DESIGN - DRYVIT "STANDARD" MESH OVER "PFAZER 20 GZ" HIGH IMPACT MESH
EX-03	COORDINATE FOR MINIMUM EXTERIOR CONTINUOUS INSULATION THICKNESS (R-VALUE REQUIREMENTS R) ACCORDANCE WITH ADOPTED ENERGY CODE REQUIREMENTS FOR ALL CLADDING AREAS.
EX-04	EPS WALL CLADDING A
EX-05	EPS WALL CLADDING B
EX-06	ENTRY FRESH - EPS WALL CLADDING
EX-07	PAINT @ EXTERIOR STAIR DOORS @ DOOR
EX-08	FRAMES
EX-09	EPS FINISH @ OPTIONAL PORTE COCHERE
EX-10	


ALERT:

REFER TO ARCHITECTURAL FINISHES AND FIXTURES SPECIFICATIONS FOR EX - NUMBER COLOR CODING INFORMATION.

GENERAL NOTES:

- REFER TO HILTON BRAND STANDARDS MANUAL AND ARCHITECTURAL NOTES AND FINISHES FOR ADDITIONAL INFORMATION REGARDING EXTERIOR MATERIALS, CONSTRUCTION REQUIREMENTS AND SIGNAGE REQUIREMENTS.
- BUILDING HEIGHT DIMENSIONS ARE BASED ON WOOD FRAME CONSTRUCTION - THESE DIMENSIONS WILL VARY BASED ON FRAM BUILDING CONSTRUCTION. INTERIOR CEILING HEIGHTS ARE CRITICAL TO MAINTAIN AS MINIMUMS.


KEY PLAN:

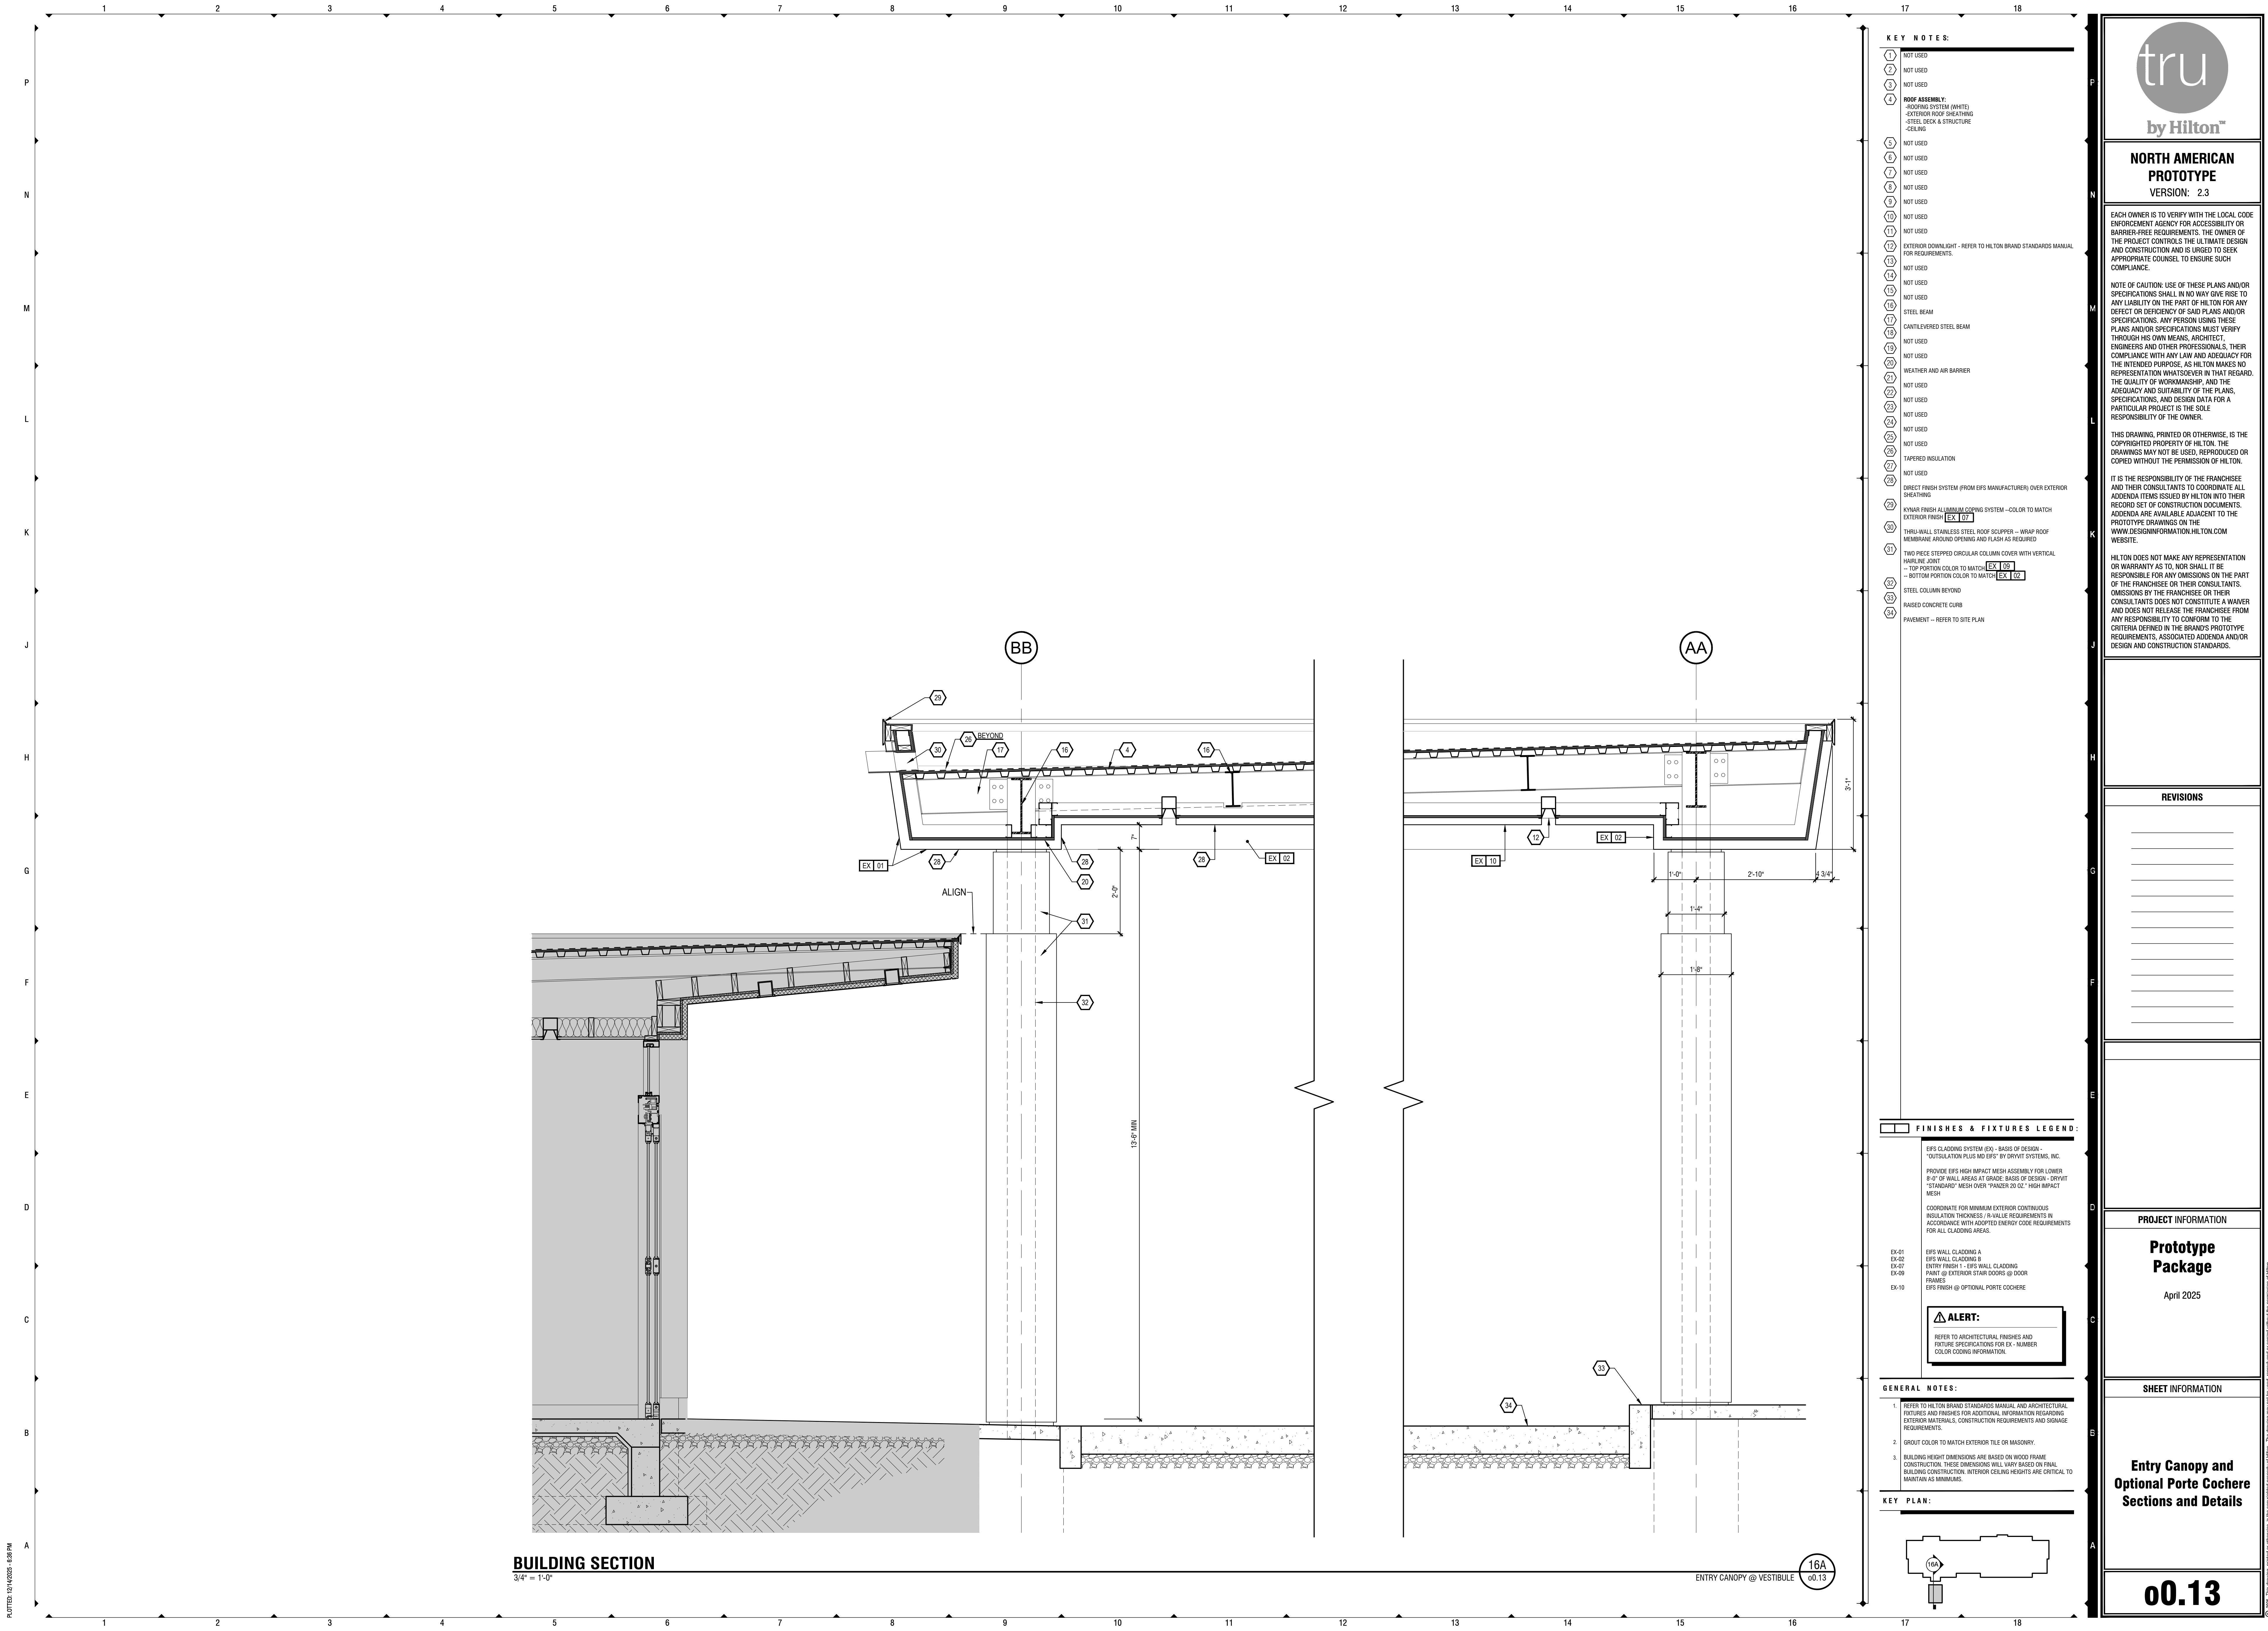

- KEY NOTES:**
- NOT USED
 - NOT USED
 - NOT USED
 - ROOF ASSEMBLY:
 - ROOFING SYSTEM (WHITE)
 - EXTERIOR ROOF SHEETING
 - STEEL JOCK & STRUCTURE
 - CEILING
 - NOT USED
 - NOT USED
 - NOT USED
 - NOT USED
 - NOT USED
 - NOT USED
 - NOT USED
 - EXTERIOR DOWNLIGHT - REFER TO HILTON BRAND STANDARDS MANUAL FOR REQUIREMENTS.
 - NOT USED
 - NOT USED
 - STEEL BEAM
 - CANTILEVERED STEEL BEAM
 - NOT USED
 - NOT USED
 - WEATHER AND AIR BARRIER
 - NOT USED
 - NOT USED
 - NOT USED
 - NOT USED
 - TAPERED INSULATION
 - NOT USED
 - DIRECT FINISH SYSTEM (FROM EPS MANUFACTURER) OVER EXTERIOR SHEETING
 - KYNAR FINISH ALUMINUM CORING SYSTEM -COLOR TO MATCH EXTERIOR FINISH EX 07
 - THRU-WALL STAINLESS STEEL ROOF SCUPPER - WRAP ROOF MEMBRANE AROUND OPENING AND FLASH AS REQUIRED
 - TWO PIECE STEPPED CIRCULAR COLUMN COVER WITH VERTICAL HARKLINE JOINT
 - TOP PORTION COLOR TO MATCH EX 09
 - BOTTOM PORTION COLOR TO MATCH EX 10
 - STEEL COLUMN BEYOND
 - RAISED CONCRETE CURB
 - PAVEMENT - REFER TO SITE PLAN

- FINISHES & FIXTURES LEGEND:**
- EPS CLADDING SYSTEM (C9 - BASIS OF DESIGN "OUTSULATION PLUS MD EPS" BY DRYVIT SYSTEMS, INC. PROVIDE EPS HIGH IMPACT MESH ASSEMBLY FOR LOWER 8'-0" OF WALL AREAS AT GRADE. BASIS OF DESIGN - DRYVIT "STANDARD" MESH OVER "VALKEN 20 02" HIGH IMPACT MESH
- COORDINATE FOR MINIMUM EXTERIOR CONTINUOUS INSULATION THICKNESS - R-VALUE REQUIREMENTS IN ACCORDANCE WITH ADOPTED ENERGY CODE REQUIREMENTS FOR ALL CLADDING AREAS.
- EX-01 EPS WALL CLADDING A
EX-02 EPS WALL CLADDING B
EX-07 ENTRY FINISH - EPS WALL CLADDING
EX-09 PAINT @ EXTERIOR STAIR DOORS @ DOOR FRAMES
EX-10 EPS FINISH @ OPTIONAL PORTE COCHERE
- ALERT:**
- REFER TO ARCHITECTURAL FINISHES AND FIXTURE SPECIFICATIONS FOR EX - NUMBER COLOR CODING INFORMATION.

- GENERAL NOTES:**
- REFER TO HILTON BRAND STANDARDS MANUAL AND ARCHITECTURAL FIXTURES AND FINISHES FOR ADDITIONAL INFORMATION REGARDING EXTERIOR MATERIALS, CONSTRUCTION REQUIREMENTS AND SIGNAGE REQUIREMENTS.
 - GROUT COLOR TO MATCH EXTERIOR TILE OR MASONRY.
 - BUILDING HEIGHT DIMENSIONS ARE BASED ON WOOD FRAME CONSTRUCTION. THESE DIMENSIONS WILL VARY BASED ON FINAL BUILDING CONSTRUCTION. INTERIOR CEILING HEIGHTS ARE CRITICAL TO MAINTAIN AS MINIMUMS.

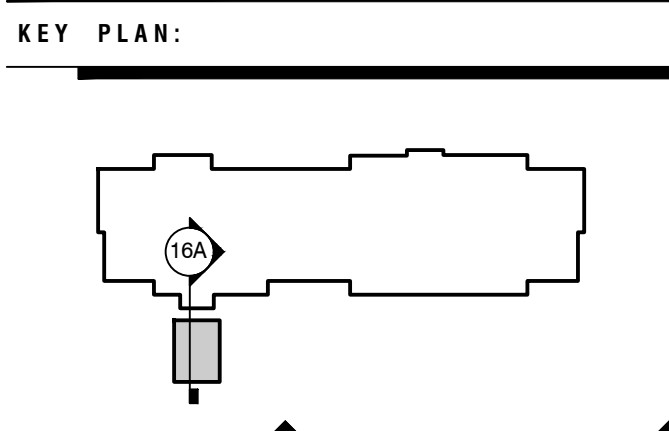

**NORTH AMERICAN
PROTOTYPE
VERSION: 2.3**

EACH OWNER IS TO VERIFY WITH THE LOCAL CODE ENFORCEMENT AGENCY FOR ACCESSIBILITY OR BARRIER-FREE REQUIREMENTS. THE OWNER OF THE PROJECT CONTROLS THE ULTIMATE DESIGN AND CONSTRUCTION AND IS URGED TO SEEK APPROPRIATE COUNSEL TO ENSURE SUCH COMPLIANCE.

NOTE OF CAUTION: USE OF THESE PLANS AND/OR SPECIFICATIONS SHALL IN NO WAY GIVE RISE TO ANY LIABILITY ON THE PART OF HILTON FOR ANY DEFECT OR DEFICIENCY OF SAID PLANS AND/OR SPECIFICATIONS. ANY PERSON USING THESE PLANS AND/OR SPECIFICATIONS MUST VERIFY THROUGH HIS OWN MEANS, ARCHITECT, ENGINEERS AND OTHER PROFESSIONALS, THEIR COMPLIANCE WITH ANY LAW AND ADEQUACY FOR THE INTENDED PURPOSE, AS HILTON MAKES NO REPRESENTATION WHATSOEVER IN THAT REGARD. THE QUALITY OF WORKMANSHIP, AND THE ADEQUACY AND SUITABILITY OF THE PLANS, SPECIFICATIONS, AND DESIGN DATA FOR A PARTICULAR PROJECT IS THE SOLE RESPONSIBILITY OF THE OWNER.

THIS DRAWING, PRINTED OR OTHERWISE, IS THE COPYRIGHTED PROPERTY OF HILTON. THE DRAWINGS MAY NOT BE USED, REPRODUCED OR COPIED WITHOUT THE PERMISSION OF HILTON.

IT IS THE RESPONSIBILITY OF THE FRANCHISEE AND THEIR CONSULTANTS TO COORDINATE ALL ADDENDA ITEMS ISSUED BY HILTON INTO THEIR RECORD SET OF CONSTRUCTION DOCUMENTS. ADDENDA ARE AVAILABLE ADJACENT TO THE PROTOTYPE DRAWINGS ON THE WWW.DESIGNINFORMATION.HILTON.COM WEBSITE.

HILTON DOES NOT MAKE ANY REPRESENTATION OR WARRANTY AS TO, NOR SHALL IT BE RESPONSIBLE FOR ANY OMISSIONS ON THE PART OF THE FRANCHISEE OR THEIR CONSULTANTS. OMISSIONS BY THE FRANCHISEE OR THEIR CONSULTANTS DOES NOT CONSTITUTE A WAIVER AND DOES NOT RELEASE THE FRANCHISEE FROM ANY RESPONSIBILITY TO CONFORM TO THE CRITERIA DEFINED IN THE BRAND'S PROTOTYPE REQUIREMENTS. ASSOCIATED ADDENDA AND/OR DESIGN AND CONSTRUCTION STANDARDS.

REVISIONS

PROJECT INFORMATION


**Prototype
Package**


April 2025

SHEET INFORMATION

**Entry Canopy and
Optional Porte Cochere
Sections and Details**

 00.13

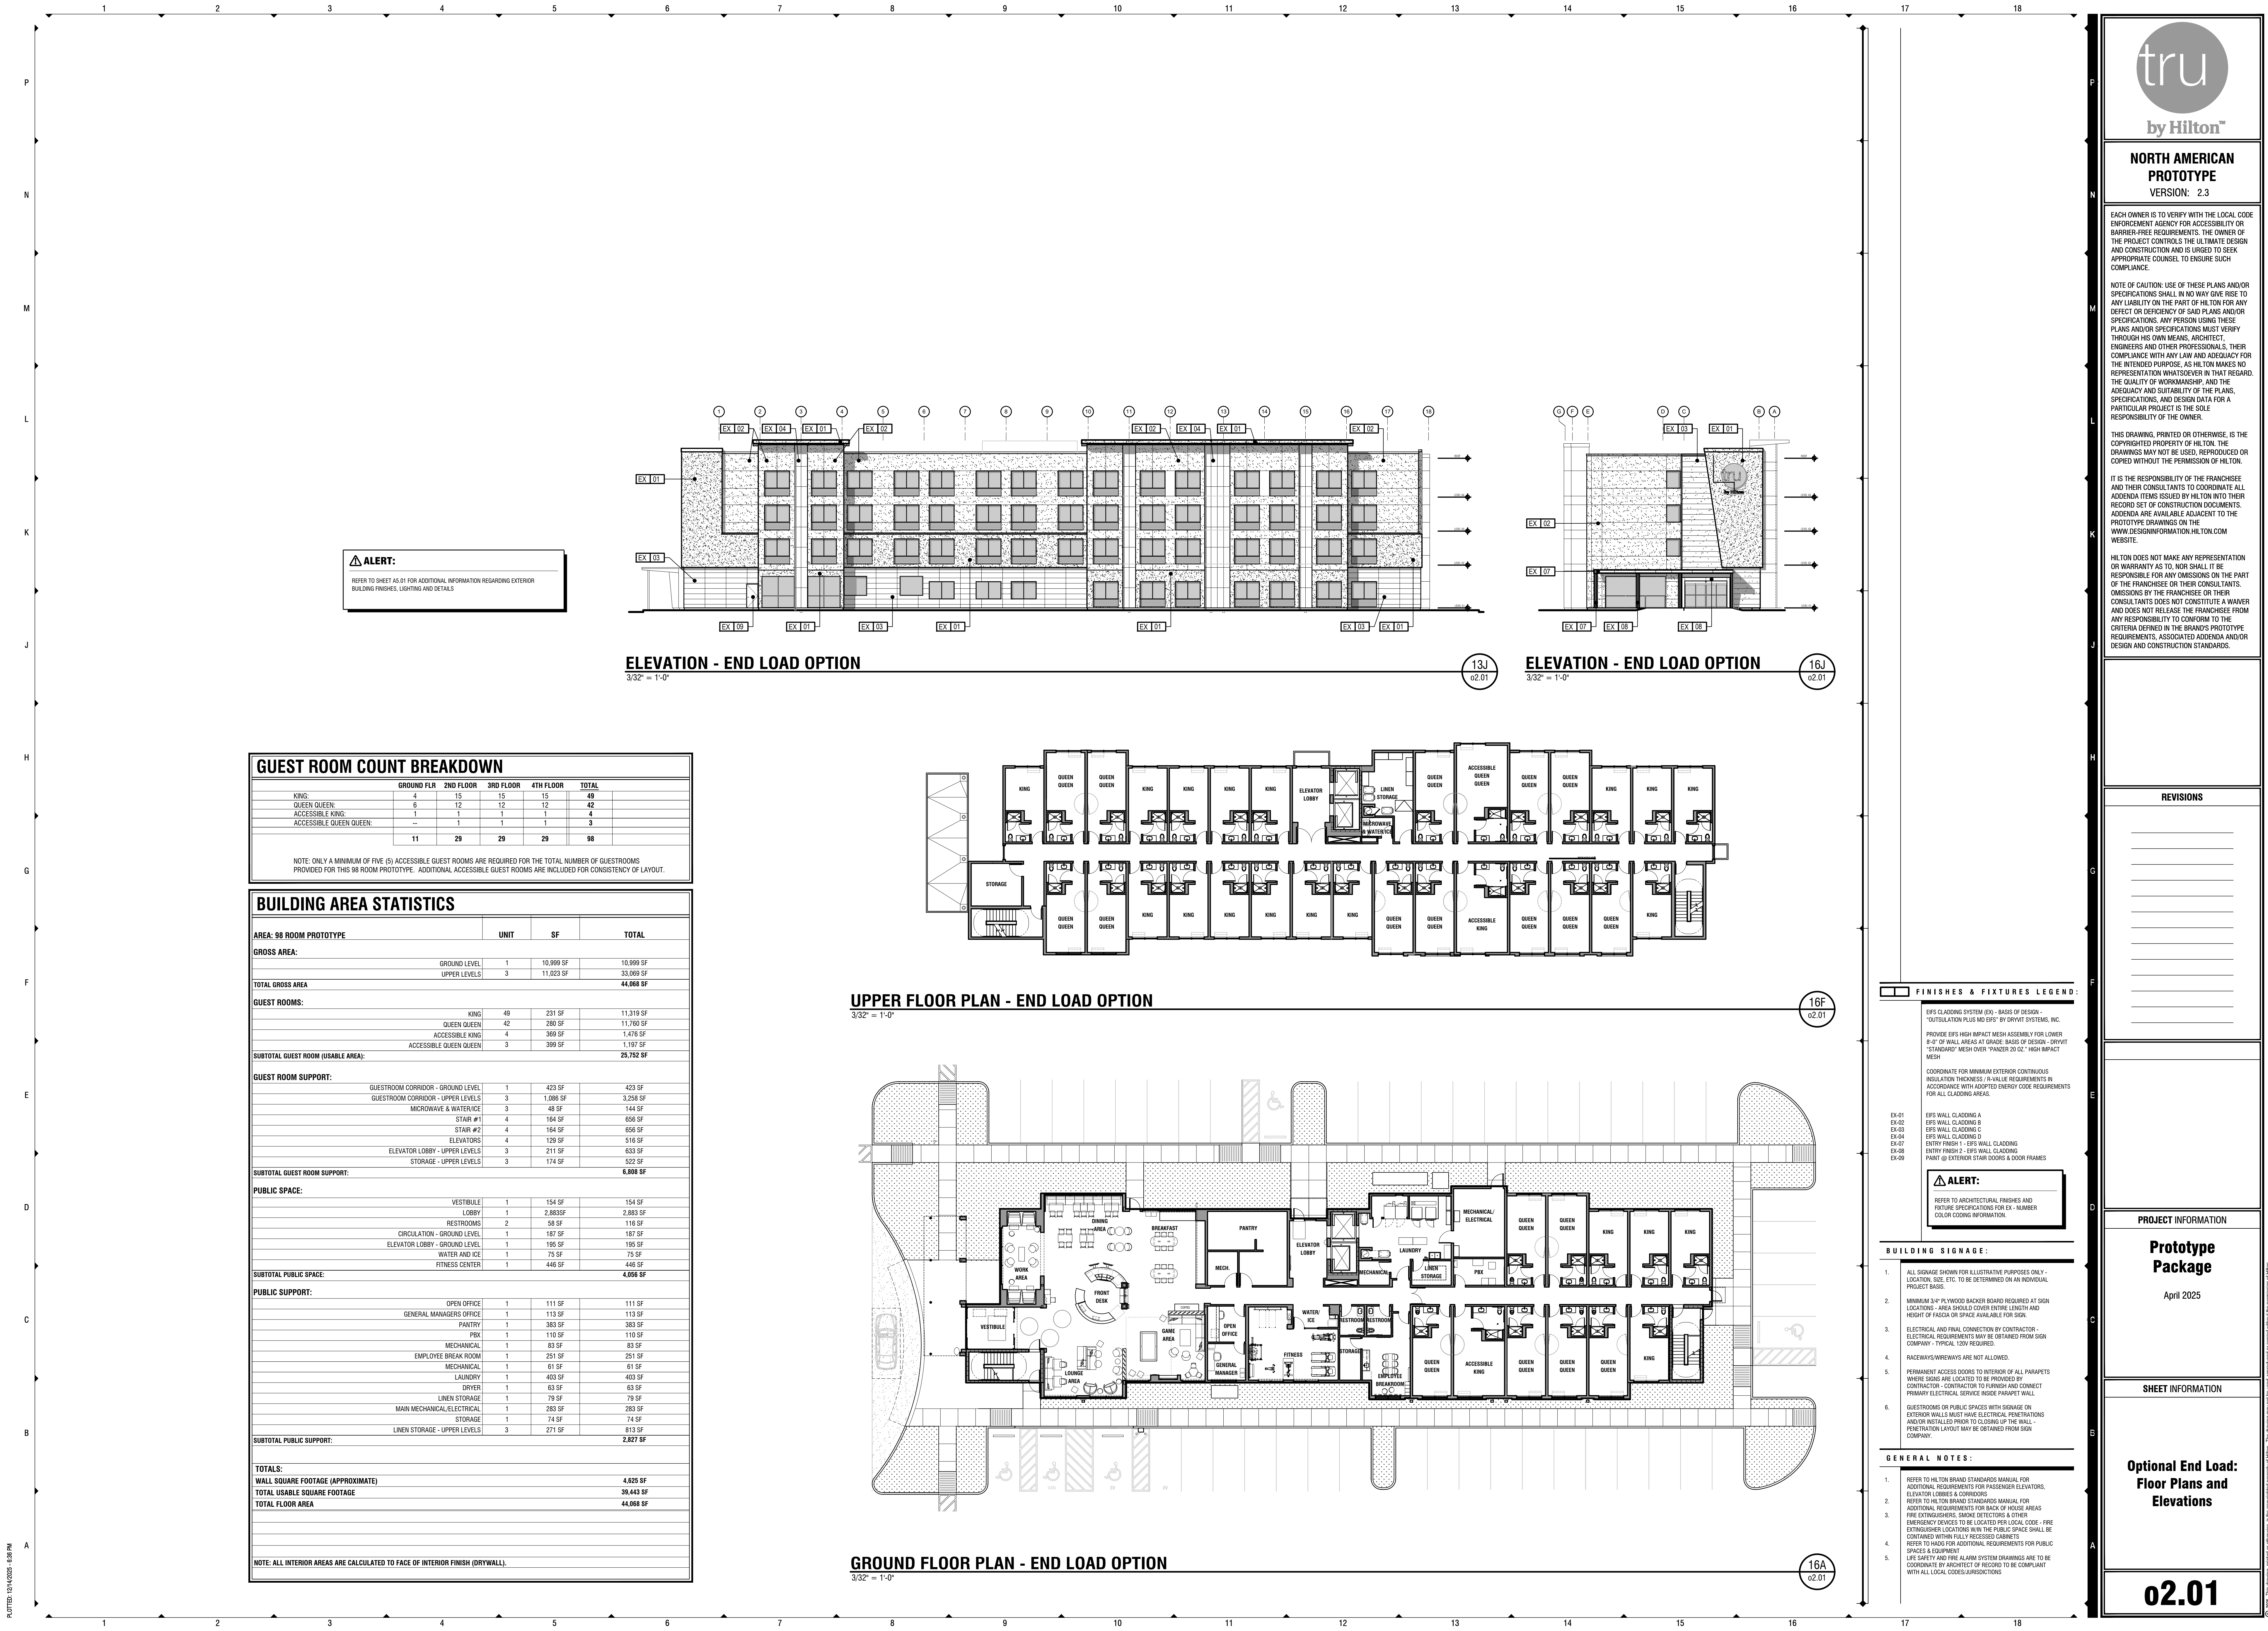



o2.02

EACH OWNER IS TO VERIFY WITH THE LOCAL CODE ENFORCEMENT AGENCY FOR ACCESSIBILITY OR BARRIER-FREE REQUIREMENTS. THE OWNER OF THE PROJECT CONTROLS THE ULTIMATE DESIGN AND CONSTRUCTION AND IS URGED TO SEEK APPROPRIATE COUNSEL TO ENSURE SUCH COMPLIANCE.

NOTE OF CAUTION: USE OF THESE PLANS AND/OR SPECIFICATIONS SHALL IN NO WAY GIVE RISE TO ANY LIABILITY ON THE PART OF HILTON FOR ANY DEFECT OR DEFICIENCY OF SAID PLANS AND/OR SPECIFICATIONS. ANY PERSON USING THESE PLANS AND/OR SPECIFICATIONS MUST VERIFY THROUGH HIS OWN MEANS, ARCHITECT, ENGINEERS AND OTHER PROFESSIONALS, THEIR COMPLIANCE WITH ANY LAW AND ADEQUACY FOR THE INTENDED PURPOSE, AS HILTON MAKES NO REPRESENTATION WHATSOEVER IN THAT REGARD AS TO THE QUALITY OF WORKMANSHIP, AND THE ADEQUACY AND SUITABILITY OF THE PLANS, SPECIFICATIONS, AND DESIGN DATA FOR A PARTICULAR PROJECT IS THE SOLE RESPONSIBILITY OF THE OWNER.

THIS DRAWING, PRINTED OR OTHERWISE, IS THE
COPYRIGHTED PROPERTY OF HILTON. THE
DRAWINGS MAY NOT BE USED, REPRODUCED OR
COPIED WITHOUT THE PERMISSION OF HILTON.

IT IS THE RESPONSIBILITY OF THE FRANCHISEE AND THEIR CONSULTANTS TO COORDINATE ALL ADDENDA ITEMS ISSUED BY HILTON INTO THEIR RECORD SET OF CONSTRUCTION DOCUMENTS. ADDENDA ARE AVAILABLE ADJACENT TO THE PROTOTYPE DRAWINGS ON THE WWW.DESIGNINFORMATION.HILTON.COM WEBSITE.

HILTON DOES NOT MAKE ANY REPRESENTATION OR WARRANTY AS TO, NOR SHALL IT BE RESPONSIBLE FOR, ANY OMISSIONS ON THE PART OF THE FRANCHISEE OR THEIR CONSULTANTS. OMISSIONS BY THE FRANCHISEE OR THEIR CONSULTANTS DOES NOT CONSTITUTE A WAIVER AND DOES NOT RELEASE THE FRANCHISEE FROM ANY RESPONSIBILITY TO CONFORM TO THE CRITERIA DEFINED IN THE BRAND'S PROTOTYPE REQUIREMENTS, ASSOCIATED ADDENDA AND/OR DESIGN AND CONSTRUCTION STANDARDS.

REVISIONS

[illegible]

PROJECT INFORMATION

Prototype Package

April 2025

SHEET INFORMATION

**Optional End Load:
Front Desk and
Breakfast Millwork**

o2.03

